

**Drawings
of
GNM School of
Nursing, Civil Hospital,
Majuli,
Assam**





Submitted by- INTEGRA VENTURES

Prithvi Greens, Block A, Ground Floor, Pathar Quarry
Guwahati: 781171, Assam, India

Branches

GUWAHATI | KOLKATA | DELHI | BENGALURU | NAIROBI |

LIST OF DRAWINGS			
MAJULI GNM			
Sl No.	Drawing Name	Drawing Number	No
1	AS BUILT SITE PLAN	2024/ASSIST-GNM/MAJ/SP/AS BUILT/01	1
2	PROPOSED SITE PLAN	2024/ASSIST-GNM/MAJ/SP/PROP/01	1
	CIVIL		
3	AS BUILT FLOOR PLAN FOR ACADEMIC BLOCK 1	2024/ASSIST-GNM/MAJ/AR/ACA/AS BUILT/01	1
4	PROPOSED FLOOR PLAN FOR ACADEMIC BLOCK 1	2024/ASSIST-GNM/MAJ/AR/ACA/PROP/01	1
5	PROPOSED FLOOR PLAN FOR ACADEMIC BLOCK 1	2024/ASSIST-GNM/MAJ/AR/ACA/PROP/01	
6	PROPOSED GROUND & FIRST FLOOR PLAN FOR ACADEMIC BLOCK 2	2024/ASSIST-GNM/MAJ/AR/ACA/PROP/02	1
7	PROPOSED GROUND & FIRST FLOOR PLAN FOR ACADEMIC BLOCK 3	2024/ASSIST-GNM/MAJ/AR/ACA/PROP/03	1
8	PROPOSED SECOND & THIRD FLOOR PLAN FOR ACADEMIC BLOCK 3	2024/ASSIST-GNM/MAJ/AR/ACA/PROP/04	1
	PLUMBING		
9	PLUMBING LAYOUT FOR ACADEMIC BLOCK 1	2024/ASSIST-GNM/MAJ/P/ACA/PROP/01	1
	ELECTRICAL		
10	ELECTRICAL LAYOUT FOR ACADEMIC BLOCK 1	2024/ASSIST-GNM/MAJ/E/ACA/PROP/01	1
	FIRE FIGHTING		
11	ELECTRICAL LAYOUT FOR ACADEMIC BLOCK 1	2024/ASSIST-GNM/MAJ/FF/ACA/PROP/01	1
12	ROAD DETAIL	2024/ASSIST-GNM/MAJ/ROAD /01	1
13	DRAIN DETAIL	2024/ASSIST-GNM/MAJ/DRAIN/01	1
14	SECURITY CABIN	2024/ASSIST-GNM/MAJ/SECURITY /01	1
15	SEPTIC TANK	2024/ASSIST-GNM/MAJ/SEPTIC TANK /01	1

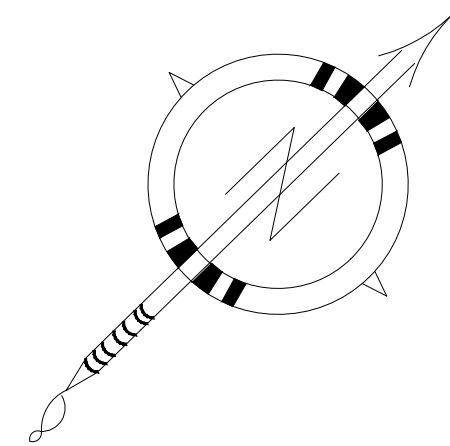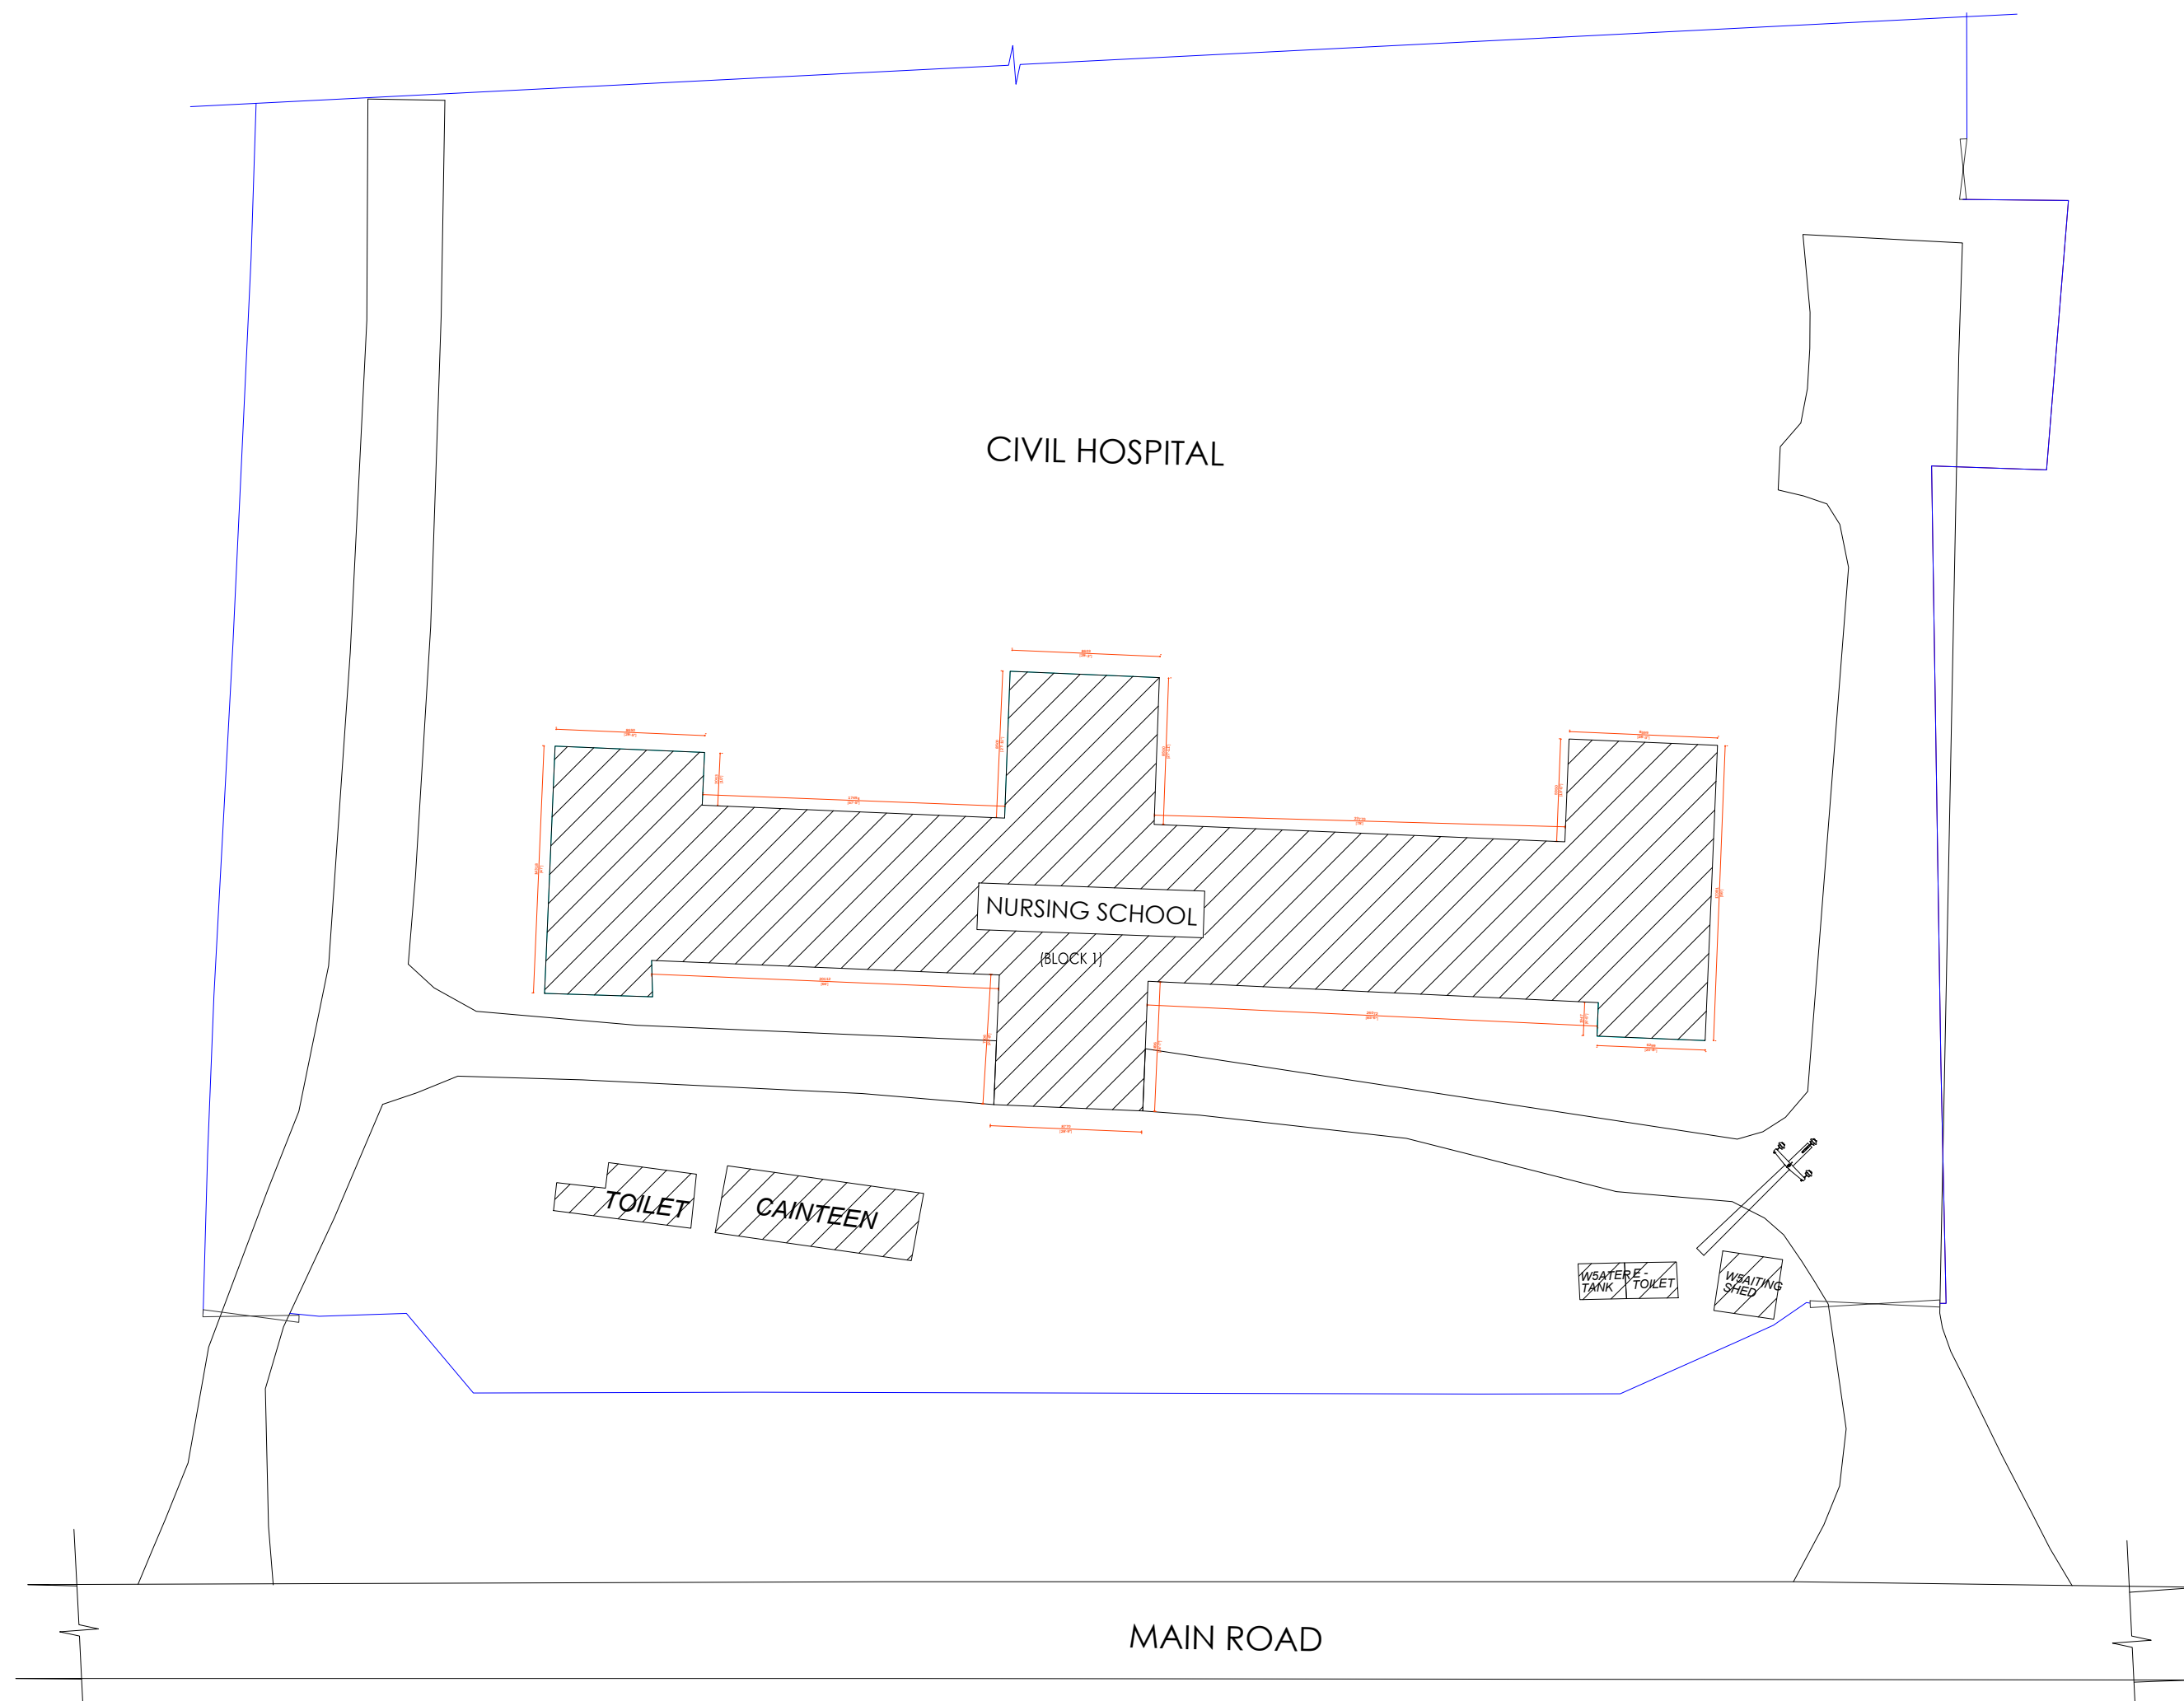

Legend:		
01. ROAD		
02. BOUNDARY WALL		
03. FANCHING		
04. BUILDING		
05. HOUSE		
06. TOILET		
07. SEPTIC TANK		
08. GATE		
09. TREE		
10. LIGHT POLE		
11. ELECTRIC POLE		

PROJECT:-
ASSAM STATE SECONDARY HEALTHCARE
INITIATIVE FOR SERVICE DELIVERY
TRANSFORMATION (ASSIST)


CLIENT:-
ASSAM HEALTH INFRASTRUCTURE
DEVELOPMENT & MANAGEMENT SOCIETY
(AHIDMS)

PRINCIPAL CONSULTANT:

PRITHVI GREENS, BLOCK A GROUND FLOOR
PATHARQUARY GUWSAHATI-781171, ASSAM
M: +91-9401727143

STAGE:-	DPR	
DRAWING NO:-	2024/ASSIST-GNM/MAJ/SP/ASBUILT/01	
START DATE	ISSUE DATE	SHEET SIZE
	07-04-2025	A3
PROJECT CODE:-	2024/ASSIST-GNM/MAJ	
SCALE:-	N.T.S.	

DRAWING TITLE:-
ASBUILT SITE PLAN

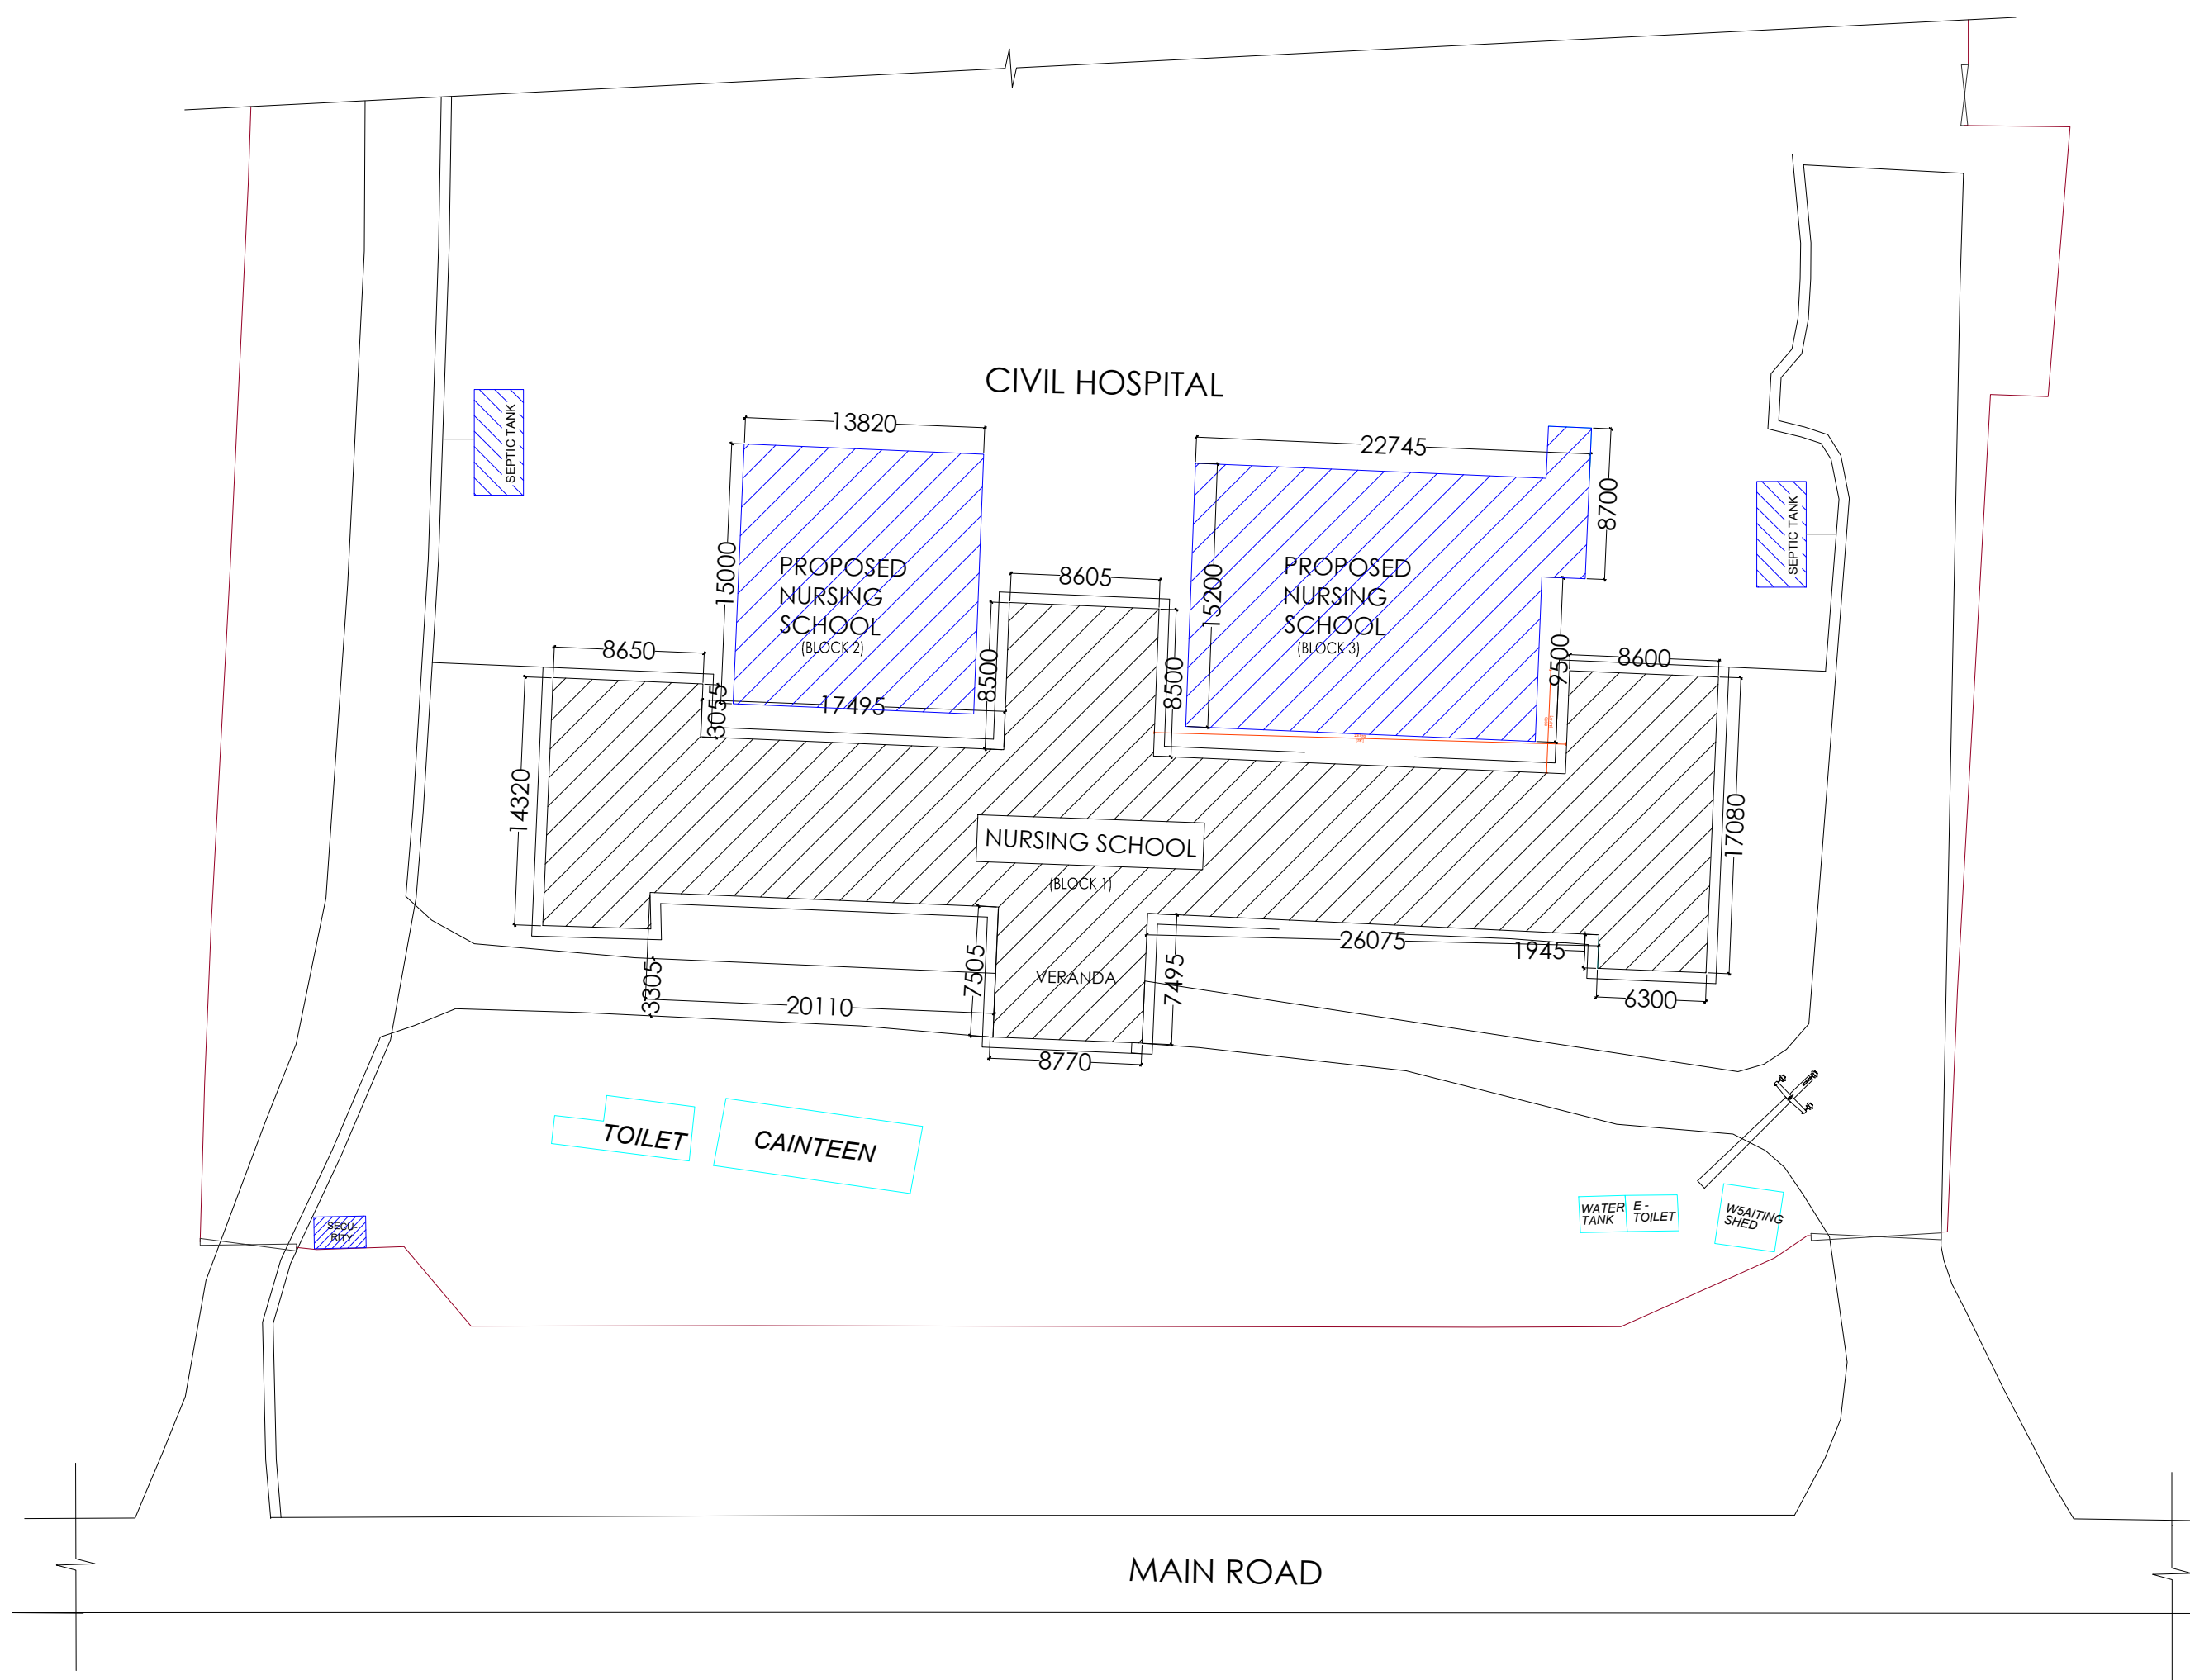

LEGEND:-	
1. ROAD	-
2. BOUNDARY WALL	-
3. EXISTING STRUCTURE	-
4. PROPOSED STRUCTURE	-
5. DRAINAGE LINE	-

PROJECT:-
ASSAM STATE SECONDARY HEALTHCARE
INITIATIVE FOR SERVICE DELIVERY
TRANSFORMATION (ASSIST)


CLIENT:-
ASSAM HEALTH INFRASTRUCTURE
DEVELOPMENT & MANAGEMENT SOCIETY
(AHIDMS)

PRINCIPAL CONSULTANT:

INTEGRA VENTURES
HEALTHCARE | INFRASTRUCTURE | CONSULTANCY
PRITHVI GREENS, BLOCK A GROUND FLOOR
PATHARQUARY GUW5AHATI-781171, ASSAM
M: +91-9401727143

STAGE:-	DPR	
DRAW5ING NO:- 2024/ASSIST-GNM/MAJ/SP/PROP/01		
START DATE	ISSUE DATE	SHEET SIZE
	07-04-2025	A3
PROJECT CODE:-	2024/ASSIST-GNM/MAJ	
SCALE:-	N.T.S.	

DRAWING TITLE:-
PROPOSED SITE PLAN

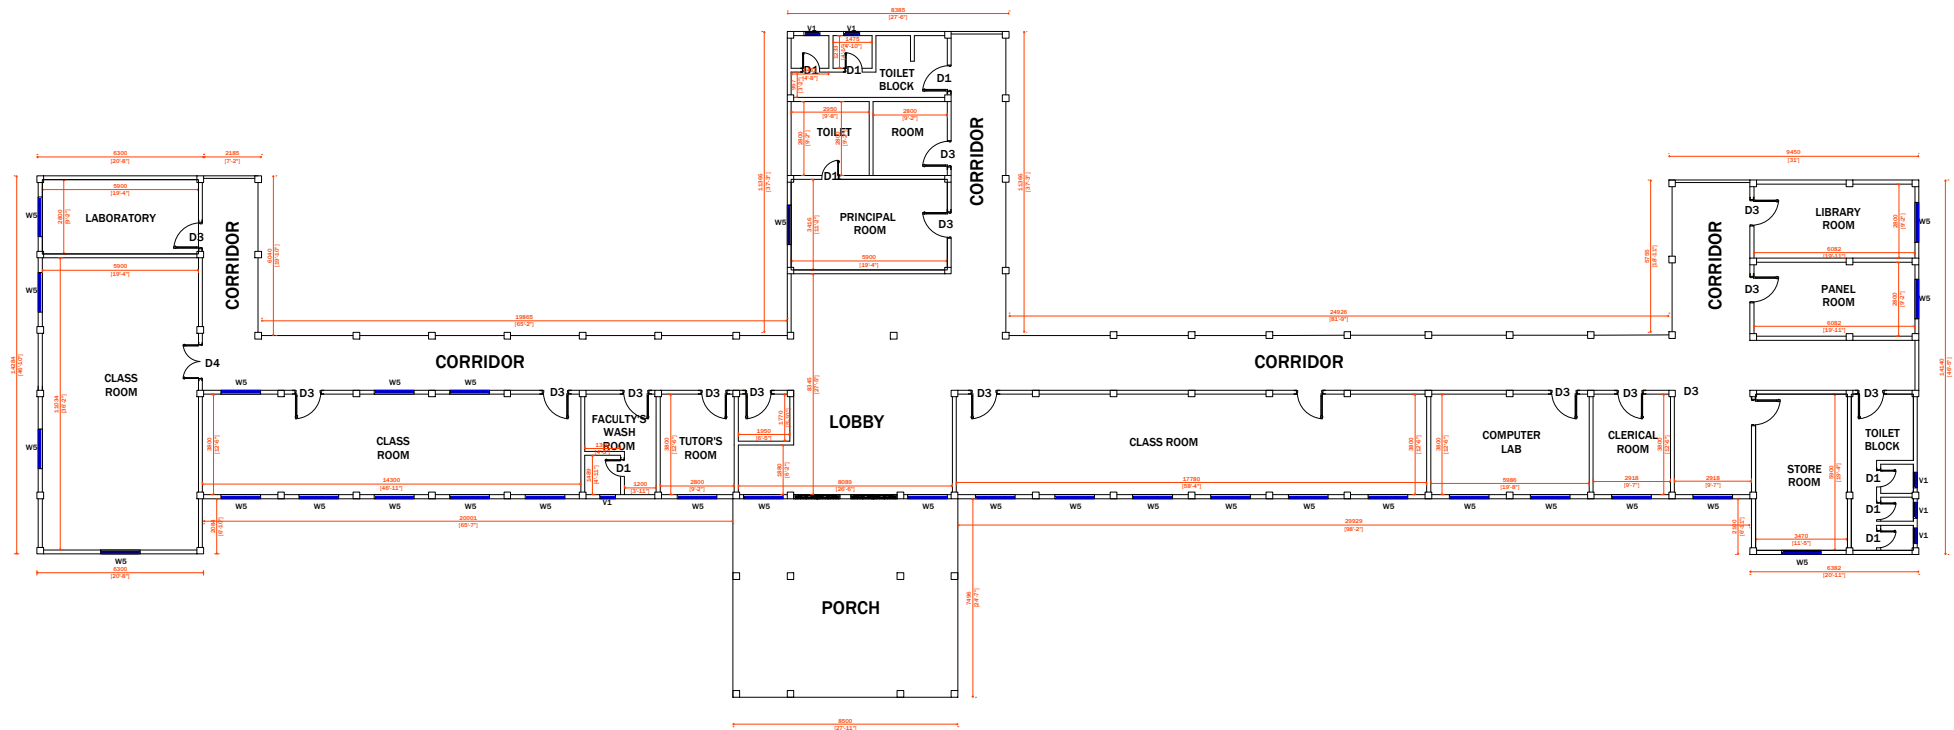

FLOOR PLAN
(GNM SCHOOL OF MAJULI)

DOOR SCHEDULE:-

SNO	NAME	W5IDTH	HEIGHT	REMARKS
1.	D1	750	2100	SINGLE PANEL WOODEN FLUSH DOOR
2.	D3	1000	2100	SINGLE PANEL WOODEN FLUSH DOOR
3.	D4	1200	2100	DOUBLE PANEL WOODEN FLUSH DOOR

WINDOW SCHEDULE:-

SNO	NAME	SILL	WIDTH	HEIGHT	REMARKS
1.	W5	900	1500	1200	DOUBLE PANEL WOODEN WINDOW WITH GLASS
2.	V1	1650	600	450	SINGLE PANEL WOODEN WINDOW WITH GLASS

PROJECT:-
ASSAM STATE SECONDARY HEALTHCARE
INITIATIVE FOR SERVICE DELIVERY
TRANSFORMATION (ASSIST)

CLIENT:-
ASSAM HEALTH INFRASTRUCTURE
DEVELOPMENT & MANAGEMENT SOCIETY
(AHIDMS)

PRINCIPAL CONSULTANT:



PRITHVI GREENS, BLOCK A GROUND FLOOR
PATHARQUARY GUW5AHATI-781171, ASSAM
M: +91-9401727143

STAGE:- DPR

DRAW5ING NO:-
2024/ASSIST-GNM/MAJ/AR/ACA/ASBUILT/01


START DATE	ISSUE DATE	SHEET SIZE
	07-04-2025	A3

PROJECT CODE:- 2024/ASSIST-GNM/MAJ

SCALE:- N.T.S.

DRAW5ING TITLE:-

ASBUILT ACADEMIC BLOCK

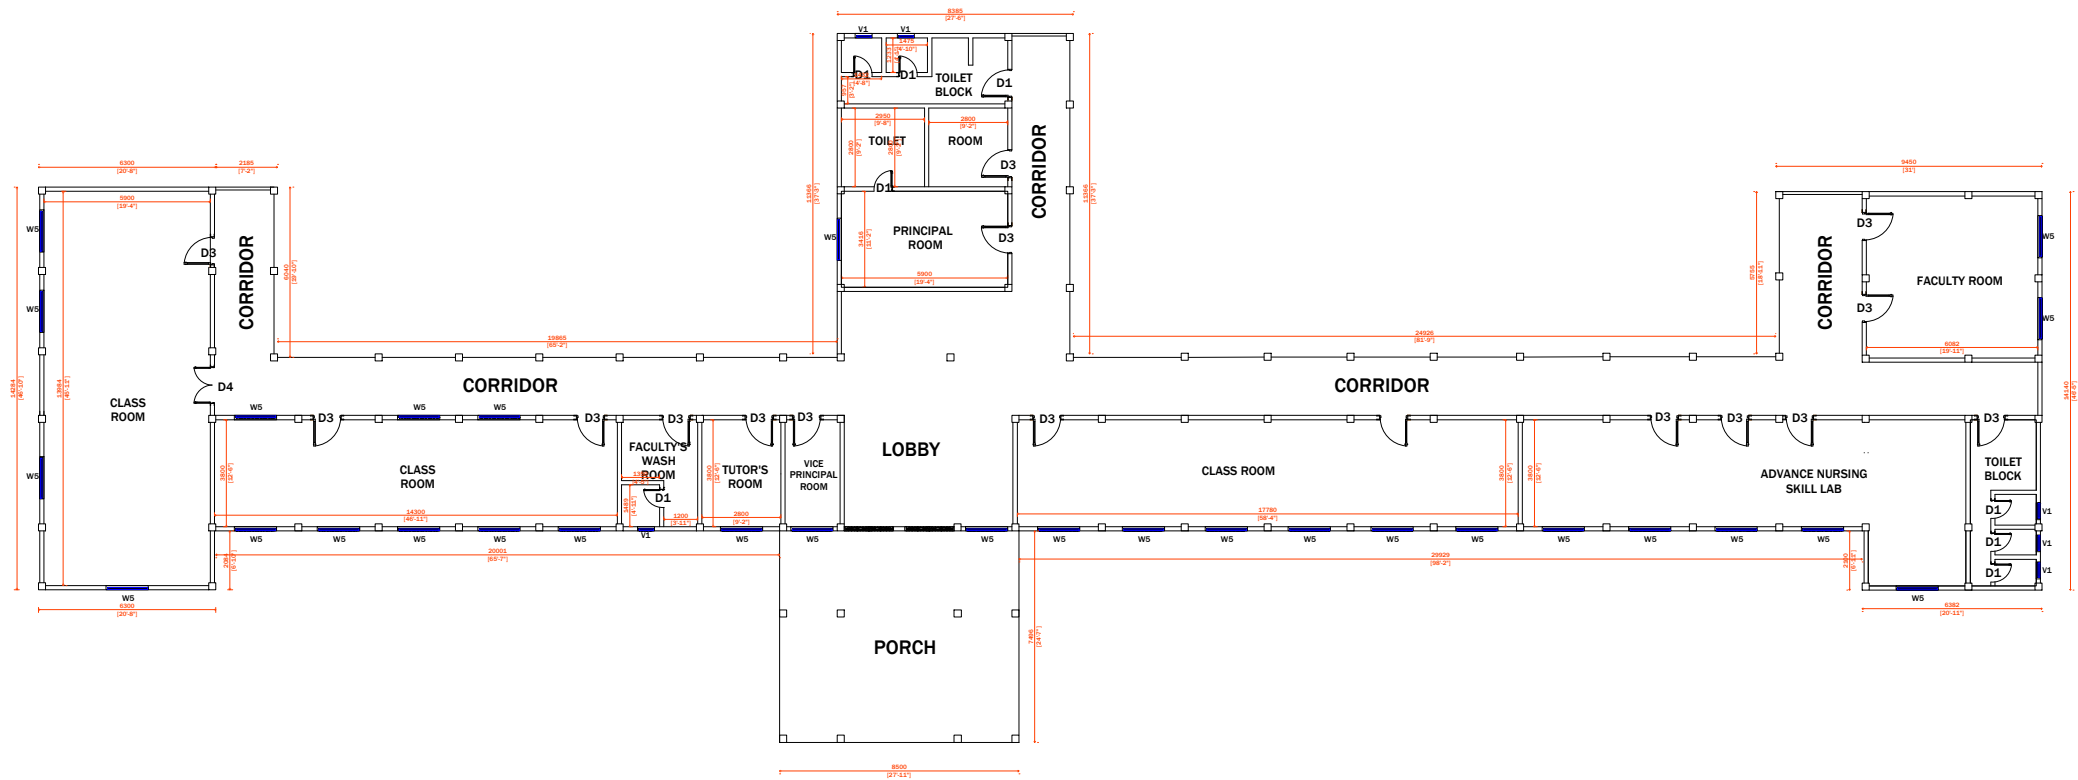

FLOOR PLAN
(GNM SCHOOL OF MAJULI)

DOOR SCHEDULE:-

SNO	NAME	WIDTH	HEIGHT	REMARKS
1.	D1	750	2100	SINGLE PANEL WOODEN FLUSH DOOR
2.	D3	1000	2100	SINGLE PANEL WOODEN FLUSH DOOR
3.	D4	1200	2100	DOUBLE PANEL WOODEN FLUSH DOOR

WINDOW SCHEDULE:-

SNO	NAME	SILL	WIDTH	HEIGHT	REMARKS
1.	W5	900	1500	1200	DOUBLE PANEL WOODEN WINDOW WITH GLASS
2.	V1	1650	600	450	SINGLE PANEL WOODEN WINDOW WITH GLASS

PROJECT:-
ASSAM STATE SECONDARY HEALTHCARE
INITIATIVE FOR SERVICE DELIVERY
TRANSFORMATION (ASSIST)

CLIENT:-
ASSAM HEALTH INFRASTRUCTURE
DEVELOPMENT & MANAGEMENT SOCIETY
(AHIDMS)

PRINCIPAL CONSULTANT:



PRITHVI GREENS, BLOCK A GROUND FLOOR
PATHARQUARY GUWSAHATI-781171, ASSAM
M: +91-9401727143

STAGE:-	DPR
----------------	-----

DRAWING NO:-
2024/ASSIST-GNM/MAJ/AR/ACA/PROP/01


START DATE	ISSUE DATE	SHEET SIZE
	15-02-2025	A3

PROJECT CODE:-	2024/ASSIST-GNM/MAJ
-----------------------	---------------------


SCALE:-	N.T.S.
----------------	--------

DRAWING TITLE:-

PROPOSED ACADEMIC BLOCK

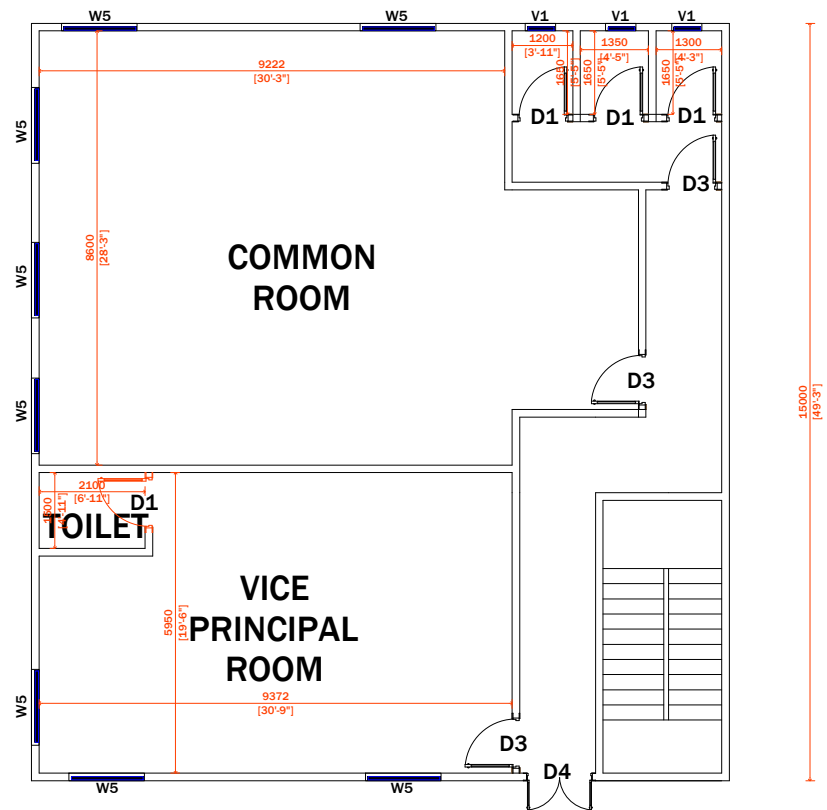

PROPOSED GR FLOOR OF GNM MAJULI

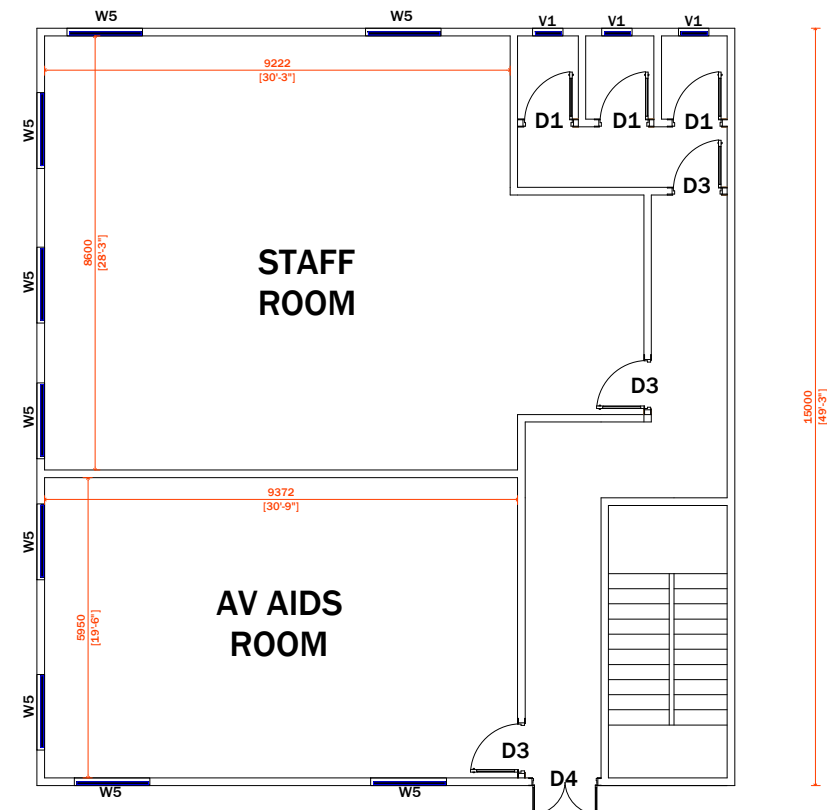

PROPOSED 1ST FLOOR OF GNM MAJULI

DOOR SCHEDULE:-

SNO	NAME	W5IDTH	HEIGHT	REMARKS
1.	D1	750	2100	SINGLE PANEL WOODEN FLUSH DOOR
2.	D3	1000	2100	SINGLE PANEL WOODEN FLUSH DOOR
3.	D4	1200	2100	DOUBLE PANEL WOODEN FLUSH DOOR

WINDOW SCHEDULE:-

SNO	NAME	SILL	WIDTH	HEIGHT	REMARKS
1.	W5	900	1500	1200	DOUBLE PANEL WOODEN WINDOW WITH GLASS
2.	V1	1650	600	450	SINGLE PANEL WOODEN WINDOW WITH GLASS

PROJECT:-
ASSAM STATE SECONDARY HEALTHCARE
INITIATIVE FOR SERVICE DELIVERY
TRANSFORMATION (ASSIST)

CLIENT:-
ASSAM HEALTH INFRASTRUCTURE
DEVELOPMENT & MANAGEMENT SOCIETY
(AHIDMS)

PRINCIPAL CONSULTANT:

PRITHVI GREENS, BLOCK A GROUND FLOOR
PATHARQUARY, GUW5AHATI-781171, ASSAM
M: +91-9401727143

STAGE:-	DPR
---------	-----

DRAW5ING NO:-
2024/ASSIST-GNM/MAJ/AR/ACA/PROP/02


START DATE	ISSUE DATE	SHEET SIZE
	07-04-2025	A3

PROJECT CODE:- 2024/ASSIST-GNM/MAJ

SCALE:- N.T.S.

DRAWING TITLE:-

PROPOSED ACADEMIC BLOCK 2

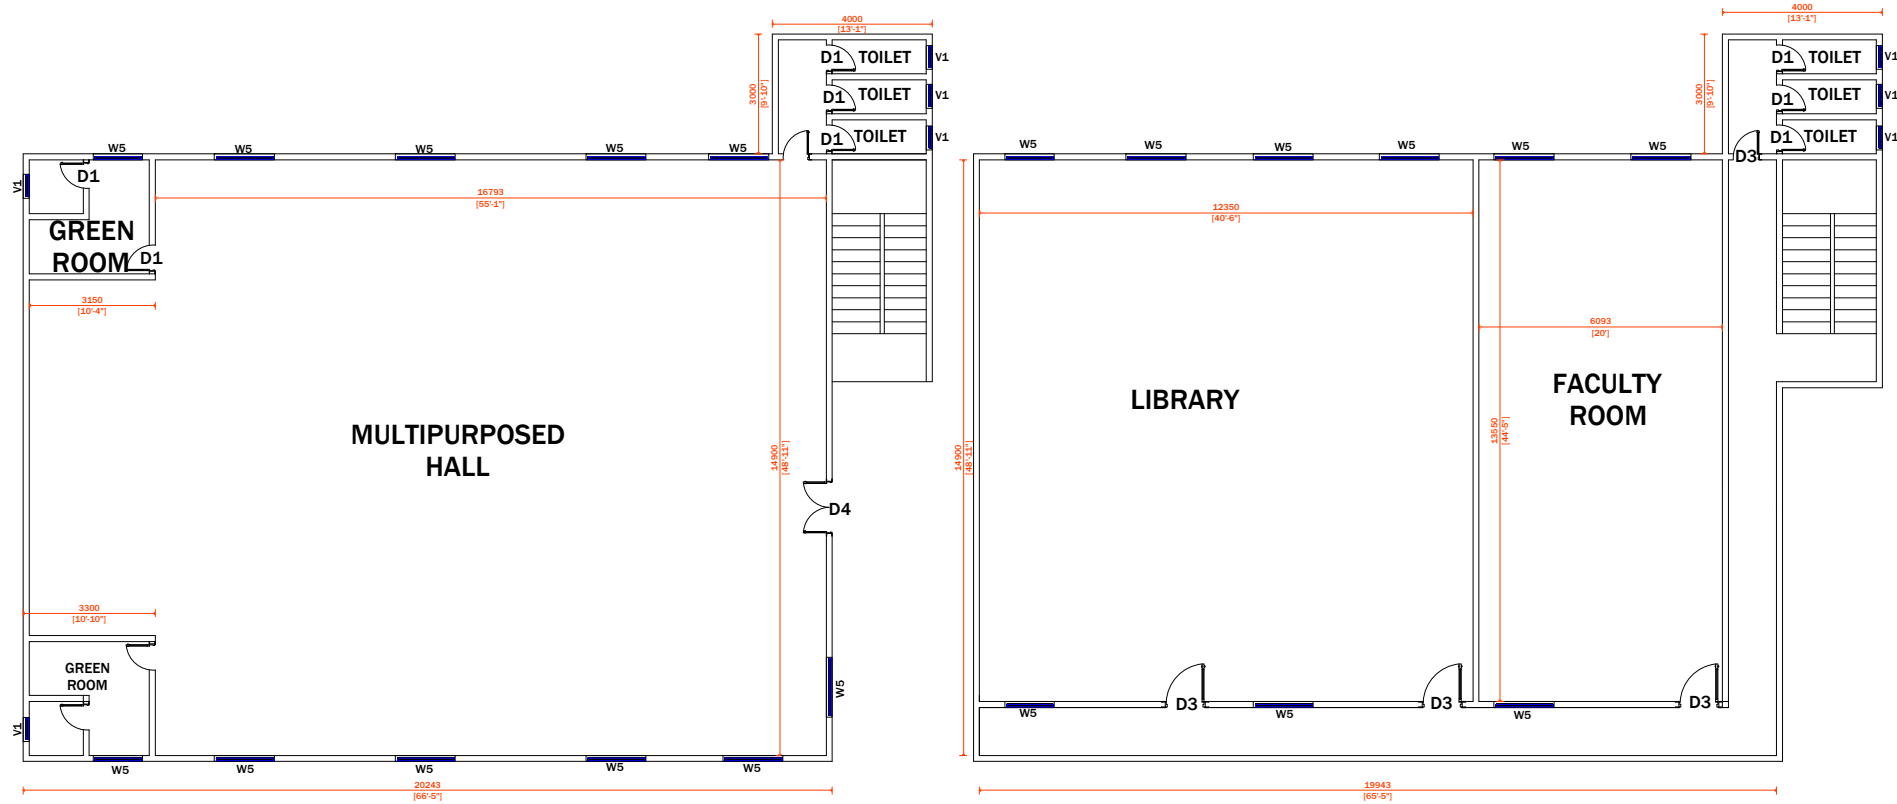

PROPOSED GR FLOOR OF GNM MAJULI

PROPOSED 1ST FLOOR OF GNM MAJULI

DOOR SCHEDULE:-

SNO	NAME	WIDTH	HEIGHT	REMARKS
1.	D1	750	2100	SINGLE PANEL WOODEN FLUSH DOOR
2.	D3	1000	2100	SINGLE PANEL WOODEN FLUSH DOOR
3.	D4	1200	2100	DOUBLE PANEL WOODEN FLUSH DOOR

WINDOW SCHEDULE:-

SNO	NAME	SILL	WIDTH	HEIGHT	REMARKS
1.	W5	900	1500	1200	DOUBLE PANEL WOODEN WINDOW WITH GLASS
2.	V1	1650	600	450	SINGLE PANEL WOODEN WINDOW WITH GLASS

PROJECT:-
ASSAM STATE SECONDARY HEALTHCARE
INITIATIVE FOR SERVICE DELIVERY
TRANSFORMATION (ASSIST)

CLIENT:-
ASSAM HEALTH INFRASTRUCTURE
DEVELOPMENT & MANAGEMENT SOCIETY
(AHIDMS)

PRINCIPAL CONSULTANT:



PRITHVI GREENS, BLOCK A GROUND FLOOR
PATHARQUARY GUWSAHATI-781171, ASSAM
M: +91-9401727143

STAGE:- DPR


DRAWING NO:-
2024/ASSIST-GNM/MAJ/AR/ACA/PROP/03

START DATE	ISSUE DATE	SHEET SIZE
	07-04-2025	A3

PROJECT CODE:- 2024/ASSIST-GNM/MAJ

SCALE:- N.T.S.

DRAWING TITLE:-
PROPOSED ACADEMIC BLOCK 3

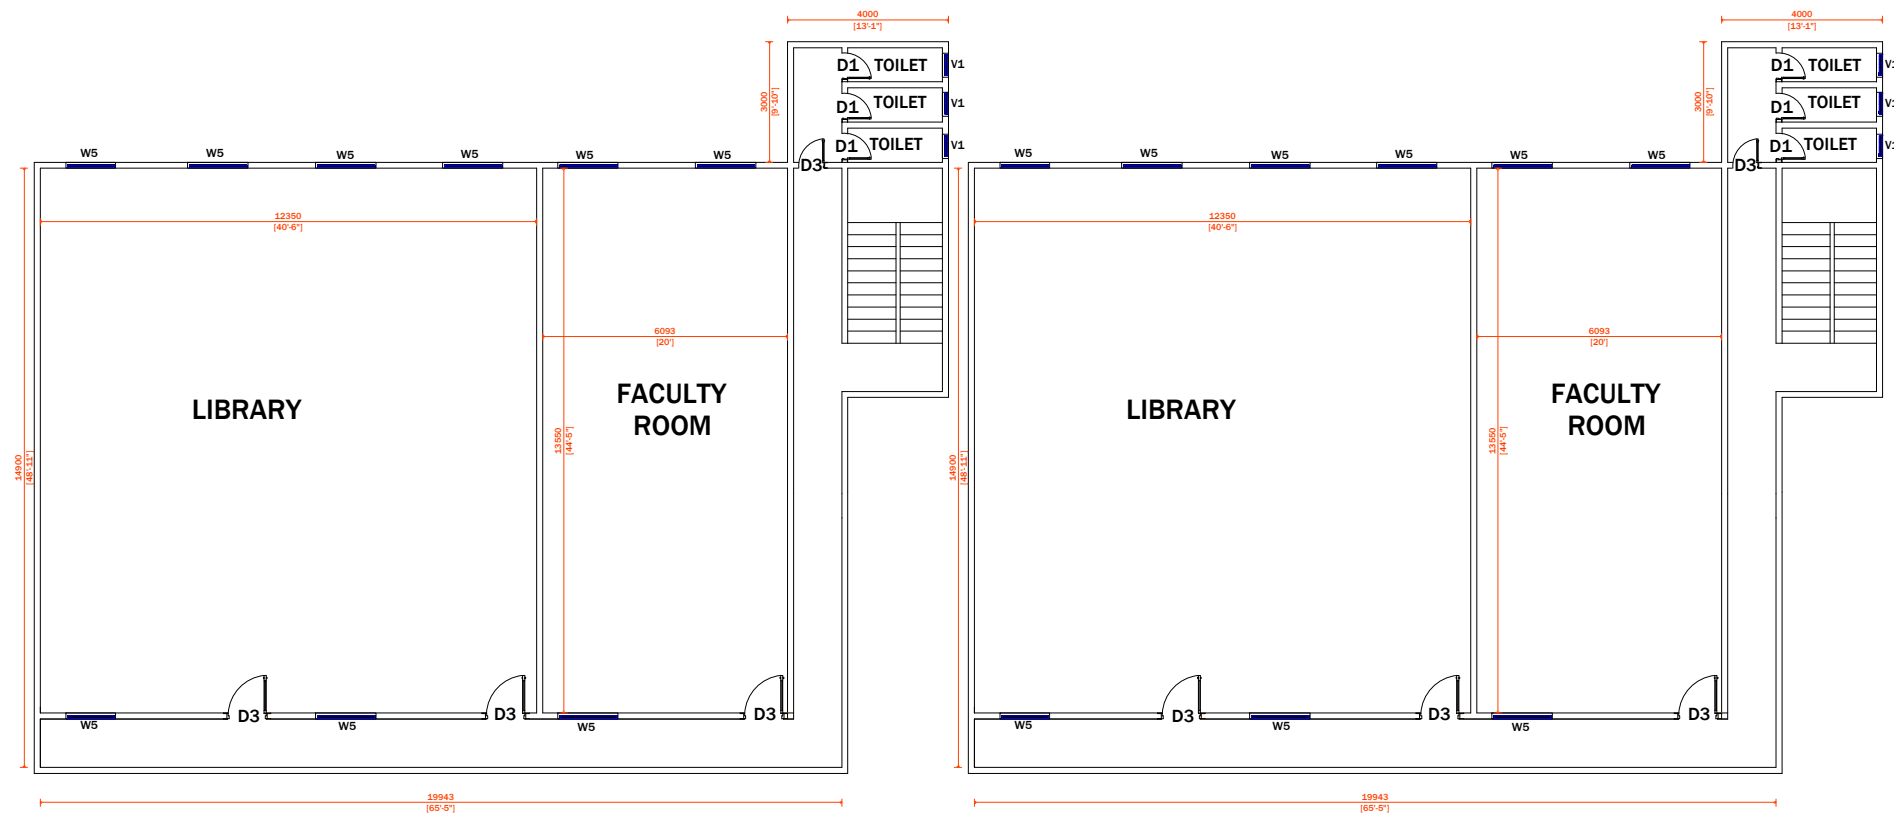

PROPOSED 2ND FLOOR OF GNM MAJULI

PROPOSED 3RD FLOOR OF GNM MAJULI

DOOR SCHEDULE:-

SNO	NAME	W5IDTH	HEIGHT	REMARKS
1.	D1	750	2100	SINGLE PANEL WOODEN FLUSH DOOR
2.	D3	1000	2100	SINGLE PANEL WOODEN FLUSH DOOR
3.	D4	1200	2100	DOUBLE PANEL WOODEN FLUSH DOOR

WINDOW SCHEDULE:-

SNO	NAME	SILL	WIDTH	HEIGHT	REMARKS
1.	W5	900	1500	1200	DOUBLE PANEL WOODEN WINDOW WITH GLASS
2.	V1	1650	600	450	SINGLE PANEL WOODEN WINDOW WITH GLASS

PROJECT:-
ASSAM STATE SECONDARY HEALTHCARE
INITIATIVE FOR SERVICE DELIVERY
TRANSFORMATION (ASSIST)

CLIENT:-
ASSAM HEALTH INFRASTRUCTURE
DEVELOPMENT & MANAGEMENT SOCIETY
(AHIDMS)

PRINCIPAL CONSULTANT:



PRITHVI GREENS, BLOCK A GROUND FLOOR
PATHARQUARY GUW5AHATI-781171, ASSAM
M: +91-9401727143

STAGE:- DPR


DRAW5ING NO:-
2024/ASSIST-GNM/MAJ/AR/ACA/PROP/04

START DATE	ISSUE DATE	SHEET SIZE
	07-04-2025	A3

PROJECT CODE:- 2024/ASSIST-GNM/MAJ

SCALE:- N.T.S.

DRAW5ING TITLE:-
PROPOSED ACADEMIC BLOCK 3

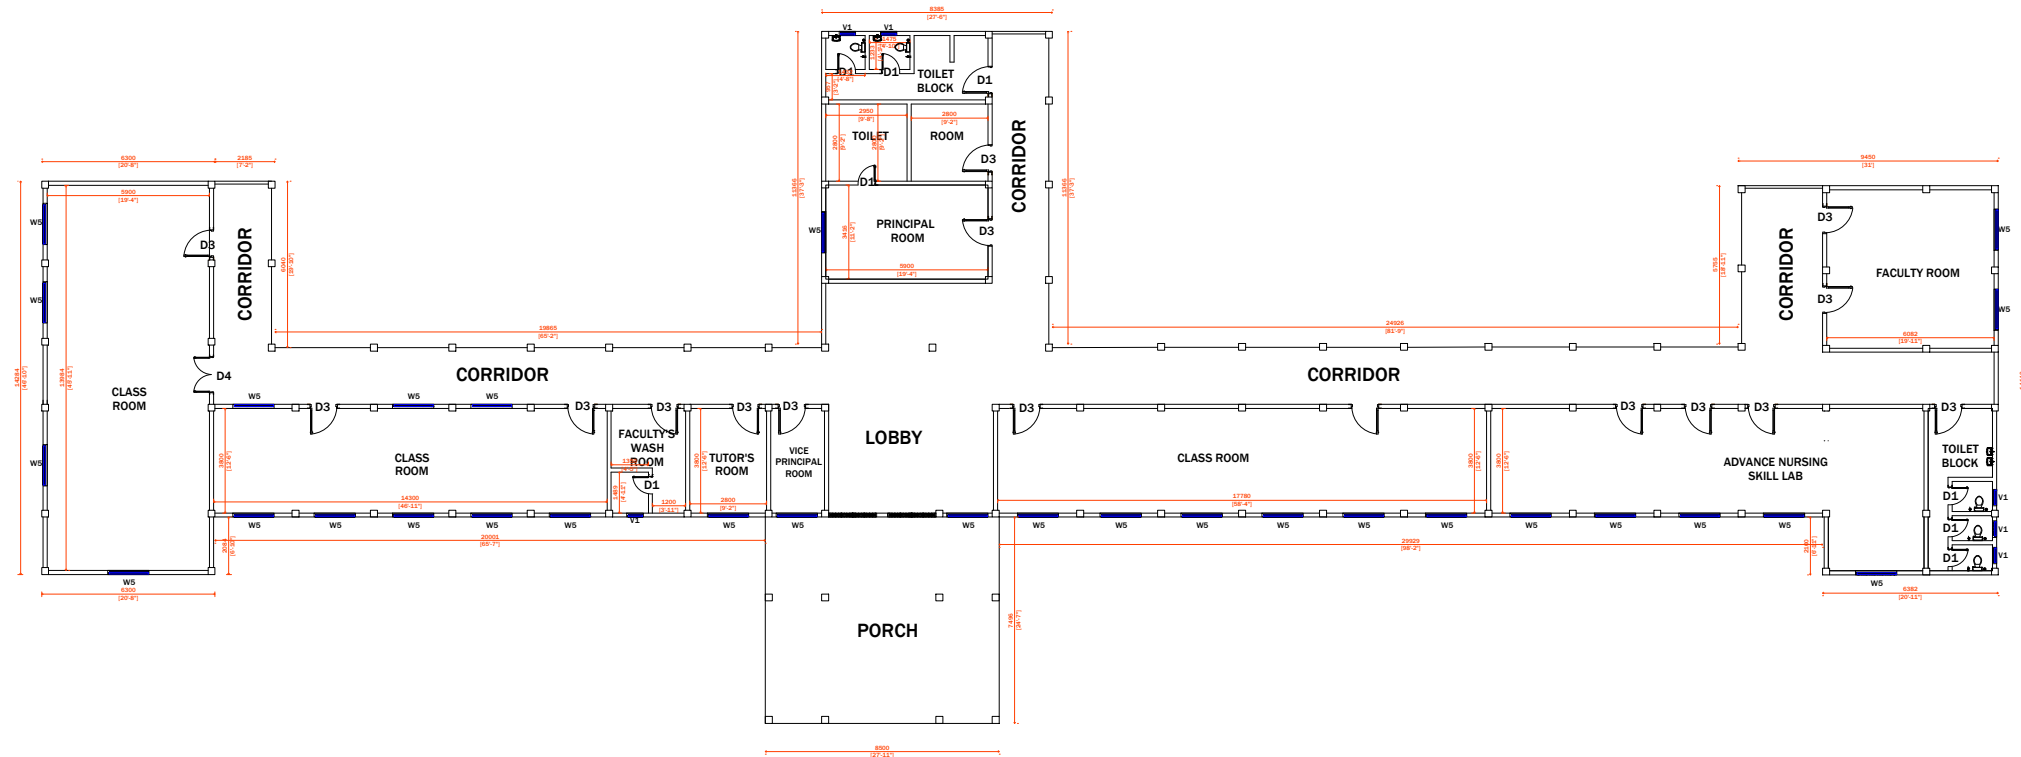

FLOOR PLAN
(GNM SCHOOL OF MAJULI)

DOOR SCHEDULE:-

SNO	NAME	W5IDTH	HEIGHT	REMARKS
1.	D1	750	2100	SINGLE PANEL WOODEN FLUSH DOOR
2.	D3	1000	2100	SINGLE PANEL WOODEN FLUSH DOOR
3.	D4	1200	2100	DOUBLE PANEL WOODEN FLUSH DOOR

WINDOW SCHEDULE:-

SNO	NAME	SILL	WIDTH	HEIGHT	REMARKS
1.	W5	900	1500	1200	DOUBLE PANEL WOODEN WINDOW WITH GLASS
2.	V1	1650	600	450	SINGLE PANEL WOODEN WINDOW WITH GLASS

EXISTING
PROPOSED

PROJECT:-
ASSAM STATE SECONDARY HEALTHCARE
INITIATIVE FOR SERVICE DELIVERY
TRANSFORMATION (ASSIST)

CLIENT:-
ASSAM HEALTH INFRASTRUCTURE
DEVELOPMENT & MANAGEMENT SOCIETY
(AHIDMS)

PRINCIPAL CONSULTANT:



PRITHVI GREENS, BLOCK A GROUND FLOOR
PATHARQUARY GUW5AHATI-781171, ASSAM
M: +91-9401727143

STAGE:-
DPR


DRAW5ING NO:-
2024/ASSIST-GNM/MAJ/P/ACA/PROP/01

START DATE	ISSUE DATE	SHEET SIZE
	07-04-2025	A3

PROJECT CODE:-
2024/ASSIST-GNM/MAJ

SCALE:-
N.T.S.

DRAWING TITLE:-
PLUMBING LAYOUT IN
ACADEMIC BLOCK 1

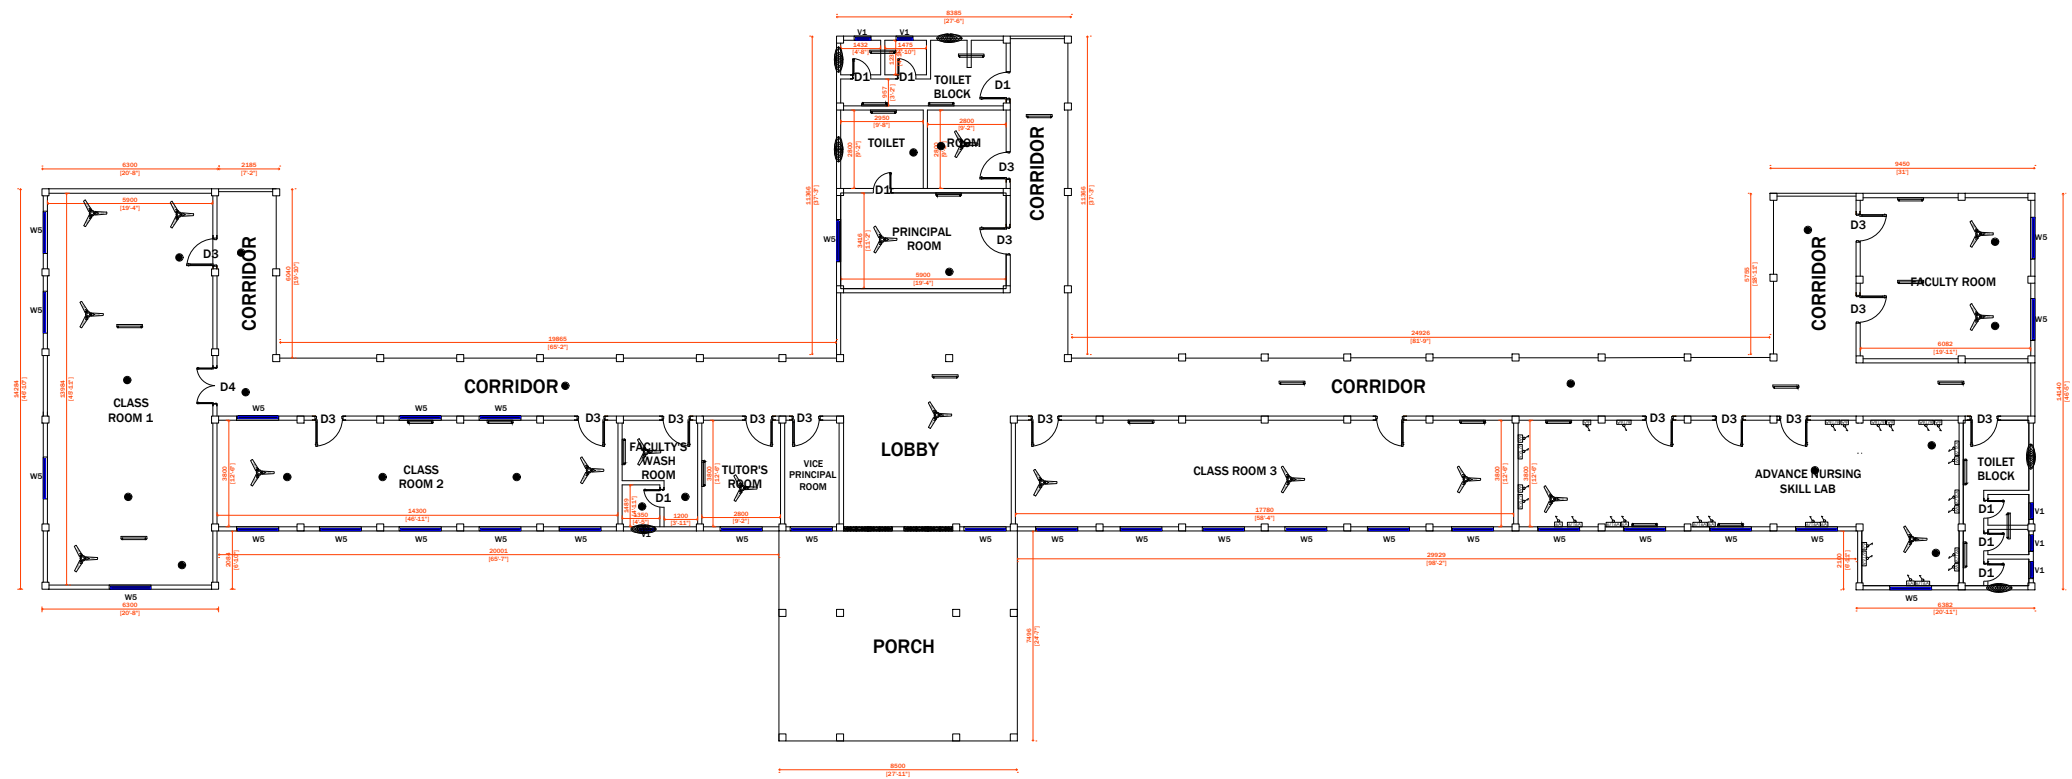

FLOOR PLAN
(GNM SCHOOL OF MAJULI)

PROPOSED LEGEND:	
	4A POWER POINT
	4/16A POWER POINT
	20W LED TUBELIGHT
	1200 MM CEILING FAN
	12W LED DOWNLIGHT
	300 MM EXHAUST FAN

DOOR SCHEDULE:-

SNO	NAME	W5IDTH	HEIGHT	REMARKS
1.	D1	750	2100	SINGLE PANEL WOODEN FLUSH DOOR
2.	D3	1000	2100	SINGLE PANEL WOODEN FLUSH DOOR
3.	D4	1200	2100	DOUBLE PANEL WOODEN FLUSH DOOR

WINDOW SCHEDULE:-

SNO	NAME	SILL	WIDTH	HEIGHT	REMARKS
1.	W5	900	1500	1200	DOUBLE PANEL WOODEN WINDOW WITH GLASS
2.	V1	1650	600	450	SINGLE PANEL WOODEN WINDOW WITH GLASS

PROJECT:-
ASSAM STATE SECONDARY HEALTHCARE
INITIATIVE FOR SERVICE DELIVERY
TRANSFORMATION (ASSIST)

CLIENT:-
ASSAM HEALTH INFRASTRUCTURE
DEVELOPMENT & MANAGEMENT SOCIETY
(AHIDMS)

PRINCIPAL CONSULTANT:



PRITHVI GREENS, BLOCK A GROUND FLOOR
PATHARQUARY GUW5AHATI-781171, ASSAM
M: +91-9401727143

STAGE:-	DPR
---------	-----


DRAW5ING NO:-
2024/ASSIST-GNM/MAJ/E/ACA/ASBUILT/01

START DATE	ISSUE DATE	SHEET SIZE
	15-02-2025	A3

PROJECT CODE:- 2024/ASSIST-GNM/MAJ

SCALE:- N.T.S.

DRAW5ING TITLE:-
ELECTRICAL LAYOUT IN
AS BUILT ACADEMIC BLOCK

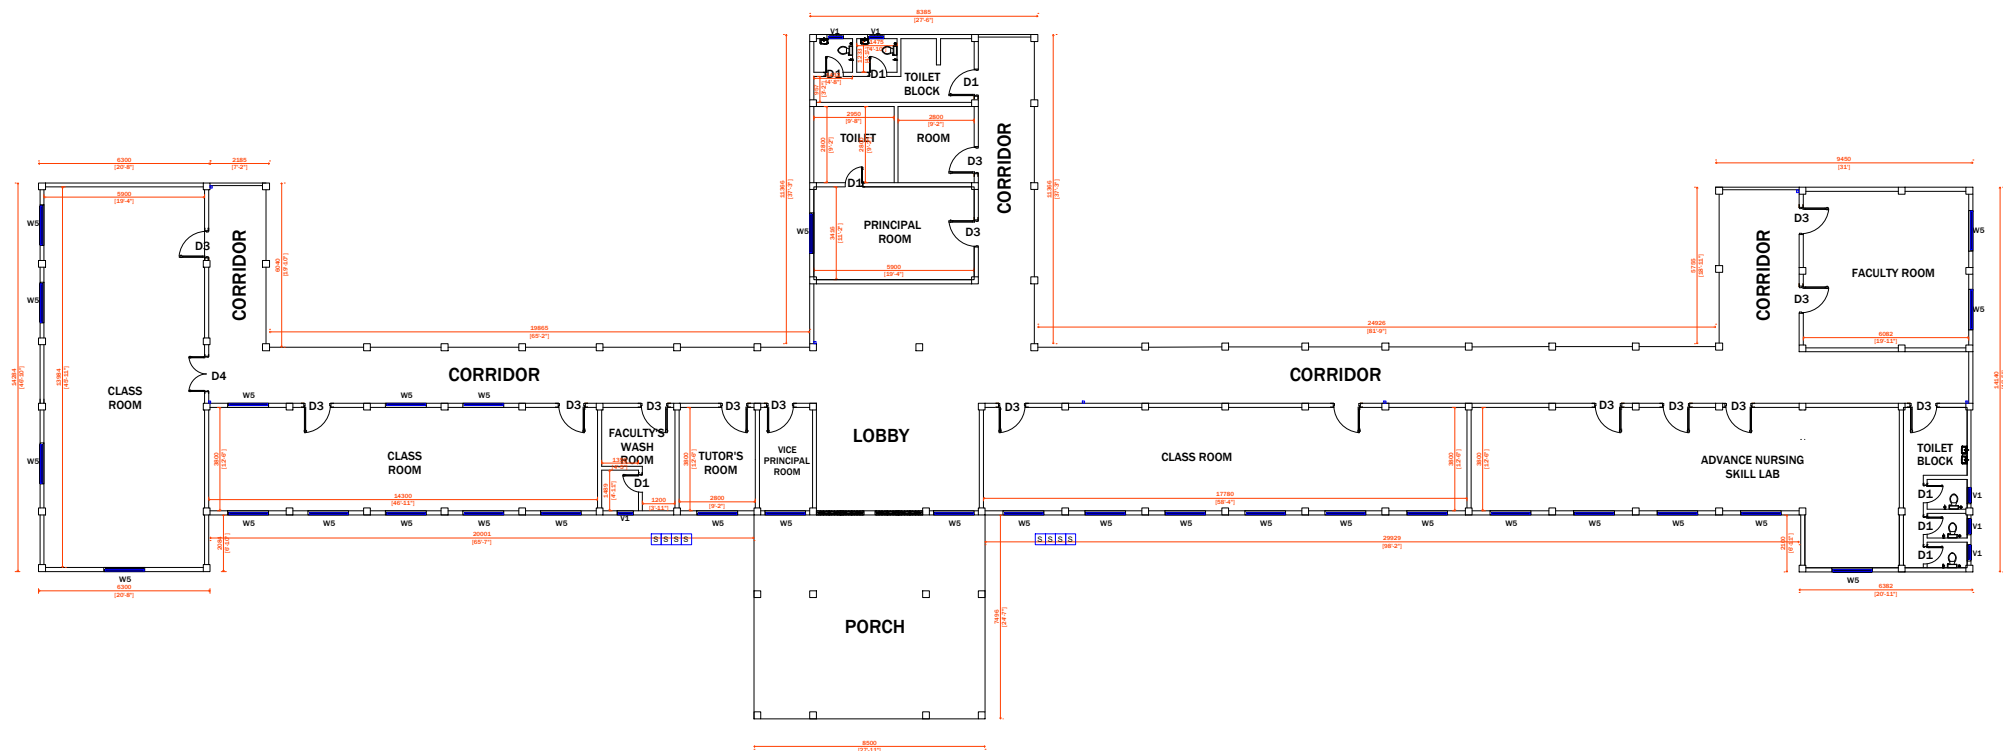

FLOOR PLAN
(GNM SCHOOL OF MAJULI)

DOOR SCHEDULE:-

SNO	NAME	W5IDTH	HEIGHT	REMARKS
1.	D1	750	2100	SINGLE PANEL WOODEN FLUSH DOOR
2.	D3	1000	2100	SINGLE PANEL WOODEN FLUSH DOOR
3.	D4	1200	2100	DOUBLE PANEL WOODEN FLUSH DOOR

WINDOW SCHEDULE:-

SNO	NAME	SILL	WIDTH	HEIGHT	REMARKS
1.	W5	900	1500	1200	DOUBLE PANEL WOODEN WINDOW WITH GLASS
2.	V1	1650	600	450	SINGLE PANEL WOODEN WINDOW WITH GLASS

LEGEND:

FE	FIRE EXTINGUISHER
S	SAND BUCKET

PROJECT:-
ASSAM STATE SECONDARY HEALTHCARE
INITIATIVE FOR SERVICE DELIVERY
TRANSFORMATION (ASSIST)

CLIENT:-
ASSAM HEALTH INFRASTRUCTURE
DEVELOPMENT & MANAGEMENT SOCIETY
(AHIDMS)

PRINCIPAL CONSULTANT:



PRITHVI GREENS, BLOCK A GROUND FLOOR
PATHARQUARY GUW5AHATI-781171, ASSAM
M: +91-9401727143

STAGE:-
DPR


DRAW5ING NO:-
2024/ASSIST-GNM/MAJ/FF/ACA/PROP/01

START DATE	ISSUE DATE	SHEET SIZE
	07-04-2025	A3

PROJECT CODE:-
2024/ASSIST-GNM/MAJ

SCALE:-
N.T.S.

DRAWING TITLE:-
FIRE FIGHTING LAYOUT IN
ACADEMIC BLOCK 1

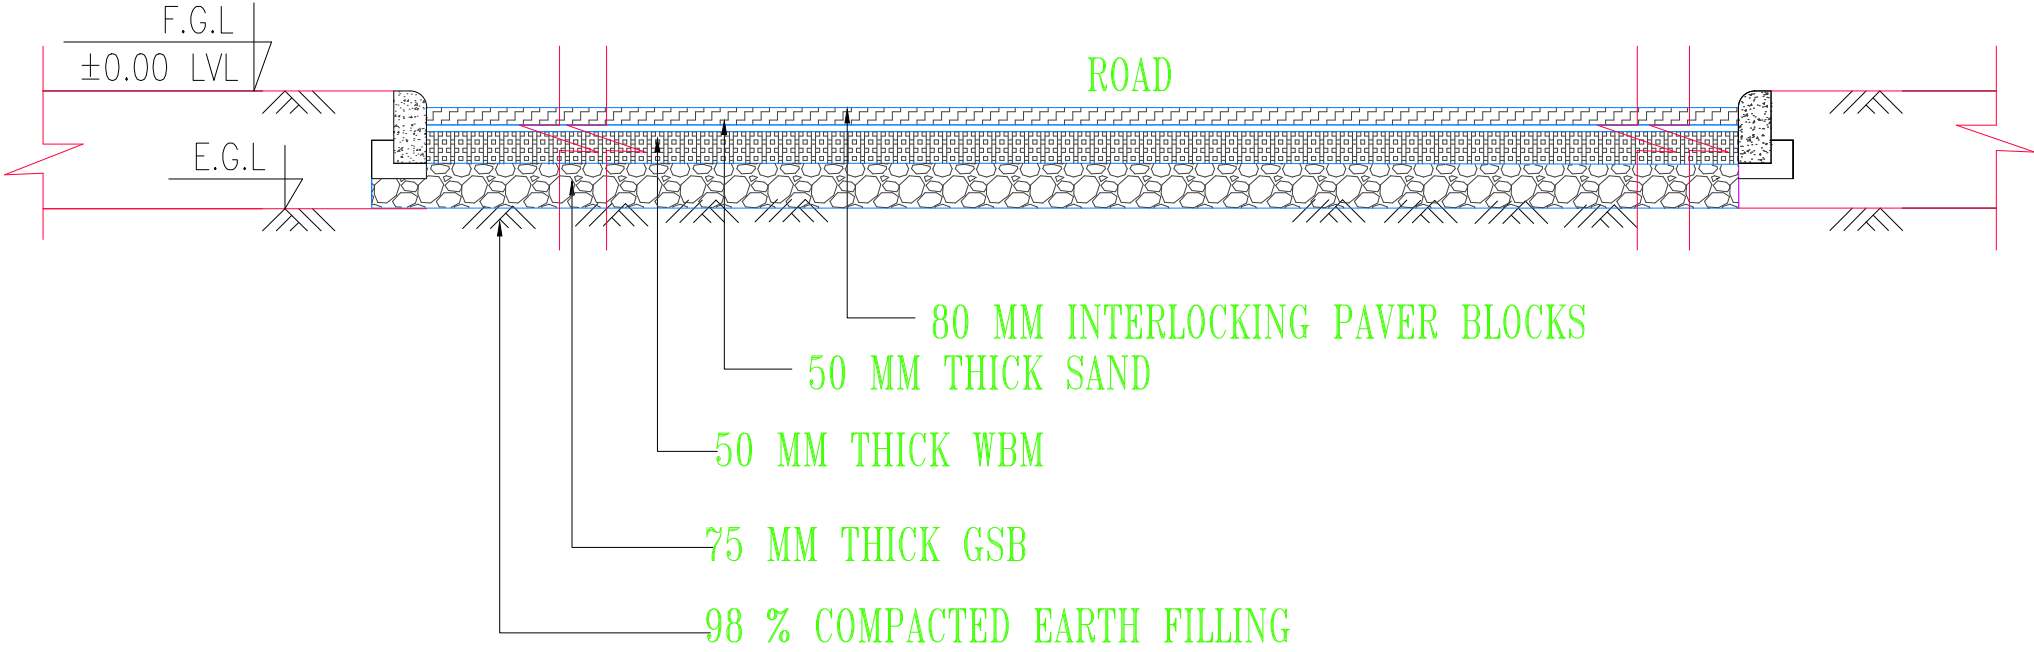

TYPICAL CROSS SECTION FOR PAVERS BLOCK ROAD

PROJECT:-
ASSAM STATE SECONDARY HEALTHCARE
INITIATIVE FOR SERVICE DELIVERY
TRANSFORMATION (ASSIST)

CLIENT:-
ASSAM HEALTH INFRASTRUCTURE
DEVELOPMENT & MANAGEMENT SOCIETY
(AHIDMS)

PRINCIPAL CONSULTANT:




INTEGRA VENTURES
HEALTHCARE | INFRASTRUCTURE | CONSULTANCY
SOLUTIONS | PROJECTS | NETWORK

PRITHVI GREENS, BLOCK A GROUND FLOOR
PATHARQUARY GUWAHATI-781171, ASSAM
M: +91-9401727143

STAGE:-	DPR	
DRAWING NO:- 2024/ASSIST-GNM/MAJ/ROAD /01		
START DATE	ISSUE DATE	SHEET SIZE
	28-03-2024	A3
PROJECT CODE:-	2024/ASSIST-GNM/MAJ	
SCALE:-	N.T.S.	

DRAWING TITLE:-

ROAD DETAIL, GNM,MAJULI,
ASSAM

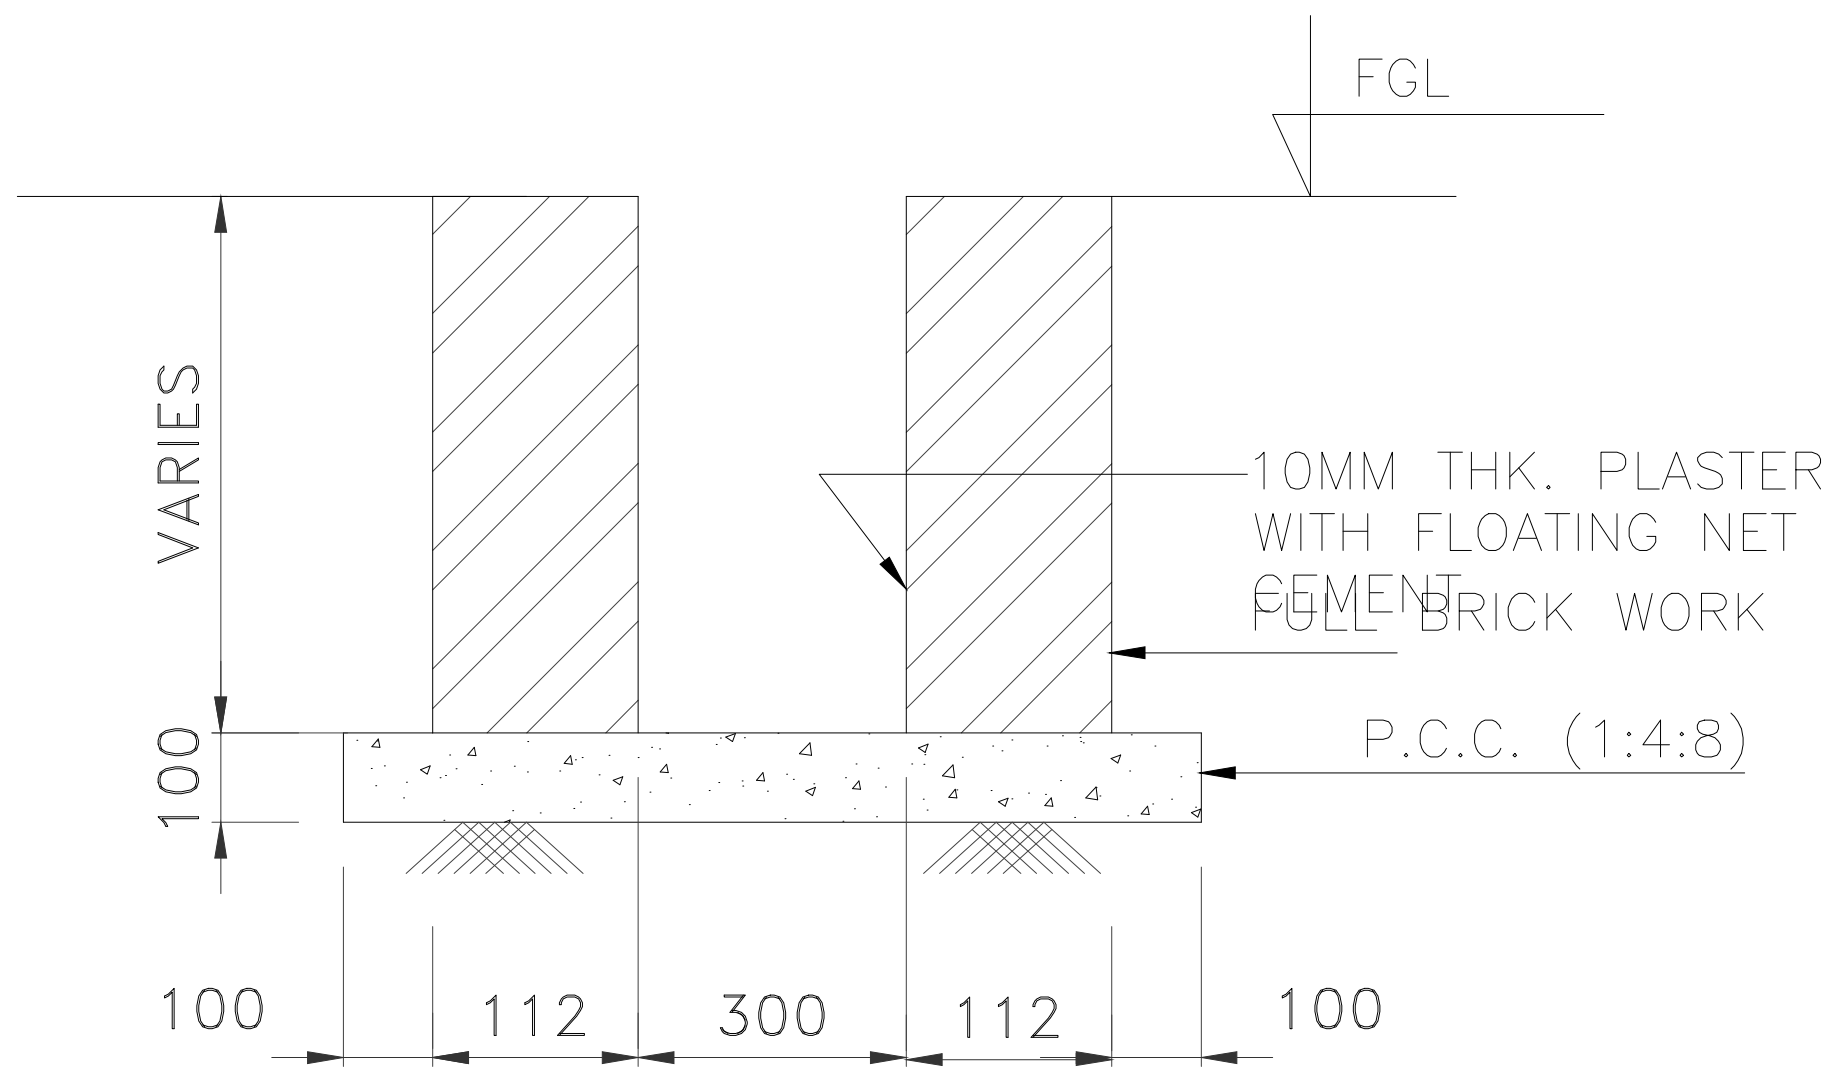

FULL BRICK DRAIN DETAIL
(FOR 300MM WIDE DRAIN)

PROJECT:-
ASSAM STATE SECONDARY HEALTHCARE
INITIATIVE FOR SERVICE DELIVERY
TRANSFORMATION (ASSIST)

CLIENT:-
ASSAM HEALTH INFRASTRUCTURE
DEVELOPMENT & MANAGEMENT SOCIETY
(AHIDMS)

PRINCIPAL CONSULTANT:

PRITHVI GREENS, BLOCK A GROUND FLOOR
PATHARQUARY GUWAHATI-781171, ASSAM
M: +91-9401727143

STAGE:-	DPR
---------	-----





DRAWING NO:- 2024/ASSIST-GNM/MAJ/DRAIN/01
--

START DATE	ISSUE DATE	SHEET SIZE
	28-03-2024	A3


PROJECT CODE:-	2024/ASSIST-GNM/MAJ
----------------	---------------------

SCALE:-	N.T.S.
---------	--------


DRAWING TITLE:- DRAIN DETAIL, GNM, MAJULI, ASSAM
--

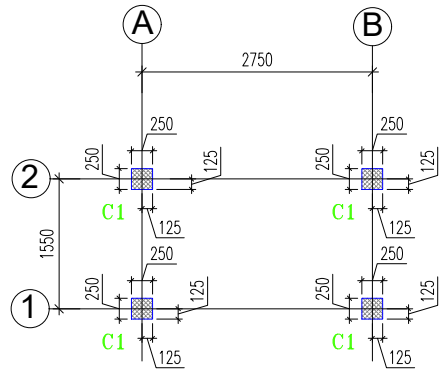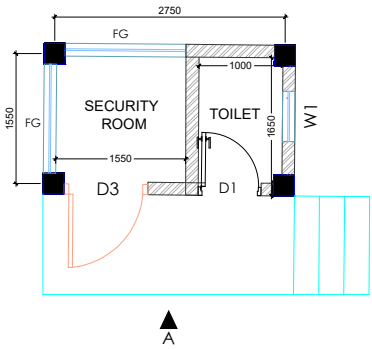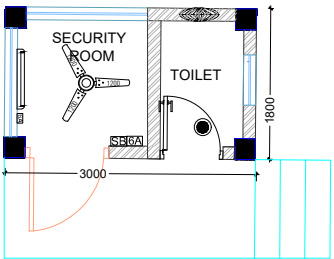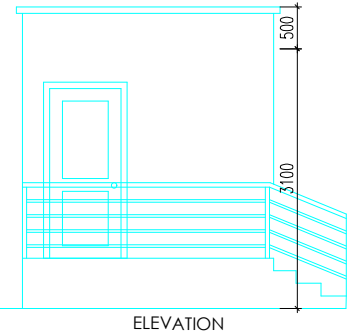


GROUND LVL. PLAN AT+0.00
ALL BEAM SIZE (250X450) U.O.S

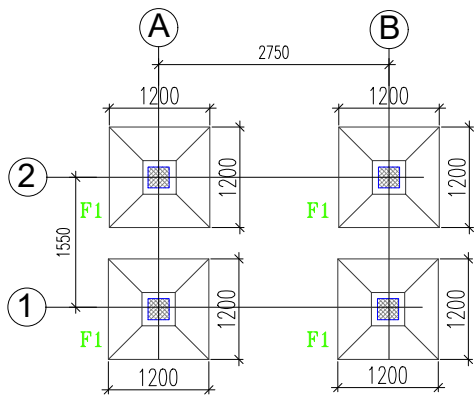


SECURITY ROOM PLAN AT+3100MM
ALL BEAM SIZE (250X450) U.O.S

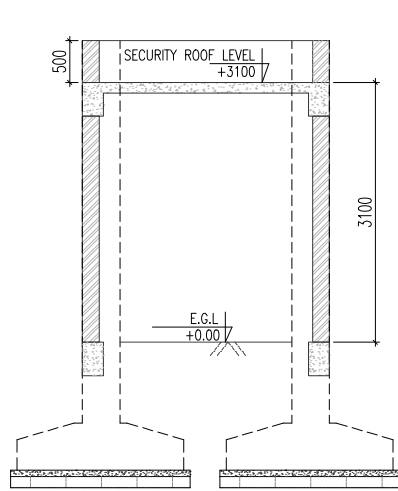

SECTION 1-1

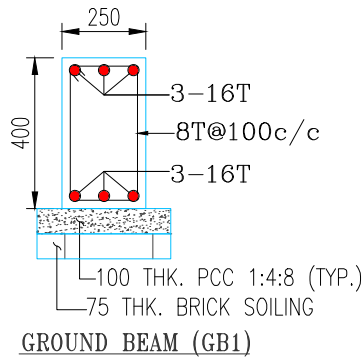

GROUND BEAM (GB1)

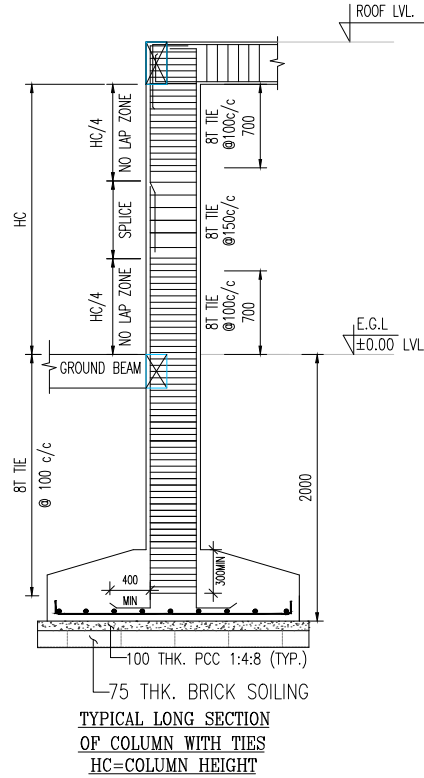

TYPICAL LONG SECTION
OF COLUMN WITH TIES
HC=COLUMN HEIGHT

NOTES:

- ALL DIMENSIONS ARE IN MILLIMETERS.
- THIS DRAWING SHALL BE READ WITH ALL RELEVANT ARCH. DRAWING.
- DO NOT SCALE, FOLLOW WRITTEN DIMENSIONS ONLY.
- ALL R.C.C. WORK SHALL BE DONE AS (IS:456) WITH LATEST AMMENDMENTS.
- STRUCTURAL DESIGN IS CARRIED OUT FOR SEISMIC ZONE V AS PER IS:1893-2016 & IS:456-2000
- GRADE OF CONCRETE WILL BE M25
- CLEAR COVER TO REINFORCEMENT SHALL BE AS PER IS: 456-2000 WHICH ARE AS FOLLOWS :-
A) FOOTINGS : 50 MM
B) BEAMS : 30 MM
C) SLAB : 20 MM
D) COLUMN : 40 MM
- ANY DISCREPANCY IN DIMENSIONS SHALL BE BROUGHT TO THE NOTICE OF ARCHITECT & ENGINEER BEFORE START OF WORK.
- HIGH YIELD STRENGTH DEFORMED BARS WITH CHARACTERISTIC STRENGTH OF 500N/5mm. CONFORMING TO (IS:1786-1985) SHALL BE USED(MT STEEL).
- NOT MORE THAN 50% OF BARS SHALL BE SPICED AT ONE SECTION.
- LAP LENGTH FOR HIGH YIELD STRENGTH DEFORMED BARS SHALL AS PER IS:456.
BARS IN COMPRESSION $40 \times d$
BARS IN TENSION $50 \times d$
WHERE d IS BAR DIAMETER.
- EGL INDICATES EXISTING GROUND LEVEL.
- FGL INDICATES FINISHED GROUND LEVEL.
- IN ALL THE BEAMS, WHERE THERE ARE TWO ROWS OF BARS, EITHER IN TOP OR IN BOTTOM BARS, THE BARS IN EACH SPACING OF 25MM BY PROVISION OF 25MM SPACER BAR.
- WELL COMPACTED EARTH UP TO 98% STANDARD PROCTOR DENSITY REQUIRED BELOW THE FOUNDATION & FLOOR LVL.
- THE ASSUMED BEARING CAPACITY OF SOIL IS TAKEN TO 12 MT/SM AT A DEPTH OF 2.5 METRES BELOW E.G.L. AS PER GEO-TECHNICAL INVESTIGATION REPORT. SOIL CAPACITY NEEDS TO BE CONFIRMED BY CONDUCTING A PLATE-LOAD TEST.

PROPOSED LEGEND:

6A	6A POWER POINT
SB	SWITCH BOARD
20W	20W LED TUBELIGHT
1200	1200 MM CEILING FAN
12W	12W DOWNLIGHT
300	300 MM EXHAUST FAN

PROJECT:-

ASSAM STATE SECONDARY HEALTHCARE INITIATIVE FOR SERVICE DELIVERY TRANSFORMATION (ASSIST)

CLIENT:-

ASSAM HEALTH INFRASTRUCTURE DEVELOPMENT & MANAGEMENT SOCIETY (AHIDMS)

PRINCIPAL CONSULTANT:



PRITHVI GREENS, BLOCK A GROUND FLOOR
PATHARQUARY GUWAHATI-781171, ASSAM
M: +91-9401727143

STAGE:-

DPR

DRAWING NO:-

2024/ASSIST-GNM/MAJ/SECURITY /01

START DATE

ISSUE DATE

SHEET SIZE

28-03-2025

A3

PROJECT CODE:-


2024/ASSIST-ANM/MAJ

SCALE:-


N.T.S.

DRAWING TITLE:-

PROPOSED SECURITY BOOTH
DETAIL, GNM, MAJULI, ASSAM

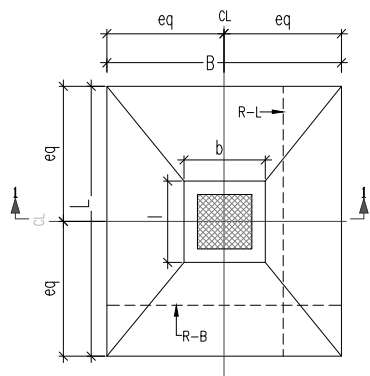



TYPICAL PLAN OF ISOLATED FOOTING

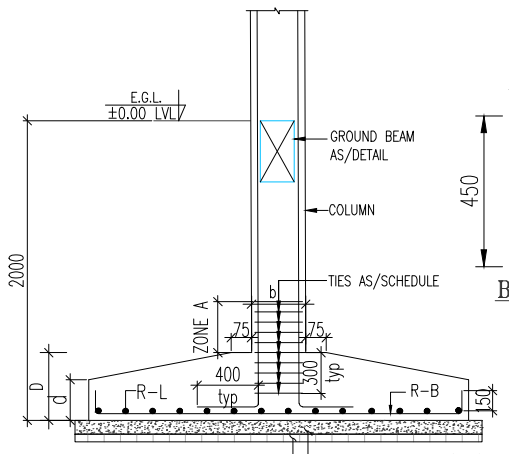

TYPICAL FOOTING-COLUMN JUNCTION DETAIL
SECTION 1-1

SCHEDULE OF ISOLATED FOOTINGS

FOOTING NO.	FOOTING SIZE				DEPTH OF FOOTING		REINFORCEMENT	
	L	B	l	b	D	d	R-L	R-B
F1	1200	1200	400	400	450	250	12T@125c/c	12T@125c/c

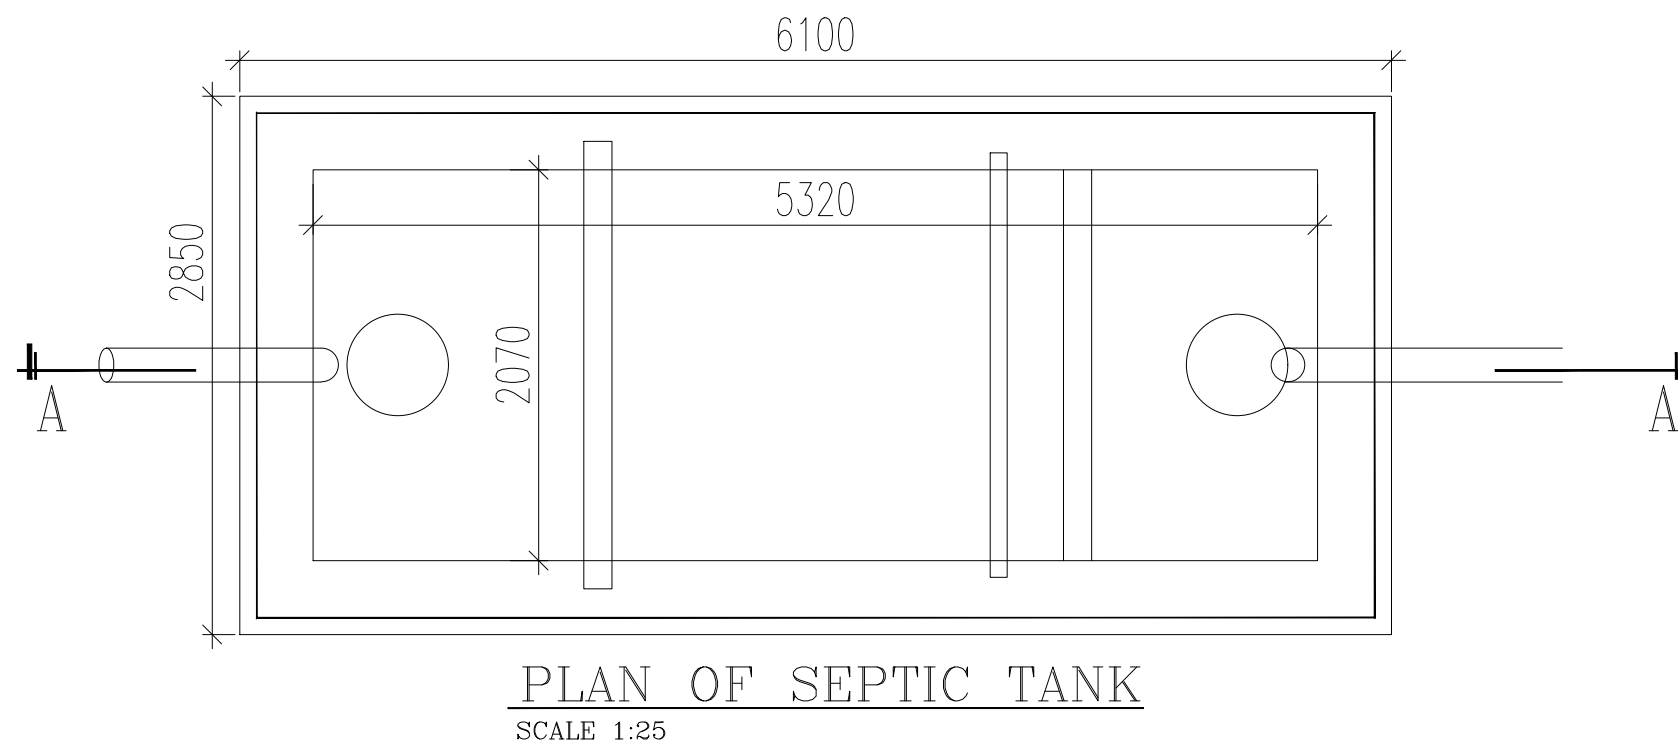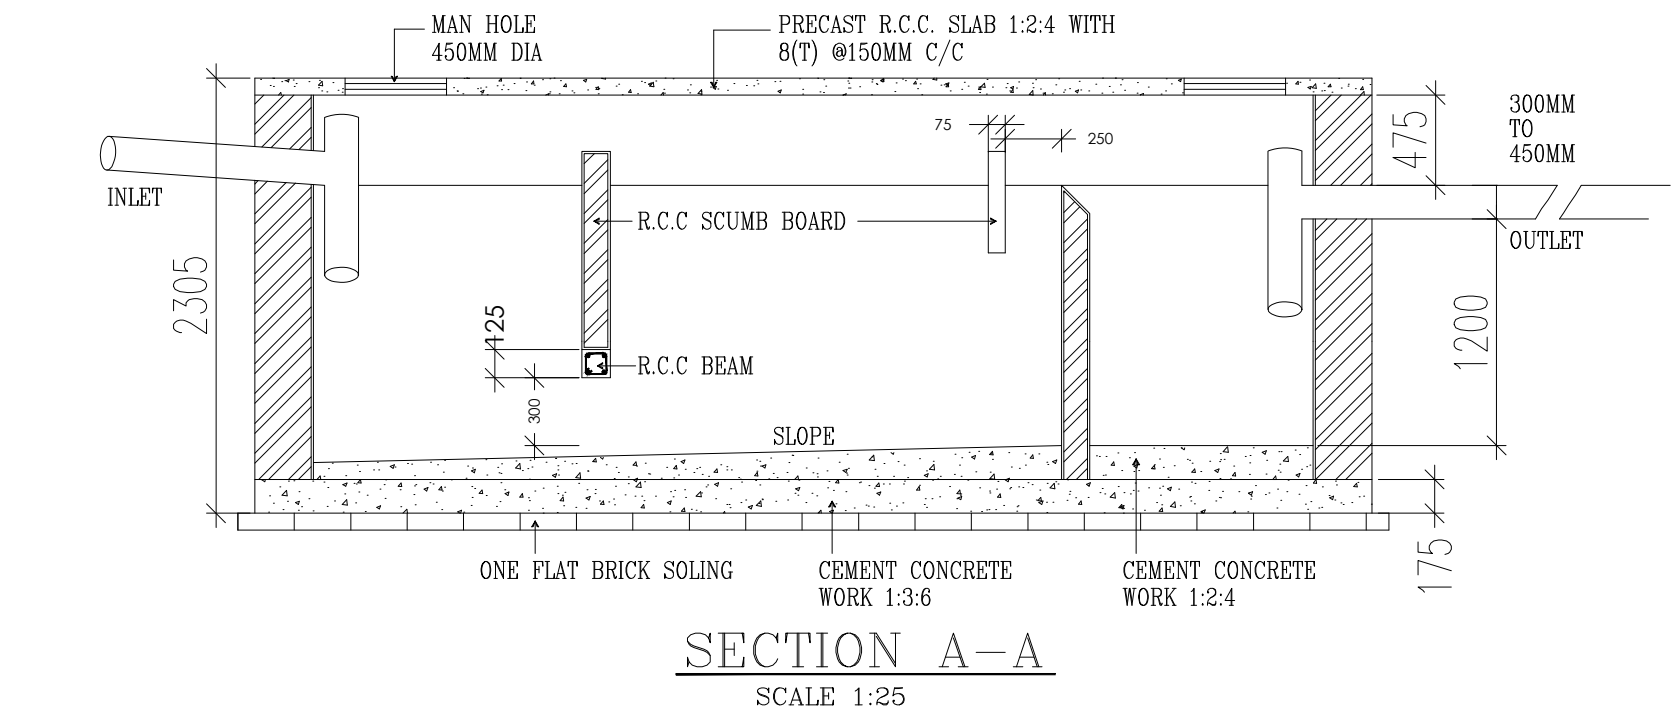

PROJECT:- ASSAM STATE SECONDARY HEALTHCARE INITIATIVE FOR SERVICE DELIVERY TRANSFORMATION (ASSIST)		
CLIENT:- ASSAM HEALTH INFRASTRUCTURE DEVELOPMENT & MANAGEMENT SOCIETY (AHIDMS)		
PRINCIPAL CONSULTANT: INTEGRA VENTURES HEALTHCARE INFRASTRUCTURE CONSULTANCY solutions projects services PRITHVI GREENS, BLOCK A GROUND FLOOR PATHARQUARY GUWAHATI-781171, ASSAM M: +91-9401727143		
STAGE:-		DPR
DRAWING NO:- 2024/ASSIST-GNM/MAJ/SEPTIC TANK/01		
START DATE	ISSUE DATE	SHEET SIZE
	28-03-2025	A3
PROJECT CODE:-		2024/ASSIST-GNM/MAJ
SCALE:-	N.T.S.	
DRAWING TITLE:- SEPTIC TANK DETAIL, GNM, MAJULI, ASSAM		