

**Drawings
of
GNM Training
Centre, Civil Hospital,
Tezpur,
Assam**




Submitted by- INTEGRA VENTURES

Prithvi Greens, Block A, Ground Floor, Pathar Quarry
Guwahati: 781171, Assam, India

Branches

GUWAHATI | KOLKATA | DELHI | BENGALURU | NAIROBI |

LIST OF DRAWINGS			
TEZPUR GNM			
Sl No.	Drawing Name	Drawing Number	No
1	SITE PLAN ACADEMIC BLOCK - AS BUILT	2024/ASSIST-ANG/TEZ/ACA/SP/AS BUILT/01	1
2	SITE PLAN HOSTEL BLOCK - AS BUILT	2024/ASSIST-ANG/TEZ/H/SP/AS BUILT/01	1
3	SITE PLAN ACADEMIC BLOCK - PROPOSED	2024/ASSIST-ANG/TEZ/ACA/SP/PROP/01	1
4	SITE PLAN HOSTEL BLOCK - PROPOSED	2024/ASSIST-ANG/TEZ/H/SP/PROP/01	1
	CIVIL		
5	AS BUILT ACADEMIC BLOCK GROUND FLOOR	2024/ASSIST-GNM/TEZ/AR/ACA/ASBUILT/01	1
6	AS BUILT ACADEMIC BLOCK FIRST FLOOR	2024/ASSIST-GNM/TEZ/AR/ACA/ASBUILT/02	1
7	AS BUILT HOSTEL BLOCK GROUND FLOOR	2024/ASSIST-GNM/TEZ/AR/H/ASBUILT/01	1
8	PROPOSED ACADEMIC BLOCK GROUND FLOOR (BLOCK A)	2024/ASSIST-GNM/TEZ/AR/ACA/A/PROP/01	1
9	PROPOSED ACADEMIC BLOCK FIRST FLOOR (BLOCK A)	2024/ASSIST-GNM/TEZ/AR/ACA/A/PROP/02	1
	PLUMBING		
13	PROPOSED ACADEMIC BLOCK GROUND FLOOR PLUMBING LAYOUT(BLOCK 1)	2024/ASSIST-GNM/TEZ/P/ACA/PROP/01	1
14	PROPOSED ACADEMIC BLOCK FIRST FLOOR PLUMBING LAYOUT(BLOCK 1)	2024/ASSIST-GNM/TEZ/P/ACA/PROP/02	1
15	PROPOSED HOSTEL BLOCK GROUND FLOOR PLUMBING LAYOUT	2024/ASSIST-GNM/TEZ/P/H/PROP/01	1
	ELECTRICAL		
16	PROPOSED ACADEMIC BLOCK GROUND FLOOR ELECTRICAL LAYOUT(BLOCK 1)	2024/ASSIST-GNM/TEZ/E/ACA/PROP/01	1
17	PROPOSED ACADEMIC BLOCK FIRST FLOOR ELECTRICAL LAYOUT(BLOCK 1)	2024/ASSIST-GNM/TEZ/E/ACA/PROP/02	1
18	PROPOSED HOSTEL BLOCK GROUND FLOOR ELECTRICAL LAYOUT	2024/ASSIST-GNM/TEZ/E/H/PROP/01	1
	FIRE FIGHTING		
19	PROPOSED ACADEMIC BLOCK GROUND FLOOR FIRE FIGHTING LAYOUT(BLOCK 1)	2024/ASSIST-GNM/DAR/FF/ACA/PROP/01	1
20	PROPOSED ACADEMIC BLOCK FIRST FLOOR FIRE FIGHTING LAYOUT(BLOCK 1)	2024/ASSIST-GNM/DAR/FF/ACA/PROP/02	1
21	PROPOSED HOSTEL BLOCK GROUND FLOOR FIRE FIGHTING LAYOUT	2024/ASSIST-GNM/DAR/FF/H/PROP/01	1
22	ROAD DETAIL	2024/ASSIST-GNM/TEZ/ROAD /01	1
23	DRAIN DETAIL	2024/ASSIST-GNM/TEZ/DRAIN/01	1
24	SECURITY CABIN	2024/ASSIST-GNM/TEZ/SECURITY /01	1
25	SEPTIC TANK	2024/ASSIST-GNM/TEZ/SEPTIC TANK/01	1

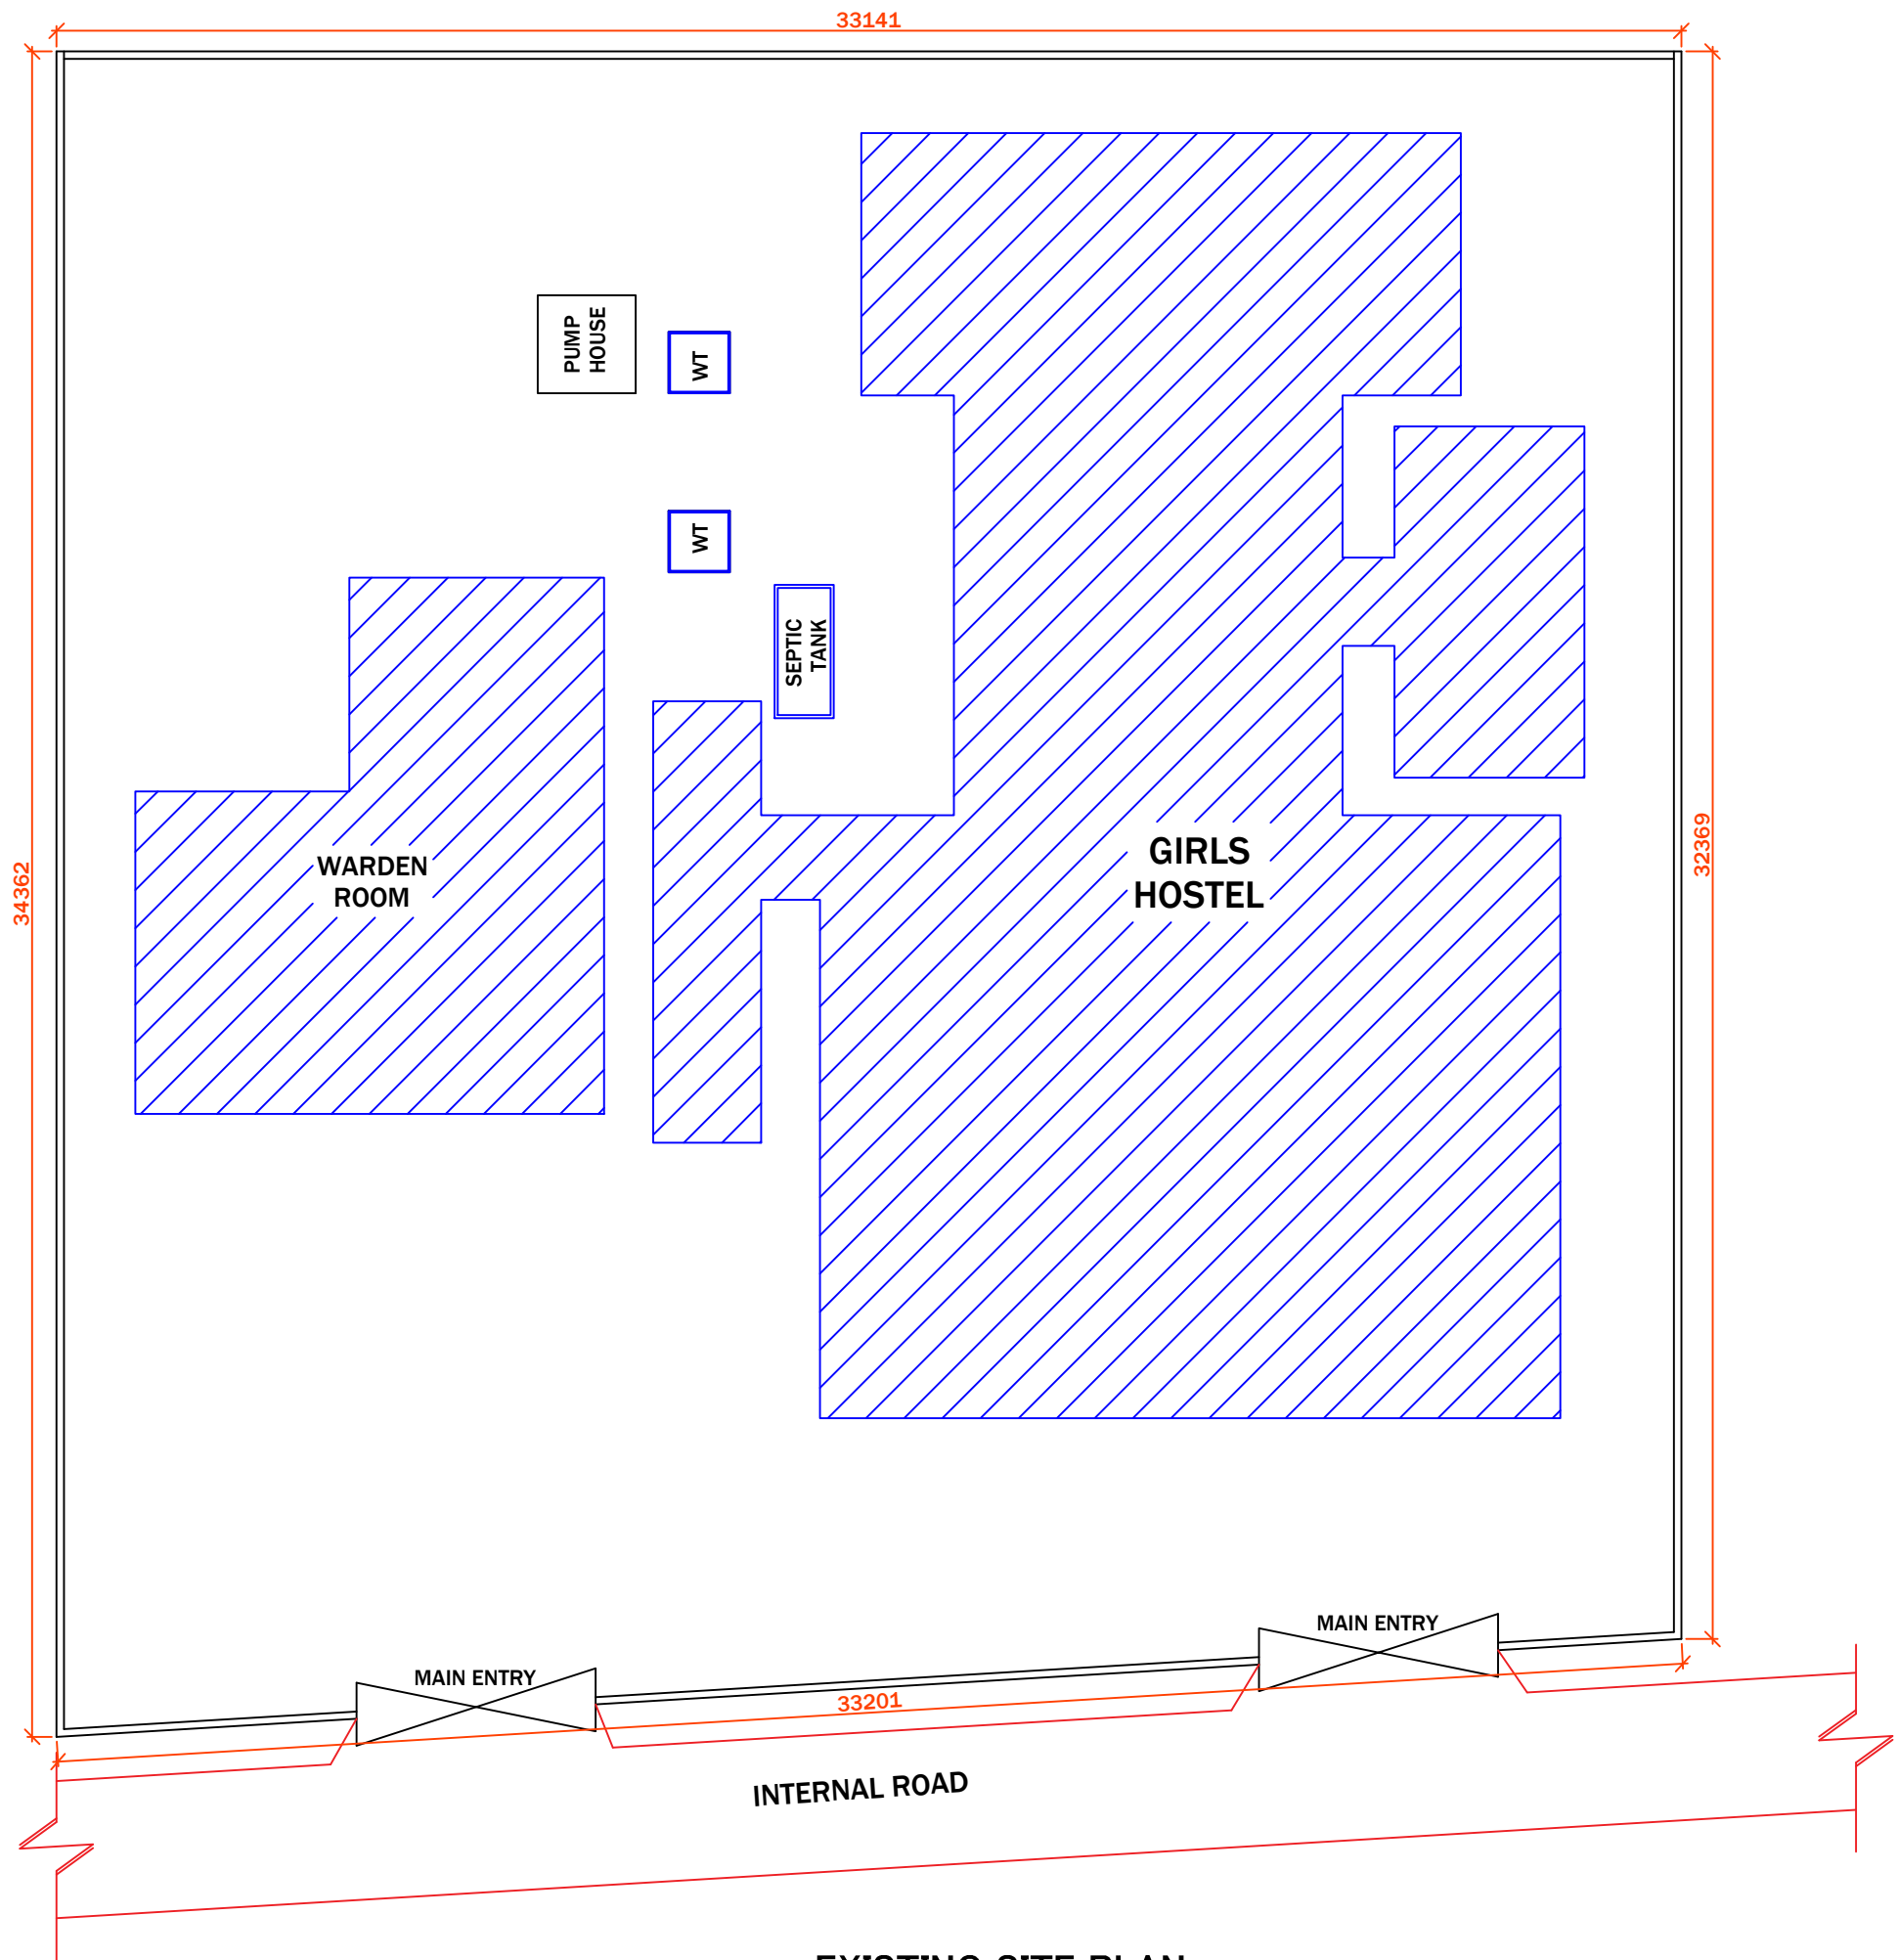

PROJECT:-
ASSAM STATE SECONDARY HEALTHCARE
INITIATIVE FOR SERVICE DELIVERY
TRANSFORMATION (ASSIST)

CLIENT:-
ASSAM HEALTH INFRASTRUCTURE
DEVELOPMENT & MANAGEMENT SOCIETY
(AHIDMS)

PRINCIPAL CONSULTANT:
**INTEGRA VENTURES**
HEALTHCARE | INFRASTRUCTURE | CONSULTANCY
SOLUTIONS | DESIGN | SERVICES
PRITHVI GREENS, BLOCK A GROUND FLOOR
PATHARQUARY GUWAHATI-781171, ASSAM
M: +91-9401727143

STAGE:- DPR


DRAWING NO:-
2024/ASSIST-GNM/TEZ/SITE/HS/AS BUILT/01

START DATE	ISSUE DATE	SHEET SIZE
	05-04-2025	A3

PROJECT CODE:- 2024/ASSIST-GNM/TEZ

SCALE:- N.T.S.

DRAWING TITLE:-
AS BUILT SITE PLAN HOSTEL
BLOCK, GNM, TEZPUR, ASSAM.

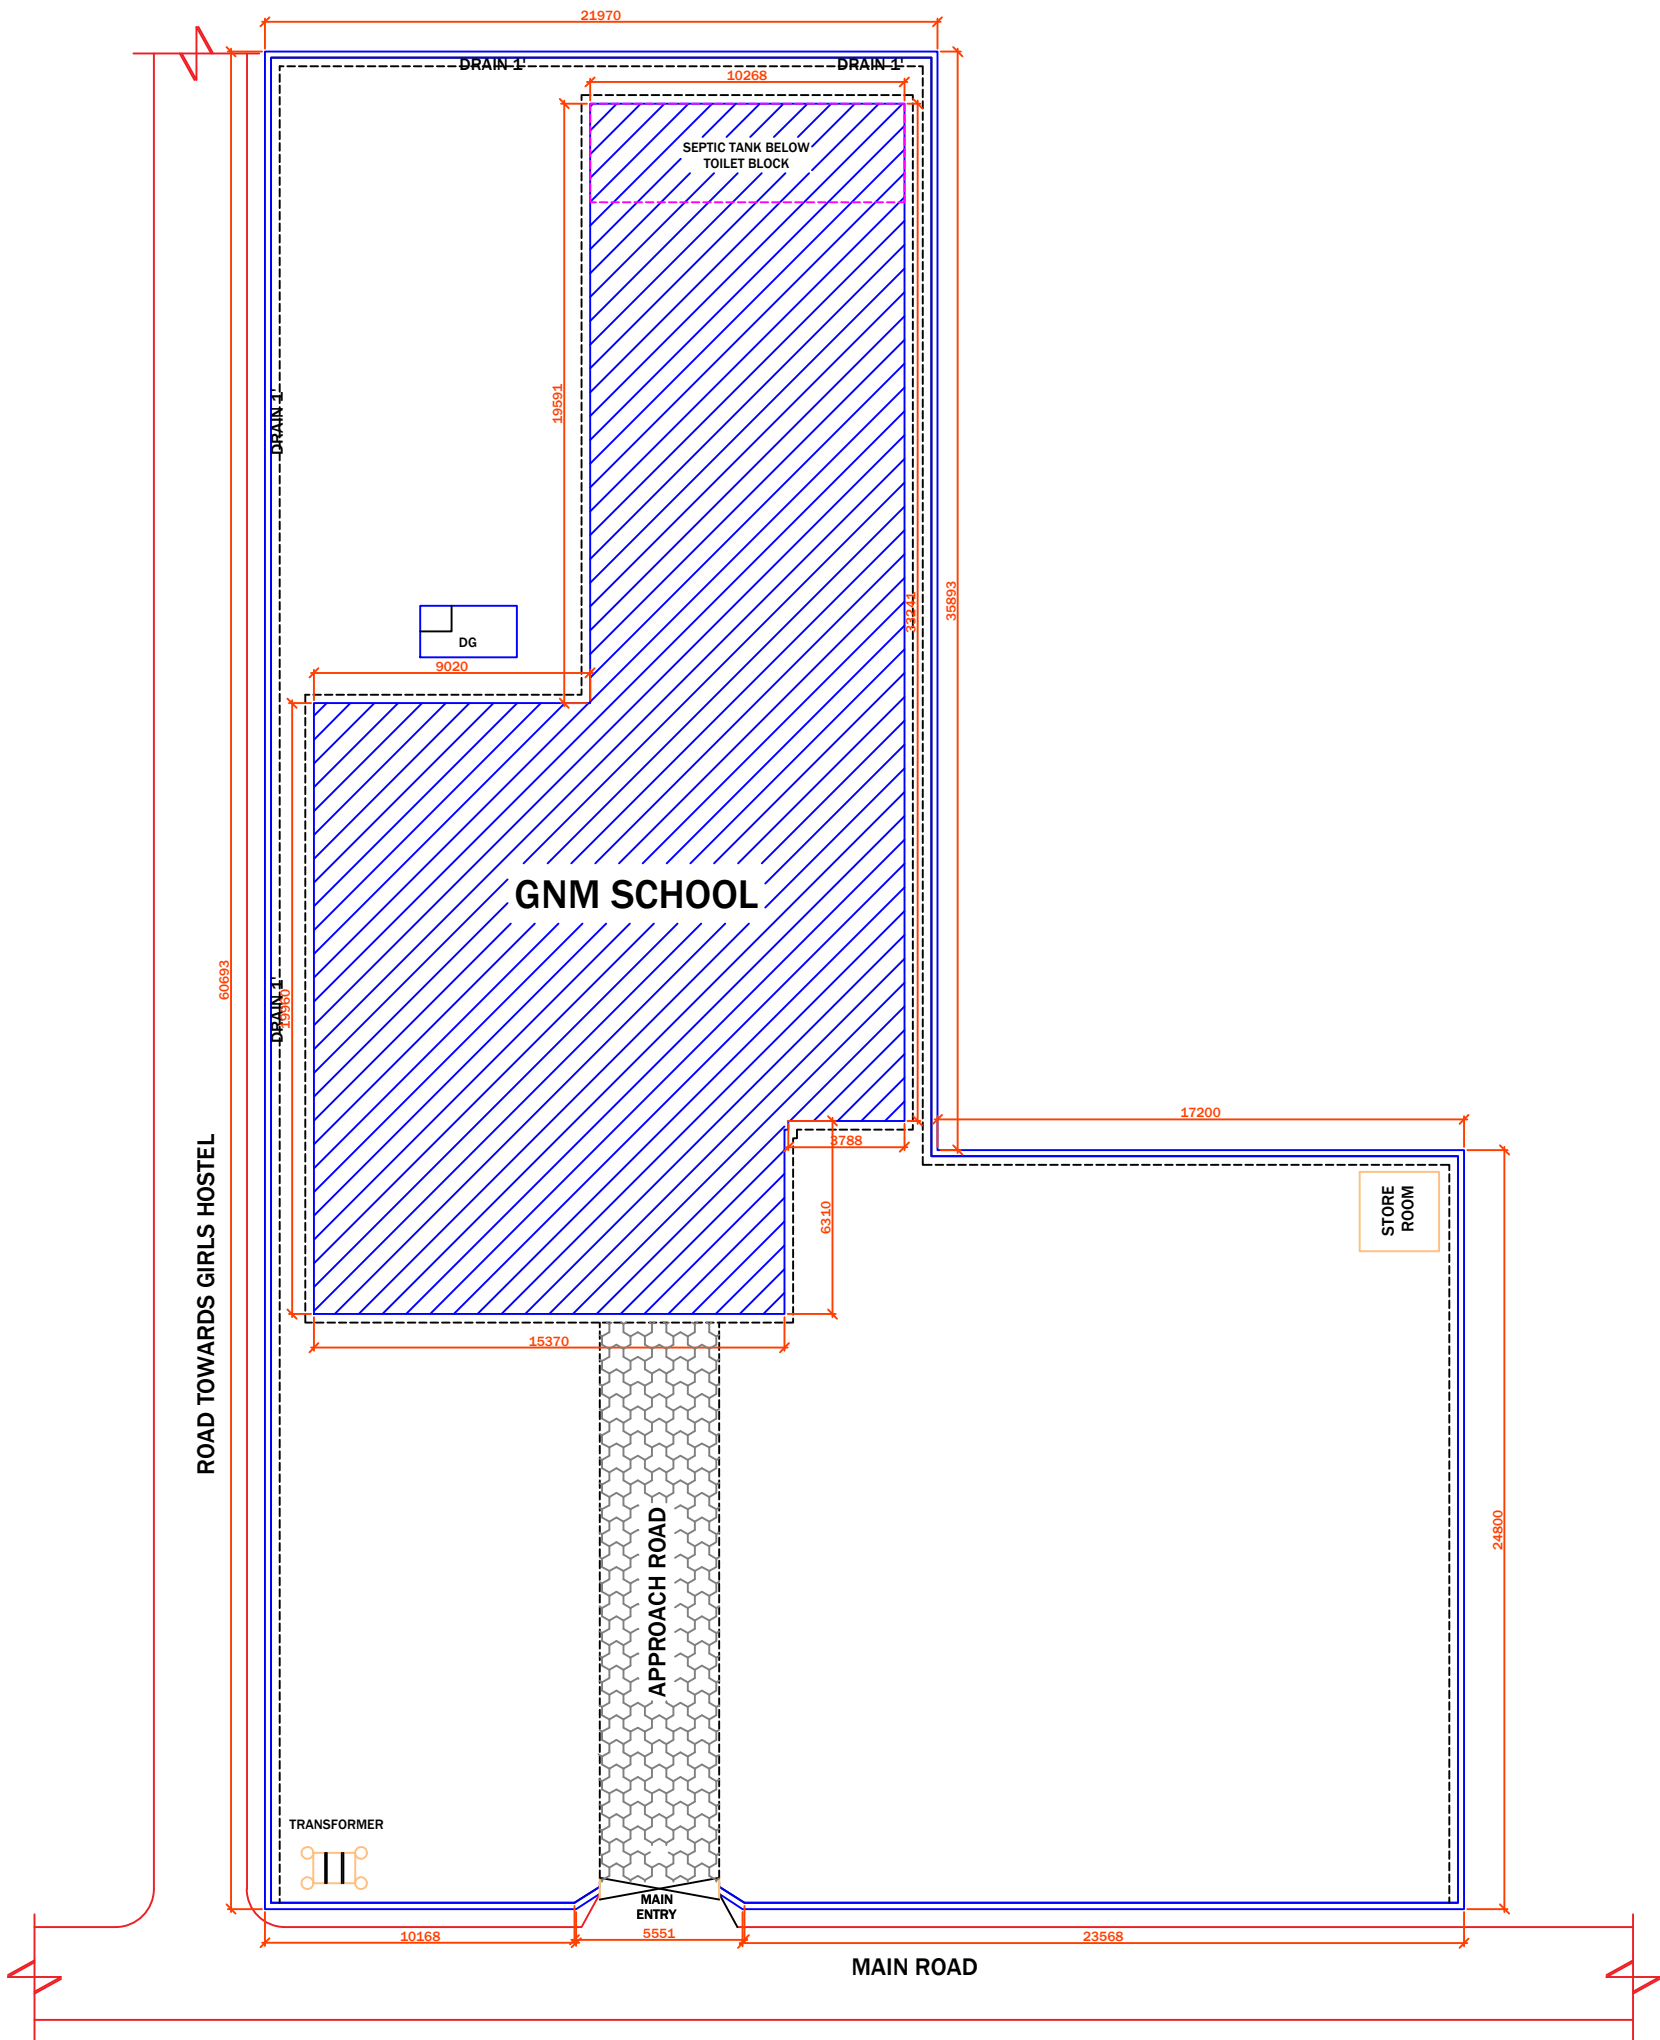

EXISTING ACADEMIC BLOCK
SCALE- 1:100

PROJECT:-
ASSAM STATE SECONDARY HEALTHCARE
INITIATIVE FOR SERVICE DELIVERY
TRANSFORMATION (ASSIST)

CLIENT:-
ASSAM HEALTH INFRASTRUCTURE
DEVELOPMENT & MANAGEMENT SOCIETY
(AHIDMS)

PRINCIPAL CONSULTANT:
**INTEGRA VENTURES**
HEALTHCARE | INFRASTRUCTURE | CONSULTANCY
SERVICES | PROJECTS | SERVICES
PRITHVI GREENS, BLOCK A GROUND FLOOR
PATHARQUARY GUWAHATI-781171, ASSAM
M: +91-9401727143

STAGE:- DPR


DRAWING NO:-
2024/ASSIST-GNM/TEZ/SITE/AC/AS BUILT/01

START DATE	ISSUE DATE	SHEET SIZE
	05-04-2025	A3

PROJECT CODE:- 2024/ASSIST-GNM/TEZ

SCALE:- N.T.S.

DRAWING TITLE:-
AS BUILT SITE PLAN ACADEMIC
BLOCK, GNM, TEZPUR, ASSAM.

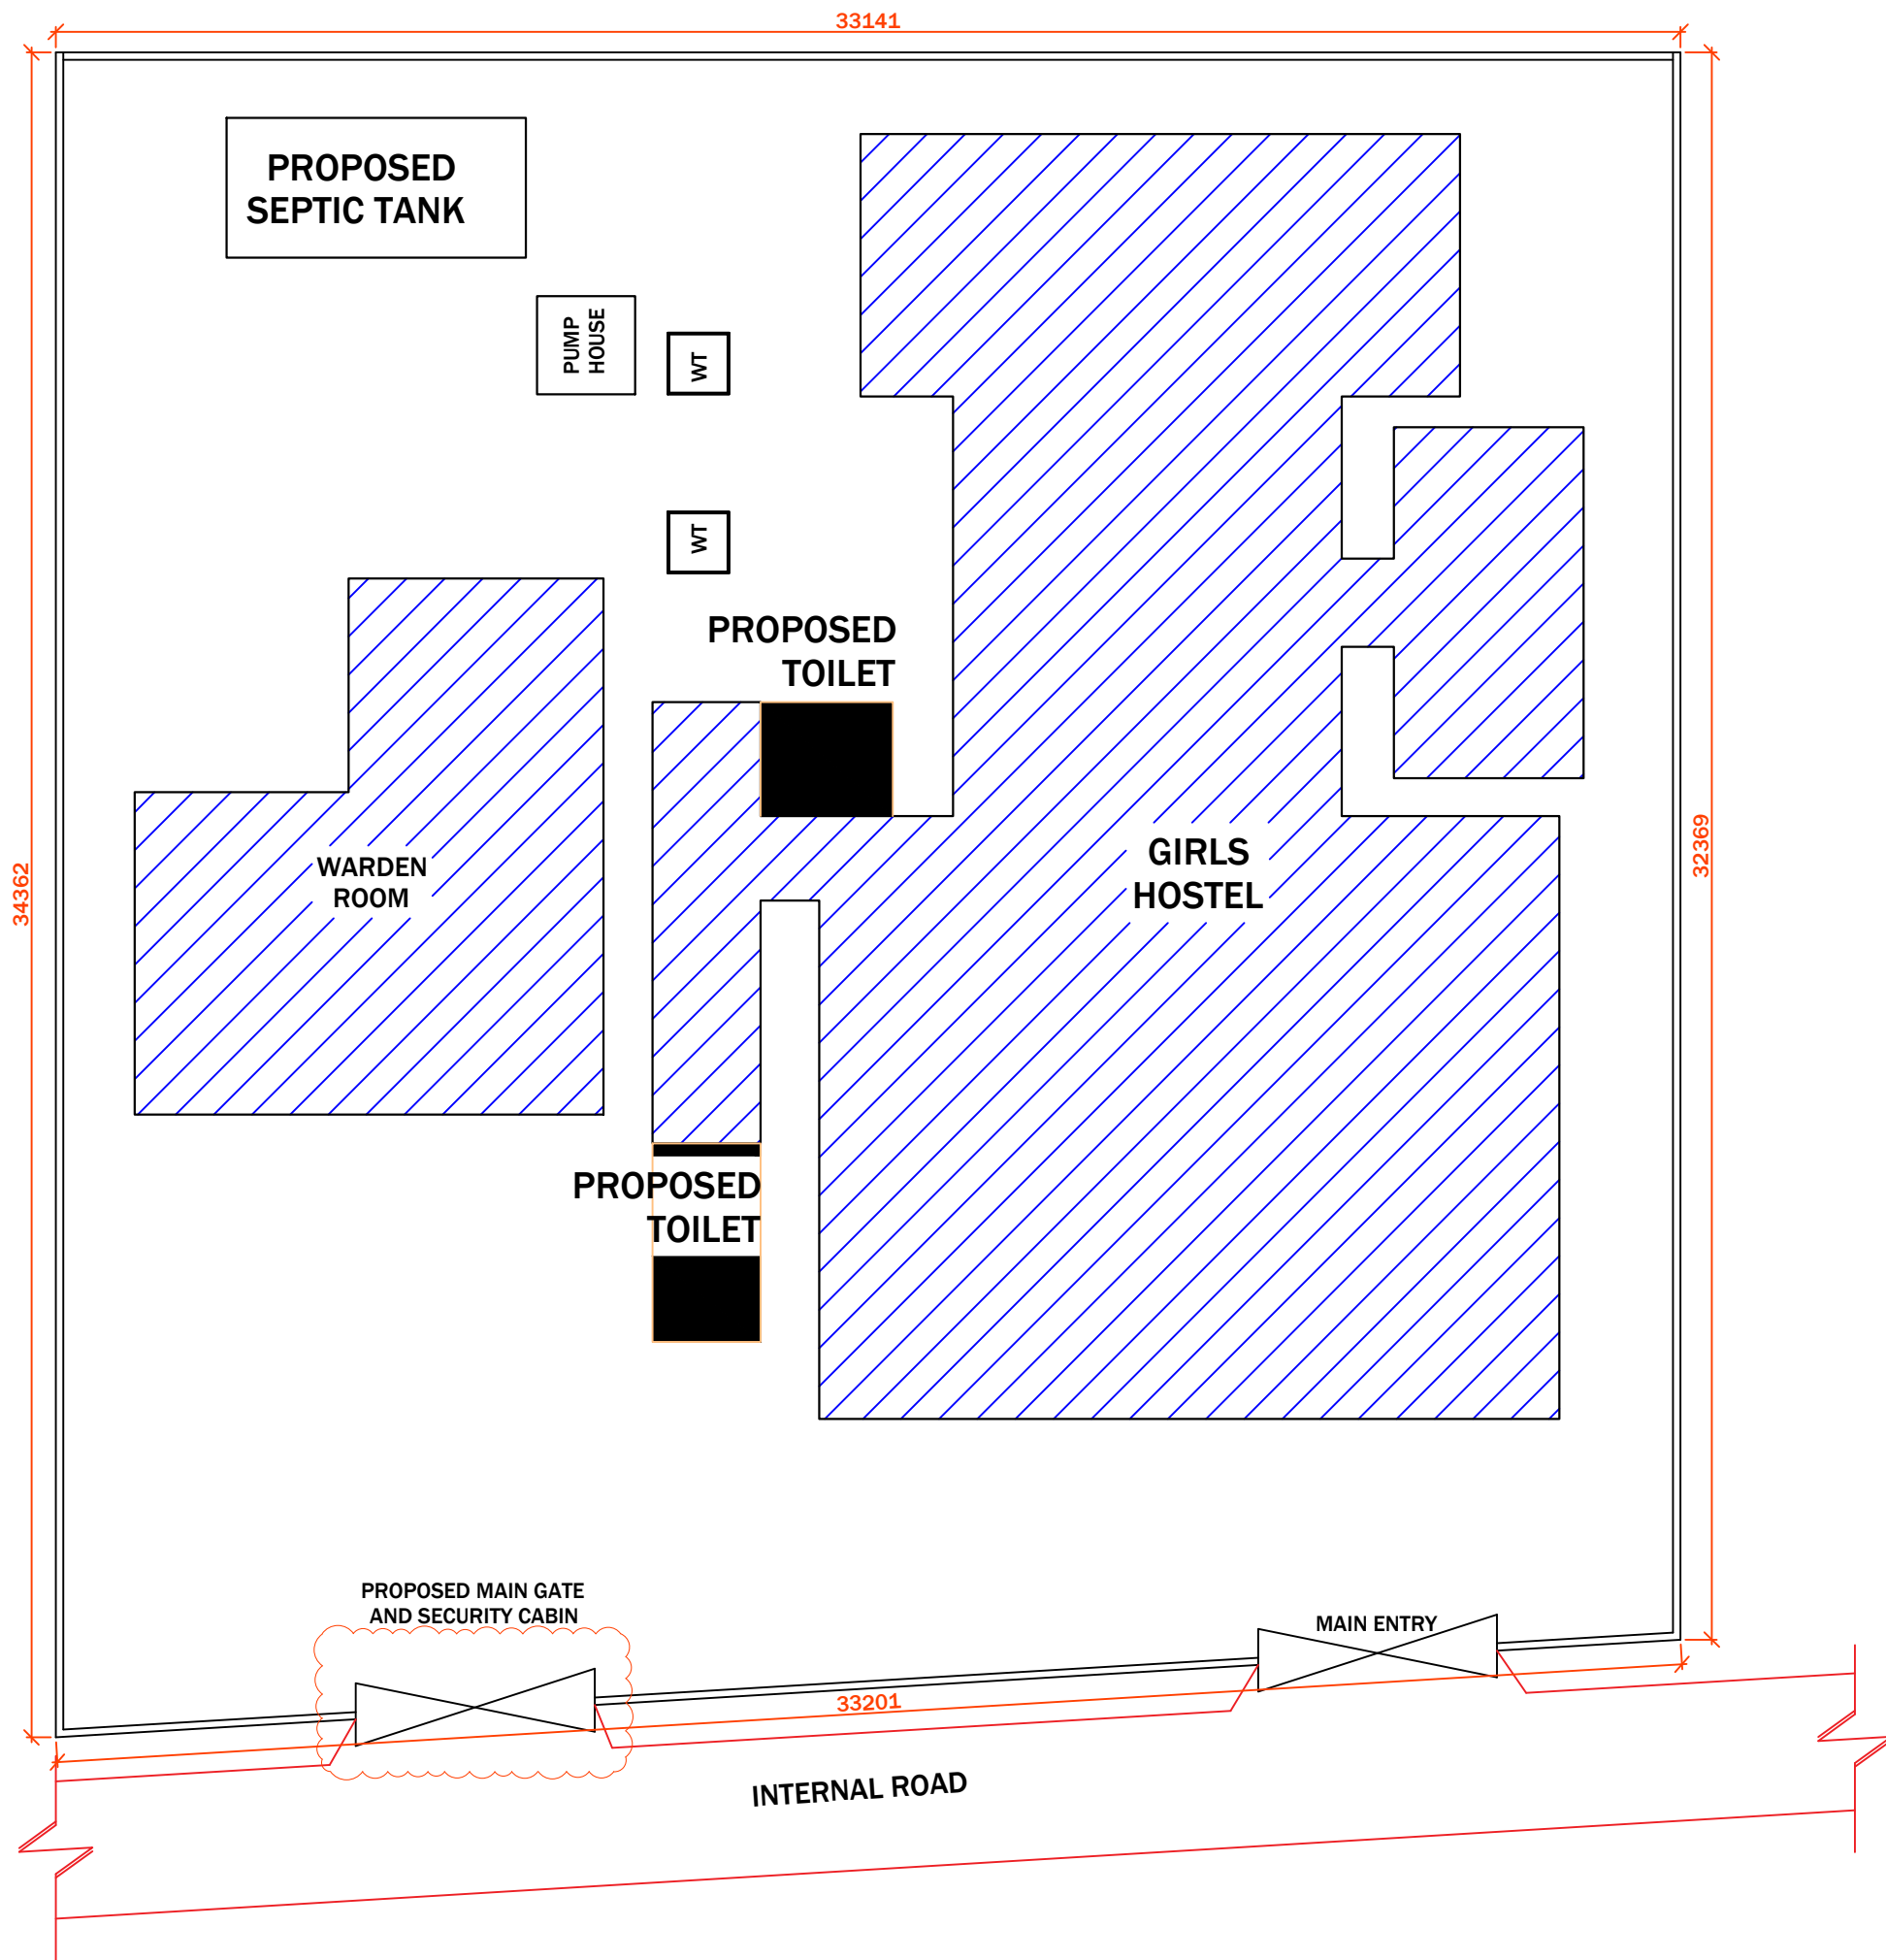

EXISTING SITE PLAN
SCALE- 1:100

PROJECT:-
ASSAM STATE SECONDARY HEALTHCARE
INITIATIVE FOR SERVICE DELIVERY
TRANSFORMATION (ASSIST)

CLIENT:-
ASSAM HEALTH INFRASTRUCTURE
DEVELOPMENT & MANAGEMENT SOCIETY
(AHIDMS)

PRINCIPAL CONSULTANT:

PRITHVI GREENS, BLOCK A GROUND FLOOR
PATHARQUARY GUWAHATI-781171, ASSAM
M: +91-9401727143

STAGE:- DPR


DRAWING NO:-
2024/ASSIST-GNM/TEZ/SITE/HS/PROP/01

START DATE	ISSUE DATE	SHEET SIZE
	05-04-2025	A3

PROJECT CODE:- 2024/ASSIST-GNM/TEZ

SCALE:- N.T.S.

DRAWING TITLE:-
PROPOSED SITE PLAN HOSTEL
BLOCK, GNM, TEZPUR, ASSAM.

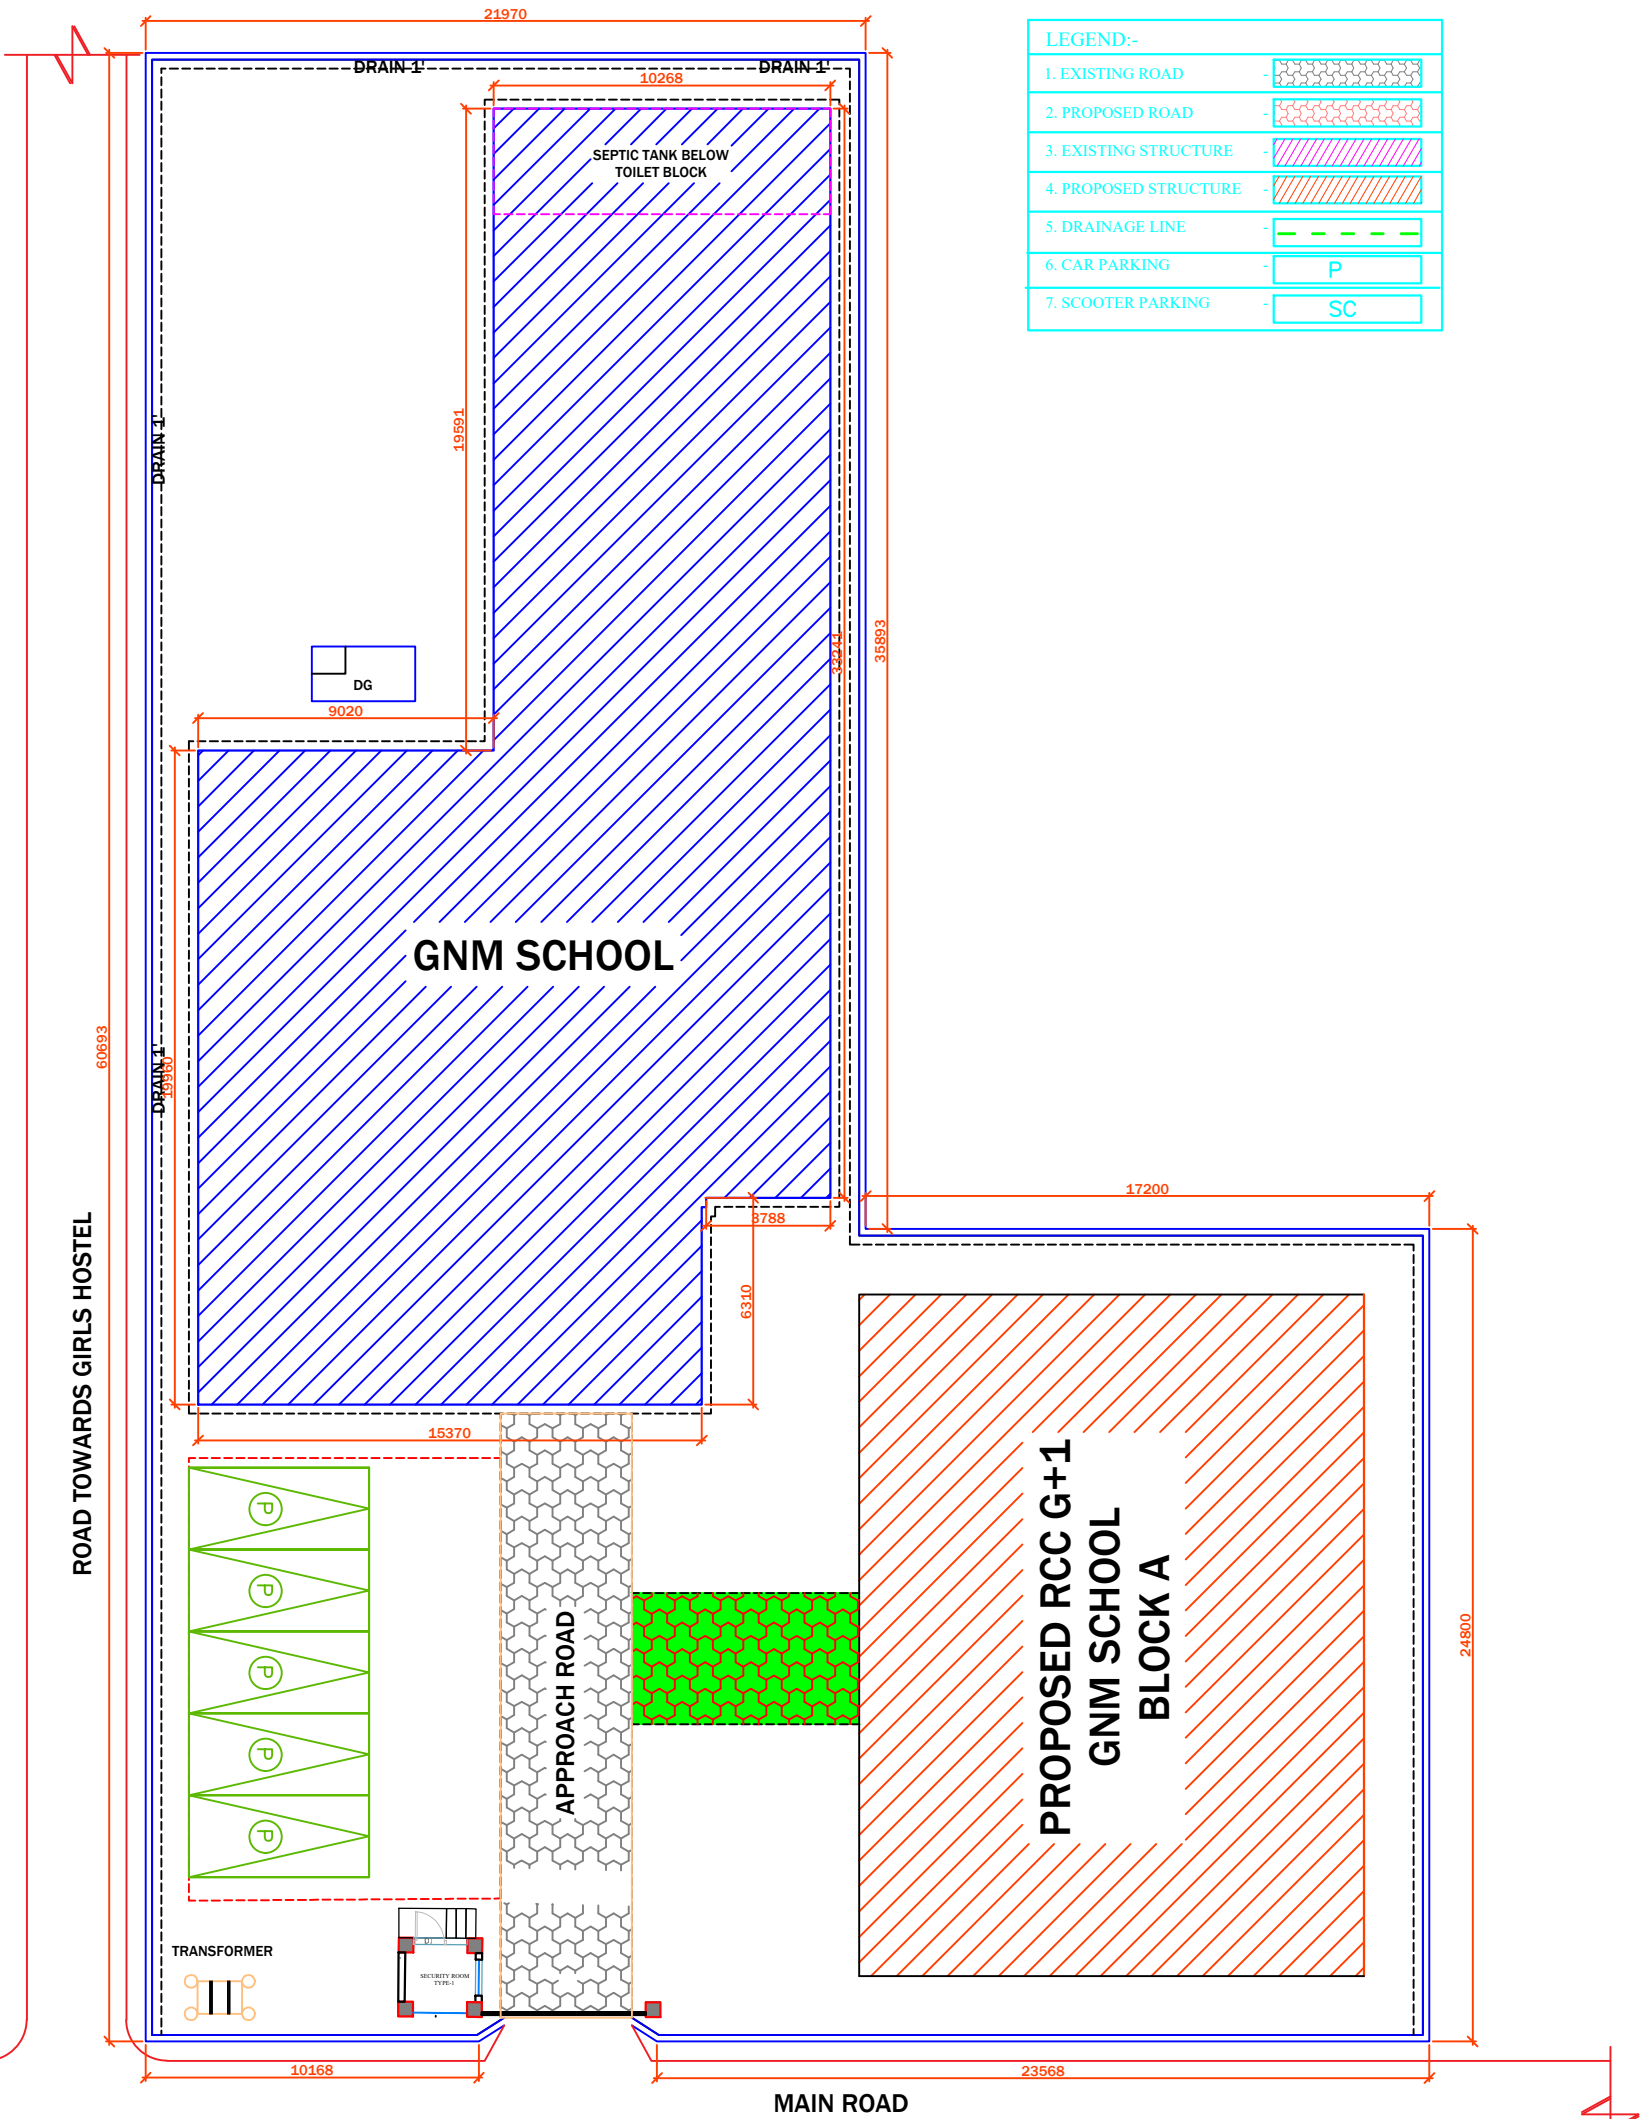

PROJECT:-
ASSAM STATE SECONDARY HEALTHCARE
INITIATIVE FOR SERVICE DELIVERY
TRANSFORMATION (ASSIST)

CLIENT:-
ASSAM HEALTH INFRASTRUCTURE
DEVELOPMENT & MANAGEMENT SOCIETY
(AHIDMS)

PRINCIPAL CONSULTANT:

PRITHVI GREENS, BLOCK A GROUND FLOOR
PATHARQUARY GUWAHATI-781171, ASSAM
M: +91-9401727143

STAGE:- DPR

DRAWING NO:-
2024/ASSIST-GNM/TEZ/SITE/AC/PROP/01

START DATE	ISSUE DATE	SHEET SIZE
	05-04-2025	A3

PROJECT CODE:- 2024/ASSIST-GNM/TEZ

SCALE:- N.T.S.


DRAWING TITLE:-
PROPOSED SITE PLAN ACADEMIC
BLOCK, GNM, TEZPUR, ASSAM.

DOOR SCHEDULE:-

SNO	NAME	WIDTH	HEIGHT	REMARKS
1.	D1	1.80	2.00	DOUBLE PANEL DOOR
2.	D2	1.50	2.00	DOUBLE PANEL DOOR
3.	D3	1.20	2.00	DOUBLE PANEL DOOR
4.	D4	0.85	2.00	SINGLE PANEL DOOR

WINDOW SCHEDULE:-

SNO	NAME	SILL	WIDTH	HEIGHT	REMARKS
1.	W1	0.70	1.20	1.30	DOUBLE PANEL WINDOW
2.	W2	0.70	1.00	1.30	DOUBLE PANEL WINDOW
3.	W3	0.70	0.75	1.30	SINGLE PANEL WINDOW

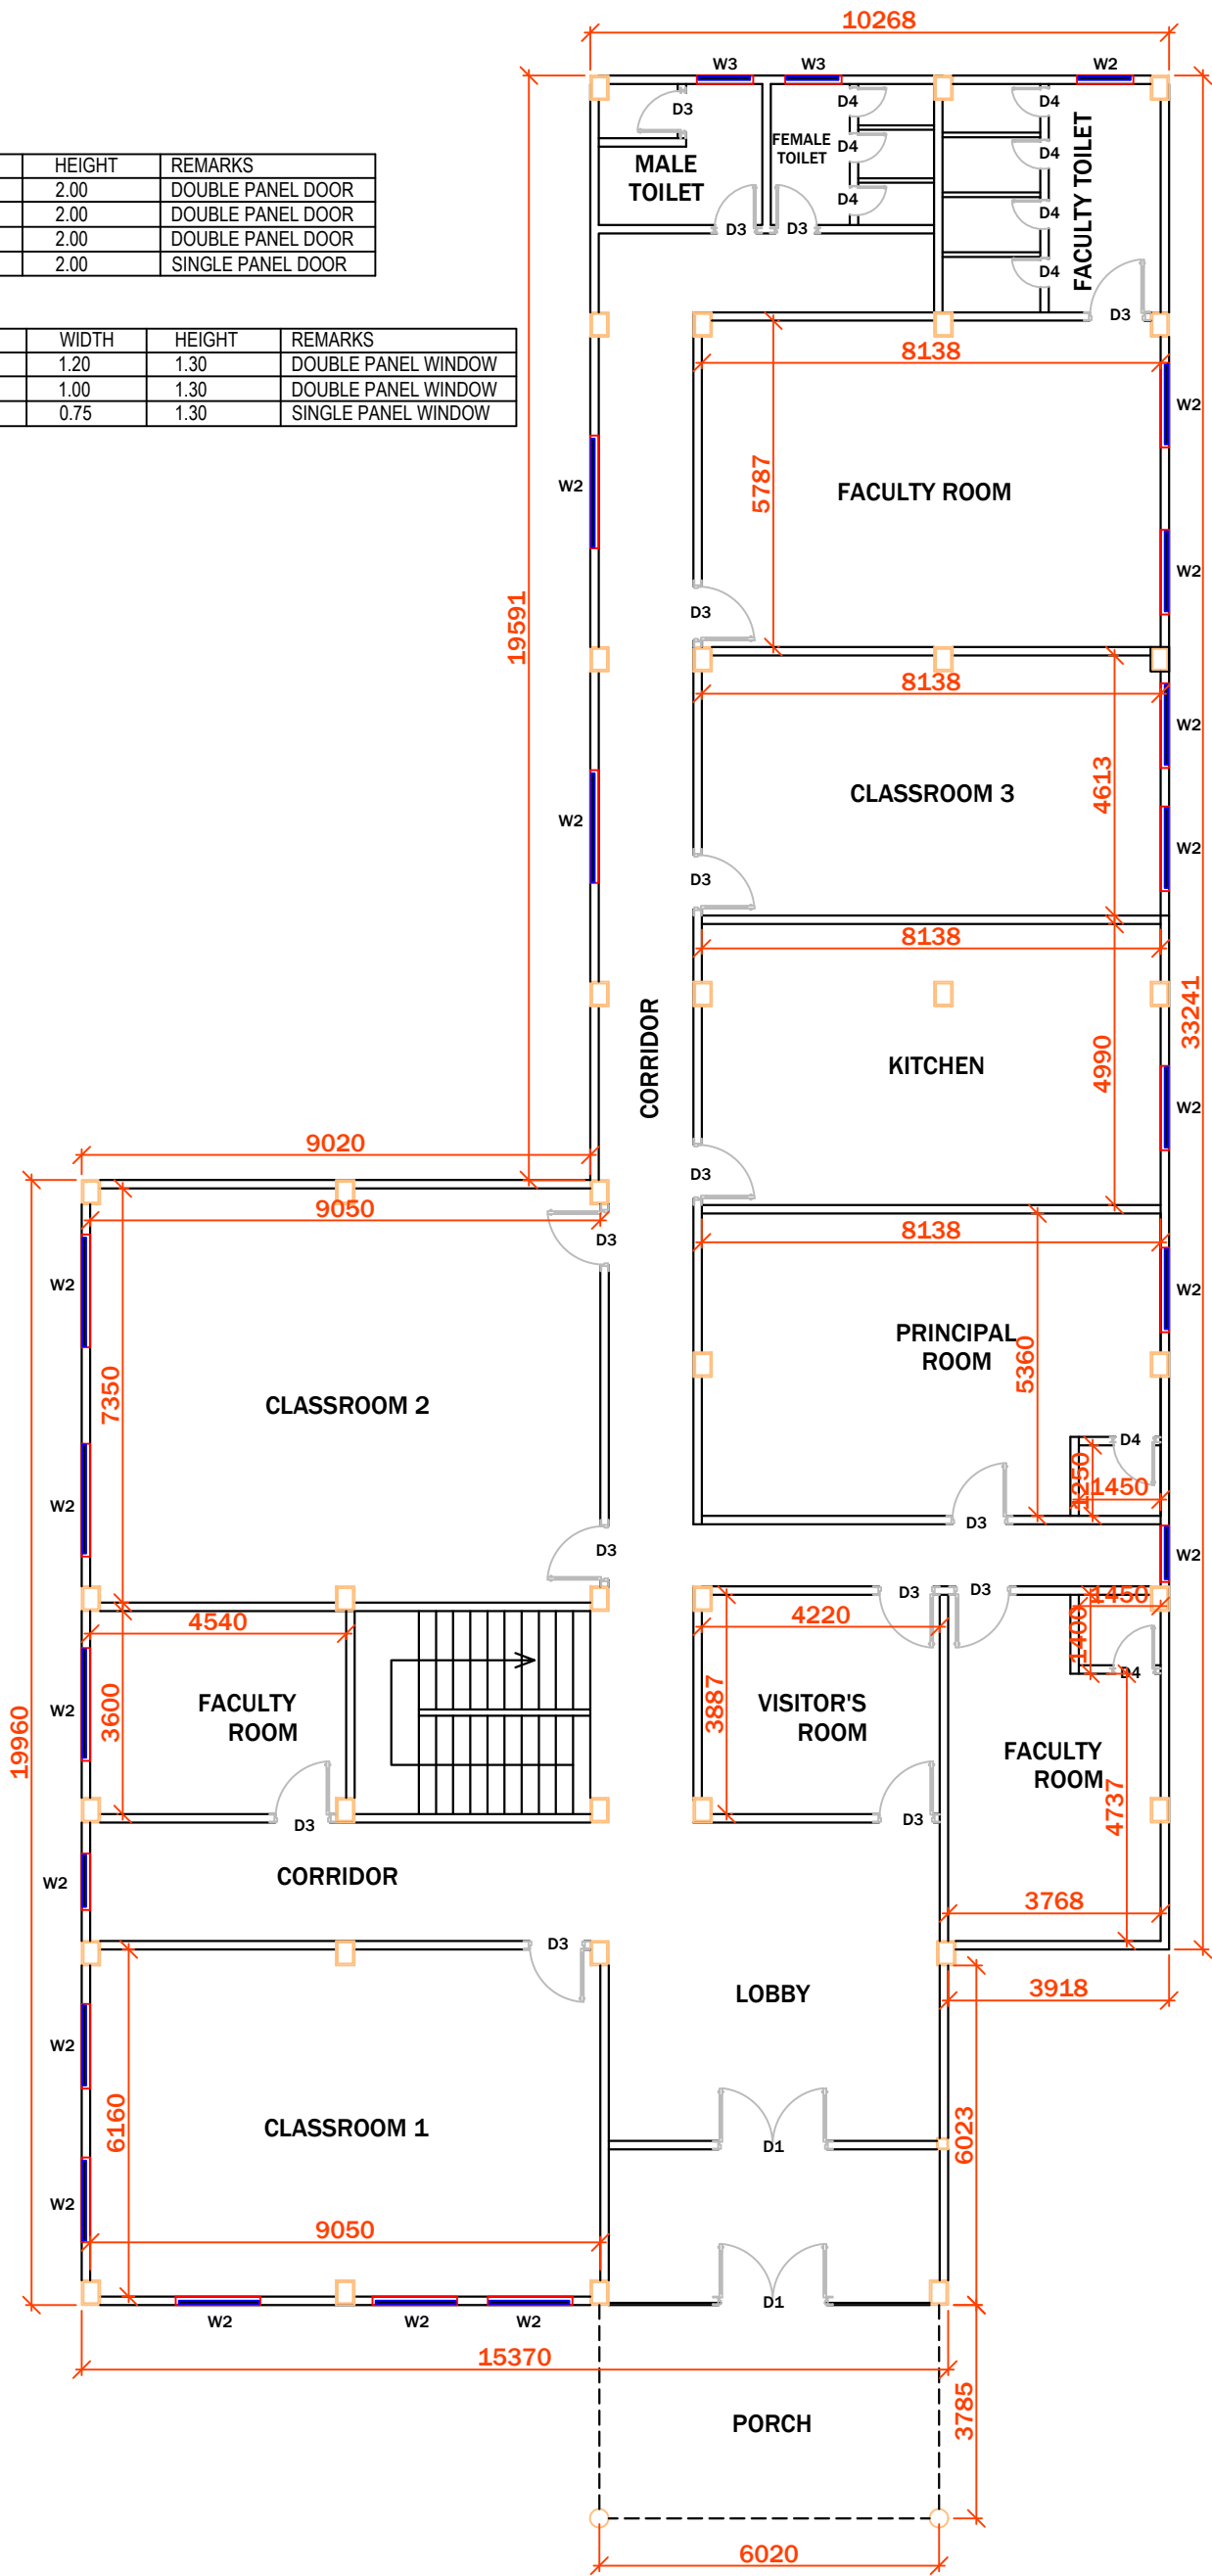

GROUND FLOOR


PROJECT:- ASSAM STATE SECONDARY HEALTHCARE INITIATIVE FOR SERVICE DELIVERY TRANSFORMATION (ASSIST)		
CLIENT:- ASSAM HEALTH INFRASTRUCTURE DEVELOPMENT & MANAGEMENT SOCIETY (AHIDMS)		
PRINCIPAL CONSULTANT: INTEGRA VENTURES HEALTHCARE INFRASTRUCTURE CONSULTANCY solutions projects services PRITHVI GREENS, BLOCK A GROUND FLOOR PATHARQUARY GUWAHATI-781171, ASSAM M: +91-9401727143		
STAGE:-	DPR	
DRAWING NO:- 2024/ASSIST-GNM/TEZ/AR/AC/AS BUILT/01		
START DATE	ISSUE DATE	SHEET SIZE
	05-04-2025	A3
PROJECT CODE:-	2024/ASSIST-GNM/TEZ	
SCALE:-	N.T.S.	
BLOCK:-	ACADEMIC	
FLOOR:-	GROUND FLOOR	
DRAWING TITLE:- AS BUILT GROUND FLOOR PLAN, ACADEMIC BLOCK, GNM, TEZPUR, ASSAM.		

DOOR SCHEDULE:-

SNO	NAME	WIDTH	HEIGHT	REMARKS
1.	D1	1.80	2.00	DOUBLE PANEL DOOR
2.	D2	1.50	2.00	DOUBLE PANEL DOOR
3.	D3	1.20	2.00	DOUBLE PANEL DOOR
4.	D4	0.85	2.00	SINGLE PANEL DOOR

WINDOW SCHEDULE:-

SNO	NAME	SILL	WIDTH	HEIGHT	REMARKS
1.	W1	0.70	1.20	1.30	DOUBLE PANEL WINDOW
2.	W2	0.70	1.00	1.30	DOUBLE PANEL WINDOW
3.	W3	0.70	0.75	1.30	SINGLE PANEL WINDOW

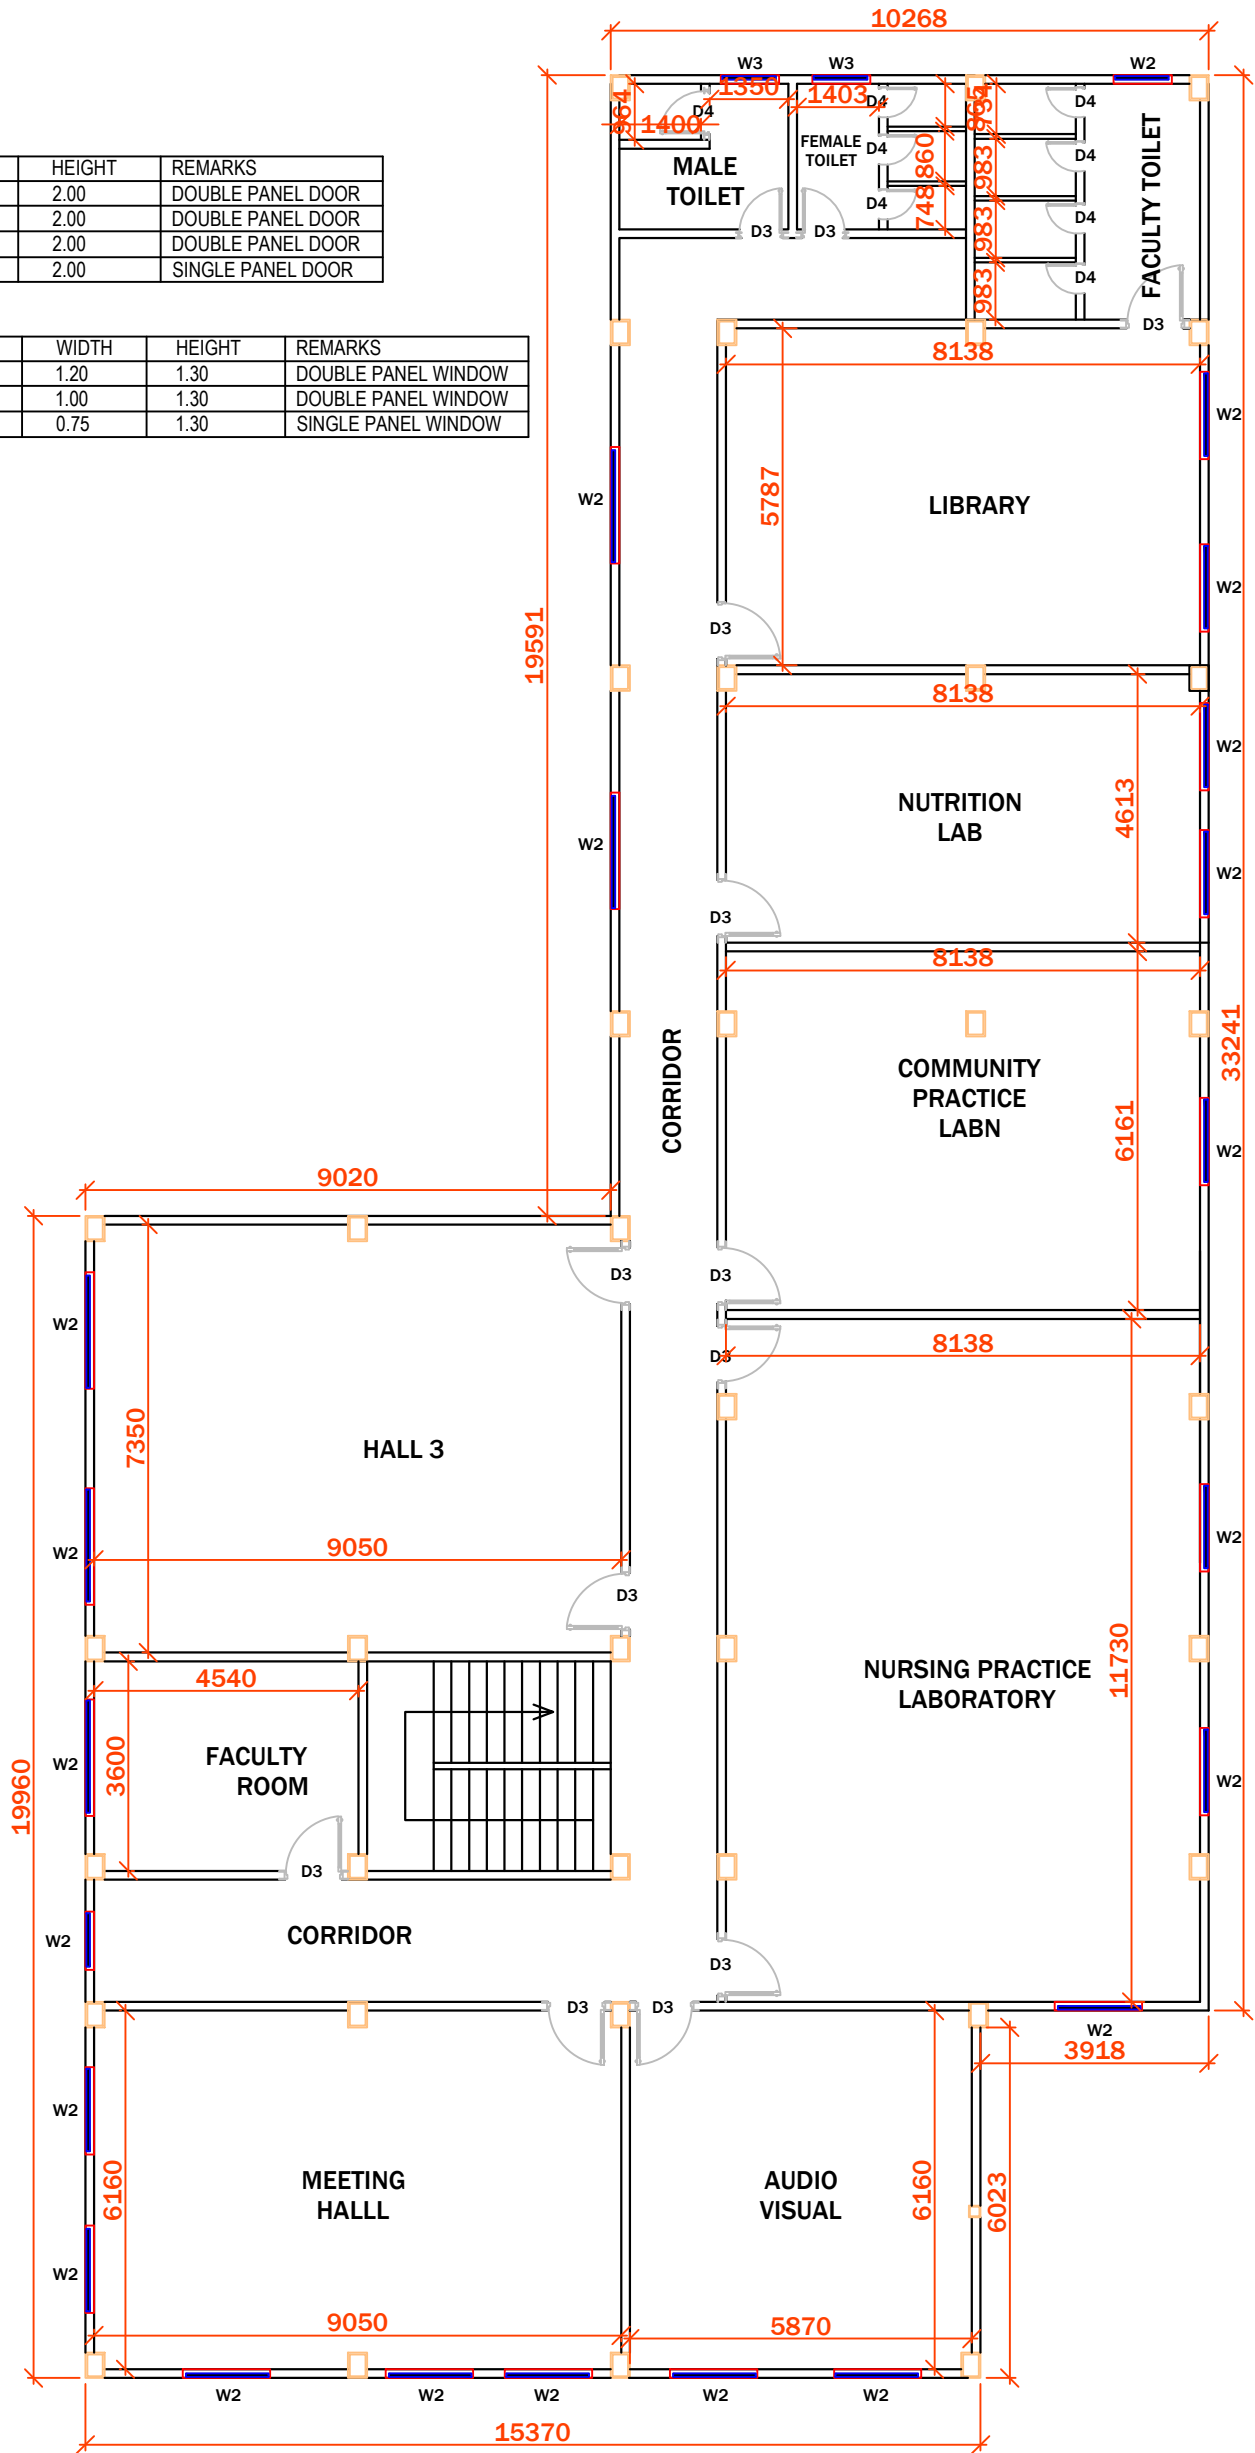

FIRST FLOOR

PROJECT:-
ASSAM STATE SECONDARY HEALTHCARE
INITIATIVE FOR SERVICE DELIVERY
TRANSFORMATION (ASSIST)

CLIENT:-
ASSAM HEALTH INFRASTRUCTURE
DEVELOPMENT & MANAGEMENT SOCIETY
(AHIDMS)

PRINCIPAL CONSULTANT:



INTEGRA VENTURES
HEALTHCARE | INFRASTRUCTURE | CONSULTANCY
solutions projects services

PRITHVI GREENS, BLOCK A GROUND FLOOR
PATHARQUARY GUWAHATI-781171, ASSAM
M: +91-9401727143

STAGE:-	DPR	
DRAWING NO:- 2024/ASSIST-GNM/TEZ/AR/AC/AS BUILT/02		
START DATE	ISSUE DATE	SHEET SIZE
	05-04-2025	A3
PROJECT CODE:-	2024/ASSIST-GNM/TEZ	
SCALE:-	N.T.S.	
BLOCK:-	ACADEMIC	
FLOOR:-	FIRST FLOOR	


DRAWING TITLE:-
AS BUILT FIRST FLOOR PLAN,
ACADEMIC BLOCK, GNM, TEZPUR,
ASSAM.

DOOR SCHEDULE:-

SNO	NAME	WIDTH	HEIGHT	REMARKS
1.	D1	1.80	2.00	DOUBLE PANEL DOOR
2.	D2	1.50	2.00	DOUBLE PANEL DOOR
3.	D3	1.20	2.00	DOUBLE PANEL DOOR
4.	D4	0.85	2.00	SINGLE PANEL DOOR

WINDOW SCHEDULE:-

SNO	NAME	SILL	WIDTH	HEIGHT	REMARKS
1.	W1	0.70	1.20	1.30	DOUBLE PANEL WINDOW
2.	W2	0.70	1.00	1.30	DOUBLE PANEL WINDOW
3.	W3	0.70	0.75	1.30	SINGLE PANEL WINDOW

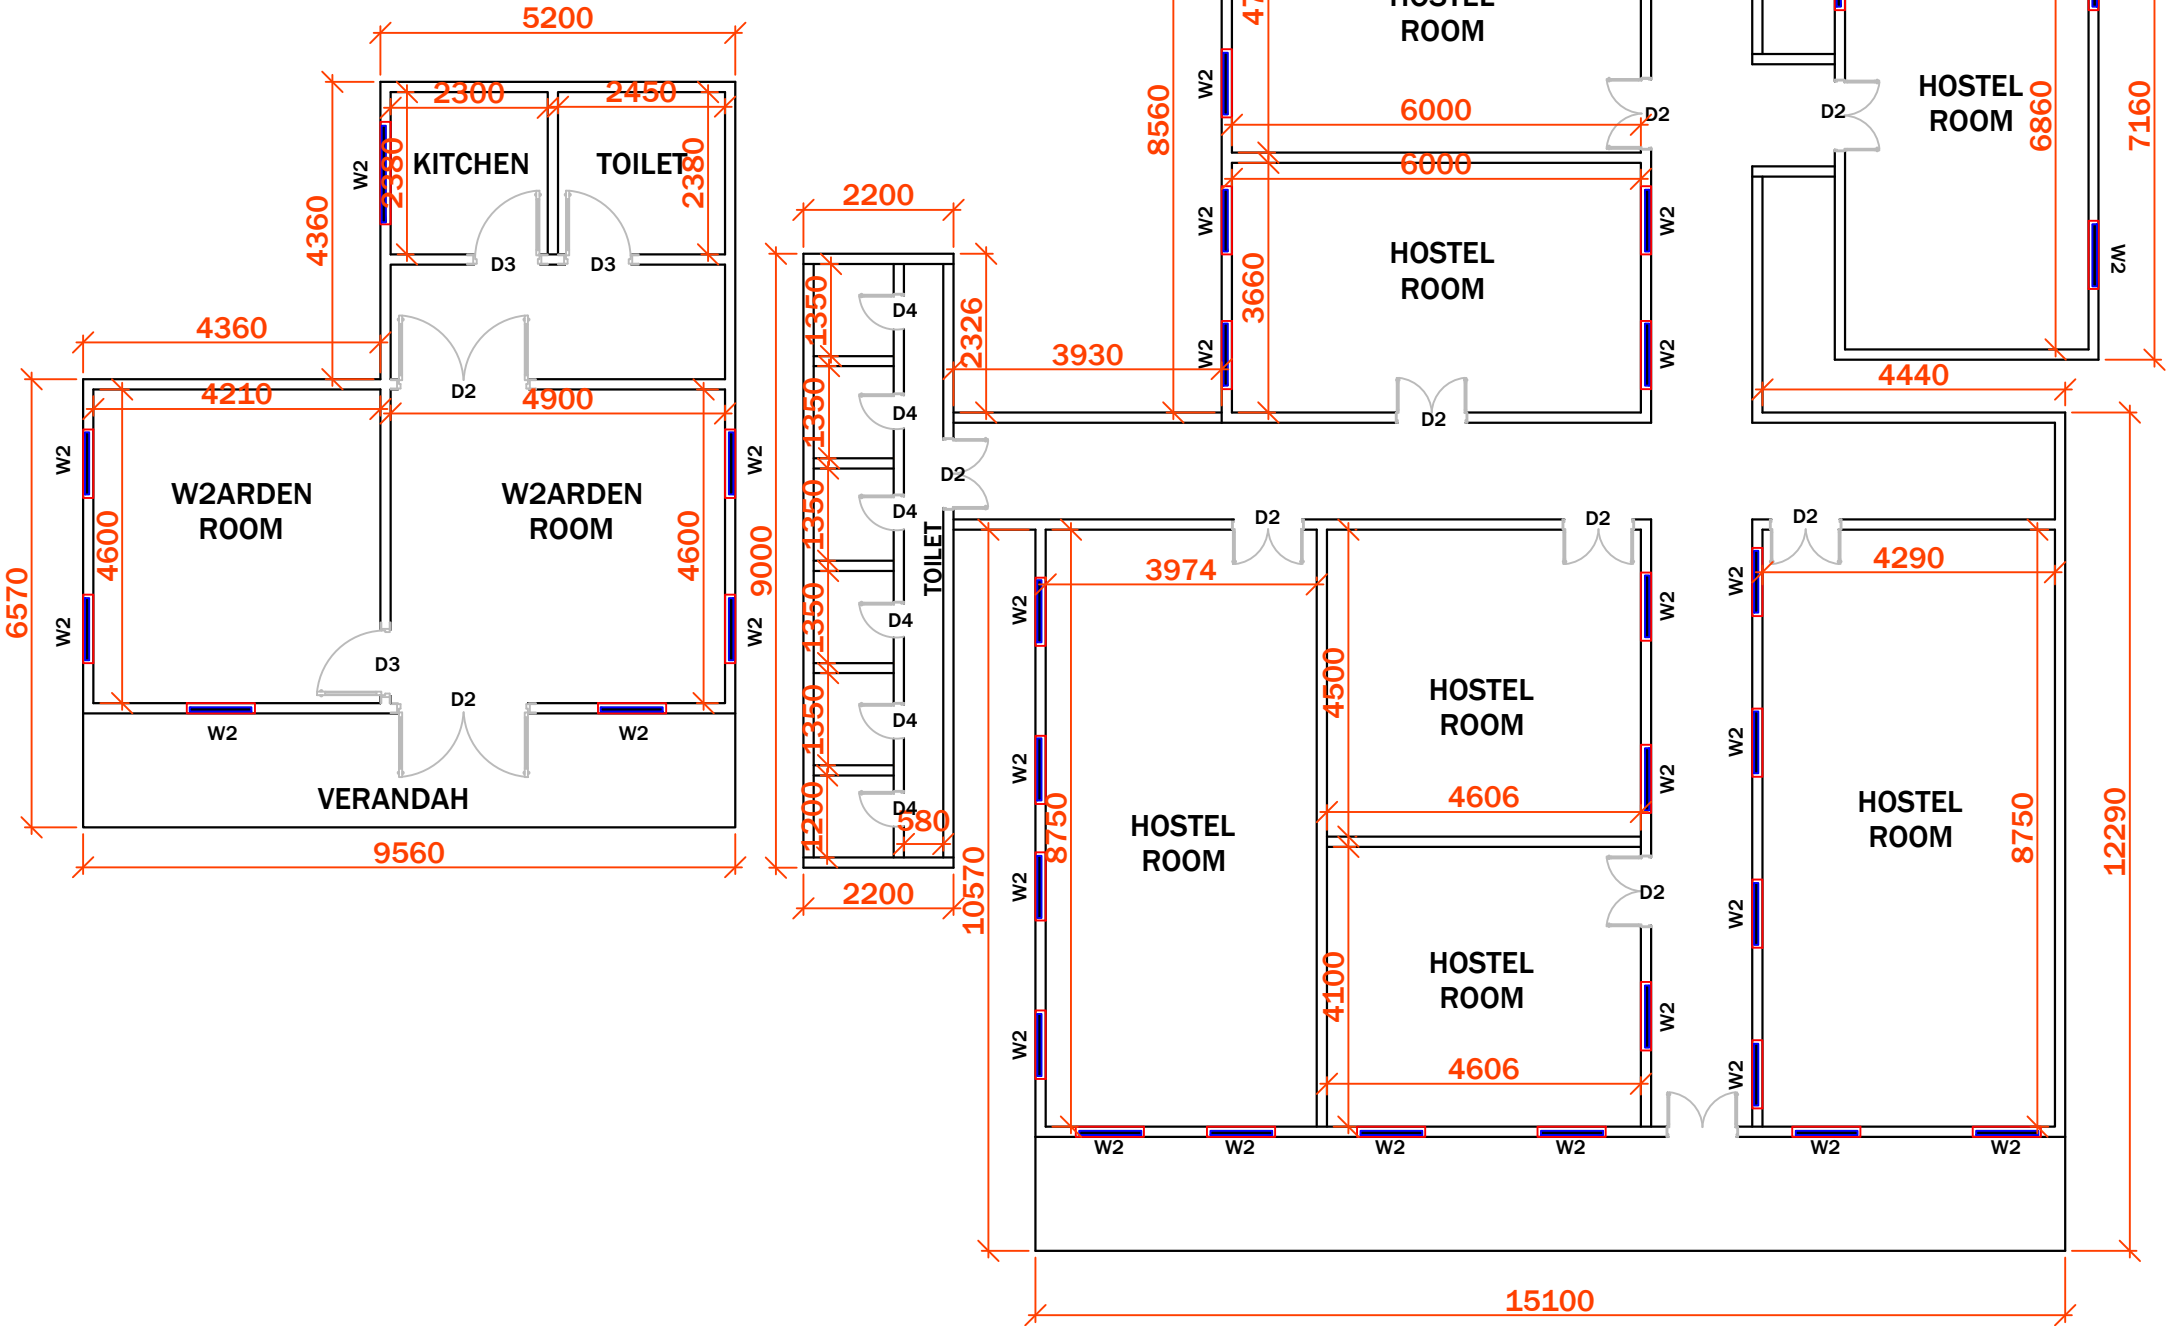

GROUND FLOOR

PROJECT:-
ASSAM STATE SECONDARY HEALTHCARE
INITIATIVE FOR SERVICE DELIVERY
TRANSFORMATION (ASSIST)

CLIENT:-
ASSAM HEALTH INFRASTRUCTURE
DEVELOPMENT & MANAGEMENT SOCIETY
(AHIDMS)

PRINCIPAL CONSULTANT:



PRITHVI GREENS, BLOCK A GROUND FLOOR
PATHARQUARY GUWAHATI-781171, ASSAM
M: +91-9401727143

STAGE:- DPR

DRAWING NO:-
2024/ASSIST-GNM/AR/HS/AS BUILT/01

START DATE	ISSUE DATE	SHEET SIZE
	05-04-2025	A3


PROJECT CODE:- 2024/ASSIST-GNM/TEZ

SCALE:- N.T.S.

BLOCK:- HOSTEL

FLOOR:- GROUND FLOOR

DRAWING TITLE:-
AS BUILT GROUND FLOOR PLAN,
HOSTEL BLOCK, GNM, TEZPUR,
ASSAM.

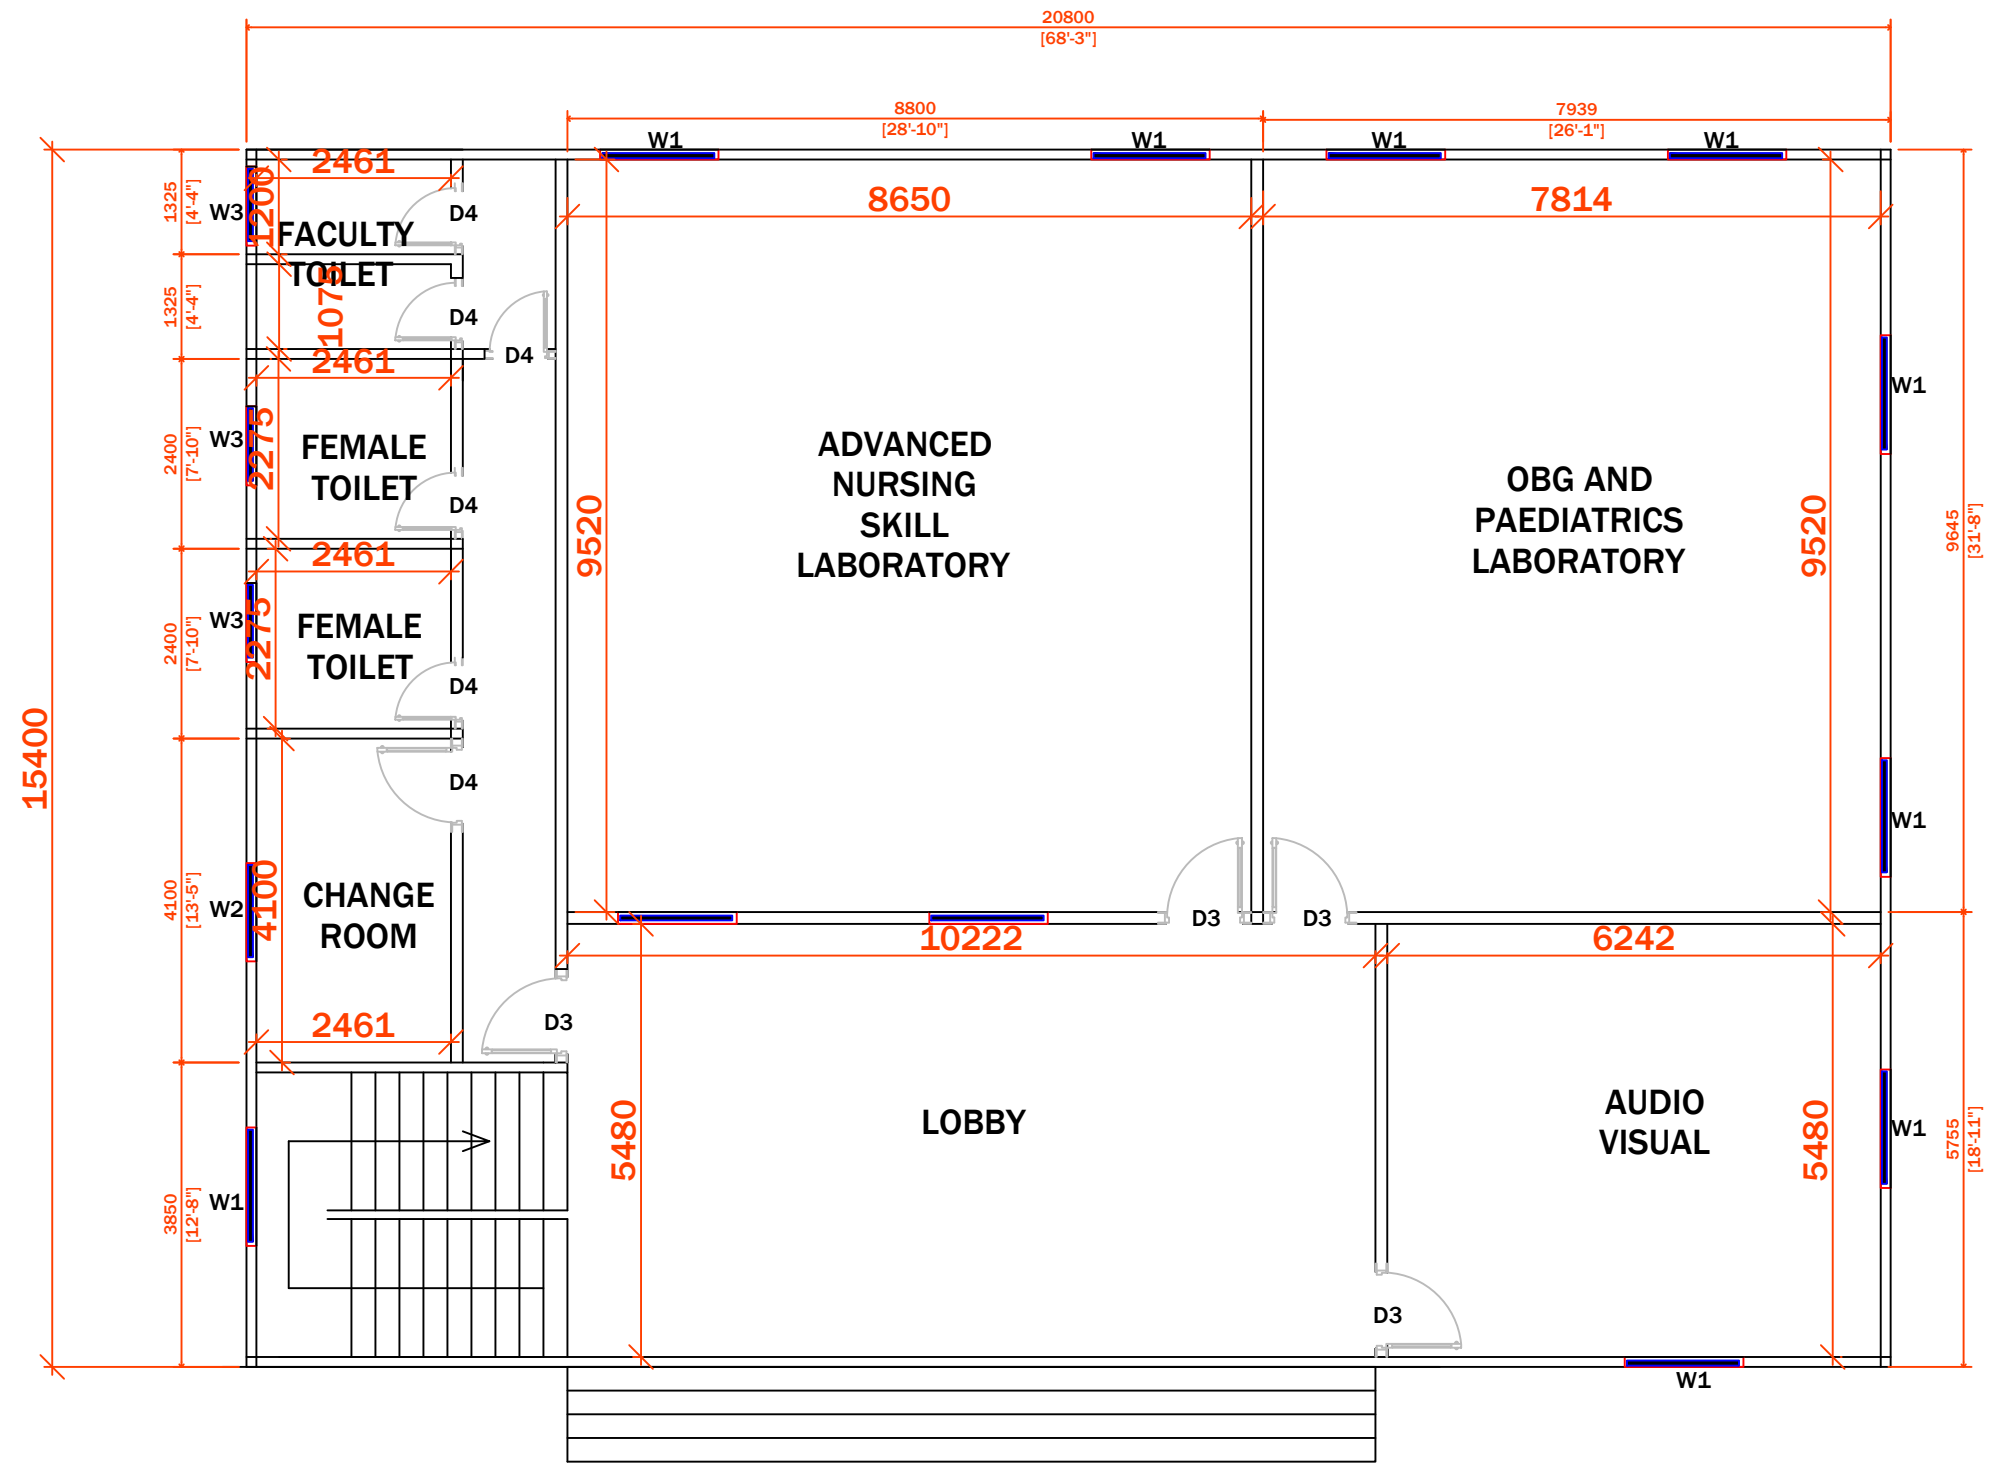

GROUND FLOOR

DOOR SCHEDULE:-

SNO	NAME	WIDTH	HEIGHT	REMARKS
1.	D1	1.80	2.00	DOUBLE PANEL DOOR
2.	D2	1.50	2.00	DOUBLE PANEL DOOR
3.	D3	1.20	2.00	DOUBLE PANEL DOOR
4.	D4	0.85	2.00	SINGLE PANEL DOOR

WINDOW SCHEDULE:-

SNO	NAME	SILL	WIDTH	HEIGHT	REMARKS
1.	W1	0.70	1.20	1.30	DOUBLE PANEL WINDOW
2.	W2	0.70	1.00	1.30	DOUBLE PANEL WINDOW
3.	W3	0.70	0.75	1.30	SINGLE PANEL WINDOW

PROJECT:-
ASSAM STATE SECONDARY HEALTHCARE
INITIATIVE FOR SERVICE DELIVERY
TRANSFORMATION (ASSIST)

CLIENT:-
ASSAM HEALTH INFRASTRUCTURE
DEVELOPMENT & MANAGEMENT SOCIETY
(AHIDMS)

PRINCIPAL CONSULTANT:



PRITHVI GREENS, BLOCK A GROUND FLOOR
PATHARQUARY GUWAHATI-781171, ASSAM
M: +91-9401727143

STAGE:- DPR

DRAWING NO:-
2024/ASSIST-GNM/TEZ/AR/AC/A/PROP/01

START DATE	ISSUE DATE	SHEET SIZE
	05-04-2025	A3


PROJECT CODE:- 2024/ASSIST-GNM/TEZ

SCALE:- N.T.S.

BLOCK:- A (ACADEMIC)

FLOOR:- GROUND FLOOR

DRAWING TITLE:-
PROPOSED GROUND FLOOR PLAN,
BLOCK A, ACADEMIC, GNM,
TEZPUR, ASSAM.

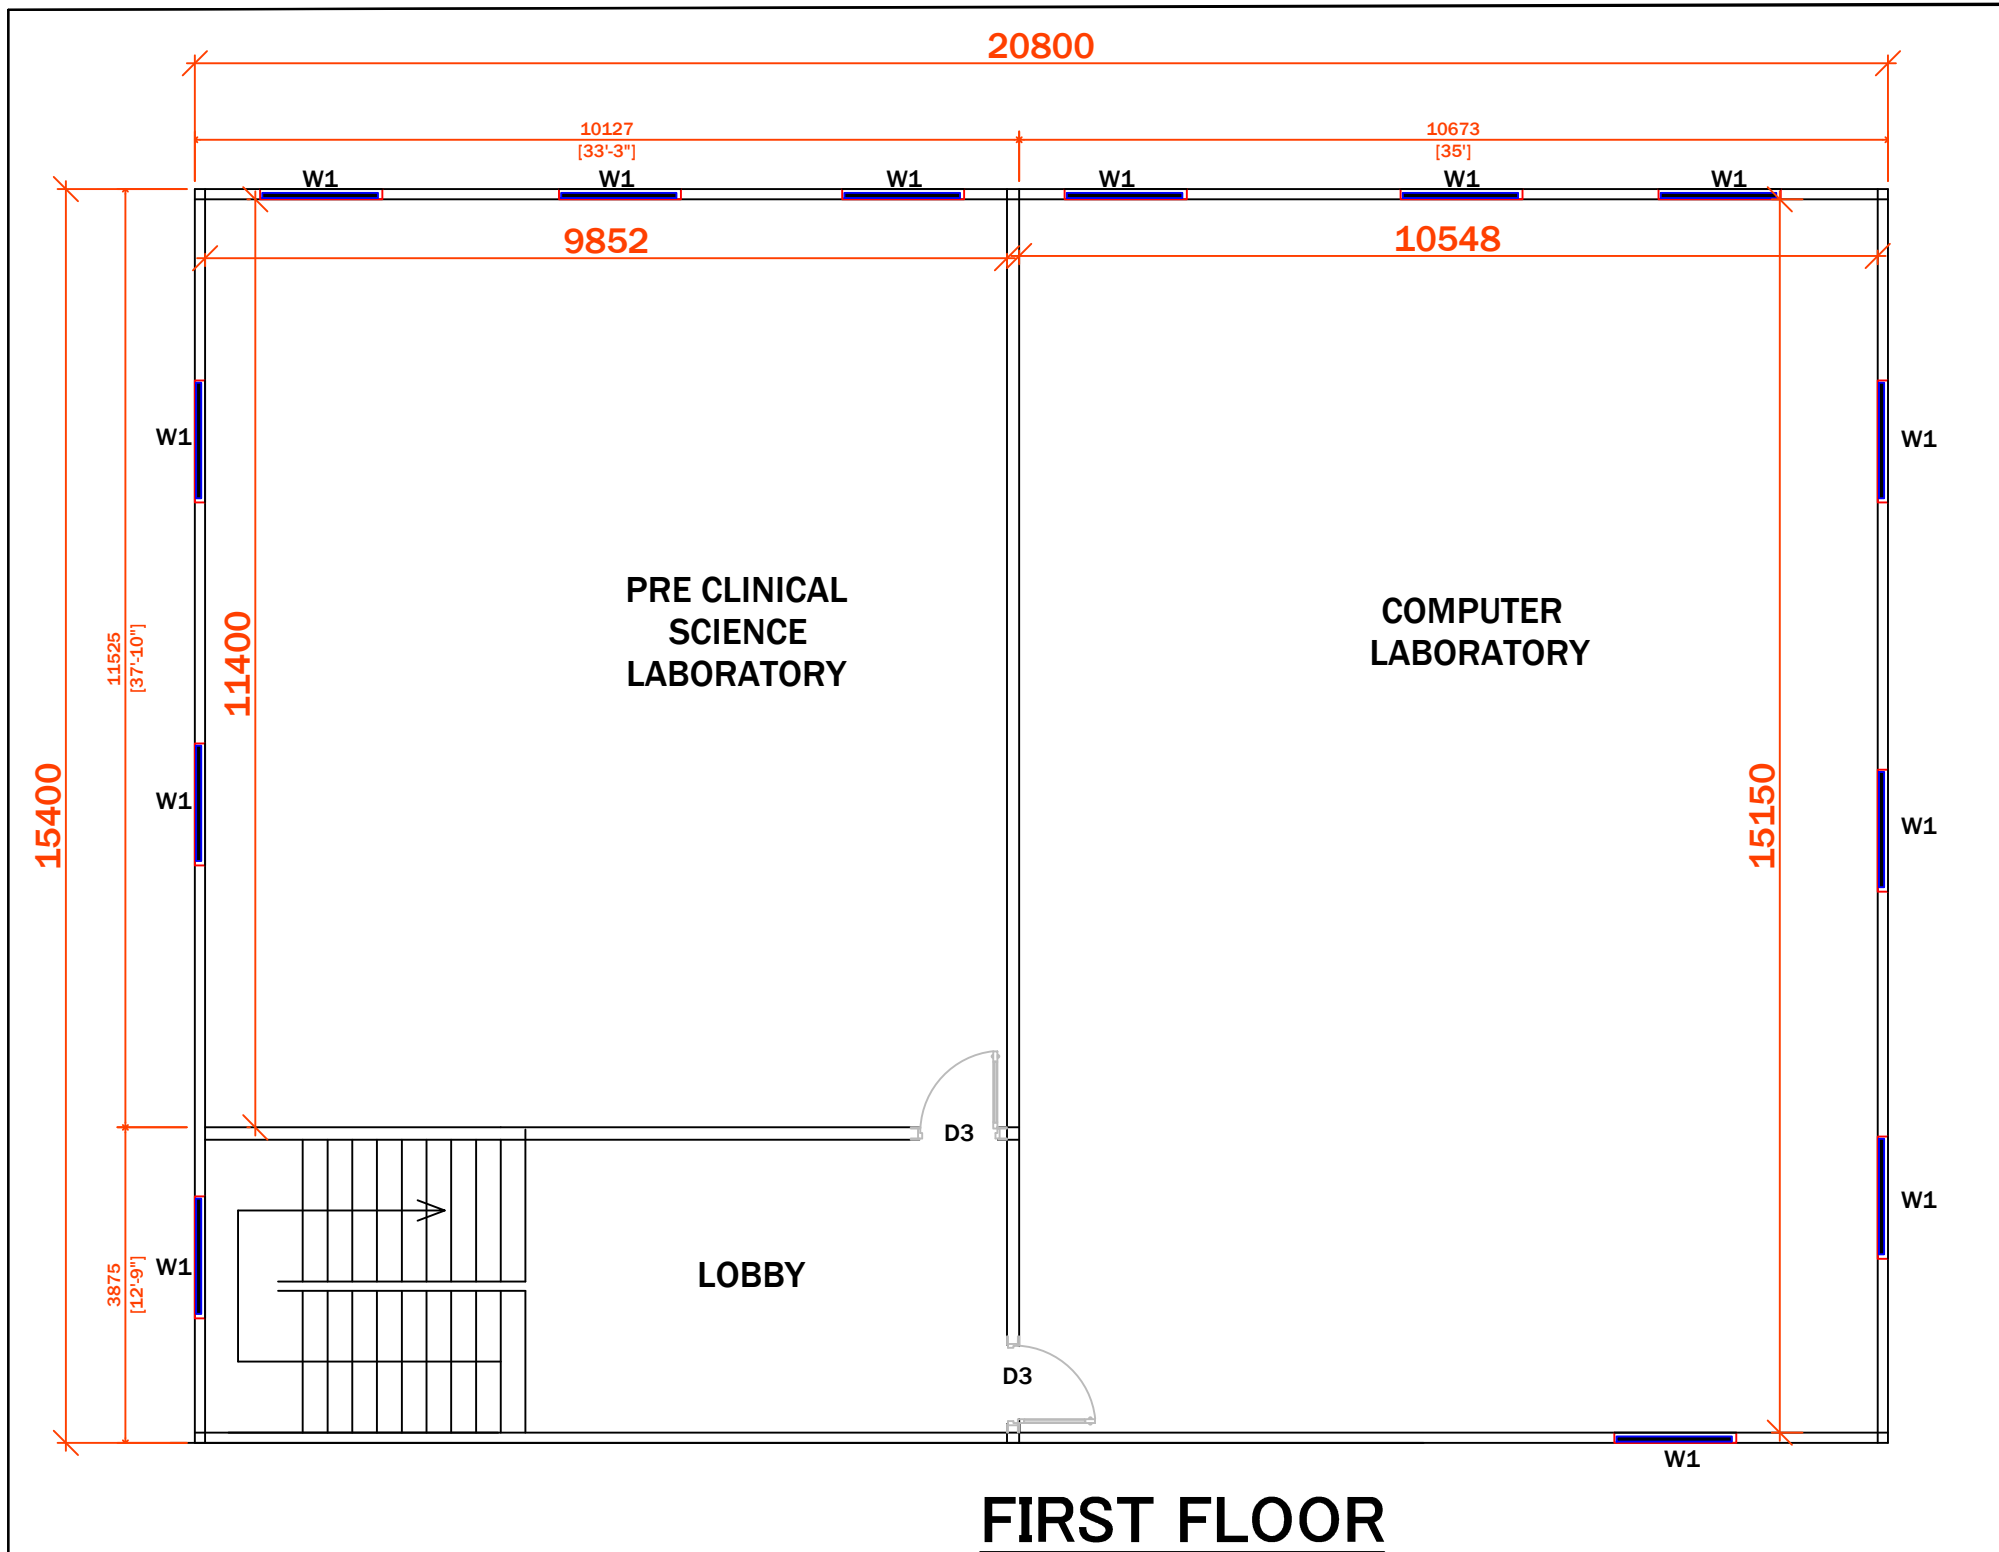

DOOR SCHEDULE:-

SNO	NAME	WIDTH	HEIGHT	REMARKS
1.	D1	1.80	2.00	DOUBLE PANEL DOOR
2.	D2	1.50	2.00	DOUBLE PANEL DOOR
3.	D3	1.20	2.00	DOUBLE PANEL DOOR
4.	D4	0.85	2.00	SINGLE PANEL DOOR

WINDOW SCHEDULE:-

SNO	NAME	SILL	WIDTH	HEIGHT	REMARKS
1.	W1	0.70	1.20	1.30	DOUBLE PANEL WINDOW
2.	W2	0.70	1.00	1.30	DOUBLE PANEL WINDOW
3.	W3	0.70	0.75	1.30	SINGLE PANEL WINDOW


PROJECT:- ASSAM STATE SECONDARY HEALTHCARE INITIATIVE FOR SERVICE DELIVERY TRANSFORMATION (ASSIST)		
CLIENT:- ASSAM HEALTH INFRASTRUCTURE DEVELOPMENT & MANAGEMENT SOCIETY (AHIDMS)		
PRINCIPAL CONSULTANT: INTEGRA VENTURES HEALTHCARE INFRASTRUCTURE CONSULTANCY solutions projects services PRITHVI GREENS, BLOCK A GROUND FLOOR PATHARQUARY GUWAHATI-781171, ASSAM M: +91-9401727143		
STAGE:-	DPR	
DRAWING NO:- 2024/ASSIST-GNM/TEZ/AR/AC/A/PROP/02		
START DATE	ISSUE DATE	SHEET SIZE
	05-04-2025	A3
PROJECT CODE:-	2024/ASSIST-GNM/TEZ	
SCALE:-	N.T.S.	
BLOCK:-	A (ACADEMIC)	
FLOOR:-	FIRST FLOOR	
DRAWING TITLE:- PROPOSED FIRST FLOOR PLAN, BLOCK A, ACADEMIC, GNM, TEZPUR, ASSAM.		

DOOR SCHEDULE:-

SNO	NAME	WIDTH	HEIGHT	REMARKS
1.	D1	1.80	2.00	DOUBLE PANEL DOOR
2.	D2	1.50	2.00	DOUBLE PANEL DOOR
3.	D3	1.20	2.00	DOUBLE PANEL DOOR
4.	D4	0.85	2.00	SINGLE PANEL DOOR

WINDOW SCHEDULE:-

SNO	NAME	SILL	WIDTH	HEIGHT	REMARKS
1.	W1	0.70	1.20	1.30	DOUBLE PANEL WINDOW
2.	W2	0.70	1.00	1.30	DOUBLE PANEL WINDOW
3.	W3	0.70	0.75	1.30	SINGLE PANEL WINDOW

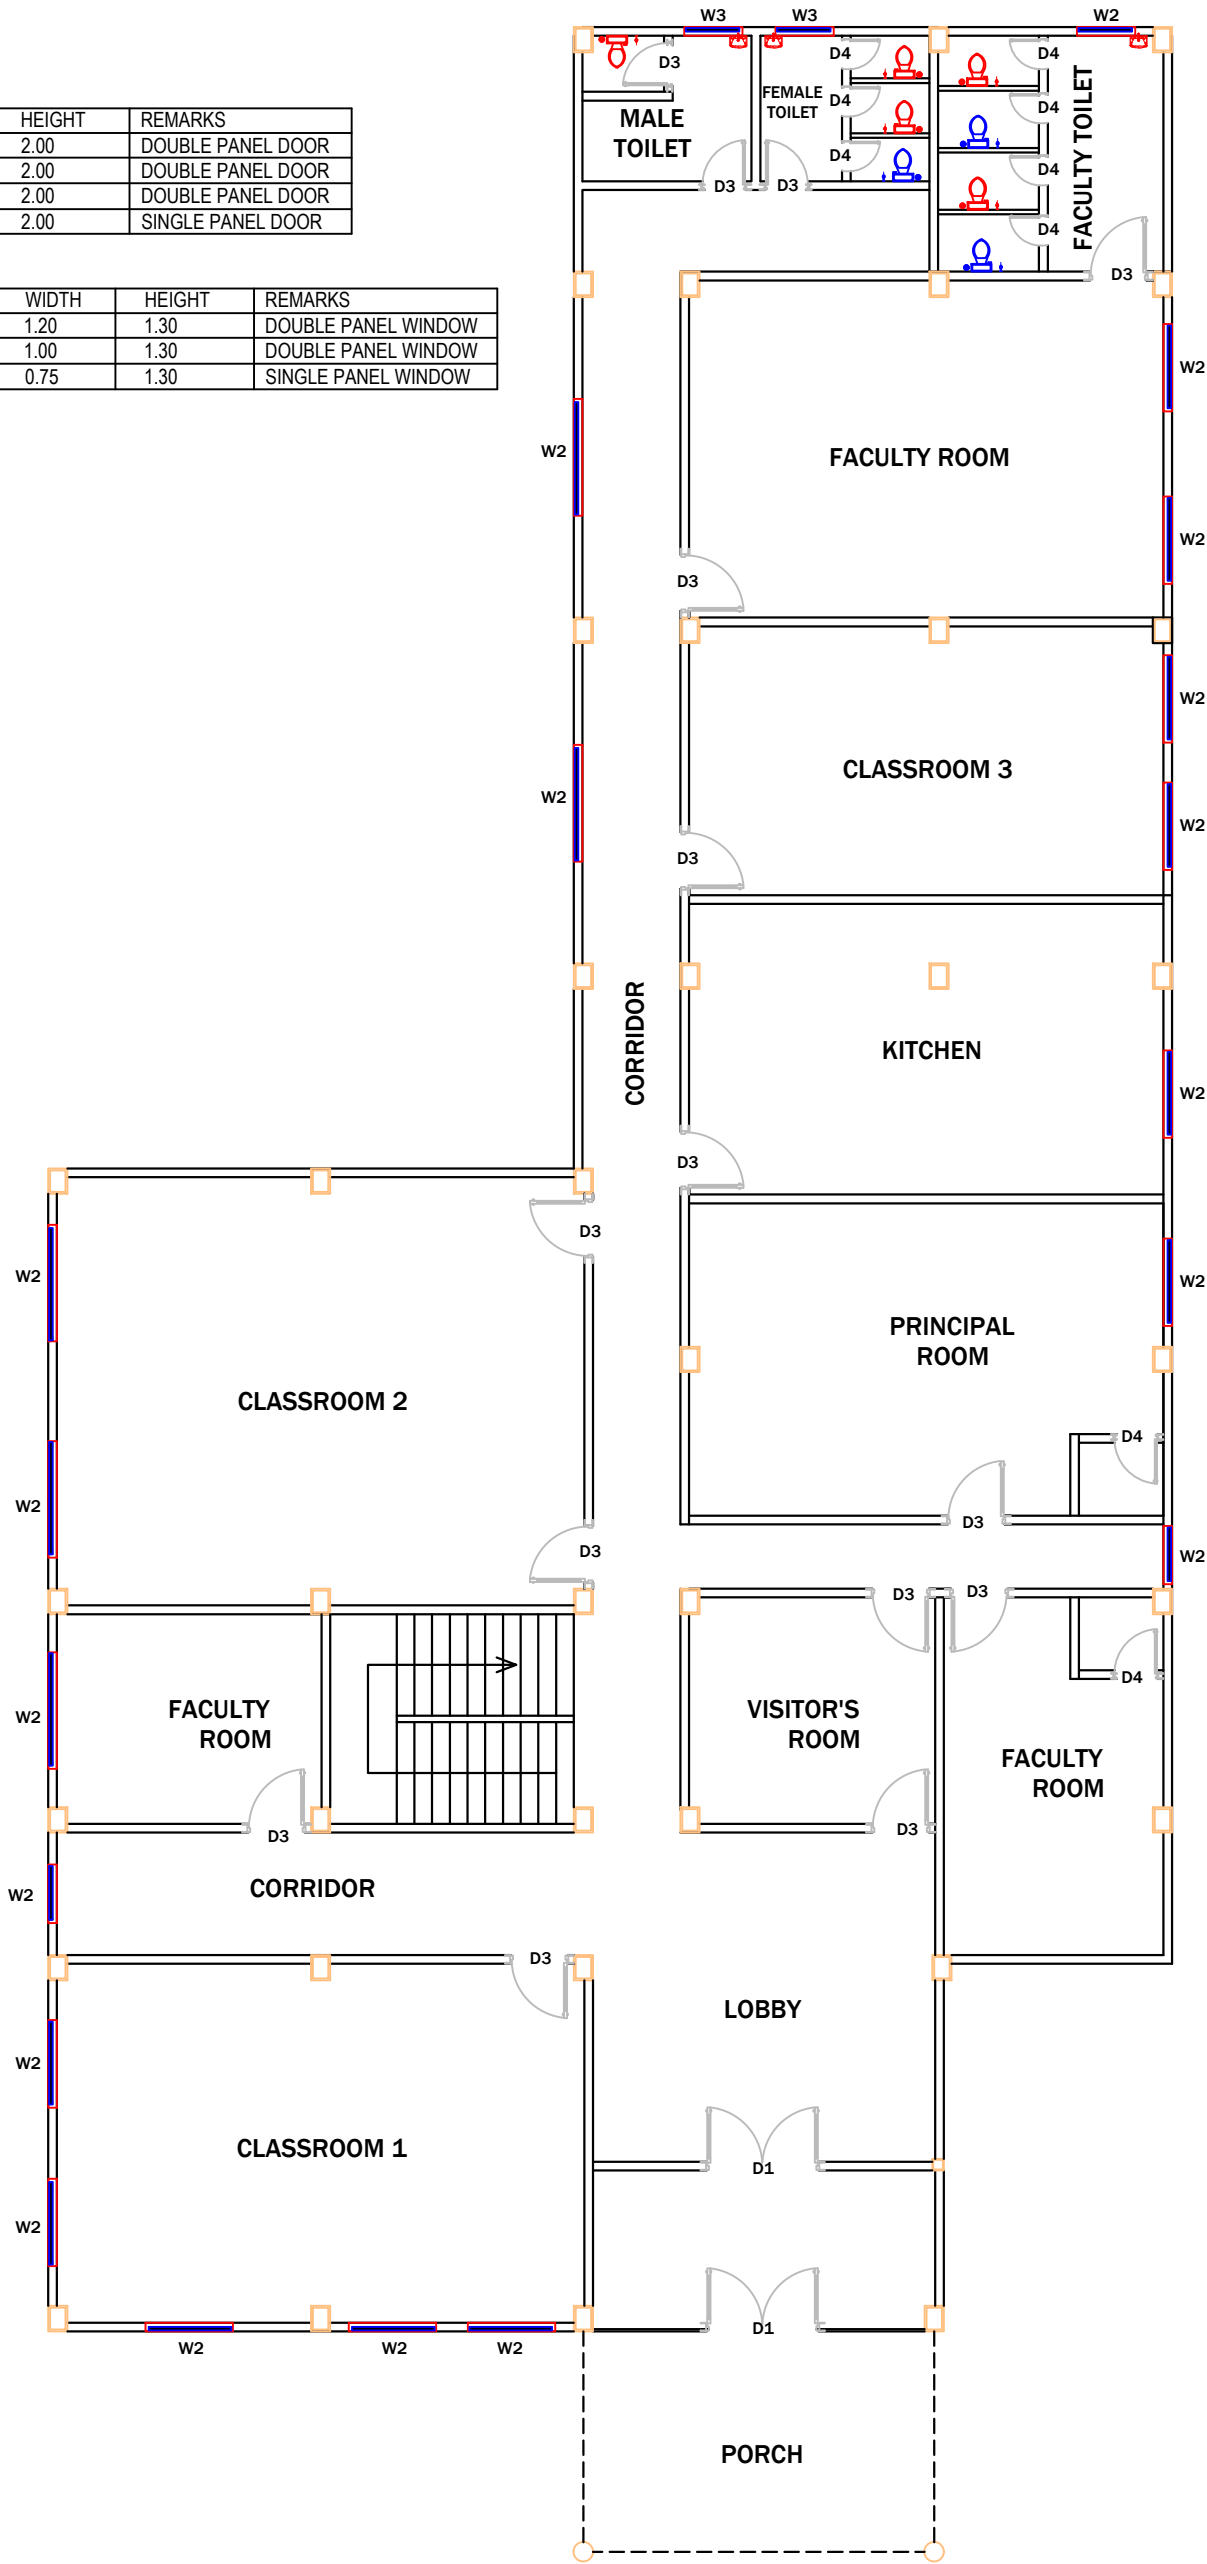

- EXISTING
- PROPOSED

GROUND FLOOR

PROJECT:-

ASSAM STATE SECONDARY HEALTHCARE INITIATIVE FOR SERVICE DELIVERY TRANSFORMATION (ASSIST)

CLIENT:-

ASSAM HEALTH INFRASTRUCTURE DEVELOPMENT & MANAGEMENT SOCIETY (AHIDMS)

PRINCIPAL CONSULTANT:



INTEGRA VENTURES

HEALTHCARE | INFRASTRUCTURE | CONSULTANCY

solutions | projects | services

PRITHVI GREENS, BLOCK A GROUND FLOOR

PATHARQUARY GUWAHATI-781171, ASSAM

M: +91-9401727143

STAGE:-

DPR

DRAWING NO:-

2024/ASSIST-GNM/TEZ/P/AC//PROP/01

START DATE

ISSUE DATE

SHEET SIZE

05-04-2025

A3

PROJECT CODE:-

2024/ASSIST-GNM/TEZ

SCALE:-

N.T.S.

BLOCK:-

ACADEMIC

FLOOR:-

GROUND FLOOR

DRAWING TITLE:-


PROPOSED PLUMBING LAYOUT, GROUND FLOOR PLAN, ACADEMIC BLOCK, GNM, TEZPUR, ASSAM.

DOOR SCHEDULE:-

SNO	NAME	WIDTH	HEIGHT	REMARKS
1.	D1	1.80	2.00	DOUBLE PANEL DOOR
2.	D2	1.50	2.00	DOUBLE PANEL DOOR
3.	D3	1.20	2.00	DOUBLE PANEL DOOR
4.	D4	0.85	2.00	SINGLE PANEL DOOR

WINDOW SCHEDULE:-

SNO	NAME	SILL	WIDTH	HEIGHT	REMARKS
1.	W1	0.70	1.20	1.30	DOUBLE PANEL WINDOW
2.	W2	0.70	1.00	1.30	DOUBLE PANEL WINDOW
3.	W3	0.70	0.75	1.30	SINGLE PANEL WINDOW

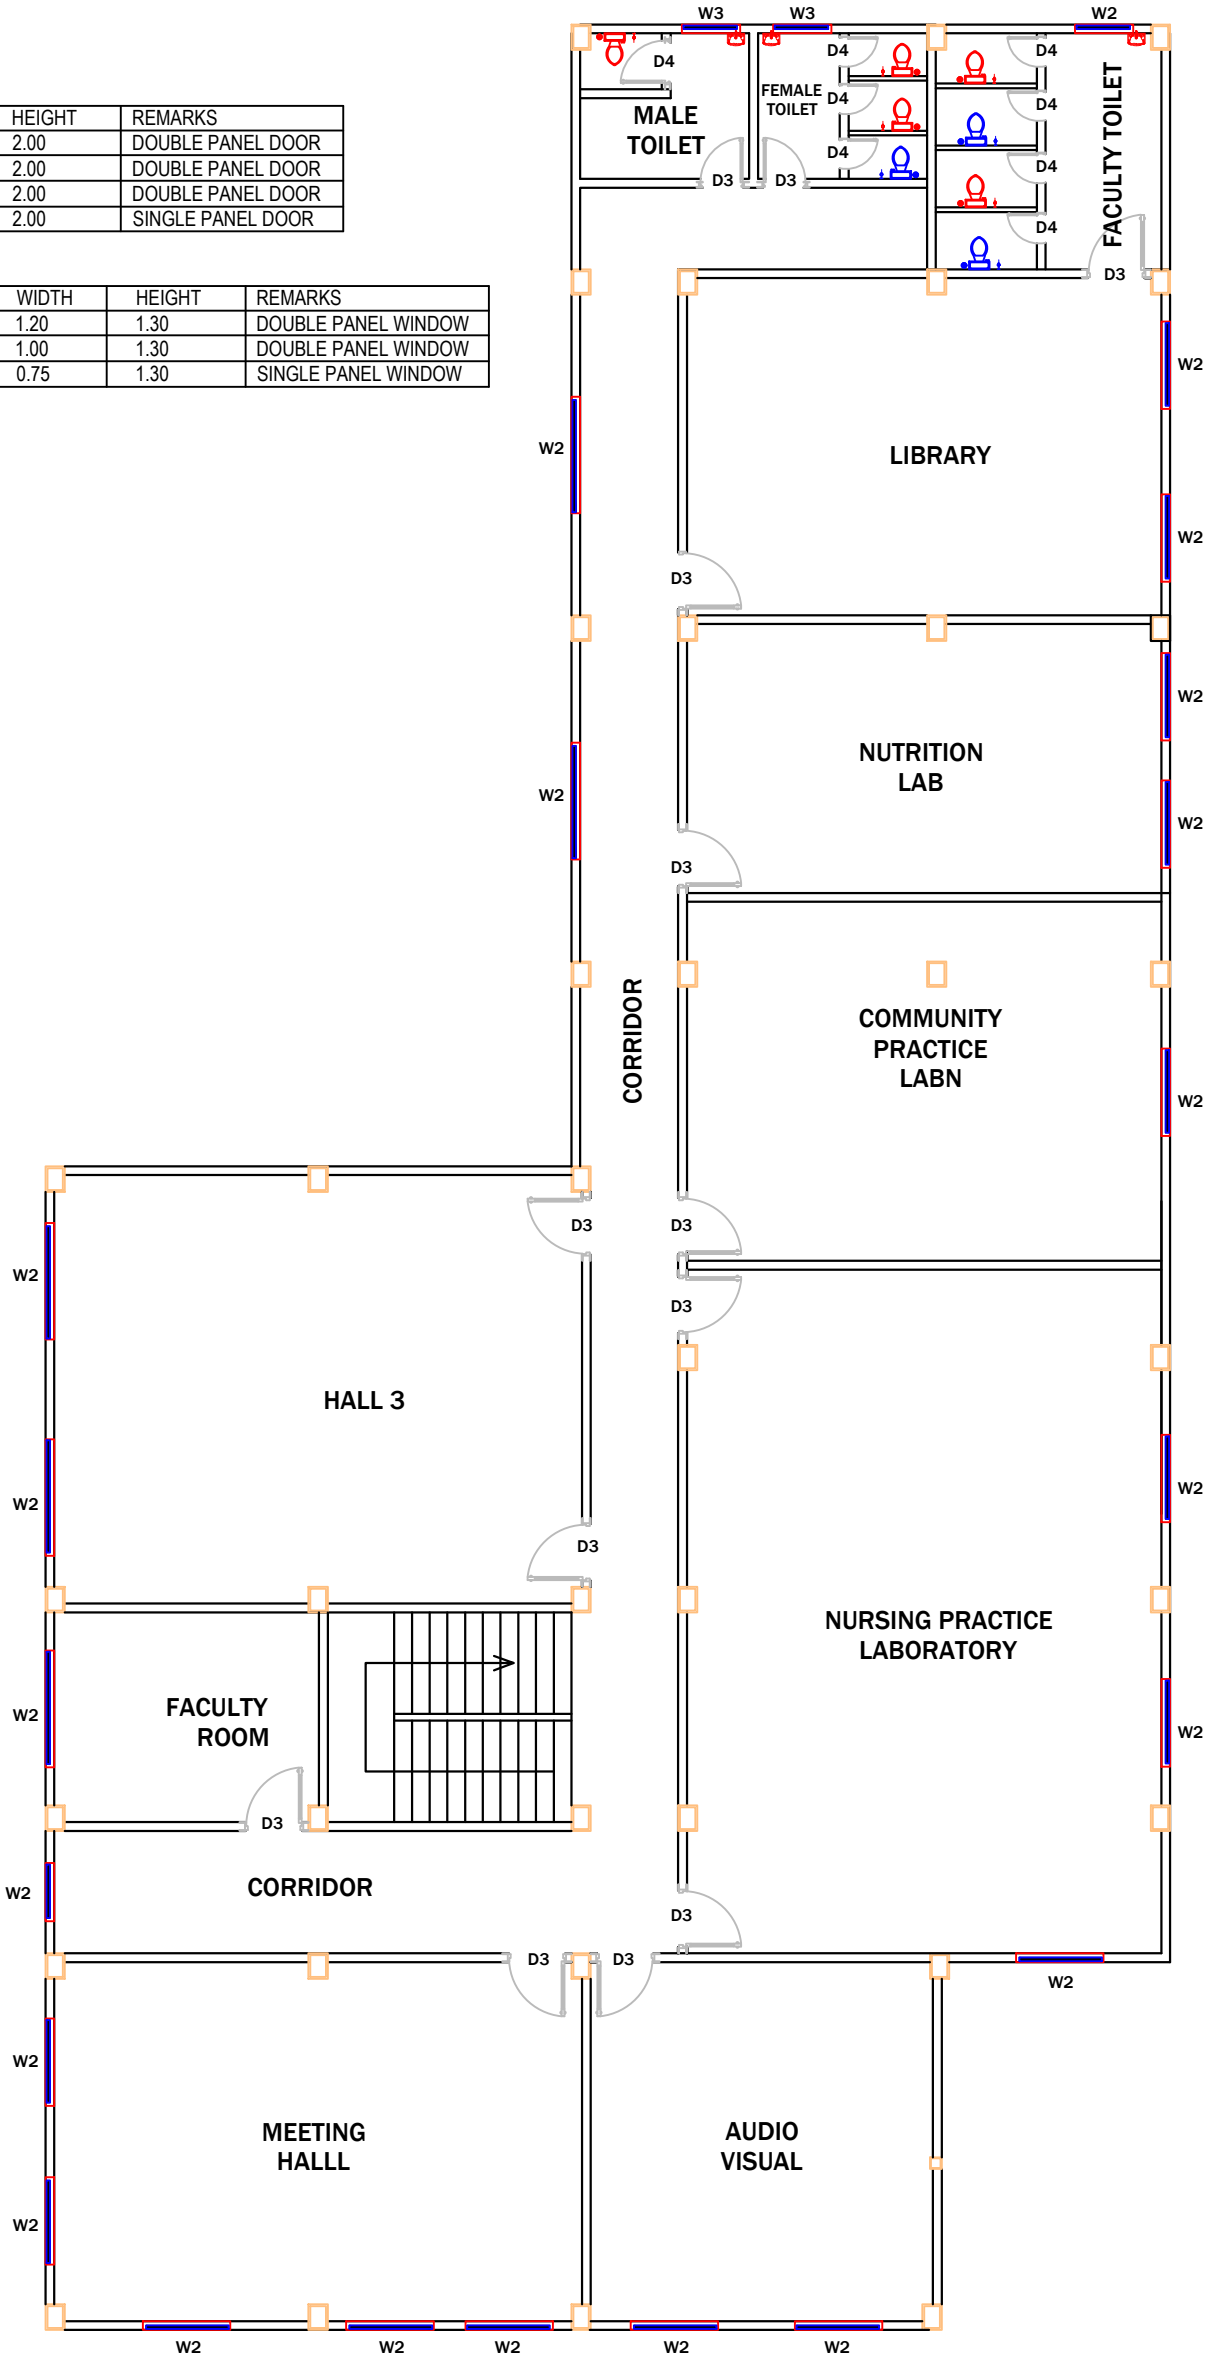

FIRST FLOOR

EXISTING

PROPOSED

PROJECT:-

ASSAM STATE SECONDARY HEALTHCARE INITIATIVE FOR SERVICE DELIVERY TRANSFORMATION (ASSIST)

CLIENT:-

ASSAM HEALTH INFRASTRUCTURE DEVELOPMENT & MANAGEMENT SOCIETY (AHIDMS)

PRINCIPAL CONSULTANT:



PRITHVI GREENS, BLOCK A GROUND FLOOR
PATHARQUARY GUWAHATI-781171, ASSAM
M: +91-9401727143

STAGE:-

DPR

DRAWING NO:-

2024/ASSIST-GNM/TEZ/P/AC/PROP/02

START DATE

ISSUE DATE

SHEET SIZE

05-04-2025

A3

PROJECT CODE:-

2024/ASSIST-GNM/TEZ

SCALE:-

N.T.S.

BLOCK:-

ACADEMIC

FLOOR:-

FIRST FLOOR

DRAWING TITLE:-




PROPOSED PLUMBING LAYOUT, FIRST FLOOR PLAN, ACADEMIC BLOCK, GNM, TEZPUR, ASSAM.

DOOR SCHEDULE:-

SNO	NAME	WIDTH	HEIGHT	REMARKS
1.	D1	1.80	2.00	DOUBLE PANEL DOOR
2.	D2	1.50	2.00	DOUBLE PANEL DOOR
3.	D3	1.20	2.00	DOUBLE PANEL DOOR
4.	D4	0.85	2.00	SINGLE PANEL DOOR

WINDOW SCHEDULE:-

SNO	NAME	SILL	WIDTH	HEIGHT	REMARKS
1.	W1	0.70	1.20	1.30	DOUBLE PANEL WINDOW
2.	W2	0.70	1.00	1.30	DOUBLE PANEL WINDOW
3.	W3	0.70	0.75	1.30	SINGLE PANEL WINDOW

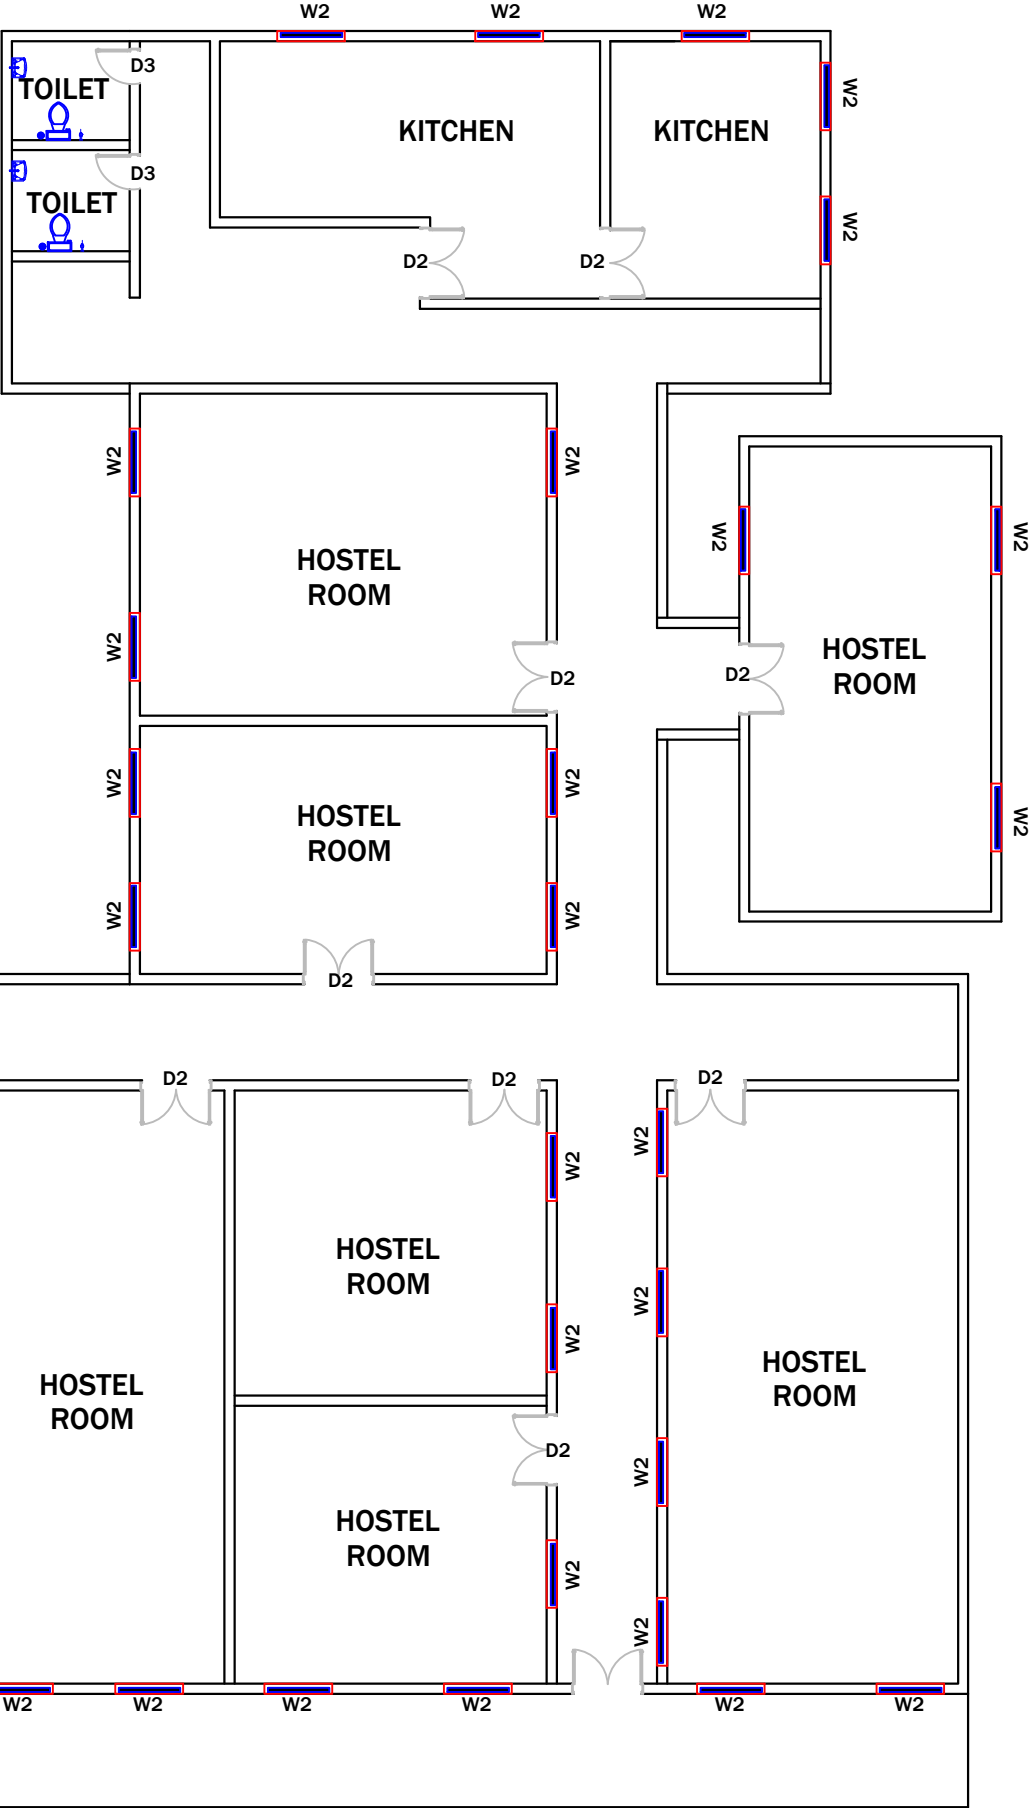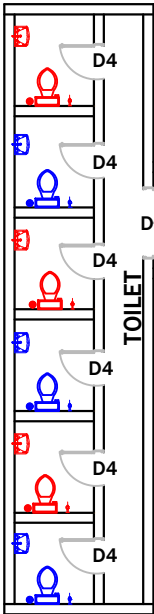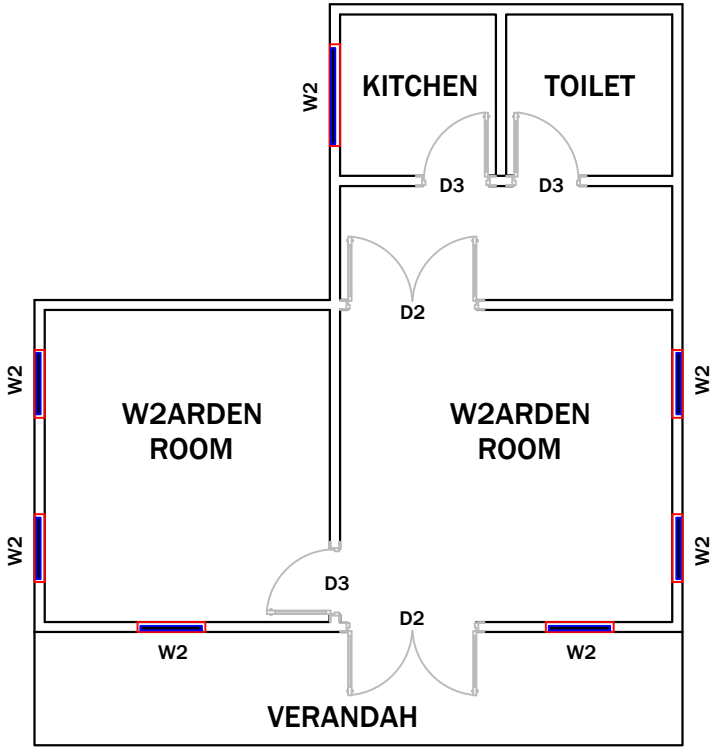

EXISTING

PROPOSED

GROUND FLOOR

PROJECT:-
ASSAM STATE SECONDARY HEALTHCARE
INITIATIVE FOR SERVICE DELIVERY
TRANSFORMATION (ASSIST)

CLIENT:-
ASSAM HEALTH INFRASTRUCTURE
DEVELOPMENT & MANAGEMENT SOCIETY
(AHIDMS)

PRINCIPAL CONSULTANT:



INTEGRA VENTURES
HEALTHCARE | INFRASTRUCTURE | CONSULTANCY
solutions projects services

PRITHVI GREENS, BLOCK A GROUND FLOOR
PATHARQUARY GUWAHATI-781171, ASSAM
M: +91-9401727143

STAGE:- DPR

DRAWING NO:-
2024/ASSIST-GNM/P/HS/PROP/01

START DATE	ISSUE DATE	SHEET SIZE
	05-04-2025	A3

PROJECT CODE:- 2024/ASSIST-GNM/TEZ

SCALE:- N.T.S.

BLOCK:- HOSTEL

FLOOR:- GROUND FLOOR


DRAWING TITLE:-
PROPOSED PLUMBING LAYOUT,
GROUND FLOOR PLAN, HOSTEL
BLOCK, GNM, TEZPUR, ASSAM.

DOOR SCHEDULE:-

SNO	NAME	WIDTH	HEIGHT	REMARKS
1.	D1	1.80	2.00	DOUBLE PANEL DOOR
2.	D2	1.50	2.00	DOUBLE PANEL DOOR
3.	D3	1.20	2.00	DOUBLE PANEL DOOR
4.	D4	0.85	2.00	SINGLE PANEL DOOR

WINDOW SCHEDULE:-

SNO	NAME	SILL	WIDTH	HEIGHT	REMARKS
1.	W1	0.70	1.20	1.30	DOUBLE PANEL WINDOW
2.	W2	0.70	1.00	1.30	DOUBLE PANEL WINDOW
3.	W3	0.70	0.75	1.30	SINGLE PANEL WINDOW

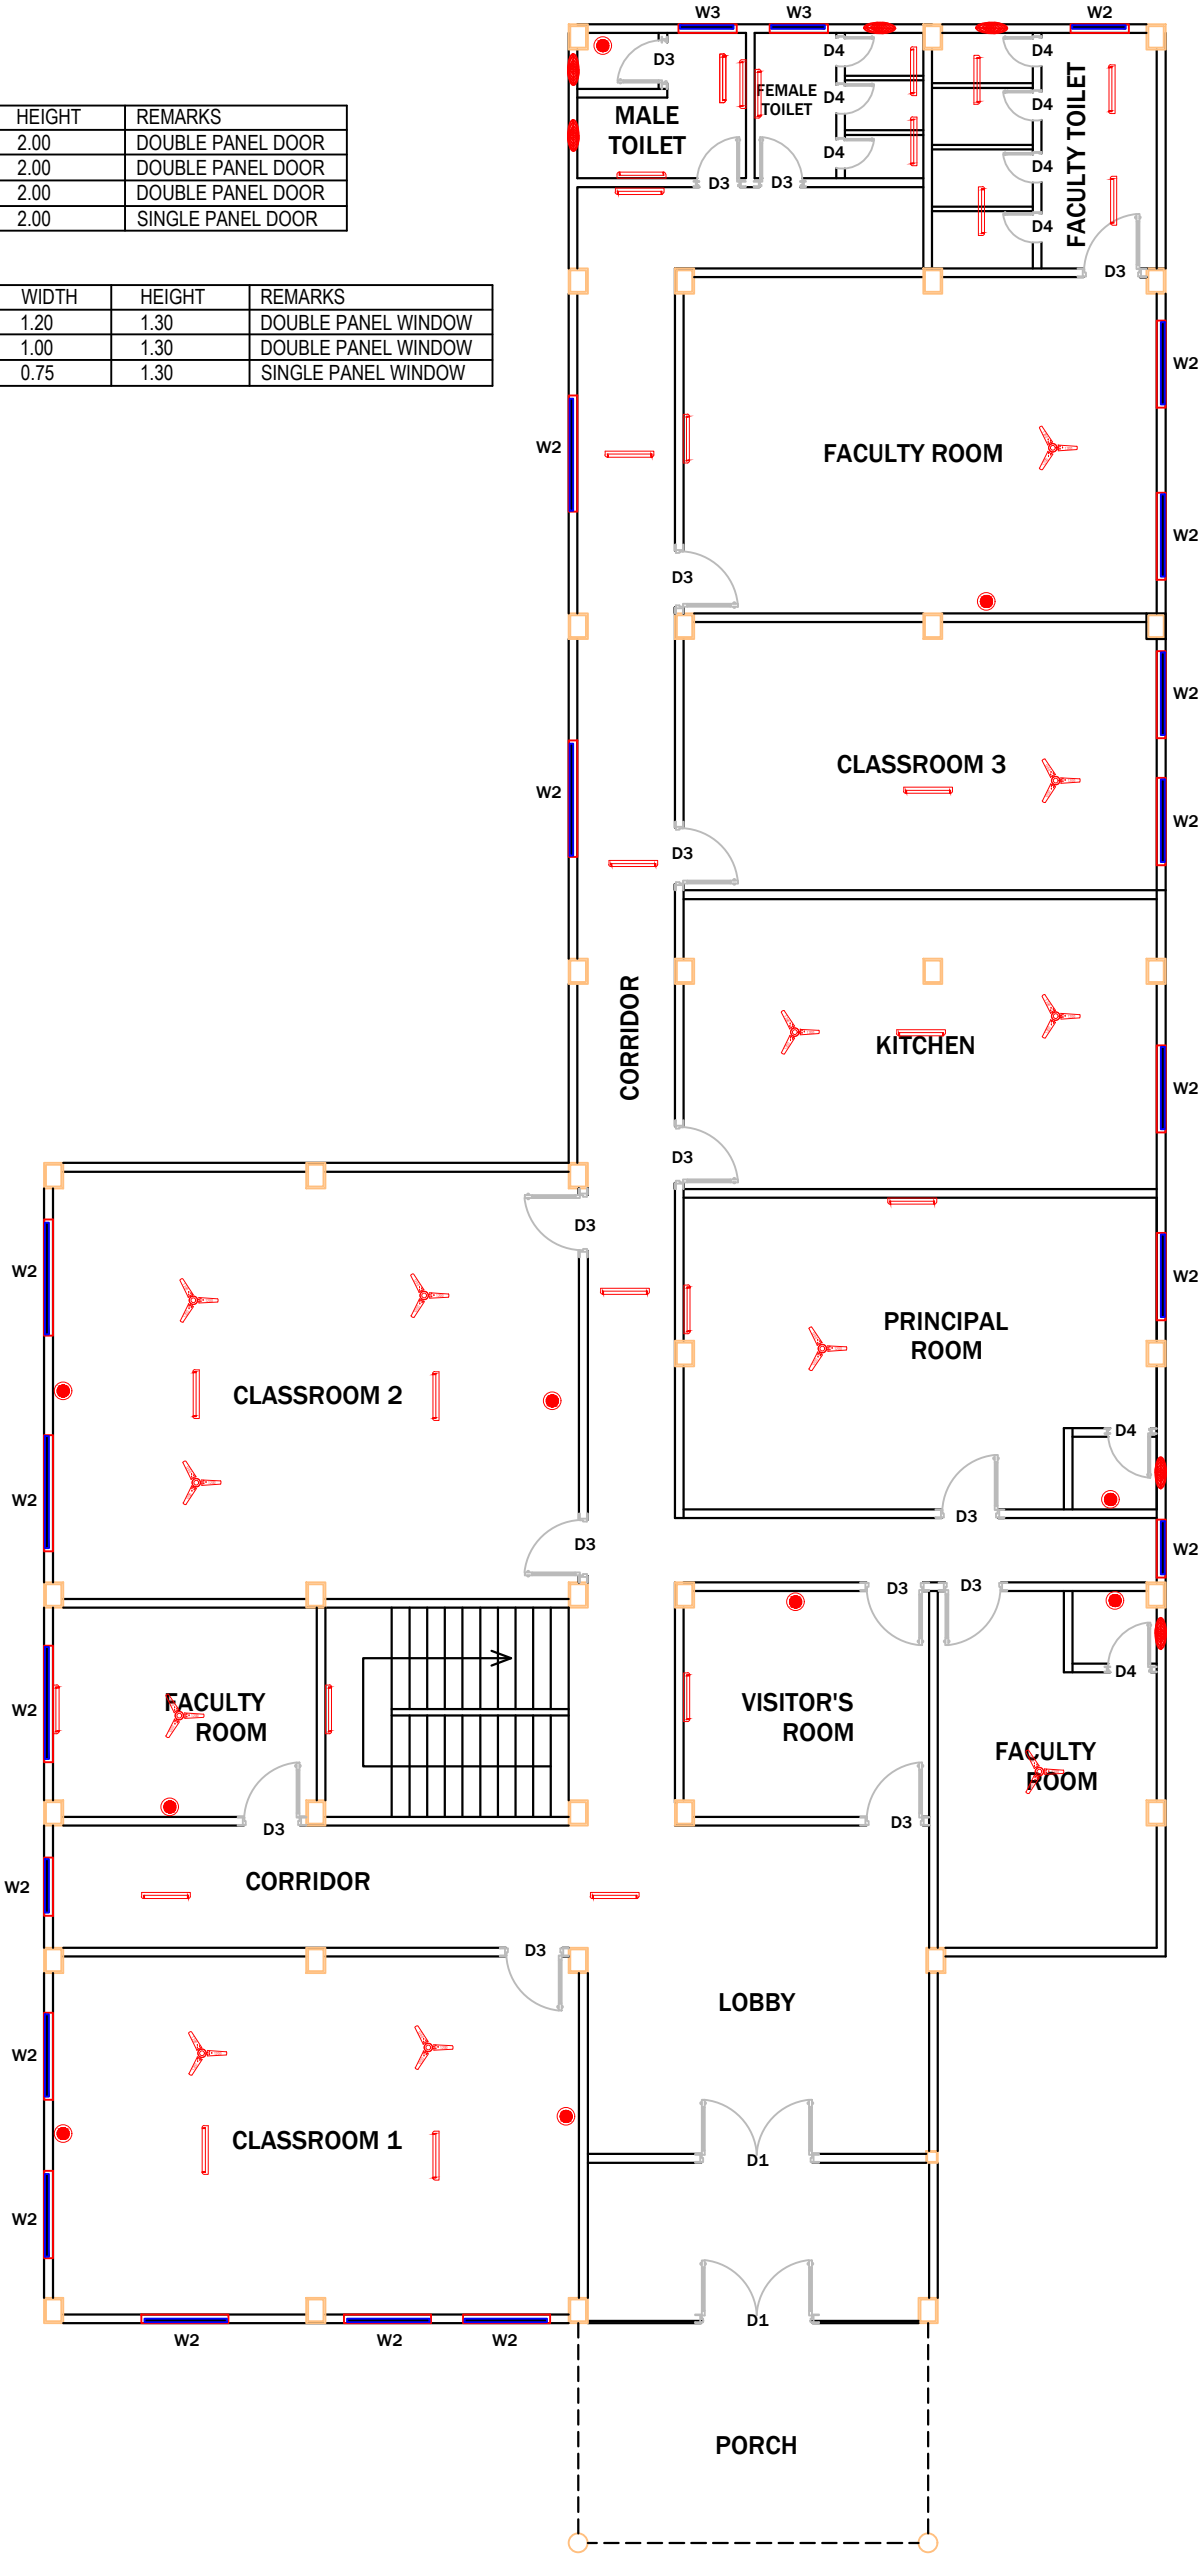

EXISTING

PROPOSED

GROUND FLOOR

PROPOSED LEGEND:

	20W LED TUBELIGHT
	1200 MM CEILING FAN
	12W LED DOWNLIGHT
	300 MM EXHAUST FAN
	SWITCH BOARD

PROJECT:-
ASSAM STATE SECONDARY HEALTHCARE
INITIATIVE FOR SERVICE DELIVERY
TRANSFORMATION (ASSIST)

CLIENT:-
ASSAM HEALTH INFRASTRUCTURE
DEVELOPMENT & MANAGEMENT SOCIETY
(AHIDMS)

PRINCIPAL CONSULTANT:

INTEGRA VENTURES
HEALTHCARE | INFRASTRUCTURE | CONSULTANCY
solutions projects services

PRITHVI GREENS, BLOCK A GROUND FLOOR
PATHARQUARY GUWAHATI-781171, ASSAM
M: +91-9401727143

STAGE:-	DPR
---------	-----

DRAWING NO:-	2024/ASSIST-GNM/TEZ/E/AC/PROP/01
--------------	----------------------------------

START DATE	ISSUE DATE	SHEET SIZE
	05-04-2025	A3

PROJECT CODE:-	2024/ASSIST-GNM/TEZ
----------------	---------------------

SCALE:-	N.T.S.
---------	--------

BLOCK:-	ACADEMIC
---------	----------

FLOOR:-	GROUND FLOOR
---------	--------------


DRAWING TITLE:-
PROPOSED ELECTRICAL LAYOUT,
GROUND FLOOR PLAN, ACADEMIC
BLOCK, GNM, TEZPUR, ASSAM.

DOOR SCHEDULE:-

SNO	NAME	WIDTH	HEIGHT	REMARKS
1.	D1	1.80	2.00	DOUBLE PANEL DOOR
2.	D2	1.50	2.00	DOUBLE PANEL DOOR
3.	D3	1.20	2.00	DOUBLE PANEL DOOR
4.	D4	0.85	2.00	SINGLE PANEL DOOR

WINDOW SCHEDULE:-

SNO	NAME	SILL	WIDTH	HEIGHT	REMARKS
1.	W1	0.70	1.20	1.30	DOUBLE PANEL WINDOW
2.	W2	0.70	1.00	1.30	DOUBLE PANEL WINDOW
3.	W3	0.70	0.75	1.30	SINGLE PANEL WINDOW

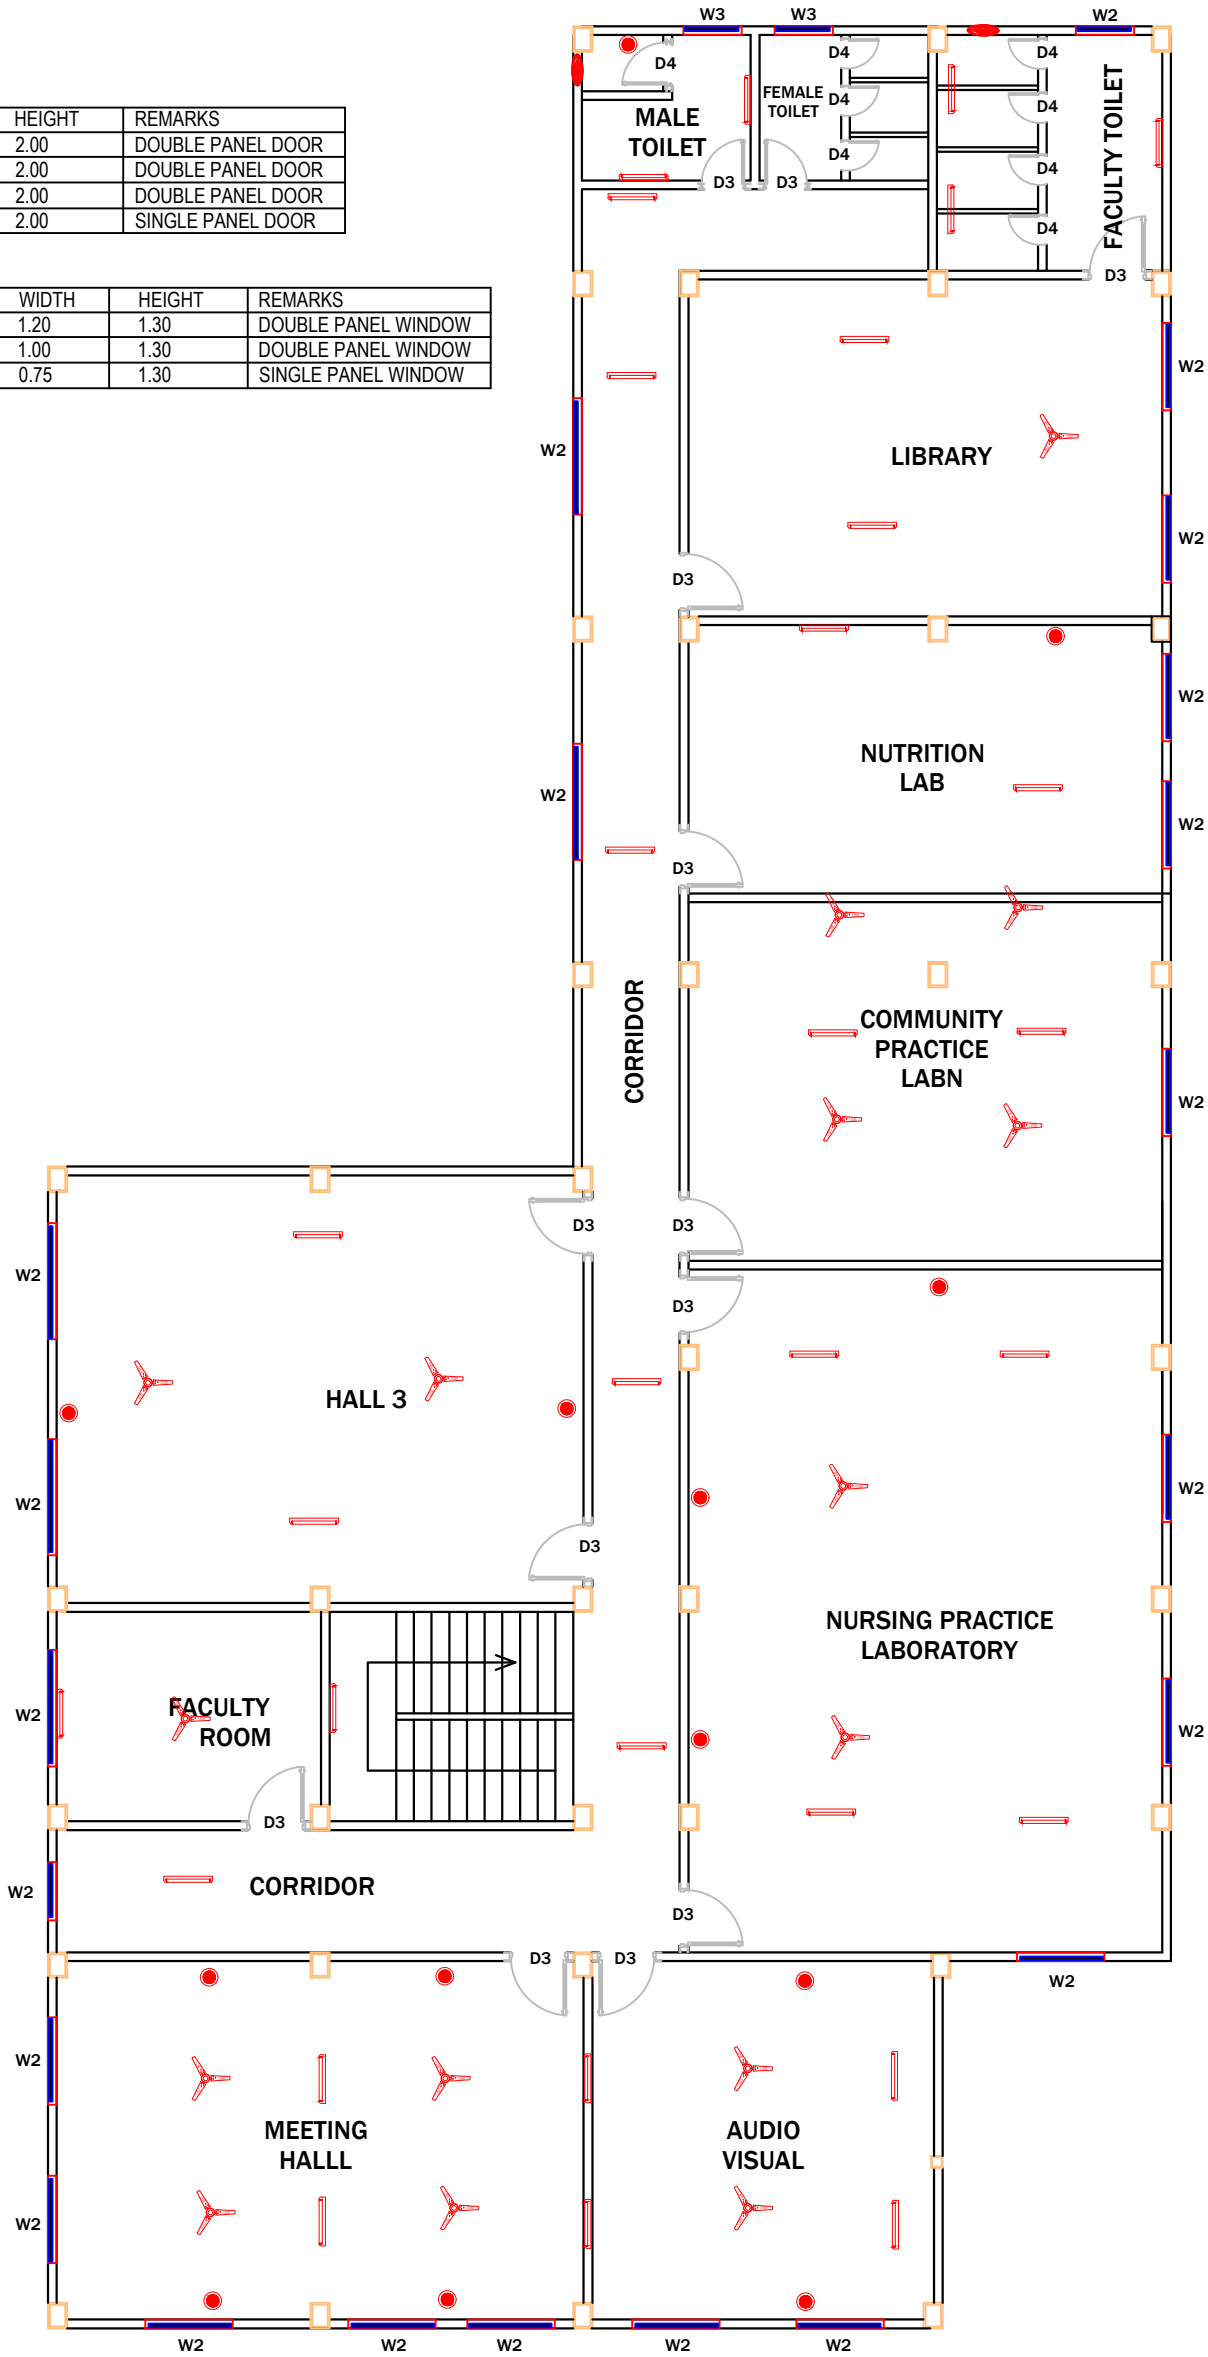

FIRST FLOOR

EXISTING

PROPOSED

PROPOSED LEGEND:	
	20W LED TUBELIGHT
	1200 MM CEILING FAN
	12W LED DOWNLIGHT
	300 MM EXHAUST FAN
	SWITCH BOARD

PROJECT:-
ASSAM STATE SECONDARY HEALTHCARE
INITIATIVE FOR SERVICE DELIVERY
TRANSFORMATION (ASSIST)

CLIENT:-
ASSAM HEALTH INFRASTRUCTURE
DEVELOPMENT & MANAGEMENT SOCIETY
(AHIDMS)

PRINCIPAL CONSULTANT:



INTEGRA VENTURES

HEALTHCARE | INFRASTRUCTURE | CONSULTANCY
solutions | projects | services

PRITHVI GREENS, BLOCK A GROUND FLOOR
PATHARQUARY GUWAHATI-781171, ASSAM
M: +91-9401727143

STAGE:-

DPR

DRAWING NO:-
2024/ASSIST-GNM/TEZ/E/AC/PROP/02

START DATE

ISSUE DATE

SHEET SIZE

05-04-2025

A3

PROJECT CODE:-

2024/ASSIST-GNM/TEZ

SCALE:-

N.T.S.

BLOCK:-

ACADEMIC

FLOOR:-

FIRST FLOOR



DRAWING TITLE:-
PROPOSED ELECTRICAL LAYOUT,
FIRST FLOOR PLAN, ACADEMIC
BLOCK, GNM, TEZPUR, ASSAM.

DOOR SCHEDULE:-

SNO	NAME	WIDTH	HEIGHT	REMARKS
1.	D1	1.80	2.00	DOUBLE PANEL DOOR
2.	D2	1.50	2.00	DOUBLE PANEL DOOR
3.	D3	1.20	2.00	DOUBLE PANEL DOOR
4.	D4	0.85	2.00	SINGLE PANEL DOOR

WINDOW SCHEDULE:-

SNO	NAME	SILL	WIDTH	HEIGHT	REMARKS
1.	W1	0.70	1.20	1.30	DOUBLE PANEL WINDOW
2.	W2	0.70	1.00	1.30	DOUBLE PANEL WINDOW
3.	W3	0.70	0.75	1.30	SINGLE PANEL WINDOW

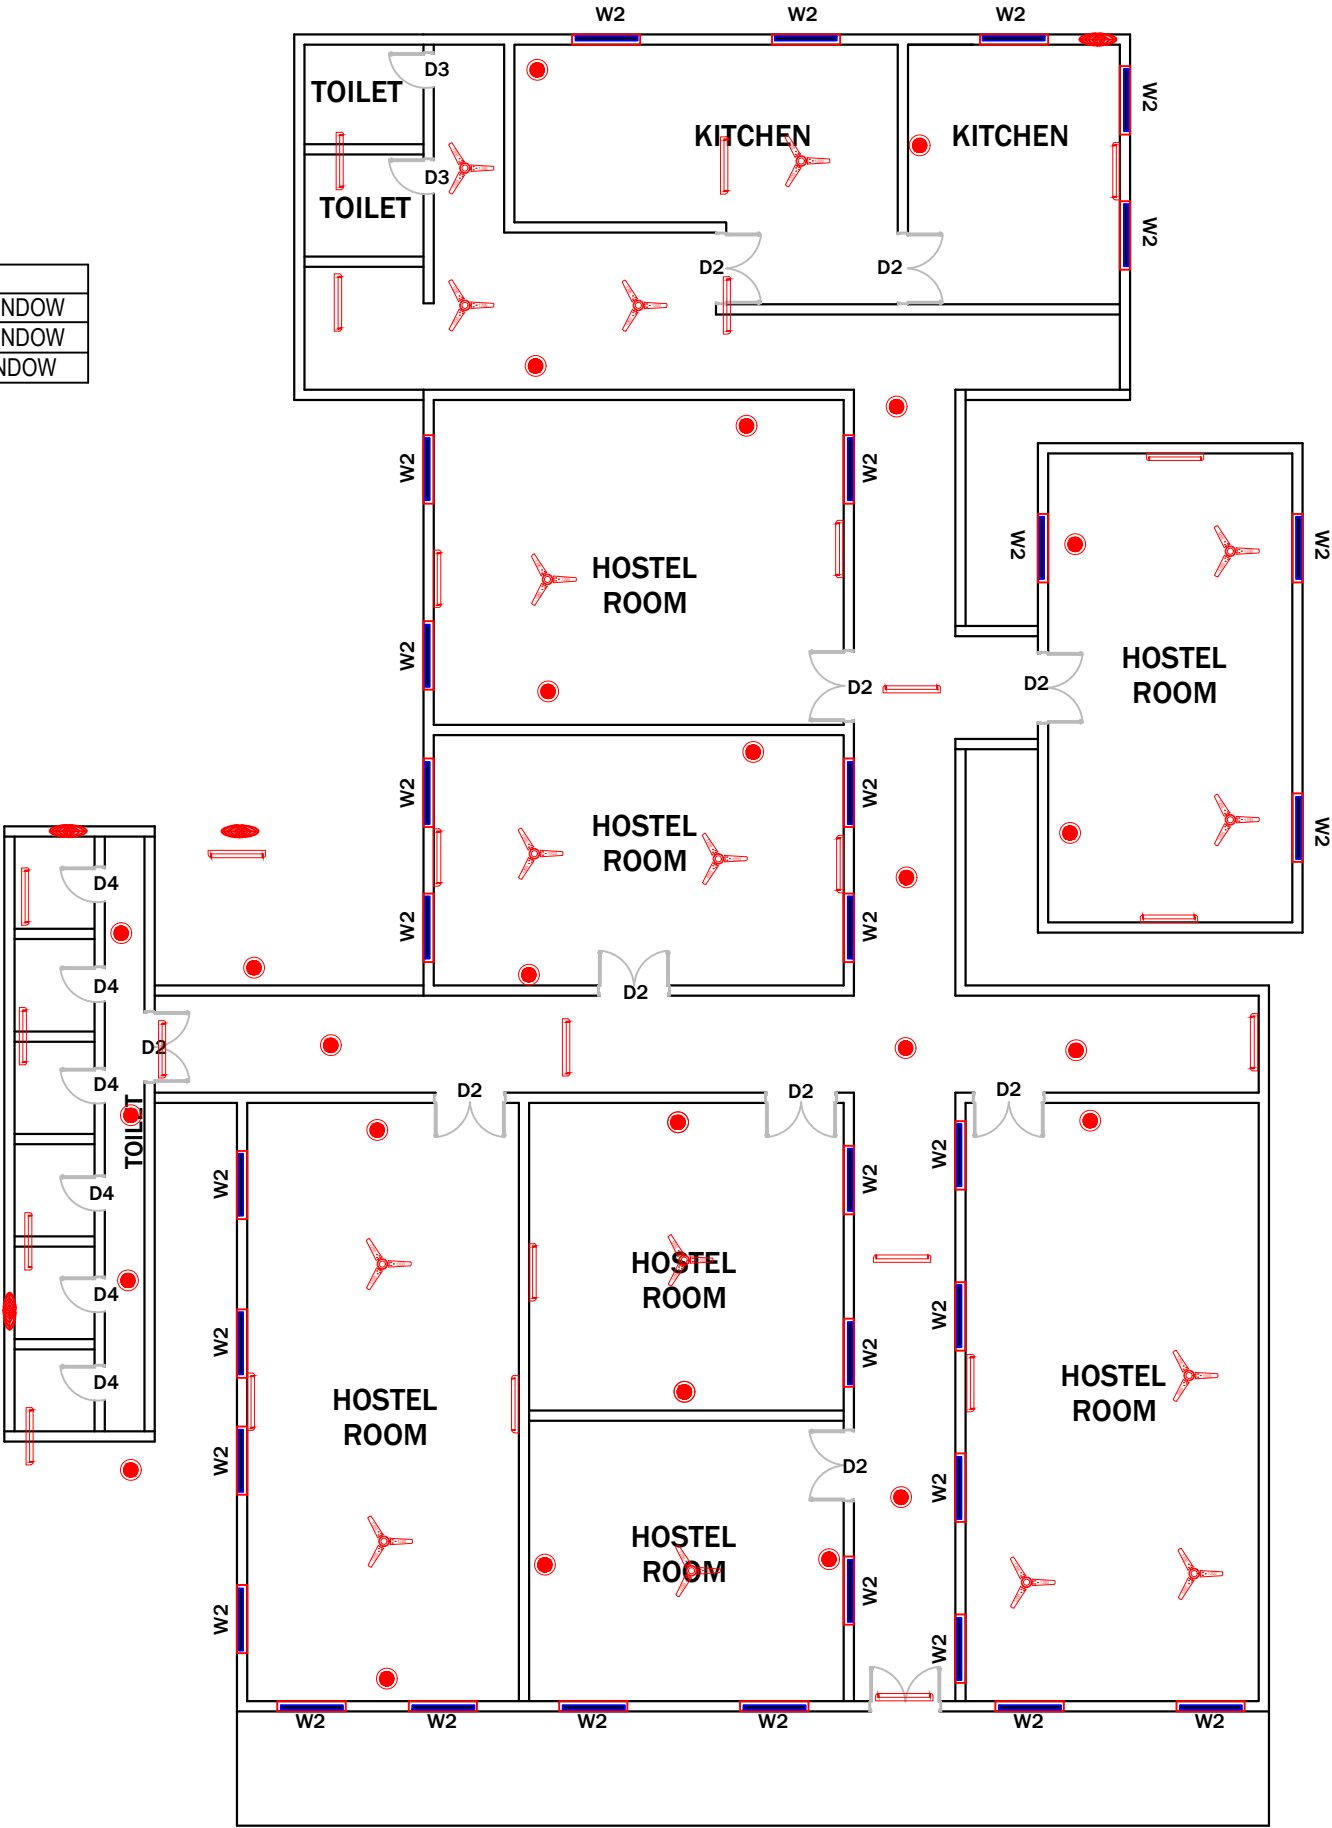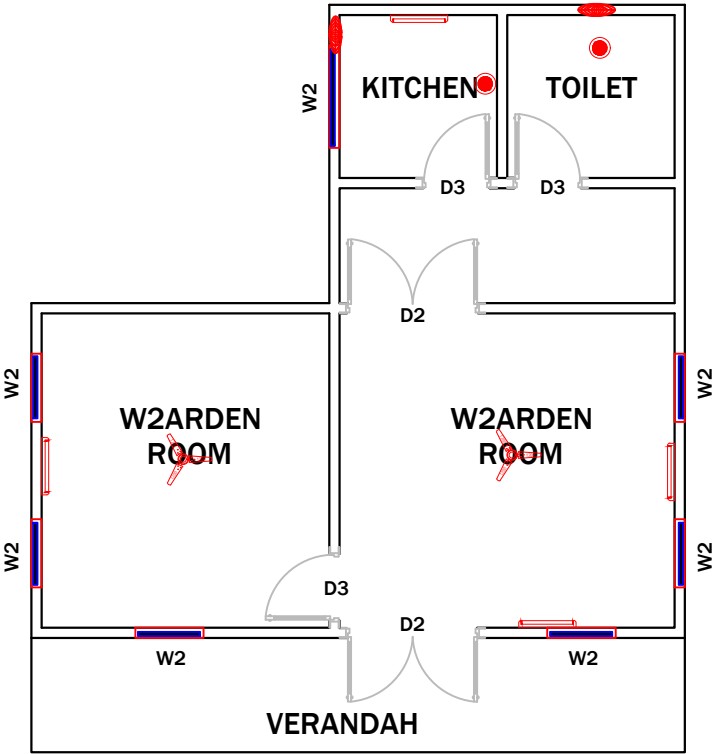

EXISTING



PROPOSED

GROUND FLOOR

PROJECT:-
ASSAM STATE SECONDARY HEALTHCARE
INITIATIVE FOR SERVICE DELIVERY
TRANSFORMATION (ASSIST)

CLIENT:-
ASSAM HEALTH INFRASTRUCTURE
DEVELOPMENT & MANAGEMENT SOCIETY
(AHIDMS)

PRINCIPAL CONSULTANT:

PRITHVI GREENS, BLOCK A GROUND FLOOR
PATHARQUARY GUWAHATI-781171, ASSAM
M: +91-9401727143

STAGE:-
DPR

DRAWING NO:-
2024/ASSIST-GNM/E/HS/PROP/01

START DATE	ISSUE DATE	SHEET SIZE
	05-04-2025	A3

PROJECT CODE:- 2024/ASSIST-GNM/TEZ

SCALE:-
N.T.S.

BLOCK:-
HOSTEL

FLOOR:-
GROUND FLOOR


DRAWING TITLE:-
PROPOSED ELECTRICAL LAYOUT,
GROUND FLOOR PLAN, HOSTEL
BLOCK, GNM, TEZPUR, ASSAM.

DOOR SCHEDULE:-

SNO	NAME	WIDTH	HEIGHT	REMARKS
1.	D1	1.80	2.00	DOUBLE PANEL DOOR
2.	D2	1.50	2.00	DOUBLE PANEL DOOR
3.	D3	1.20	2.00	DOUBLE PANEL DOOR
4.	D4	0.85	2.00	SINGLE PANEL DOOR

WINDOW SCHEDULE:-

SNO	NAME	SILL	WIDTH	HEIGHT	REMARKS
1.	W1	0.70	1.20	1.30	DOUBLE PANEL WINDOW
2.	W2	0.70	1.00	1.30	DOUBLE PANEL WINDOW
3.	W3	0.70	0.75	1.30	SINGLE PANEL WINDOW

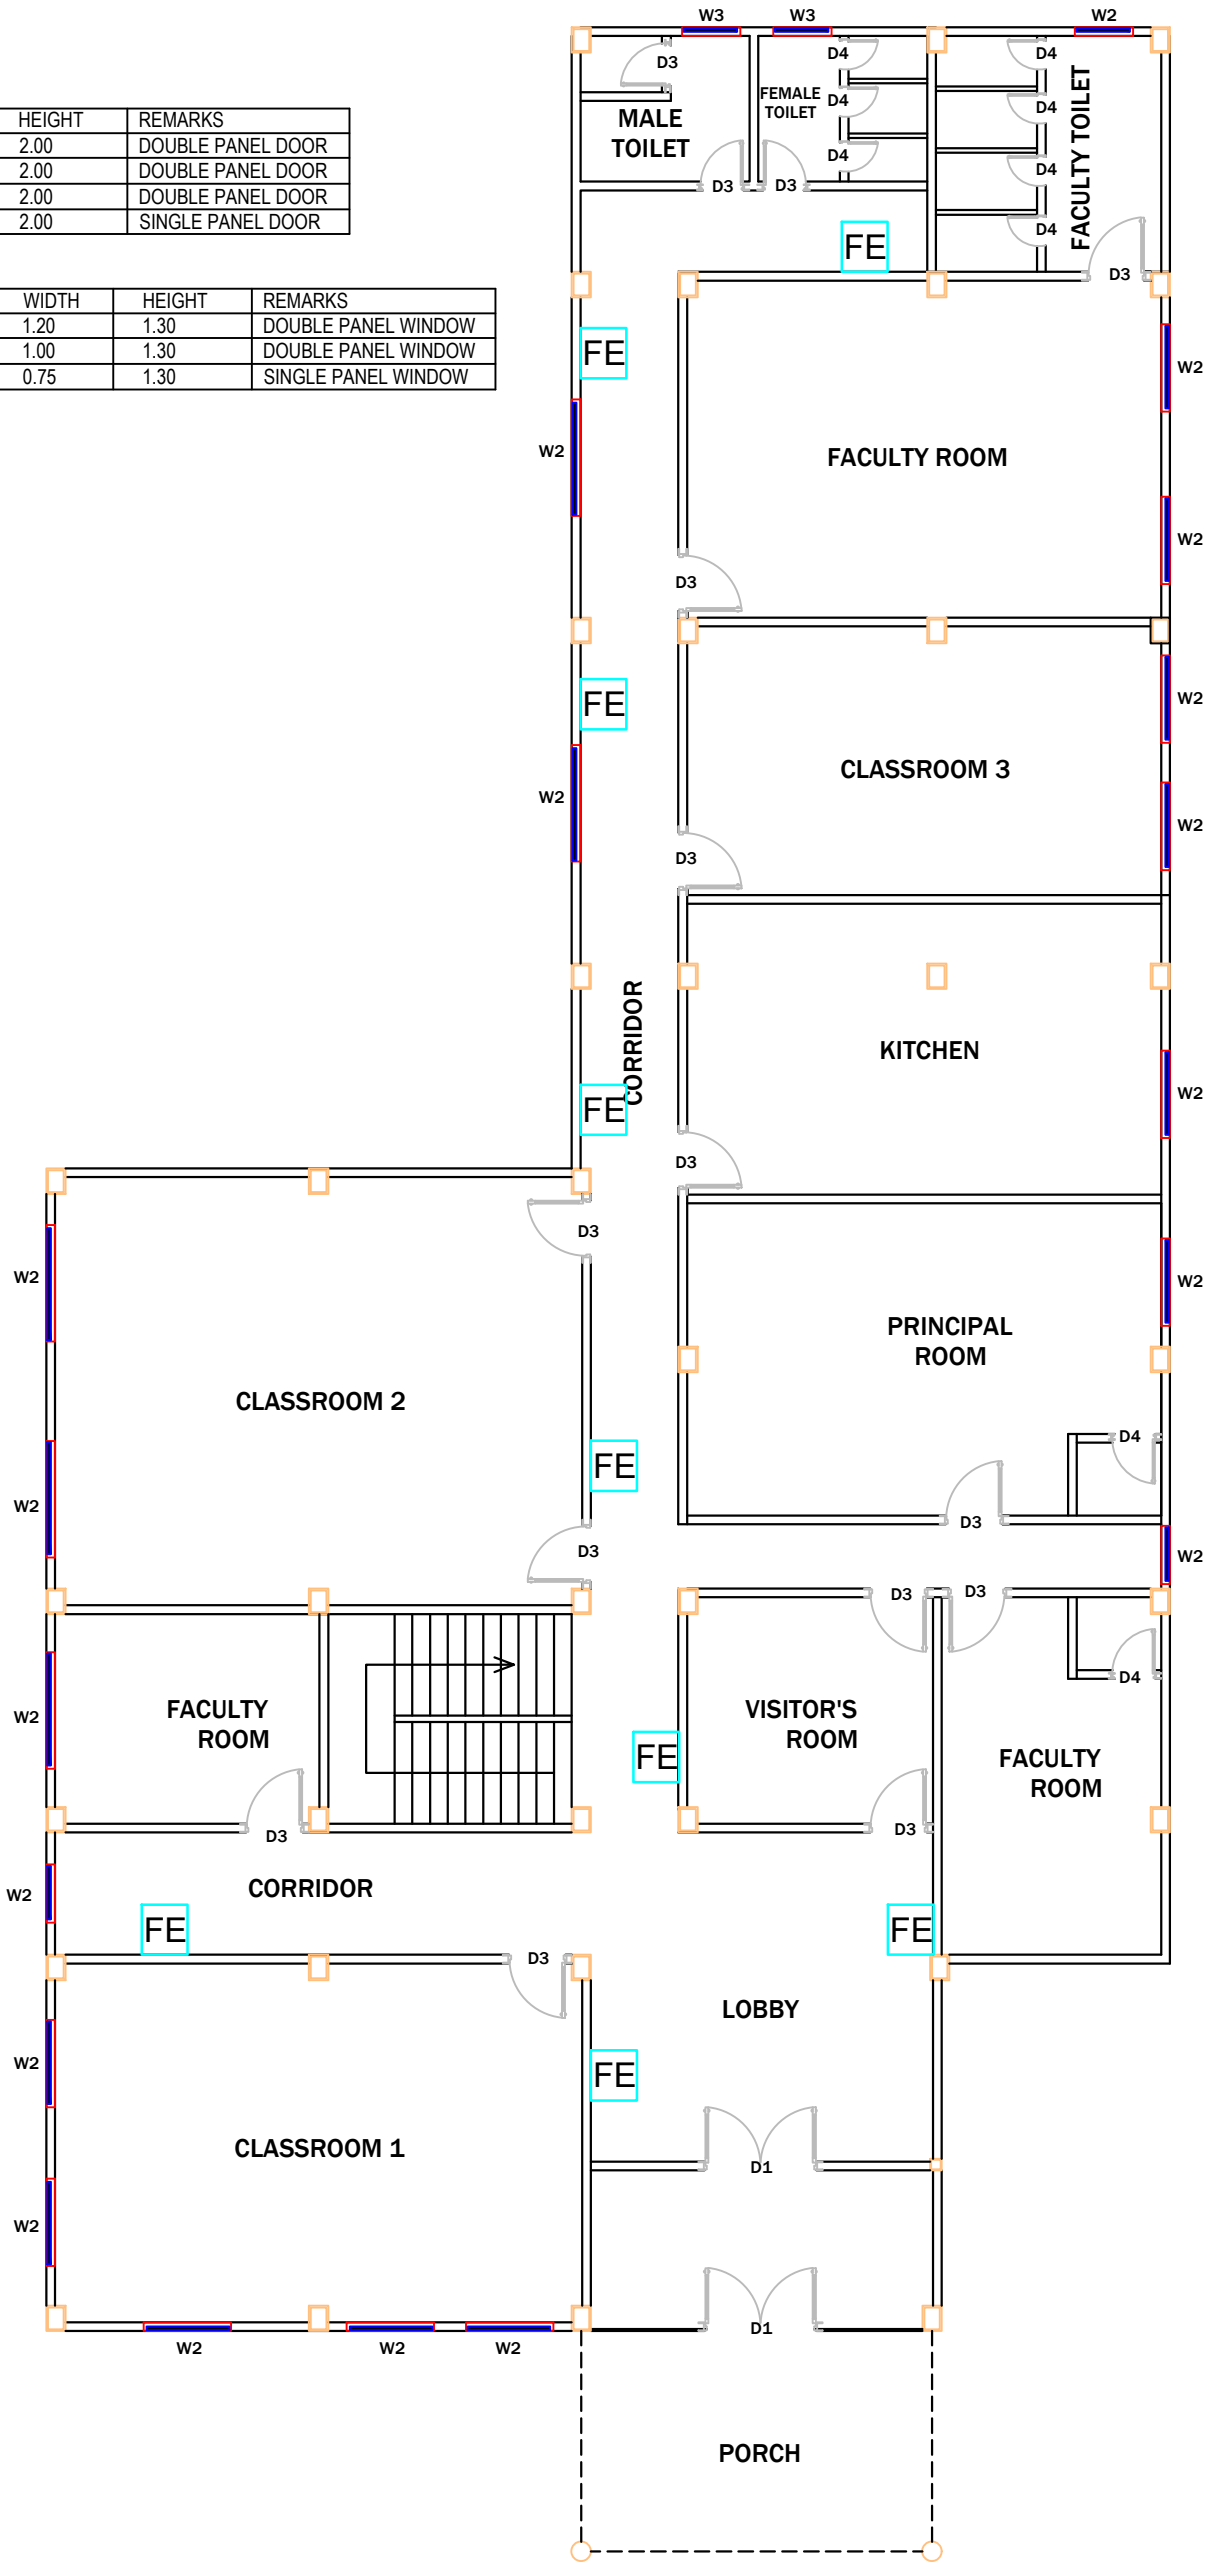

GROUND FLOOR

LEGEND:	
FE	FIRE EXTINGUISHER
S	SAND BUCKET


PROJECT:- ASSAM STATE SECONDARY HEALTHCARE INITIATIVE FOR SERVICE DELIVERY TRANSFORMATION (ASSIST)		
CLIENT:- ASSAM HEALTH INFRASTRUCTURE DEVELOPMENT & MANAGEMENT SOCIETY (AHIDMS)		
PRINCIPAL CONSULTANT:  INTEGRA VENTURES HEALTHCARE INFRASTRUCTURE CONSULTANCY solutions projects services PRITHVI GREENS, BLOCK A GROUND FLOOR PATHARQUARY GUWAHATI-781171, ASSAM M: +91-9401727143		
STAGE:-	DPR	
DRAWING NO:- 2024/ASSIST-GNM/TEZ/FF/AC/PROP/01		
START DATE	ISSUE DATE	SHEET SIZE
	05-04-2025	A3
PROJECT CODE:-	2024/ASSIST-GNM/TEZ	
SCALE:-	N.T.S.	
BLOCK:-	ACADEMIC	
FLOOR:-	GROUND FLOOR	
DRAWING TITLE:- PROPOSED FIRE FIGHTING LAYOUT, GROUND FLOOR PLAN, ACADEMIC BLOCK, GNM, TEZPUR, ASSAM.		

DOOR SCHEDULE:-

SNO	NAME	WIDTH	HEIGHT	REMARKS
1.	D1	1.80	2.00	DOUBLE PANEL DOOR
2.	D2	1.50	2.00	DOUBLE PANEL DOOR
3.	D3	1.20	2.00	DOUBLE PANEL DOOR
4.	D4	0.85	2.00	SINGLE PANEL DOOR

WINDOW SCHEDULE:-

SNO	NAME	SILL	WIDTH	HEIGHT	REMARKS
1.	W1	0.70	1.20	1.30	DOUBLE PANEL WINDOW
2.	W2	0.70	1.00	1.30	DOUBLE PANEL WINDOW
3.	W3	0.70	0.75	1.30	SINGLE PANEL WINDOW

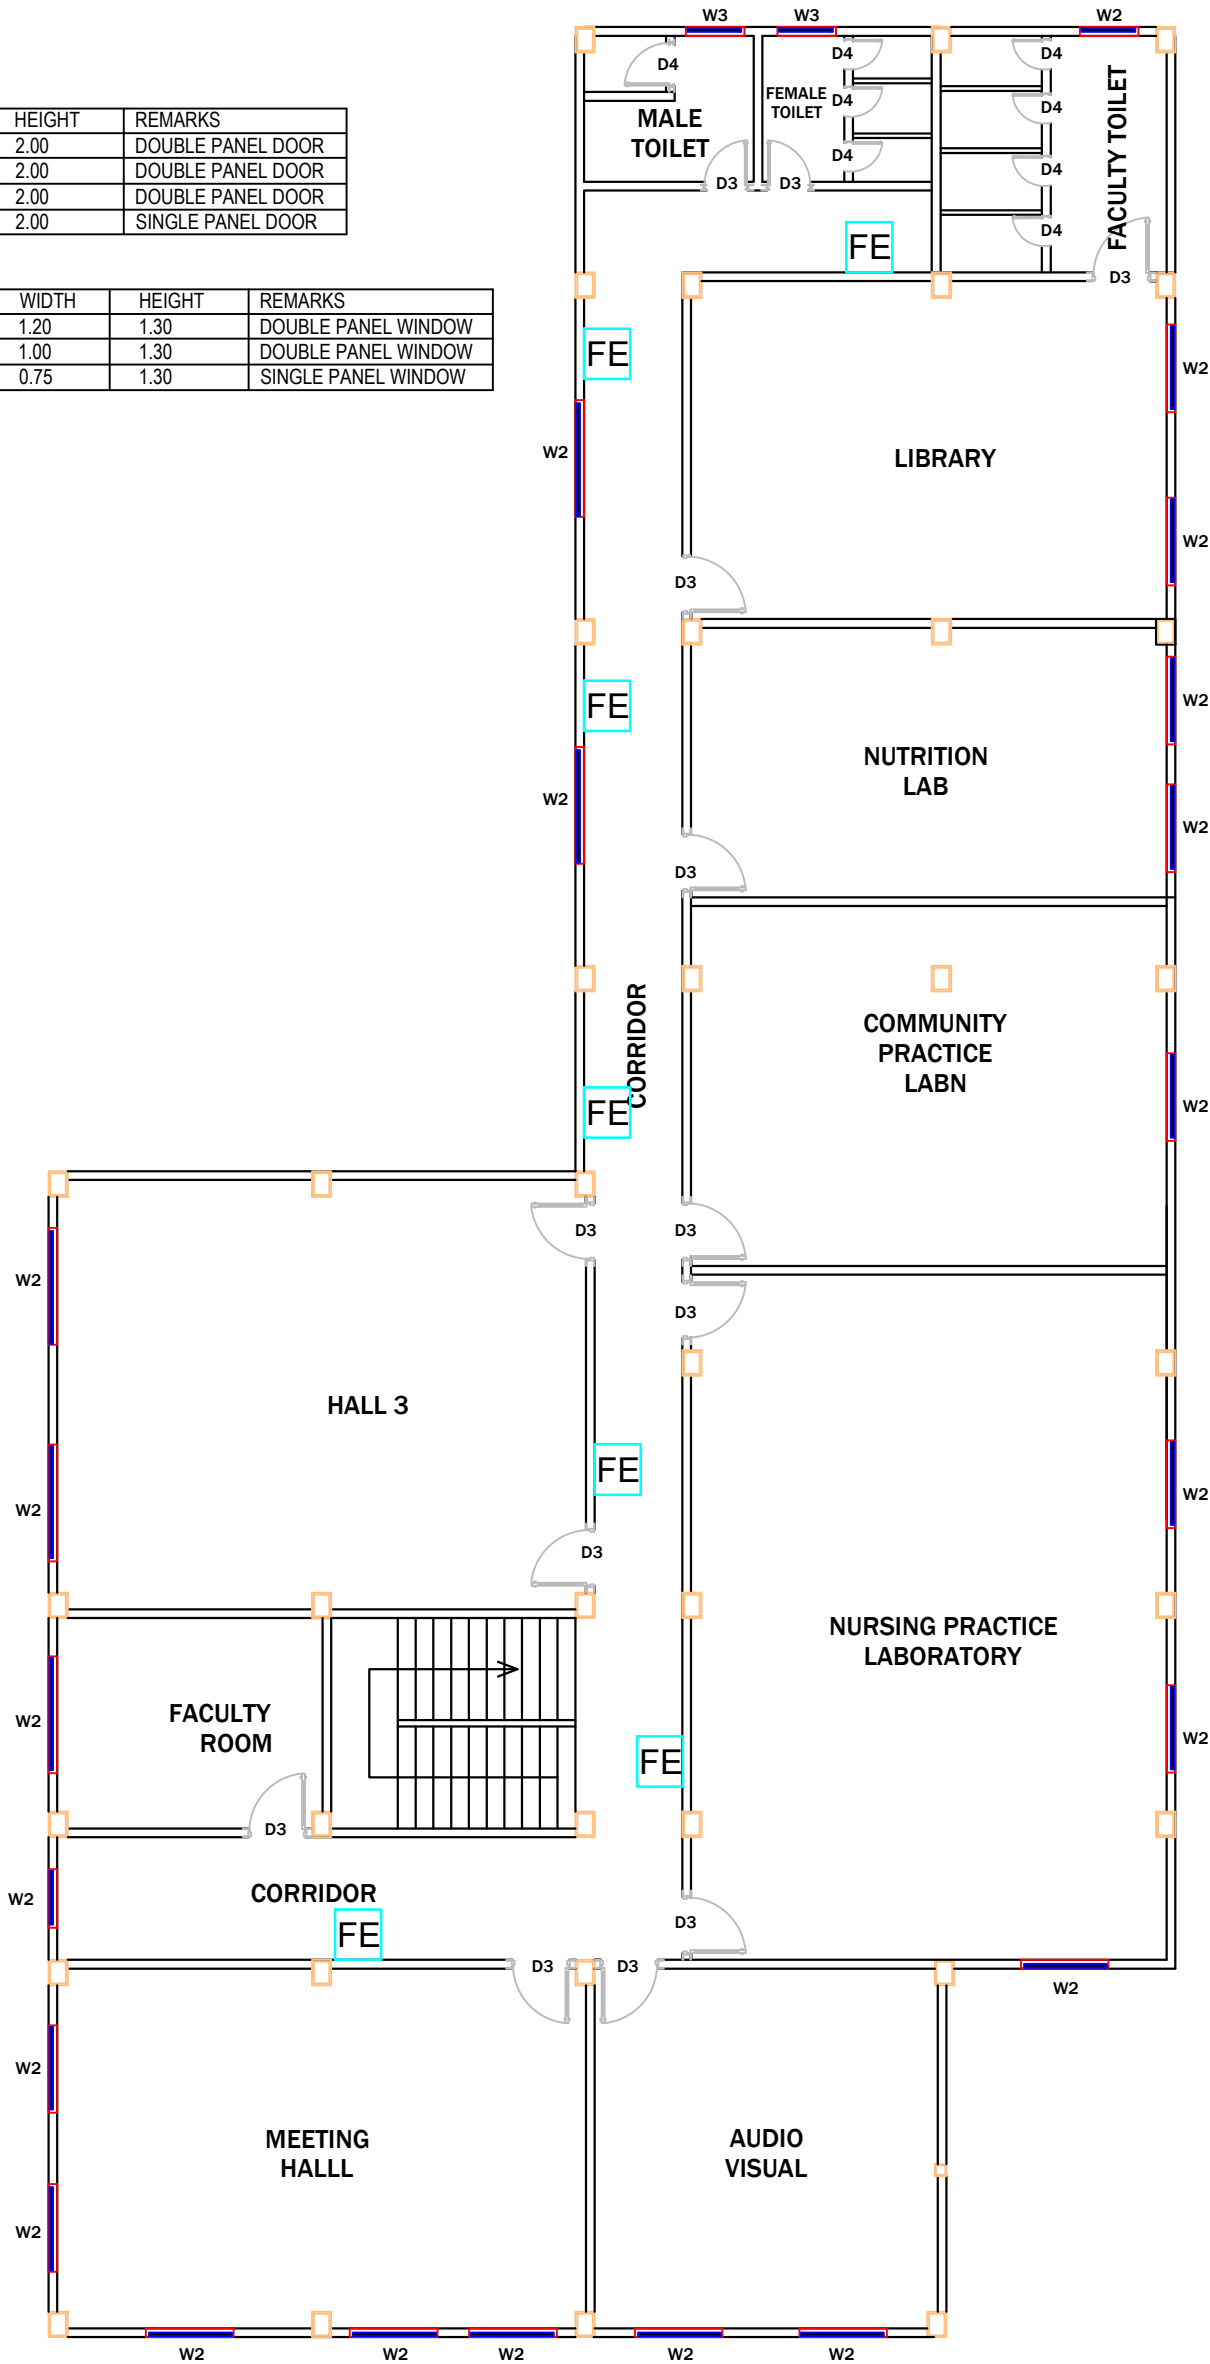

FIRST FLOOR




PROJECT:- ASSAM STATE SECONDARY HEALTHCARE INITIATIVE FOR SERVICE DELIVERY TRANSFORMATION (ASSIST)		
CLIENT:- ASSAM HEALTH INFRASTRUCTURE DEVELOPMENT & MANAGEMENT SOCIETY (AHIDMS)		
PRINCIPAL CONSULTANT: INTEGRA VENTURES HEALTHCARE INFRASTRUCTURE CONSULTANCY ROBILTON PRITHVI SERVICES PRITHVI GREENS, BLOCK A GROUND FLOOR PATHARQUARY GUWAHATI-781171, ASSAM M: +91-9401727143		
STAGE:-	DPR	
DRAWING NO:- 2024/ASSIST-GNM/TEZ/FF/AC/PROP/02		
START DATE	ISSUE DATE	SHEET SIZE
	15-02-2025	A3
PROJECT CODE:-	2024/ASSIST-GNM/TEZ	
SCALE:-	N.T.S.	
BLOCK:-	ACADEMIC	
FLOOR:-	FIRST FLOOR	
DRAWING TITLE:- PROPOSED FIRE FIGHTING LAYOUT, FIRST FLOOR PLAN, ACADEMIC BLOCK, GNM, TEZPUR, ASSAM.		

DOOR SCHEDULE:-

SNO	NAME	WIDTH	HEIGHT	REMARKS
1.	D1	1.80	2.00	DOUBLE PANEL DOOR
2.	D2	1.50	2.00	DOUBLE PANEL DOOR
3.	D3	1.20	2.00	DOUBLE PANEL DOOR
4.	D4	0.85	2.00	SINGLE PANEL DOOR

WINDOW SCHEDULE:-

SNO	NAME	SILL	WIDTH	HEIGHT	REMARKS
1.	W1	0.70	1.20	1.30	DOUBLE PANEL WINDOW
2.	W2	0.70	1.00	1.30	DOUBLE PANEL WINDOW
3.	W3	0.70	0.75	1.30	SINGLE PANEL WINDOW

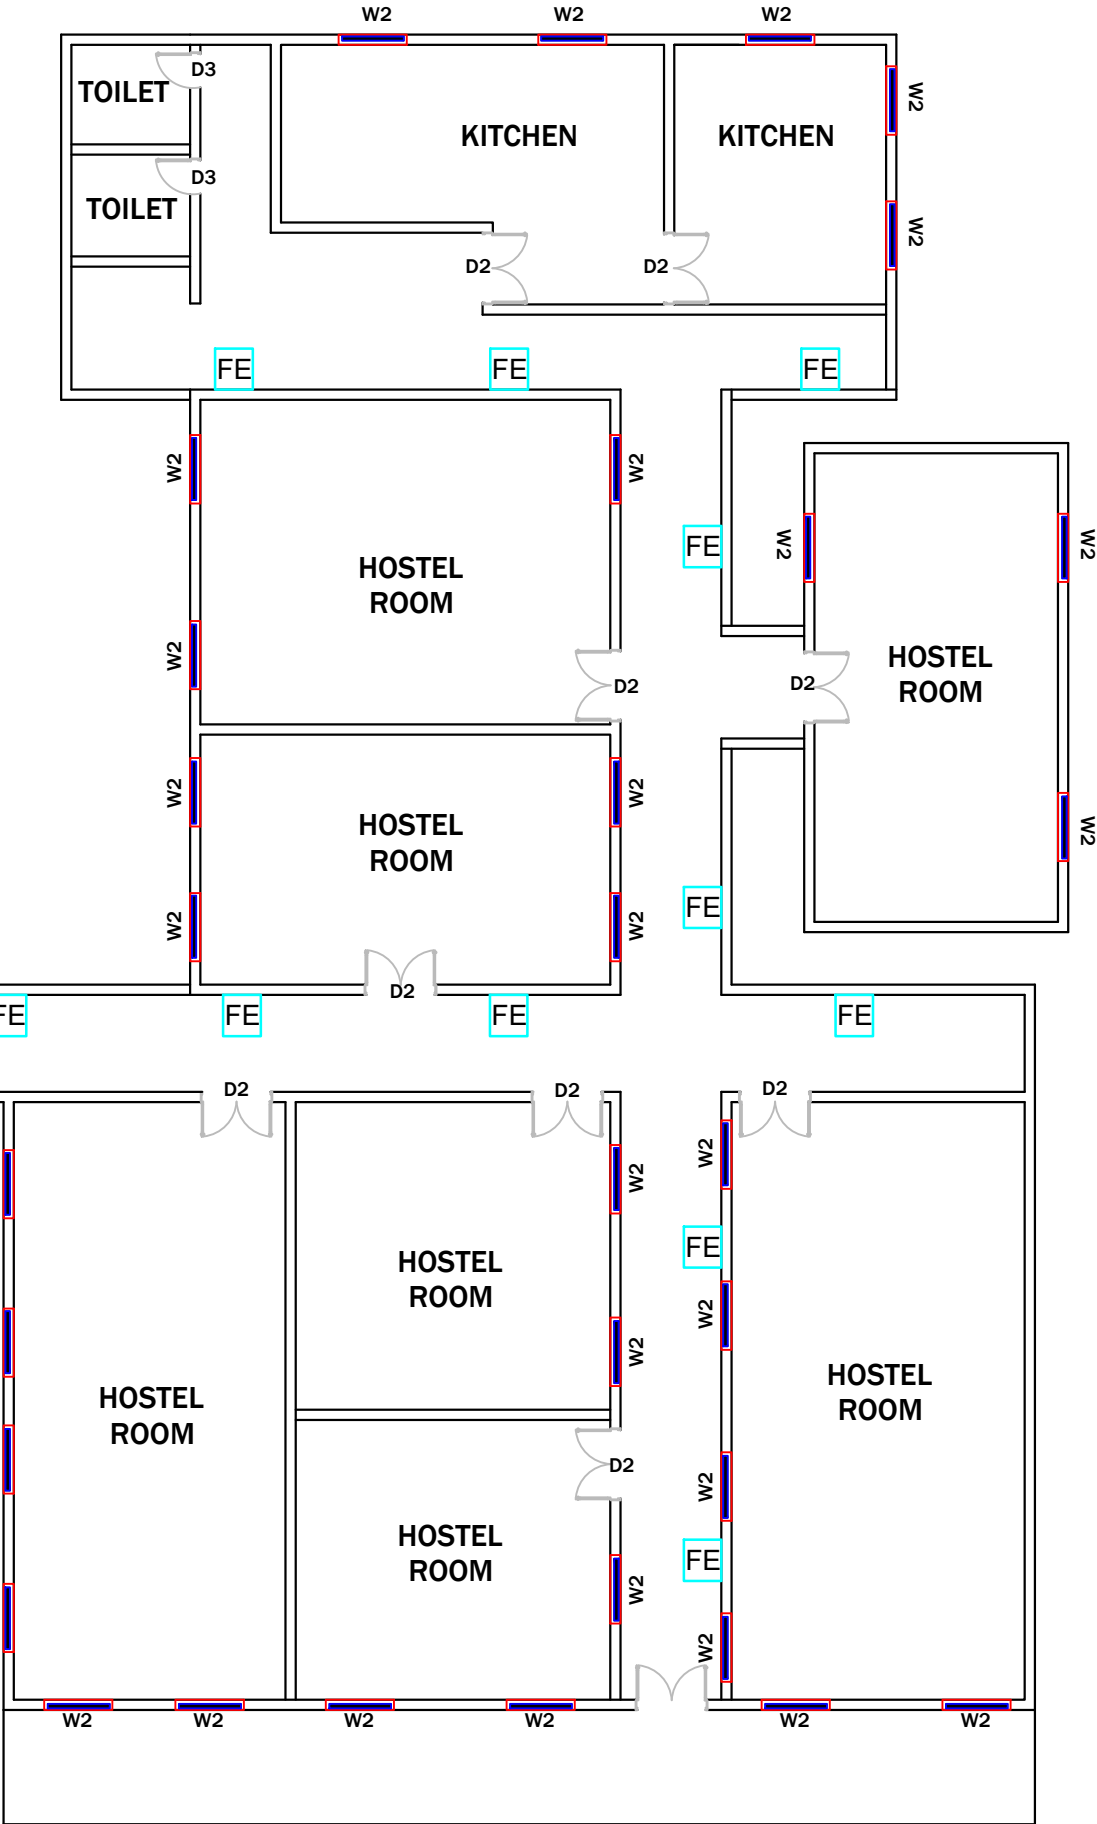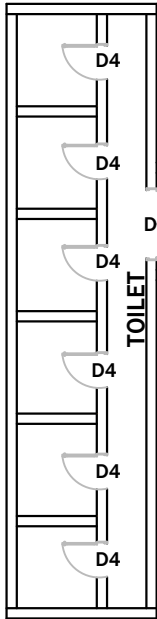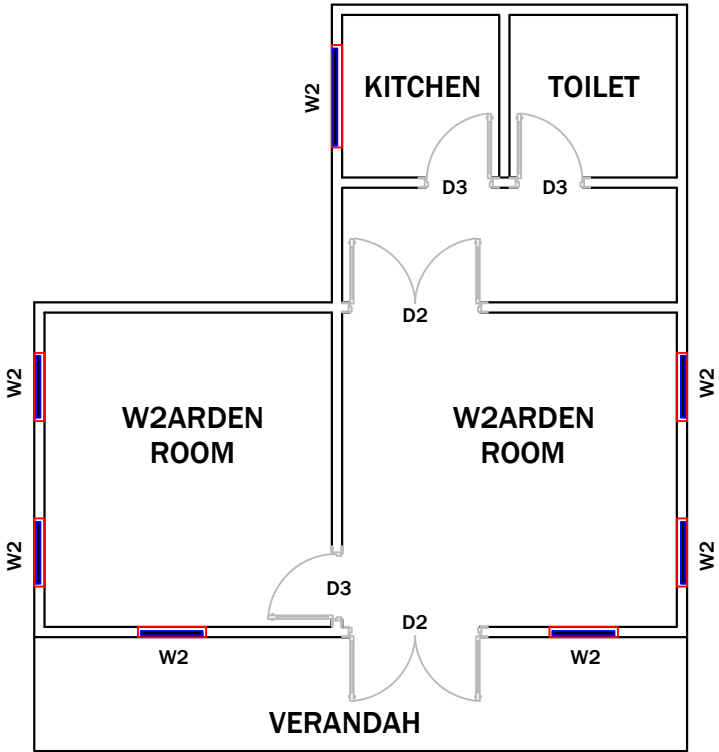

GROUND FLOOR

PROJECT:-
ASSAM STATE SECONDARY HEALTHCARE
INITIATIVE FOR SERVICE DELIVERY
TRANSFORMATION (ASSIST)

CLIENT:-
ASSAM HEALTH INFRASTRUCTURE
DEVELOPMENT & MANAGEMENT SOCIETY
(AHIDMS)

PRINCIPAL CONSULTANT:



PRITHVI GREENS, BLOCK A GROUND FLOOR
PATHARQUARY GUWAHATI-781171, ASSAM
M: +91-9401727143

STAGE:-
DPR

DRAWING NO:-
2024/ASSIST-GNM/FF/HS/PROP/01

START DATE	ISSUE DATE	SHEET SIZE
	05-04-2025	A3


PROJECT CODE:- 2024/ASSIST-GNM/TEZ

SCALE:-
N.T.S.

BLOCK:-
HOSTEL

FLOOR:-
GROUND FLOOR

DRAWING TITLE:-
PROPOSED FIRE FIGHTING
LAYOUT, GROUND FLOOR PLAN,
HOSTEL BLOCK, GNM, TEZPUR,
ASSAM.

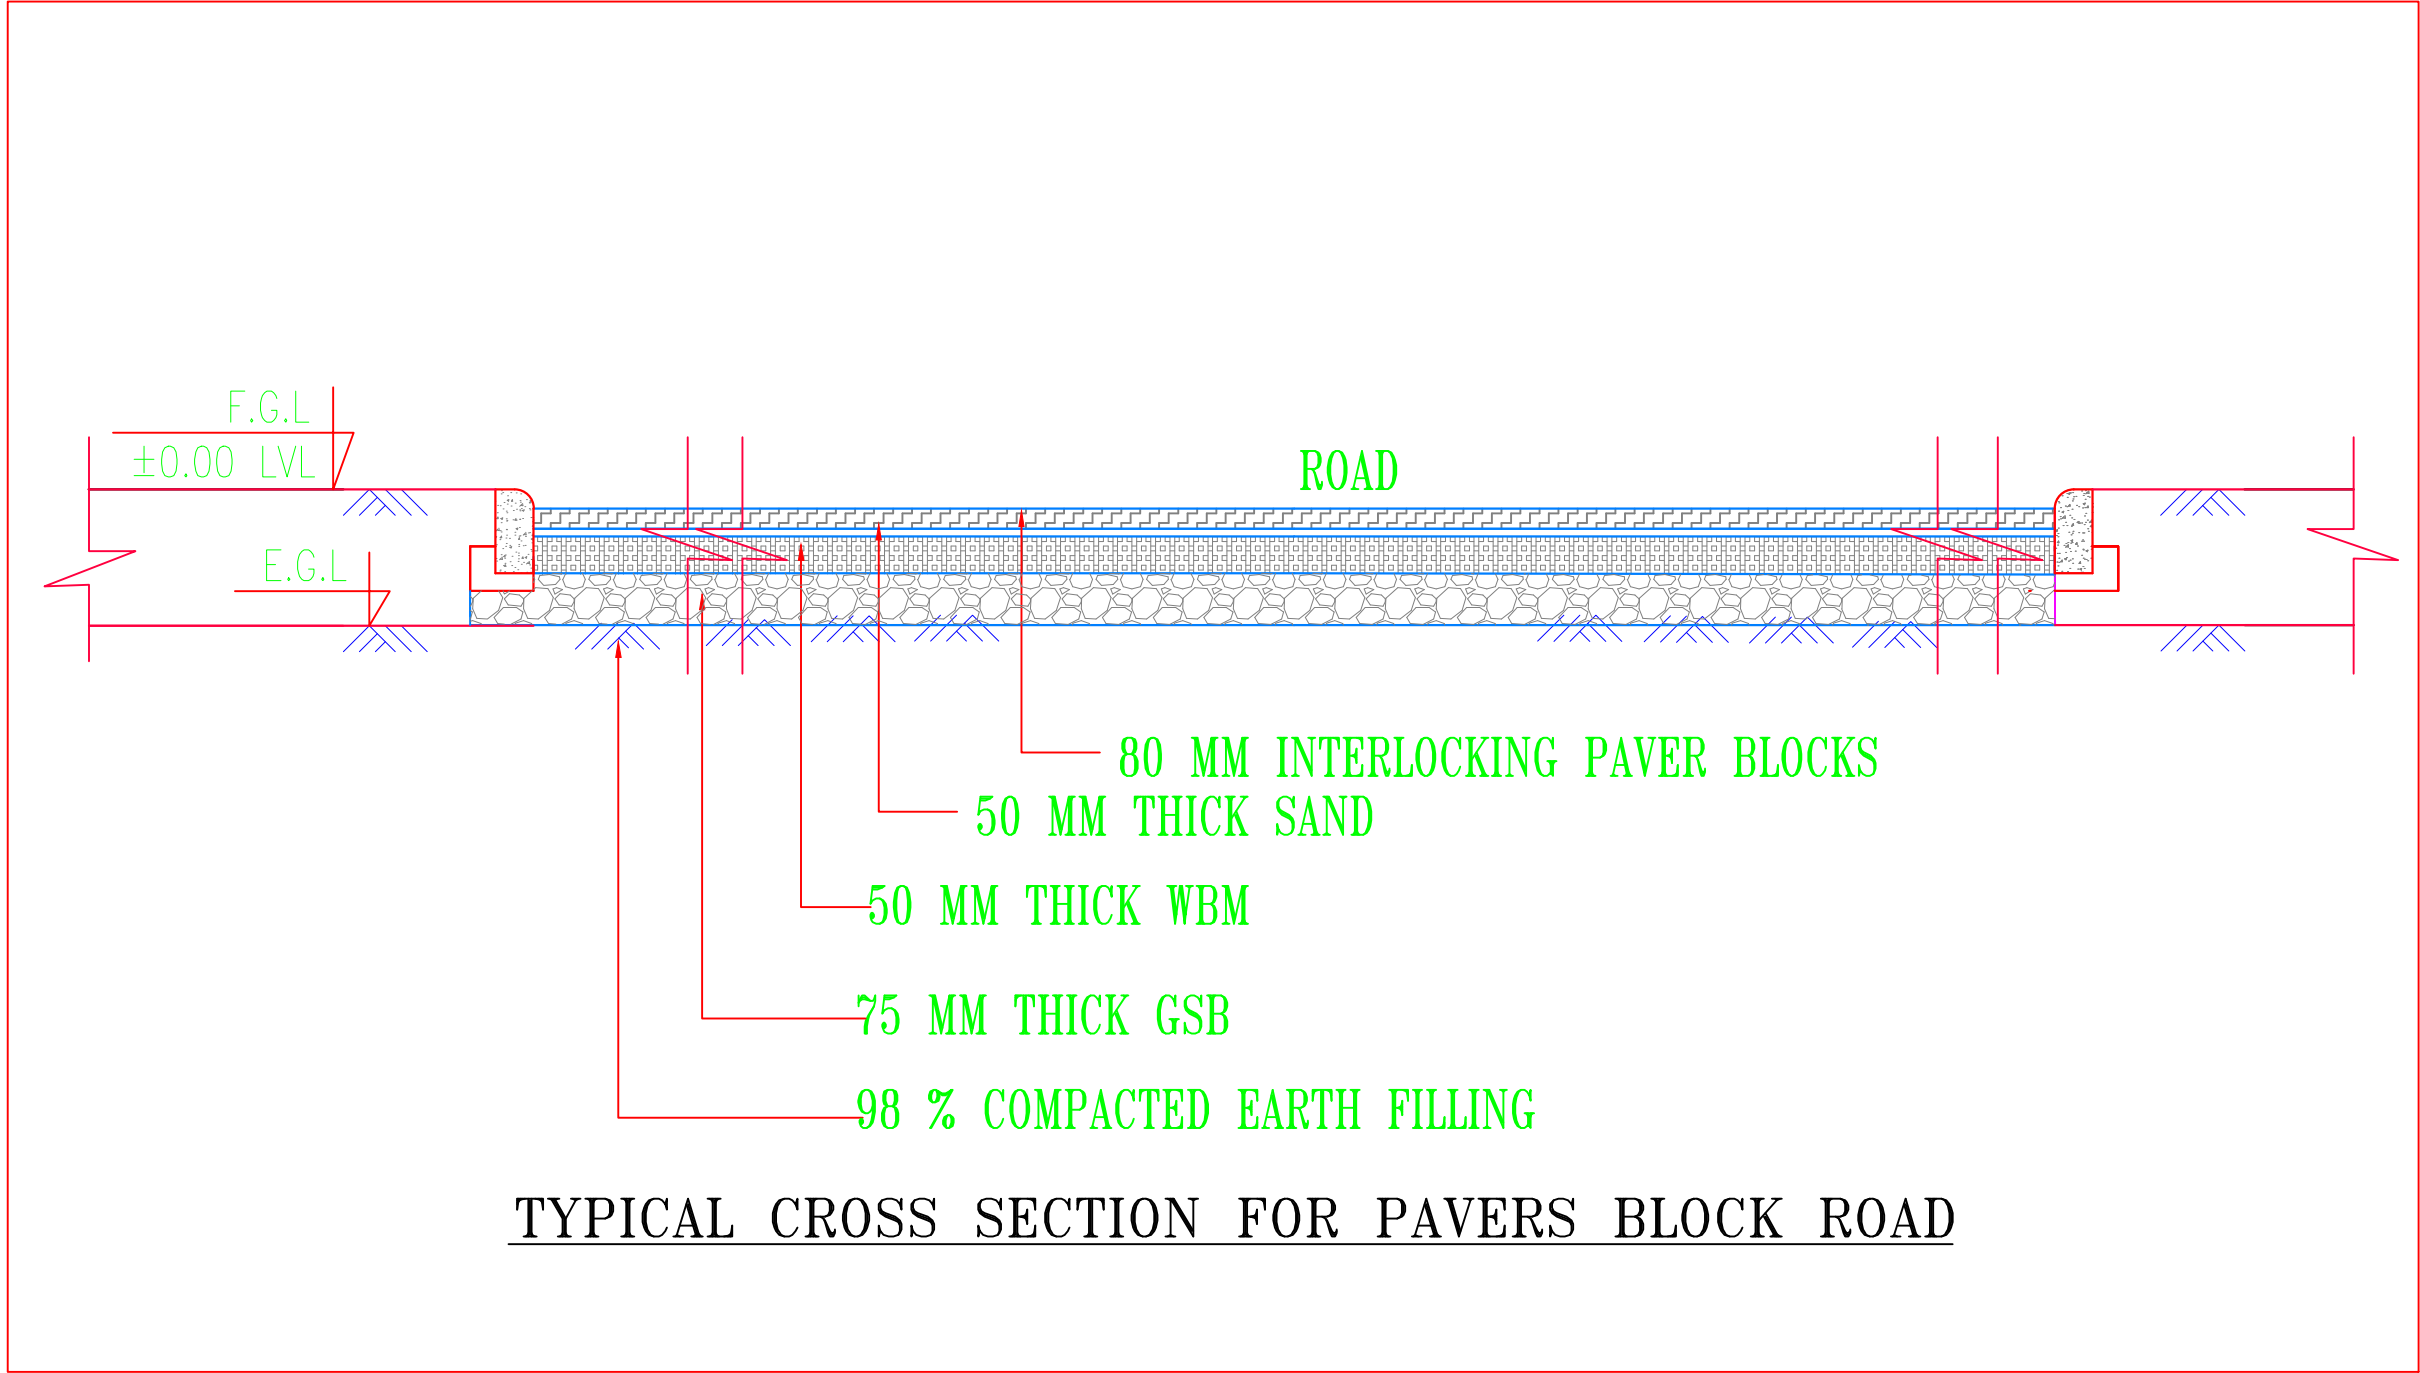

TYPICAL CROSS SECTION FOR PAVERS BLOCK ROAD

PROJECT:-
ASSAM STATE SECONDARY HEALTHCARE
INITIATIVE FOR SERVICE DELIVERY
TRANSFORMATION (ASSIST)

CLIENT:-
ASSAM HEALTH INFRASTRUCTURE
DEVELOPMENT & MANAGEMENT SOCIETY
(AHIDMS)

PRINCIPAL CONSULTANT:

 **INTEGRA VENTURES**
HEALTHCARE | INFRASTRUCTURE | CONSULTANCY
solutions projects services

PRITHVI GREENS, BLOCK A GROUND FLOOR
PATHARQUARY GUWAHATI-781171, ASSAM
M: +91-9401727143

STAGE:-	DPR
---------	-----

DRAWING NO:- 2024/ASSIST-GNM/TEZ/ROAD /01
--

START DATE	ISSUE DATE	SHEET SIZE
	05-04-2024	A3

PROJECT CODE:-	2024/ASSIST-GNM/TEZ
----------------	---------------------


SCALE:-	N.T.S.
---------	--------

--	--

--	--




DRAWING TITLE:-

ROAD DETAIL, GNM, TEZPUR,
ASSAM

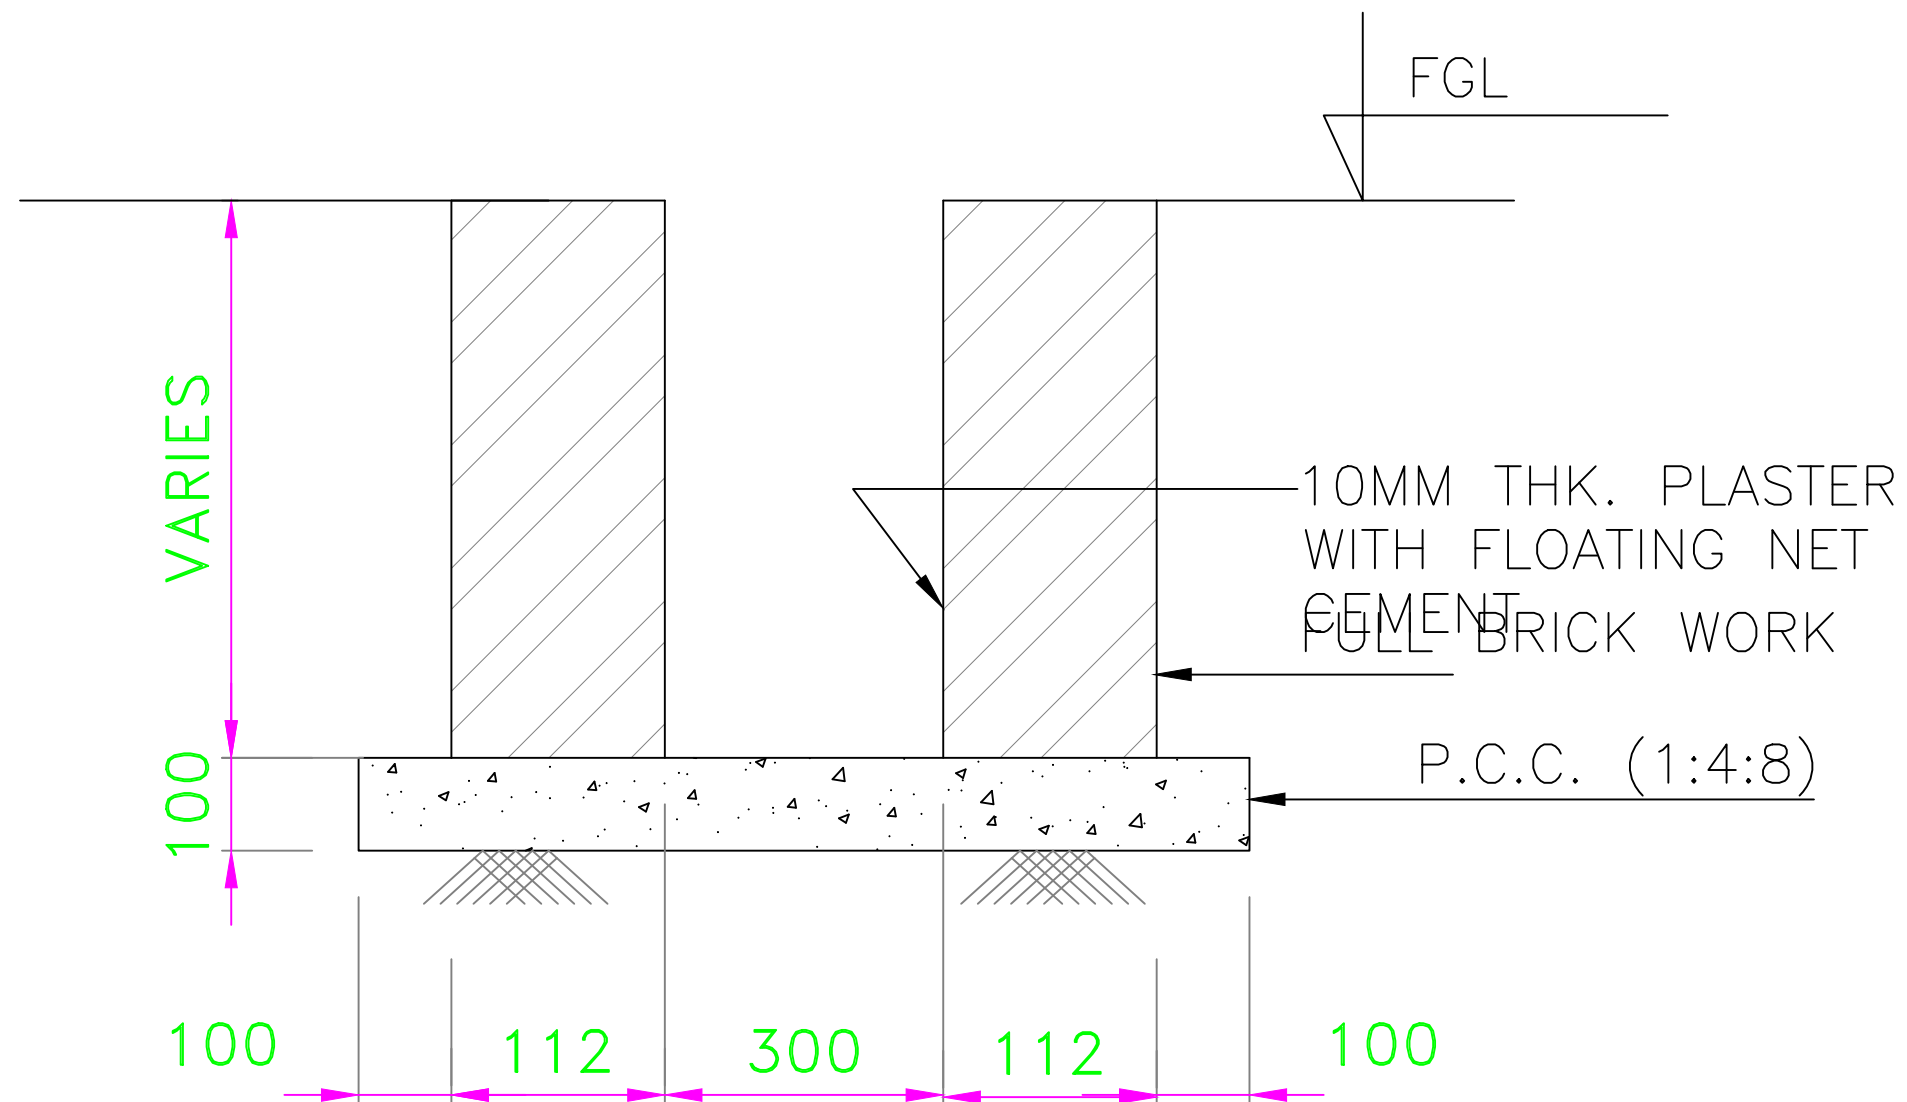


FULL BRICK DRAIN DETAIL
(FOR 300MM WIDE DRAIN)


PROJECT:- ASSAM STATE SECONDARY HEALTHCARE INITIATIVE FOR SERVICE DELIVERY TRANSFORMATION (ASSIST)		
CLIENT:- ASSAM HEALTH INFRASTRUCTURE DEVELOPMENT & MANAGEMENT SOCIETY (AHIDMS)		
PRINCIPAL CONSULTANT: INTEGRA VENTURES HEALTHCARE INFRASTRUCTURE CONSULTANCY solutions projects services PRITHVI GREENS, BLOCK A GROUND FLOOR PATHARQUARY GUWAHATI-781171, ASSAM M: +91-9401727143		
STAGE:-	DPR	
DRAWING NO:- 2024/ASSIST-GNM/TEZ/DRAIN/01		
START DATE	ISSUE DATE	SHEET SIZE
	05-04-2024	A3
PROJECT CODE:-	2024/ASSIST-GNM/TEZ	
SCALE:-	N.T.S.	
DRAWING TITLE:- DRAIN DETAIL, GNM, TEZPUR, ASSAM		

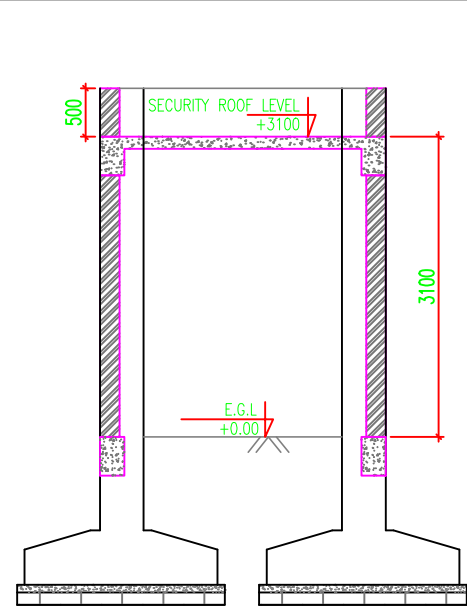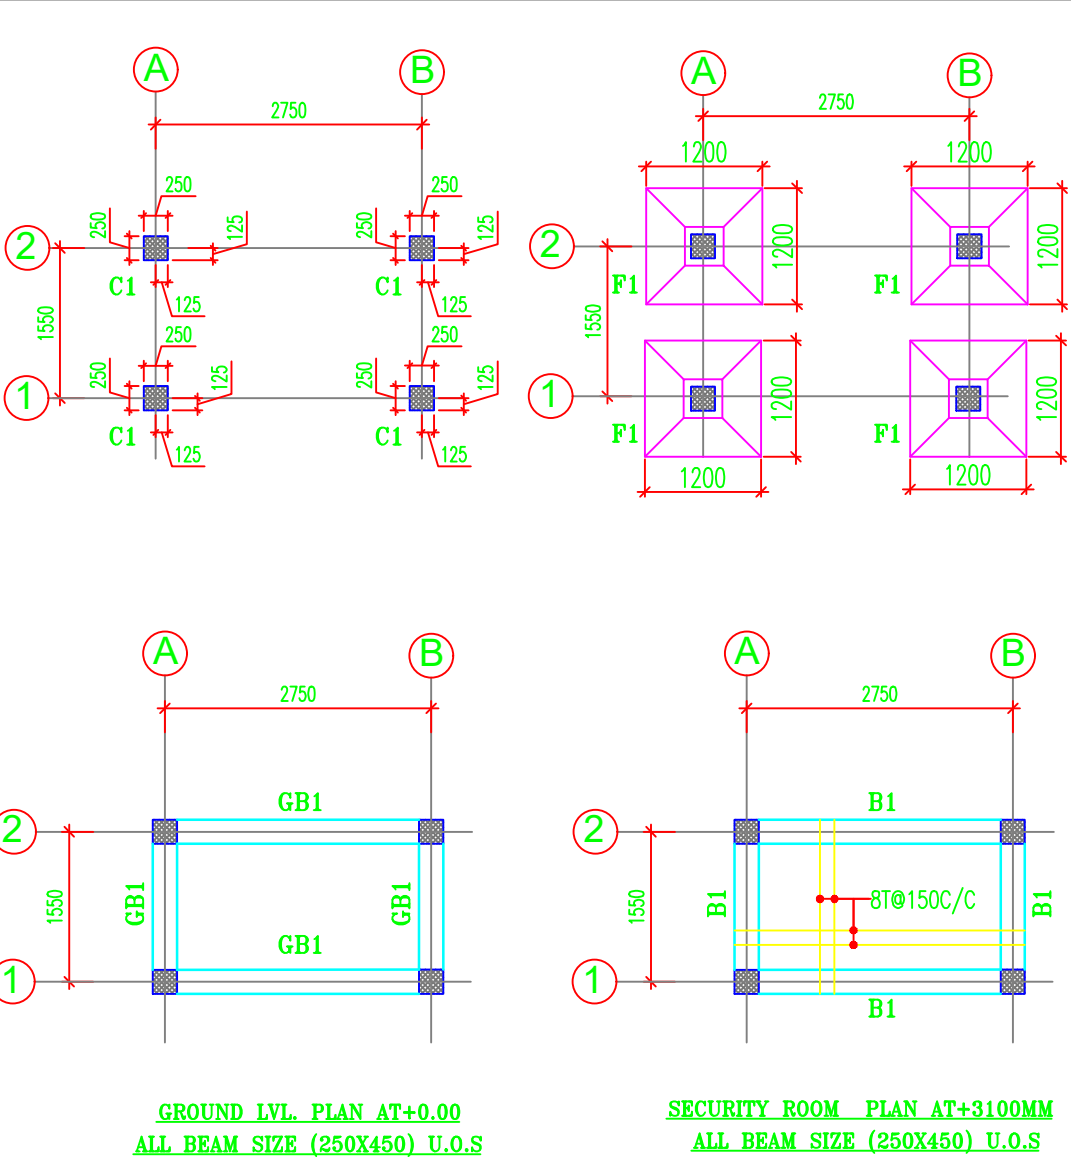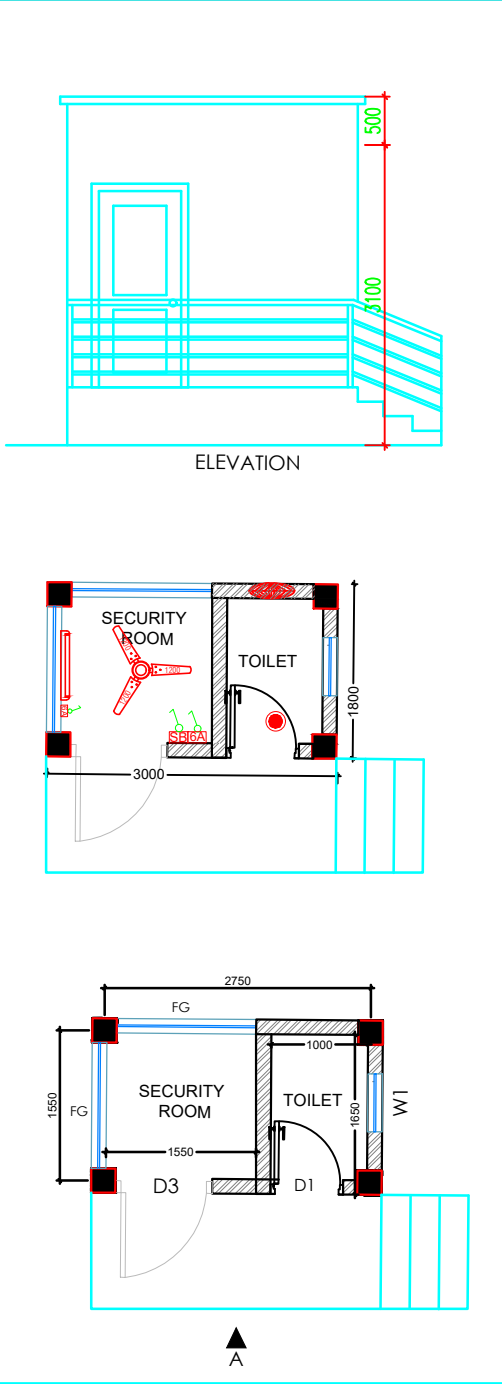

SECTION 1-1

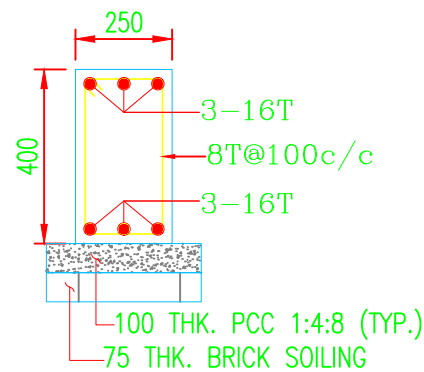


GROUND BEAM (GB1)

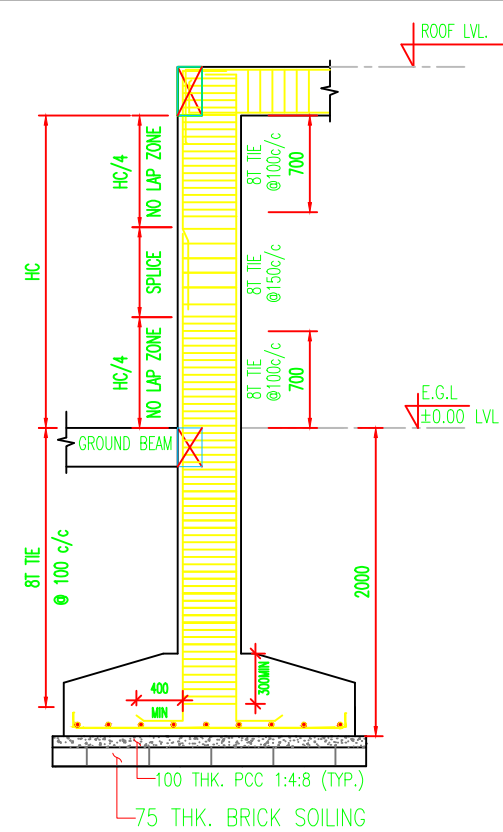

TYPICAL LONG SECTION
OF COLUMN WITH TIES
HC= COLUMN HEIGHT


FOUNDATION TO ROOF FLOOR LVL.	SECTION	
	TIES/SET	a+2b (G1)
	REINF.	4-16T
	COLUMN SIZE	250x250
	MIX.	M-25
LEVELS MARKED		C-1

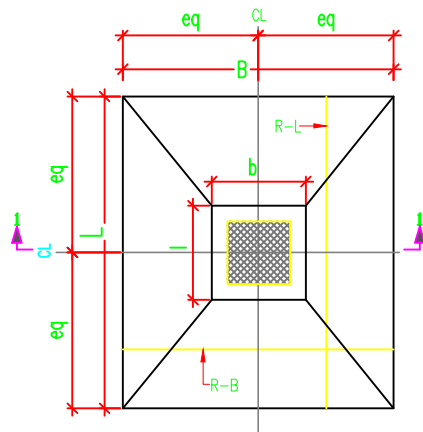

TYPICAL PLAN OF ISOLATED FOOTING

SCHEDULE OF ISOLATED FOOTINGS

FOOTING NO.	FOOTING SIZE				DEPTH OF FOOTING		REINFORCEMENT	
	L	B	l	b	D	d	R-L	R-B
F1	1200	1200	400	400	450	250	12T@125c/c	12T@125c/c

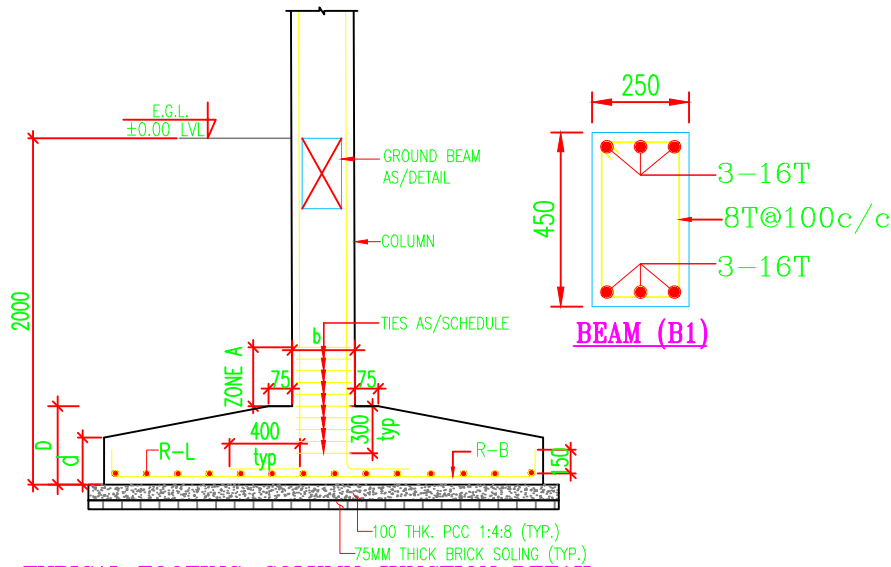

TYPICAL FOOTING-COLUMN JUNCTION DETAIL
SECTION 1-1

BEAM (B1)

NOTES:

1. ALL DIMENSIONS ARE IN MILLIMETERS.
2. THIS DRAWING SHALL BE READ WITH ALL RELEVANT ARCH. DRAWING.
3. DO NOT SCALE, FOLLOW WRITTEN DIMENSIONS ONLY.
4. ALL R.C.C. WORK SHALL BE DONE AS (IS:456) WITH LATEST AMENDMENTS.
5. STRUCTURAL DESIGN IS CARRIED OUT FOR SEISMIC ZONE-V AS PER IS:1893-2016 & IS:456-2000.
6. GRADE OF CONCRETE WILL BE M25.
7. CLEAR COVER TO REINFORCEMENT SHALL BE AS PER IS: 456-2000 WHICH ARE AS FOLLOWS :-
 - A) FOOTINGS : 50 MM
 - B) BEAMS : 30 MM
 - C) SLAB : 20 MM
 - D) COLUMN : 40 MM
8. ANY DISCREPANCY IN DIMENSIONS SHALL BE BROUGHT TO THE NOTICE OF ARCHITECT & ENGINEER BEFORE START OF WORK.
9. HIGH YIELD STRENGTH DEFORMED BARS WITH CHARACTERISTIC STRENGTH OF 500N/Sqmm, CONFORMING TO (IS:1786-1985) SHALL BE USED (TMT STEEL).
10. NOT MORE THAN 50% OF BARS SHALL BE SPLICED AT ONE SECTION.
11. LAP LENGTH FOR HIGH YIELD STRENGTH DEFORMED BARS SHALL AS PER IS:456.
BARS IN COMPRESSION $40 \times d$
BARS IN TENSION $50 \times d$
WHERE d IS BAR DIAMETER.
12. E.G.L. INDICATES EXISTING GROUND LEVEL.
13. F.G.L. INDICATES FINISHED GROUND LEVEL.
14. IN ALL THE BEAMS, WHERE THERE ARE TWO ROWS OF BARS, EITHER IN TOP OR IN BOTTOM BARS, THE BARS IN EACH SPACING OF 25MM BY PROVISION OF 25MM SPACER BAR.
15. WELL COMPACTED EARTH UP TO 93% STANDARD PROCTOR DENSITY REQUIRED BELOW THE FOUNDATION & FLOOR LVL.
16. THE ASSUMED BEARING CAPACITY OF SOIL IS TAKEN TO 12 MT/SM AT A DEPTH OF 2.5 METRES BELOW E.G.L. AS PER GEO-TECHNICAL INVESTIGATION REPORT. SOIL CAPACITY NEEDS TO BE CONFIRMED BY CONDUCTING A PLATE-LOAD TEST.

PROPOSED LEGEND:

	6A POWER POINT
	SWITCH BOARD
	20W LED TUBELIGHT
	1200 MM CEILING FAN
	12W DOWNLIGHT
	300 MM EXHAUST FAN

PROJECT:-

ASSAM STATE SECONDARY HEALTHCARE INITIATIVE FOR SERVICE DELIVERY TRANSFORMATION (ASSIST)

CLIENT:-

ASSAM HEALTH INFRASTRUCTURE DEVELOPMENT & MANAGEMENT SOCIETY (AHIDMS)

PRINCIPAL CONSULTANT:



PRITHVI GREENS, BLOCK A GROUND FLOOR
PATHARQUARY GUWAHATI-781171, ASSAM
M: +91-9401727143

STAGE:-

DPR

DRAWING NO:-

2024/ASSIST-GNM/TEZ/SECURITY /01

START DATE

ISSUE DATE

SHEET SIZE

05-04-2025

A3

PROJECT CODE:-


2024/ASSIST-ANM/TEZ

SCALE:-


N.T.S.

DRAWING TITLE:-

PROPOSED SECURITY BOOTH
DETAIL, GNM, TEZPUR, ASSAM

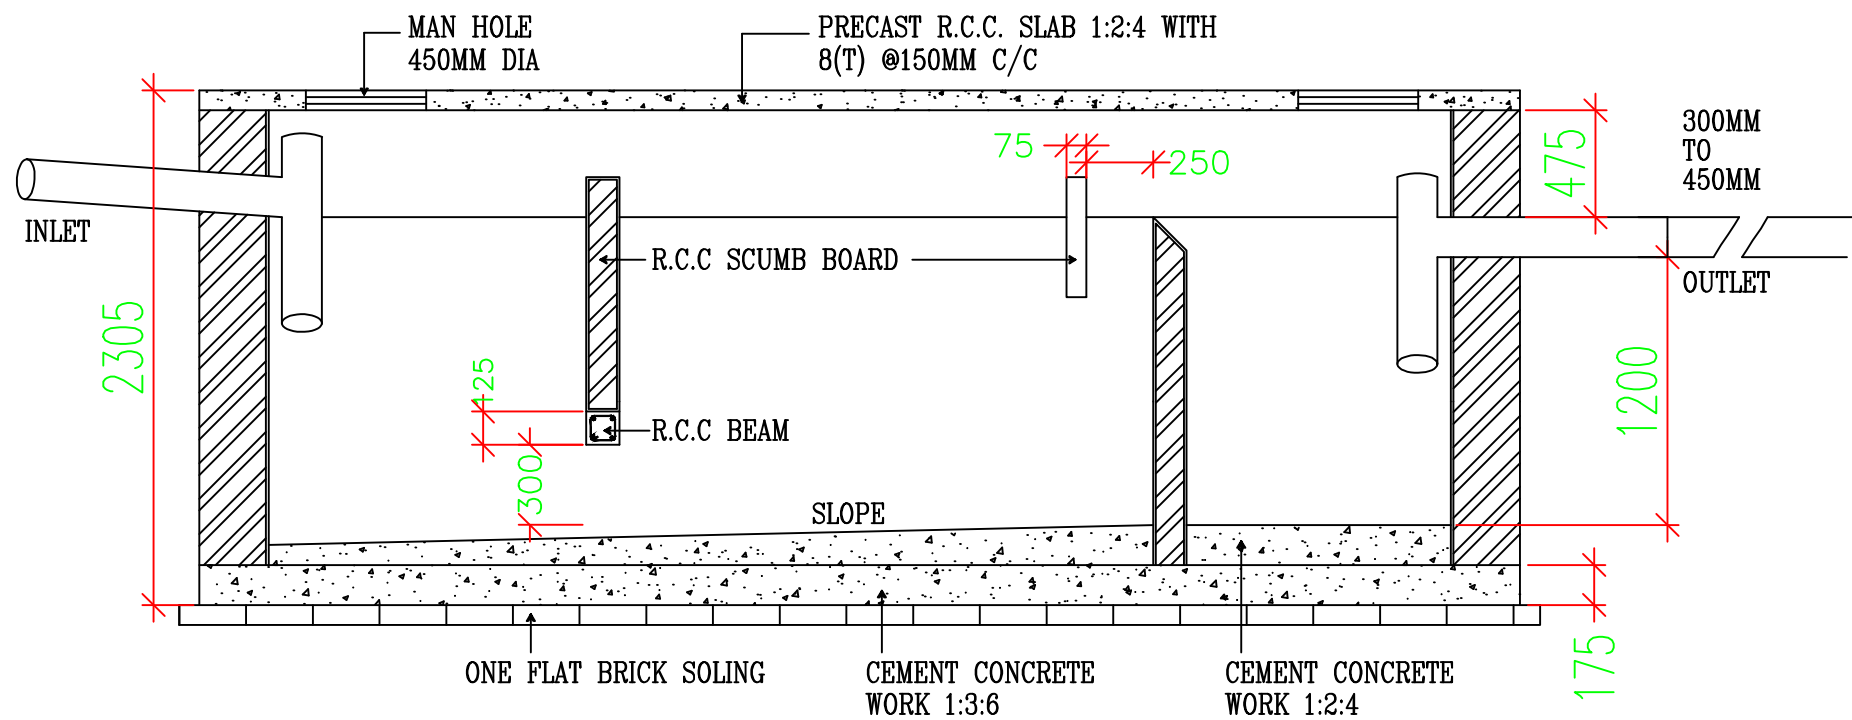

SECTION A-A
SCALE 1:25

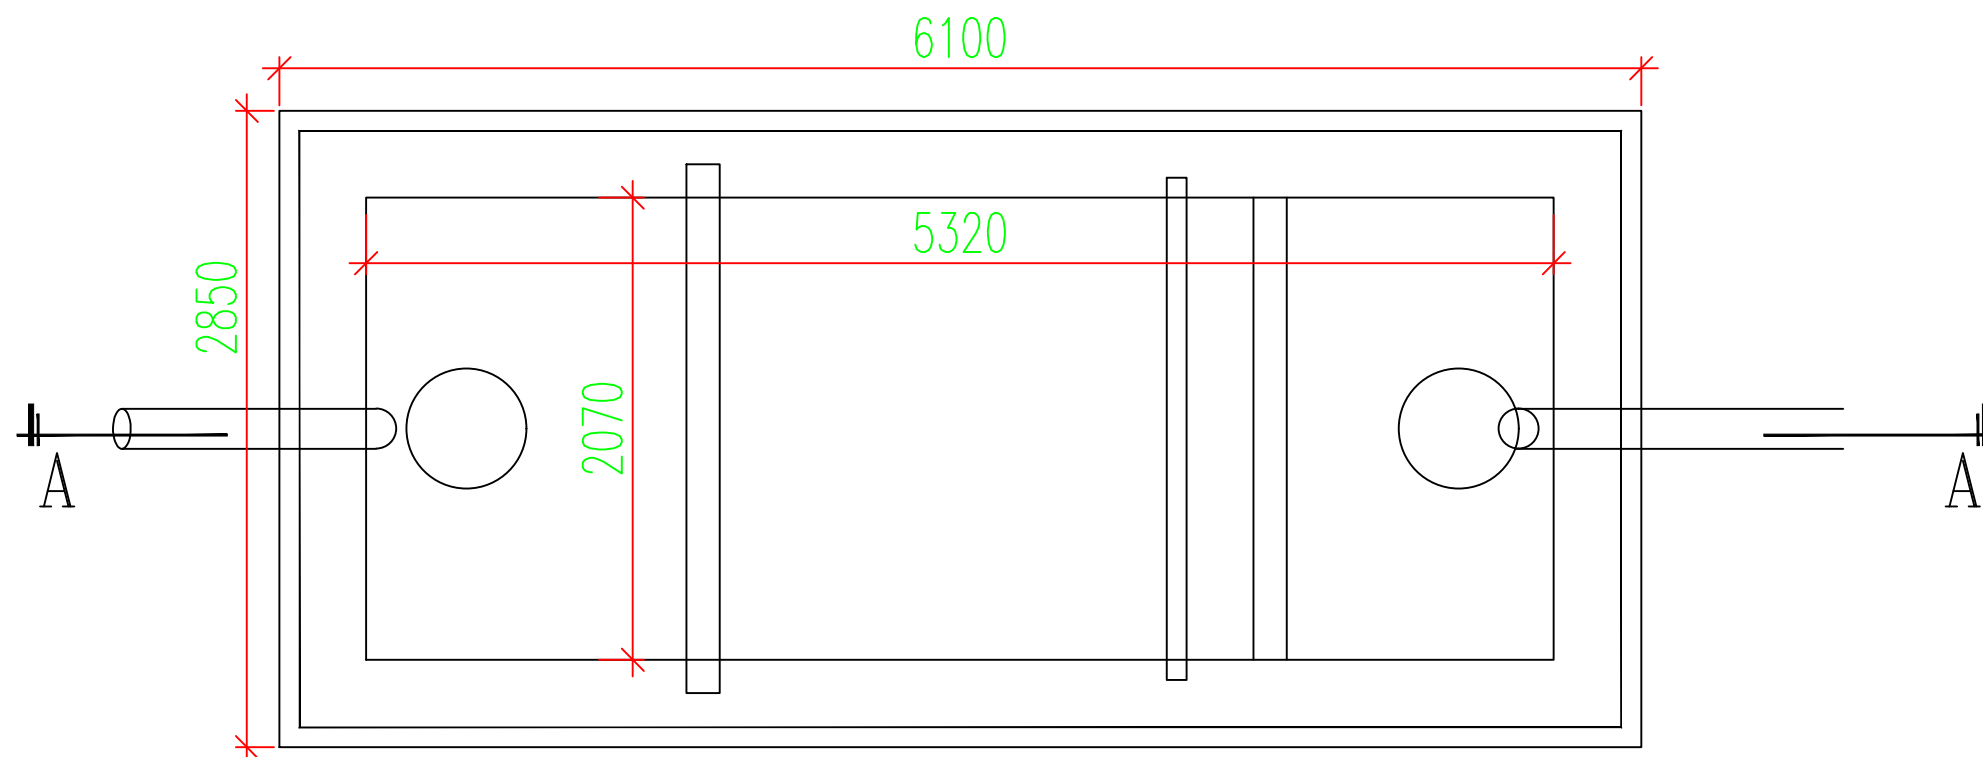

PLAN OF SEPTIC TANK
SCALE 1:25

PROJECT:-
ASSAM STATE SECONDARY HEALTHCARE
INITIATIVE FOR SERVICE DELIVERY
TRANSFORMATION (ASSIST)

CLIENT:-
ASSAM HEALTH INFRASTRUCTURE
DEVELOPMENT & MANAGEMENT SOCIETY
(AHIDMS)

PRINCIPAL CONSULTANT:

**INTEGRA VENTURES**
HEALTHCARE | INFRASTRUCTURE | CONSULTANCY
SOLUTIONS | PROJECTS | SERVICES

PRITHVI GREENS, BLOCK A GROUND FLOOR
PATHARQUARY GUWAHATI-781171, ASSAM
M: +91-9401727143

STAGE:-	DPR
---------	-----

DRAWING NO:- 2024/ASSIST-GNM/TEZ/SEPTIC TANK/01
--

START DATE	ISSUE DATE	SHEET SIZE
	05-04-2025	A3

PROJECT CODE:-	2024/ASSIST-GNM/TEZ
----------------	---------------------

SCALE:-	N.T.S.
---------	--------

DRAWING TITLE:-

SEPTIC TANK DETAIL, GNM,
TEZPUR, ASSAM