



INTEGRA VENTURES

HEALTHCARE | INFRASTRUCTURE | CONSULTANCY
solutions projects services

Drawing of Karimganj Civil Hospital, Karimganj, Assam (200 Bedded)



Submitted by- INTEGRA VENTURES

**Prithvi Greens, Block A, Ground Floor, Pathar Quarry
Guwahati: 781171, Assam, India**

Branches

KOLKATA|DELHI|BENGALURU|NAIROBI|SAMARQAND

LIST OF DRAWINGS			
KARIMGANJ CIVIL HOSPITAL, KARIMGANJ, ASSAM			
Sl No.	Drawing Name	Drawing Number	No
1	Site Plan-As Built	2024/ASSIST-KAR/DH/AR/AS BUILT/SITE/01	1
2	Site Plan-Proposed	2024/ASSIST-KAR/DH/AR/PROP/SITE/01	1
3	Service Plan-Proposed	2024/ASSIST-KAR/DH/AR/SERVICE/01	1
4	Civil-As Built	2024/ASSIST-KAR/DH/AR/AS BUILT/01/GF	1
		2024/ASSIST-KAR/DH/AR/AS BUILT/01/FF	1
		2024/ASSIST-KAR/DH/AR/AS BUILT/01/SF	1
		2024/ASSIST-KAR/DH/AR/AS BUILT/01/TF	1
		2024/ASSIST-KAR/DH/AR/AS BUILT/02/GF	1
		2024/ASSIST-KAR/DH/AR/AS BUILT/02/FF	1
		2024/ASSIST-KAR/DH/AR/AS BUILT/02/SF	1
		2024/ASSIST-KAR/DH/AR/AS BUILT/02/TF	1
		2024/ASSIST-KAR/DH/AR/AS BUILT/03	1
5	Main Gate & security booth	2024/ASSIST-KAR/DH/MAIN GATE/01	1
		2024/ASSIST-KAR/DH/MAIN GATE/02	1
		2024/ASSIST-KAR/DH/SEC/E/01	1
6	Road	2024/ASSIST-KAR/DH/ROAD/01	1
7	Drain	2024/ASSIST-KAR/DH/DRAIN/01	1
8	Boundary Wall	2024/ASSIST-KAR/DH/B-WALL/01	1
9	10 KLD ETP	2024/ASSIST-KAR/DH/ETP/01	1
10	70 KLD STP	2024/ASSIST-KAR/DH/STP/01	1
11	Plumbing	2024/ASSIST-KAR/DH/P/PROP/01/GF	1
		2024/ASSIST-KAR/DH/P/PROP/01/FF	1
		2024/ASSIST-KAR/DH/P/PROP/01/SF	1
		2024/ASSIST-KAR/DH/P/PROP/01/TF	1
		2024/ASSIST-KAR/DH/P/PROP/02/GF	1
		2024/ASSIST-KAR/DH/P/PROP/02/FF	1
		2024/ASSIST-KAR/DH/P/PROP/02/SF	1
		2024/ASSIST-KAR/DH/P/PROP/02/TF	1
		2024/ASSIST-KAR/DH/P/PROP/03	1
12	Electrical Internal	2024/ASSIST-KAR/DH/E/PROP/01/GF	1
		2024/ASSIST-KAR/DH/E/PROP/01/FF	1
		2024/ASSIST-KAR/DH/E/PROP/01/SF	1
		2024/ASSIST-KAR/DH/E/PROP/01/TF	1
		2024/ASSIST-KAR/DH/E/PROP/02/GF	1
		2024/ASSIST-KAR/DH/E/PROP/02/FF	1
		2024/ASSIST-KAR/DH/E/PROP/02/SF	1
		2024/ASSIST-KAR/DH/E/PROP/02/TF	1
		2024/ASSIST-KAR/DH/E/PROP/03	1
13	Electrical External-Proposed	2024/ASSIST-KAR/DH/EE/PROP/01	1
14	CCTV, PA SYSTEM, FIRE DETECTION, LVS	2024/ASSIST-KAR/DH/ELV/01/GF	1
		2024/ASSIST-KAR/DH/ELV/01/FF	1
		2024/ASSIST-KAR/DH/ELV/01/SF	1
		2024/ASSIST-KAR/DH/ELV/01/TF	1
		2024/ASSIST-KAR/DH/ELV/02/GF	1
		2024/ASSIST-KAR/DH/ELV/02/FF	1
		2024/ASSIST-KAR/DH/ELV/02/SF	1
		2024/ASSIST-KAR/DH/ELV/02/TF	1
		2024/ASSIST-KAR/DH/ELV/03	1
15	Fire Protection-Proposed	2024/ASSIST-KAR/DH/FF/PROP/01	1
16	UGR	2024/ASSIST-KAR/DH/UGR/PROP/01	1
17	MGPS	2024/ASSIST-KAR/DH/MGPS/PROP/01/GF	1
		2024/ASSIST-KAR/DH/MGPS/PROP/01/FF	1
		2024/ASSIST-KAR/DH/MGPS/PROP/01/SF	1
		2024/ASSIST-KAR/DH/MGPS/PROP/01/TF	1
		2024/ASSIST-KAR/DH/MGPS/PROP/02/GF	1
		2024/ASSIST-KAR/DH/MGPS/PROP/02/FF	1
		2024/ASSIST-KAR/DH/MGPS/PROP/02/SF	1
		2024/ASSIST-KAR/DH/MGPS/PROP/02/TF	1
18	HVAC	2024/ASSIST-KAR/DH/HVAC/PROP/01/GF	1
		2024/ASSIST-KAR/DH/HVAC/PROP/01/FF	1
		2024/ASSIST-KAR/DH/HVAC/PROP/01/SF	1
		2024/ASSIST-KAR/DH/HVAC/PROP/01/TF	1
		2024/ASSIST-KAR/DH/HVAC/PROP/02/GF	1
		2024/ASSIST-KAR/DH/HVAC/PROP/02/FF	1
		2024/ASSIST-KAR/DH/HVAC/PROP/02/SF	1
		2024/ASSIST-KAR/DH/HVAC/PROP/02/TF	1
		2024/ASSIST-KAR/DH/HVAC/PROP/03	1



LEGEND	
Road	
Boundary line	
Drain	
Tree	
Proposed	

PROJECT:- ASSAM STATE SECONDARY HEALTHCARE INITIATIVE FOR SERVICE DELIVERY TRANSFORMATION (ASSIST)		
CLIENT:- ASSAM HEALTH INFRASTRUCTURE DEVELOPMENT & MANAGEMENT SOCIETY (AHIDMS)		
PRINCIPAL CONSULTANT:  INTEGRA VENTURES HEALTHCARE INFRASTRUCTURE CONSULTANTS DESIGN PROJECT OPERATE PRITHVI GREENS, BLOCK A-GROUND FLOOR PATHARQUARY GUMHATI-781171, ASSAM M: +91-9401727143		
STAGE:-	DPR	
DRAWING NO:- 2024/ASSIST-KAR/DH/AR/AS BUILT/SITE/01		
START DATE	ISSUE DATE	SHEET SIZE
	10-02-2025	A2
PROJECT CODE:-	2024/ASSIST-KAR/DH	
SCALE:-	N.T.S.	
DRAWING TITLE:- SITE PLAN AS BUILT, KARIMGANJ CIVIL HOSPITAL, KARIMGANJ, ASSAM		



PROJECT:-
ASSAM STATE SECONDARY HEALTHCARE
INITIATIVE FOR SERVICE DELIVERY
TRANSFORMATION (ASSIST)

CLIENT:-
ASSAM HEALTH INFRASTRUCTURE
DEVELOPMENT & MANAGEMENT SOCIETY
(AHIDMS)

PRINCIPAL CONSULTANT:-
**INTEGRA VENTURES**
HEALTHCARE INFRASTRUCTURE CONSULTANCY
PRITHVI GREENS, BLOCK-A GROUND FLOOR
PATHARQUARY GUWAHATI-781071, ASSAM
M: +91-9401727143

STAGE:- DPR

DRAWING NO:-
2024/ASSIST-KAR/DH/AR/PROP/SITE/01

START DATE	ISSUE DATE	SHEET SIZE
	10-02-2025	A2

PROJECT CODE:- 2024/ASSIST-KAR/DH

SCALE:- N.T.S.

DRAWING TITLE:-

SITE PLAN PROPOSED,
KARIMGANJ CIVIL HOSPITAL, KARIMGANJ,
ASSAM.


LEGEND

Road	
Boundary line	
Drain	
Tree	
Proposed	



LEGEND	
Road	
Boundary line	
Drain	
Tree	
Proposed	

PROJECT:- ASSAM STATE SECONDARY HEALTHCARE INITIATIVE FOR SERVICE DELIVERY TRANSFORMATION (ASSIST)		
CLIENT:- ASSAM HEALTH INFRASTRUCTURE DEVELOPMENT & MANAGEMENT SOCIETY (AHIDMS)		
PRINCIPAL CONSULTANT:  INTEGRA VENTURES HEALTHCARE INFRASTRUCTURE CONSULTANCY PRITHVI GREENS, BLOCK A GROUND FLOOR PATHARQUARY GUWAHATI-781011, ASSAM M: +91-8401727143		
STAGE:-	DPR	
DRAWING NO:- 2024/ASSIST-KAR/DH/AR/SERVICE/01		
START DATE	ISSUE DATE	SHEET SIZE
	10-02-2025	A2
PROJECT CODE:-	2024/ASSIST-KAR/DH	
SCALE:-	N.T.S.	
DRAWING TITLE:- SERVICE PLAN PROPOSED, KARIMGANJ CIVIL HOSPITAL, KARIMGANJ, ASSAM		

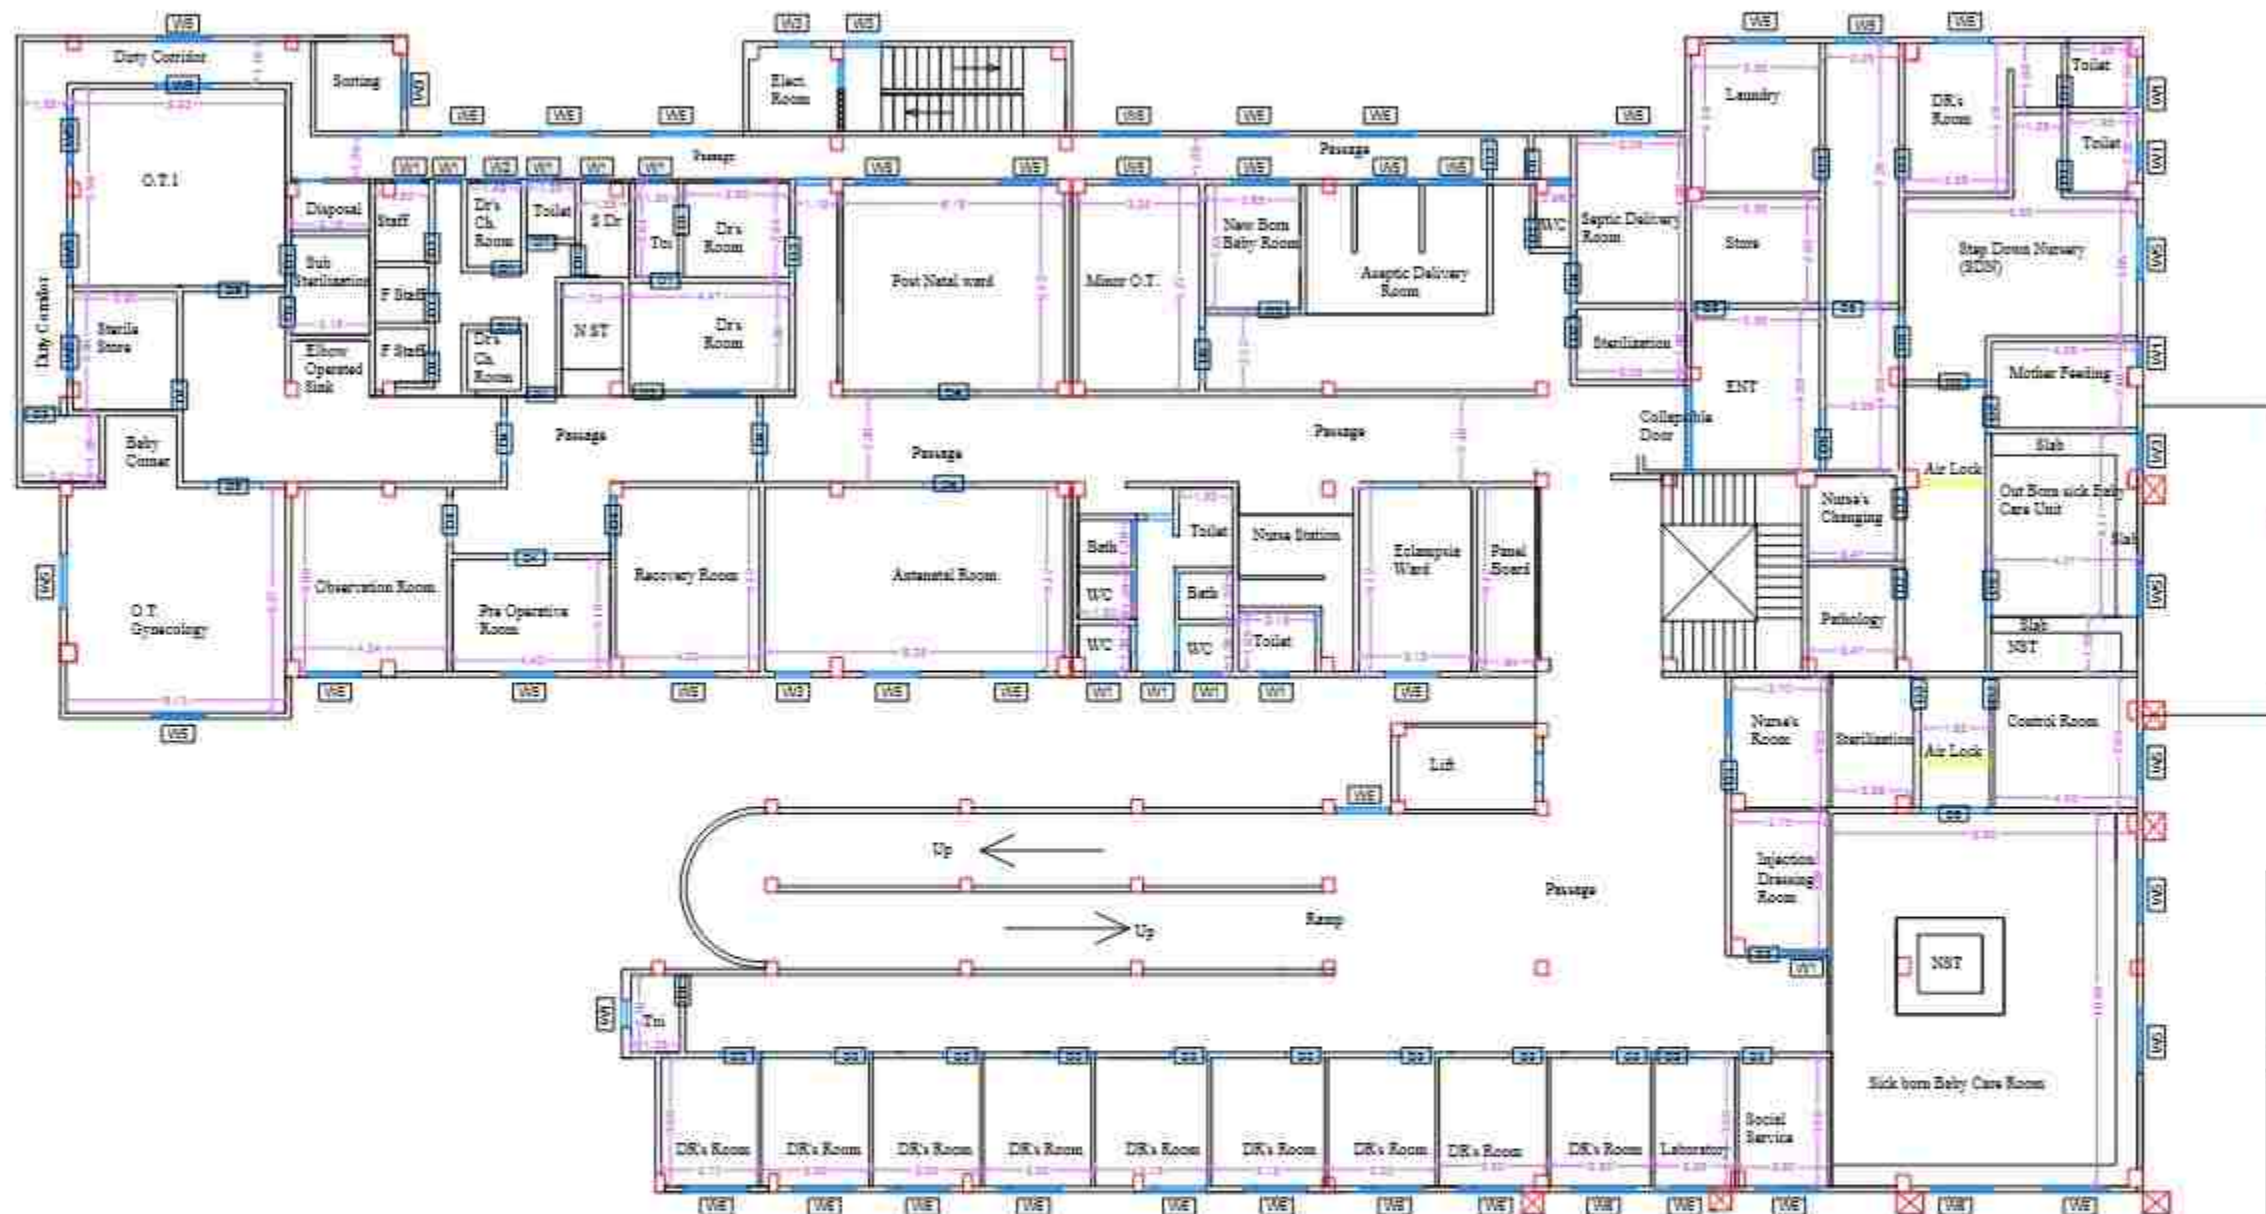

DOOR SCHEDULE:-

SNO	NAME	WIDTH	HEIGHT	REMARKS
1.	D1	0.75	2.00	SINGLE PANEL DOOR
2.	D2	0.90	2.00	SINGLE PANEL DOOR
3.	D3	1.05	2.00	SINGLE PANEL DOOR
4.	D4	1.20	2.00	SINGLE PANEL DOOR
4.	D4c	1.20	2.00	DOUBLE PANEL DOOR
5.	D5	1.50	2.00	DOUBLE PANEL DOOR
6.	D6	1.80	2.00	DOUBLE PANEL DOOR
7.	D7	2.00	2.00	DOUBLE PANEL DOOR


WINDOW SCHEDULE:-

SNO	NAME	SILL	WIDTH	HEIGHT	REMARKS
1.	W1	1.40	0.60	0.60	SINGLE PANEL WINDOW
2.	W2	0.70	0.90	1.30	SINGLE PANEL WINDOW
3.	W3	0.70	1.05	1.30	SINGLE PANEL WINDOW
4.	W4	0.70	1.20	1.30	DOUBLE PANEL WINDOW
5.	W5	0.70	1.50	1.30	DOUBLE PANEL WINDOW
6.	W6	0.70	1.80	1.30	DOUBLE PANEL WINDOW
7.	W7	0.70	2.00	1.30	DOUBLE PANEL WINDOW

PROJECT:-
ASSAM STATE SECONDARY HEALTHCARE
INITIATIVE FOR SERVICE DELIVERY
TRANSFORMATION (ASSIST)

CLIENT:-
ASSAM HEALTH INFRASTRUCTURE
DEVELOPMENT & MANAGEMENT SOCIETY
(AHIDMS)

 PRINCIPAL CONSULTANT:-



STAGE:- DPR

DRAWING NO:-
2024/ASSIST-KAR/DH/AR/AS BUILT/01/FF

START DATE	ISSUE DATE	SHEET SIZE
	10-02-2025	A3

PROJECT CODE:- 2024/ASSIST-KAR/DH

SCALE:- N.T.S.

BLOCK NO:- 1

FLOOR:- FIRST FLOOR

DRAWING TITLE:-

BLOCK 1 AS BUILT FIRST FLOOR PLAN,
KARIMGANJ CIVIL HOSPITAL, KARIMGANJ,
ASSAM



DOOR SCHEDULE -

SNO	NAME	WIDTH	HEIGHT	REMARKS
1	D1	0.75	2.00	SINGLE PANEL DOOR
2	D2	0.90	2.00	SINGLE PANEL DOOR
3	D3	1.58	2.00	SINGLE PANEL DOOR
4	D4	1.20	2.00	SINGLE PANEL DOOR
4	D4a	1.20	2.00	DOUBLE PANEL DOOR
5	D5	1.80	2.00	DOUBLE PANEL DOOR
6	D6	1.80	2.00	DOUBLE PANEL DOOR
7	D7	2.50	2.00	DOUBLE PANEL DOOR


WINDOW SCHEDULE -

SNO	NAME	SILL	WIDTH	HEIGHT	REMARKS
1	W1	1.40	0.60	0.60	SINGLE PANEL WINDOW
2	W2	0.70	0.90	1.30	SINGLE PANEL WINDOW
3	W3	0.70	1.05	1.30	SINGLE PANEL WINDOW
4	W4	0.70	1.25	1.30	DOUBLE PANEL WINDOW
5	W5	0.70	1.50	1.30	DOUBLE PANEL WINDOW
6	W6	0.70	1.80	1.30	DOUBLE PANEL WINDOW
7	W7	0.70	2.50	1.30	DOUBLE PANEL WINDOW

PROJECT:-
ASSAM STATE SECONDARY HEALTHCARE
INITIATIVE FOR SERVICE DELIVERY
TRANSFORMATION (ASSIST)

CLIENT:-
ASSAM HEALTH INFRASTRUCTURE
DEVELOPMENT & MANAGEMENT SOCIETY
(AHIDMS)

 PRINCIPAL CONSULTANT:-



INTEGRA VENTURES
Architects, Engineers, Planners & Interiors
PVT. LTD.

STAGE - DPR

DRAWING NO:-
2014/ASSIST-KAR/DH/AR/AS BUILT/01/GF

START DATE	ISSUE DATE	SHEET SIZE
	10-02-2025	A3

PROJECT CODE:- 2014/ASSIST-KAR/DH


SCALE:- N.T.S.

BLOCK NO:- I

FLOOR:- GROUND FLOOR

DRAWING TITLE:-

**BLOCK I AS BUILT GROUND FLOOR PLAN,
KARIMGANJ CIVIL HOSPITAL, KARIMGANJ,
ASSAM**

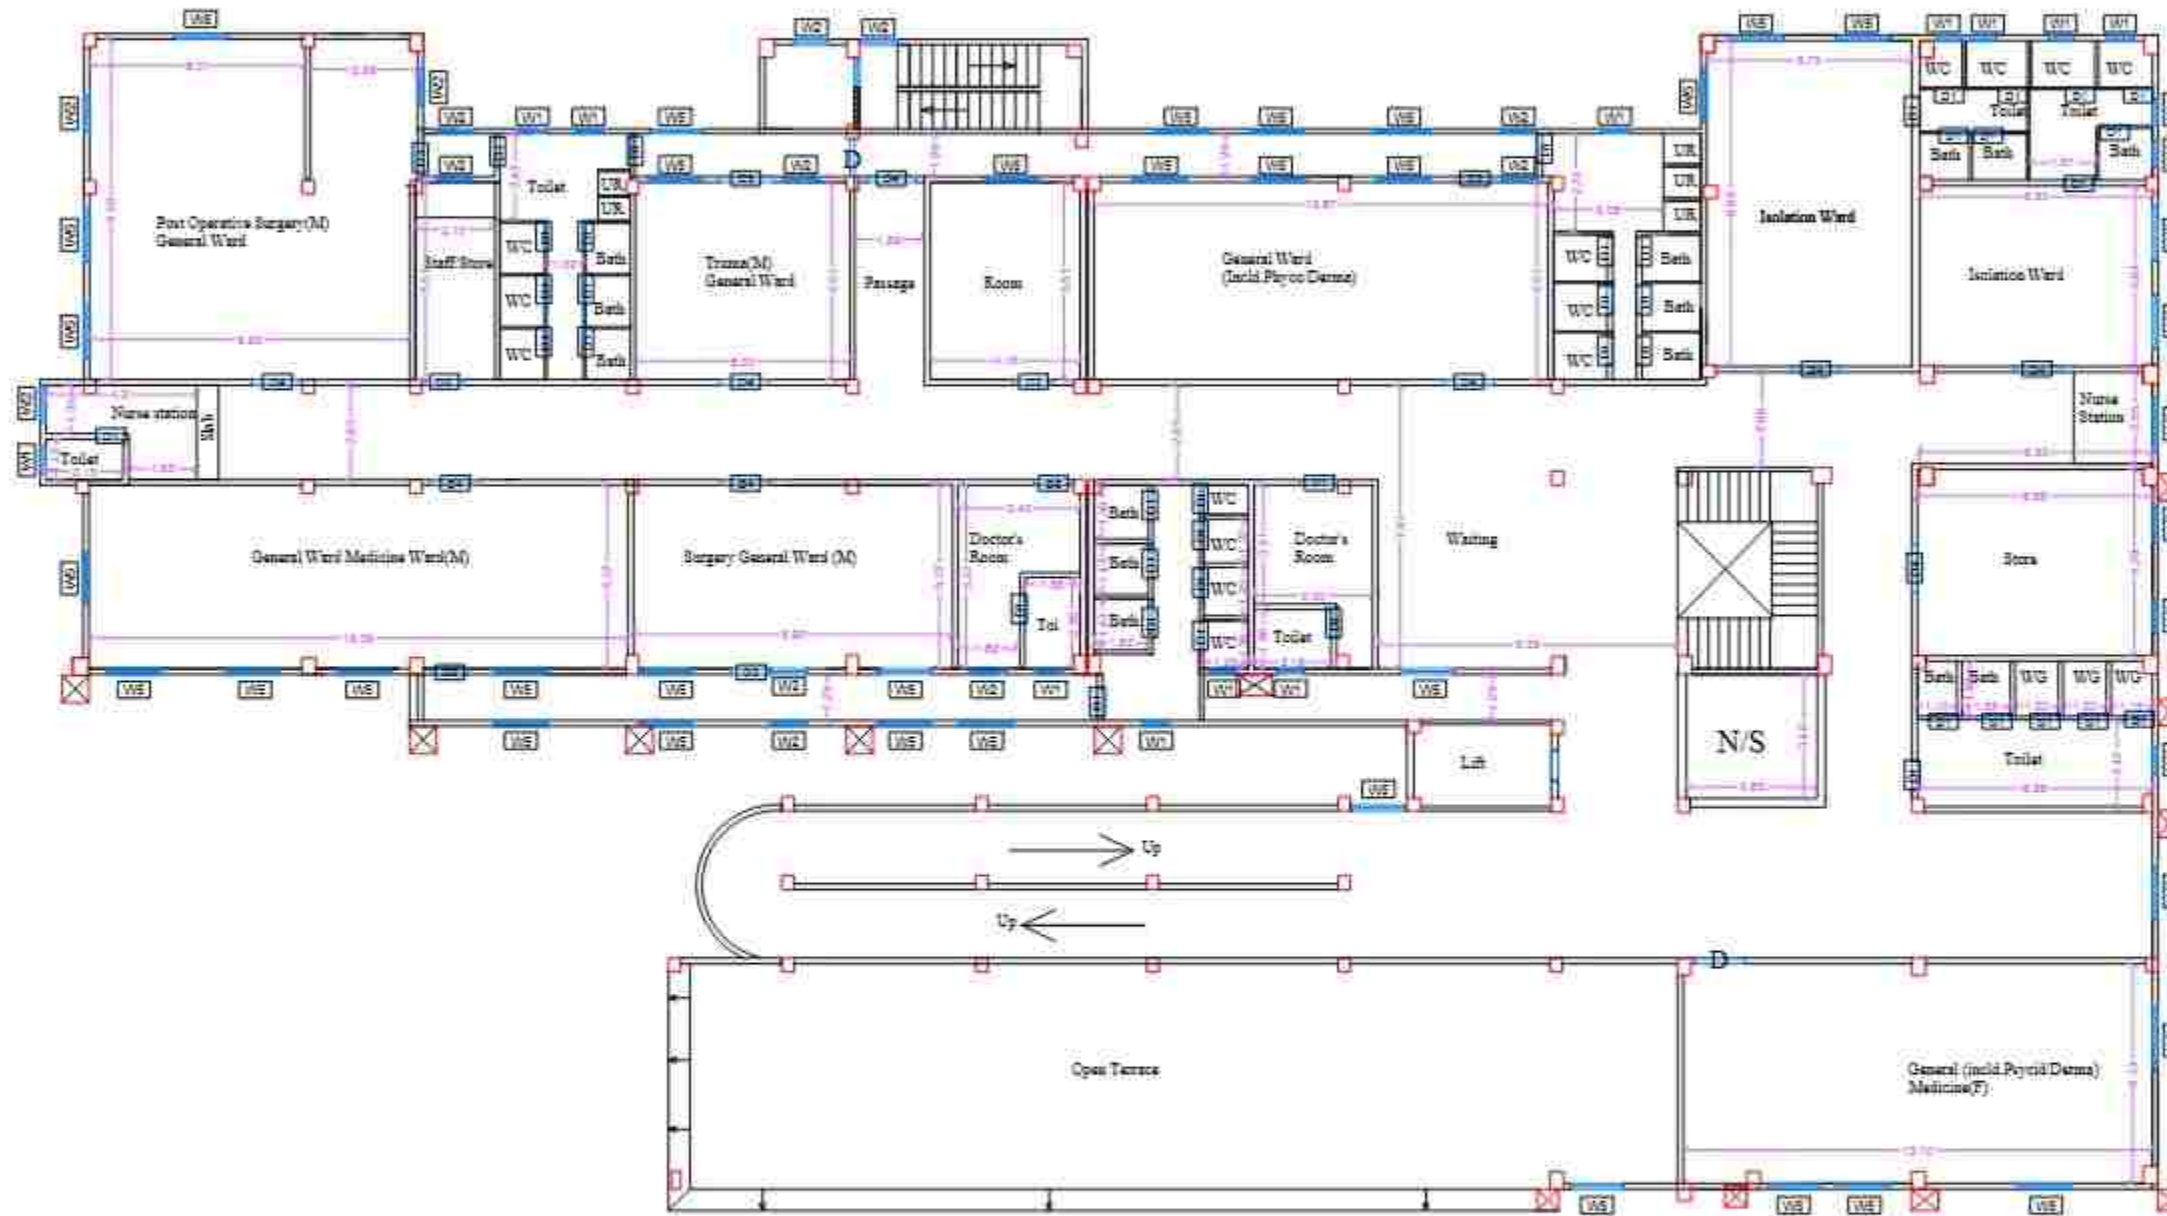

DOOR SCHEDULE:-

SNO	NAME	WIDTH	HEIGHT	REMARKS
1	D1	0.75	2.00	SINGLE PANEL DOOR
2	D2	0.90	2.00	SINGLE PANEL DOOR
3	D3	1.05	2.00	SINGLE PANEL DOOR
4	D4	1.20	2.00	SINGLE PANEL DOOR
4	D4d	1.20	2.00	DOUBLE PANEL DOOR
5	D5	1.50	2.00	DOUBLE PANEL DOOR
6	D6	1.80	2.00	DOUBLE PANEL DOOR
7	D7	2.00	2.00	DOUBLE PANEL DOOR

WINDOW SCHEDULE:-

SNO	NAME	SILL	WIDTH	HEIGHT	REMARKS
1	W1	1.40	0.80	0.80	SINGLE PANEL WINDOW
2	W2	0.70	0.90	1.30	SINGLE PANEL WINDOW
3	W3	0.70	1.05	1.30	SINGLE PANEL WINDOW
4	W4	0.70	1.20	1.30	DOUBLE PANEL WINDOW
5	W5	0.70	1.80	1.30	DOUBLE PANEL WINDOW
6	W6	0.70	1.80	1.30	DOUBLE PANEL WINDOW
7	W7	0.70	2.00	1.30	DOUBLE PANEL WINDOW

PROJECT:-
ASSAM STATE SECONDARY HEALTHCARE
INITIATIVE FOR SERVICE DELIVERY
TRANSFORMATION (ASSIST)

CLIENT:-
ASSAM HEALTH INFRASTRUCTURE
DEVELOPMENT & MANAGEMENT SOCIETY
(AHIMS)

PRINCIPAL CONSULTANT:-



INTERIOR DESIGN, BLOCK & GROUND FLOOR
WITH ANGLARY SUBMITTALS TO IT, ASSAM
IN 10/03/2025

STAGE:- DPR

DRAWING NO:-
2024/ASSIST-KAR/DH/AR/AS BUILT/01/57

START DATE ISSUE DATE SHEET SIZE

10-03-2025 A3

PROJECT CODE:- 2024/ASSIST-KAR/DH

SCALE:- N.T.S.

BLOCK NO:- 1

FLOOR:- SECOND FLOOR

DRAWING TITLE:-

BLOCK 1 AS BUILT SECOND FLOOR PLAN,
KARIMGANJ CIVIL HOSPITAL, KARIMGANJ,
ASSAM



PROJECT:-
ASSAM STATE SECONDARY HEALTHCARE
INITIATIVE FOR SERVICE DELIVERY
TRANSFORMATION (ASST)

CLIENT:-
ASSAM HEALTH INFRASTRUCTURE
DEVELOPMENT & MANAGEMENT SOCIETY
(AHIDMS)

PRINCIPAL CONSULTANT:
INTEGRA VENTURES
PVT. LTD.
PLOT NO. 10, PHASE II, KALINGA, GUWAHATI, ASSAM
PIN-781005, TEL: 9830077777

STAGE:- DPR

DRAWING NO:-
2024-ASST-KAR CH AR AS BUILT 02 OF

START DATE: 10-02-2025 ISSUE DATE: 10-02-2025 SHEET SIZE: A3

PROJECT CODE:- 2024-ASST-KAR CH

SCALE:- N.T.S.

BLOCK NO:- 2

FLOOR:- GROUND FLOOR

DRAWING TITLE:-

BLOCK 2 AS BUILT GROUND FLOOR PLAN,
KARAMGANJ CIVIL HOSPITAL, KARIMGANJ,
ASSAM

DOOR SCHEDULE:-

SNO	NAME	WIDTH	HEIGHT	REMARKS
1	D1	0.75	2.00	SINGLE PANEL DOOR
2	D2	1.30	2.00	SINGLE PANEL DOOR
3	D3	1.00	2.00	SINGLE PANEL DOOR
4	D4	1.30	2.00	SINGLE PANEL DOOR
5	D5	1.30	2.00	DOUBLE PANEL DOOR
6	D6	1.30	2.00	DOUBLE PANEL DOOR
7	D7	1.30	2.00	DOUBLE PANEL DOOR
8	D8	1.30	2.00	DOUBLE PANEL DOOR
9	D9	1.30	2.00	DOUBLE PANEL DOOR

WINDOW SCHEDULE:-

SNO	NAME	W.D	H.D	REMARKS
1	W1	1.40	1.30	SINGLE PANEL WINDOW
2	W2	1.30	1.30	SINGLE PANEL WINDOW
3	W3	1.30	1.30	SINGLE PANEL WINDOW
4	W4	1.30	1.30	DOUBLE PANEL WINDOW
5	W5	1.30	1.30	DOUBLE PANEL WINDOW
6	W6	1.30	1.30	DOUBLE PANEL WINDOW
7	W7	1.30	1.30	DOUBLE PANEL WINDOW
8	W8	1.30	1.30	DOUBLE PANEL WINDOW

PROJECT:-
ASSAM STATE SECONDARY HEALTHCARE
INITIATIVE FOR SERVICE DELIVERY
TRANSFORMATION (ASST)

CLIENT:-
ASSAM HEALTH INFRASTRUCTURE
DEVELOPMENT & MANAGEMENT SOCIETY
(AHIMS)

PRINCIPAL CONSULTANT



PROJECT OFFICE: BLOCK 4 SECOND FLOOR
PATRASAGANJ, DISPURA, IVTL, ASSAM
781 001

STAGE:- DPR

DRAWING NO:-
1014-ASST-KAR-DH-AR-AS-BULT-03-TF

START DATE: 10-02-2023
ISSUE DATE: 10-02-2023
SHEET SIZE: A3

PROJECT CODE:- 1014-ASST-KAR-DH

SCALE:- M.T.B.

BLOCK NO:- 2

FLOOR:- THIRD FLOOR

DRAWING TITLE:-


BLOCK 2 AS BUILT THIRD FLOOR PLAN,
KARIMGANJ CIVIL HOSPITAL, KARIMGANJ,
ASSAM


DOOR SCHEDULE:-

NO.	NAME	WIDTH	HEIGHT	REMARKS
1	D1	0.75	2.00	SINGLE PANEL DOOR
2	D2	0.90	2.00	SINGLE PANEL DOOR
3	D3	1.05	2.00	SINGLE PANEL DOOR
4	D4	1.00	2.00	SINGLE PANEL DOOR
5	D5	1.00	2.00	DOUBLE PANEL DOOR
6	D6	1.80	2.00	DOUBLE PANEL DOOR
7	D7	1.80	2.00	DOUBLE PANEL DOOR
8	D8	2.00	2.00	DOUBLE PANEL DOOR

WINDOW SCHEDULE:-

NO.	NAME	W.D.	W.D.	HEIGHT	REMARKS
1	W1	1.40	0.80	0.80	SINGLE PANEL WINDOW
2	W2	0.70	0.80	1.30	SINGLE PANEL WINDOW
3	W3	0.70	1.00	1.30	SINGLE PANEL WINDOW
4	W4	0.70	1.30	1.30	DOUBLE PANEL WINDOW
5	W5	0.70	1.30	1.30	DOUBLE PANEL WINDOW
6	W6	0.70	1.80	1.30	DOUBLE PANEL WINDOW
7	W7	0.70	2.00	1.30	DOUBLE PANEL WINDOW

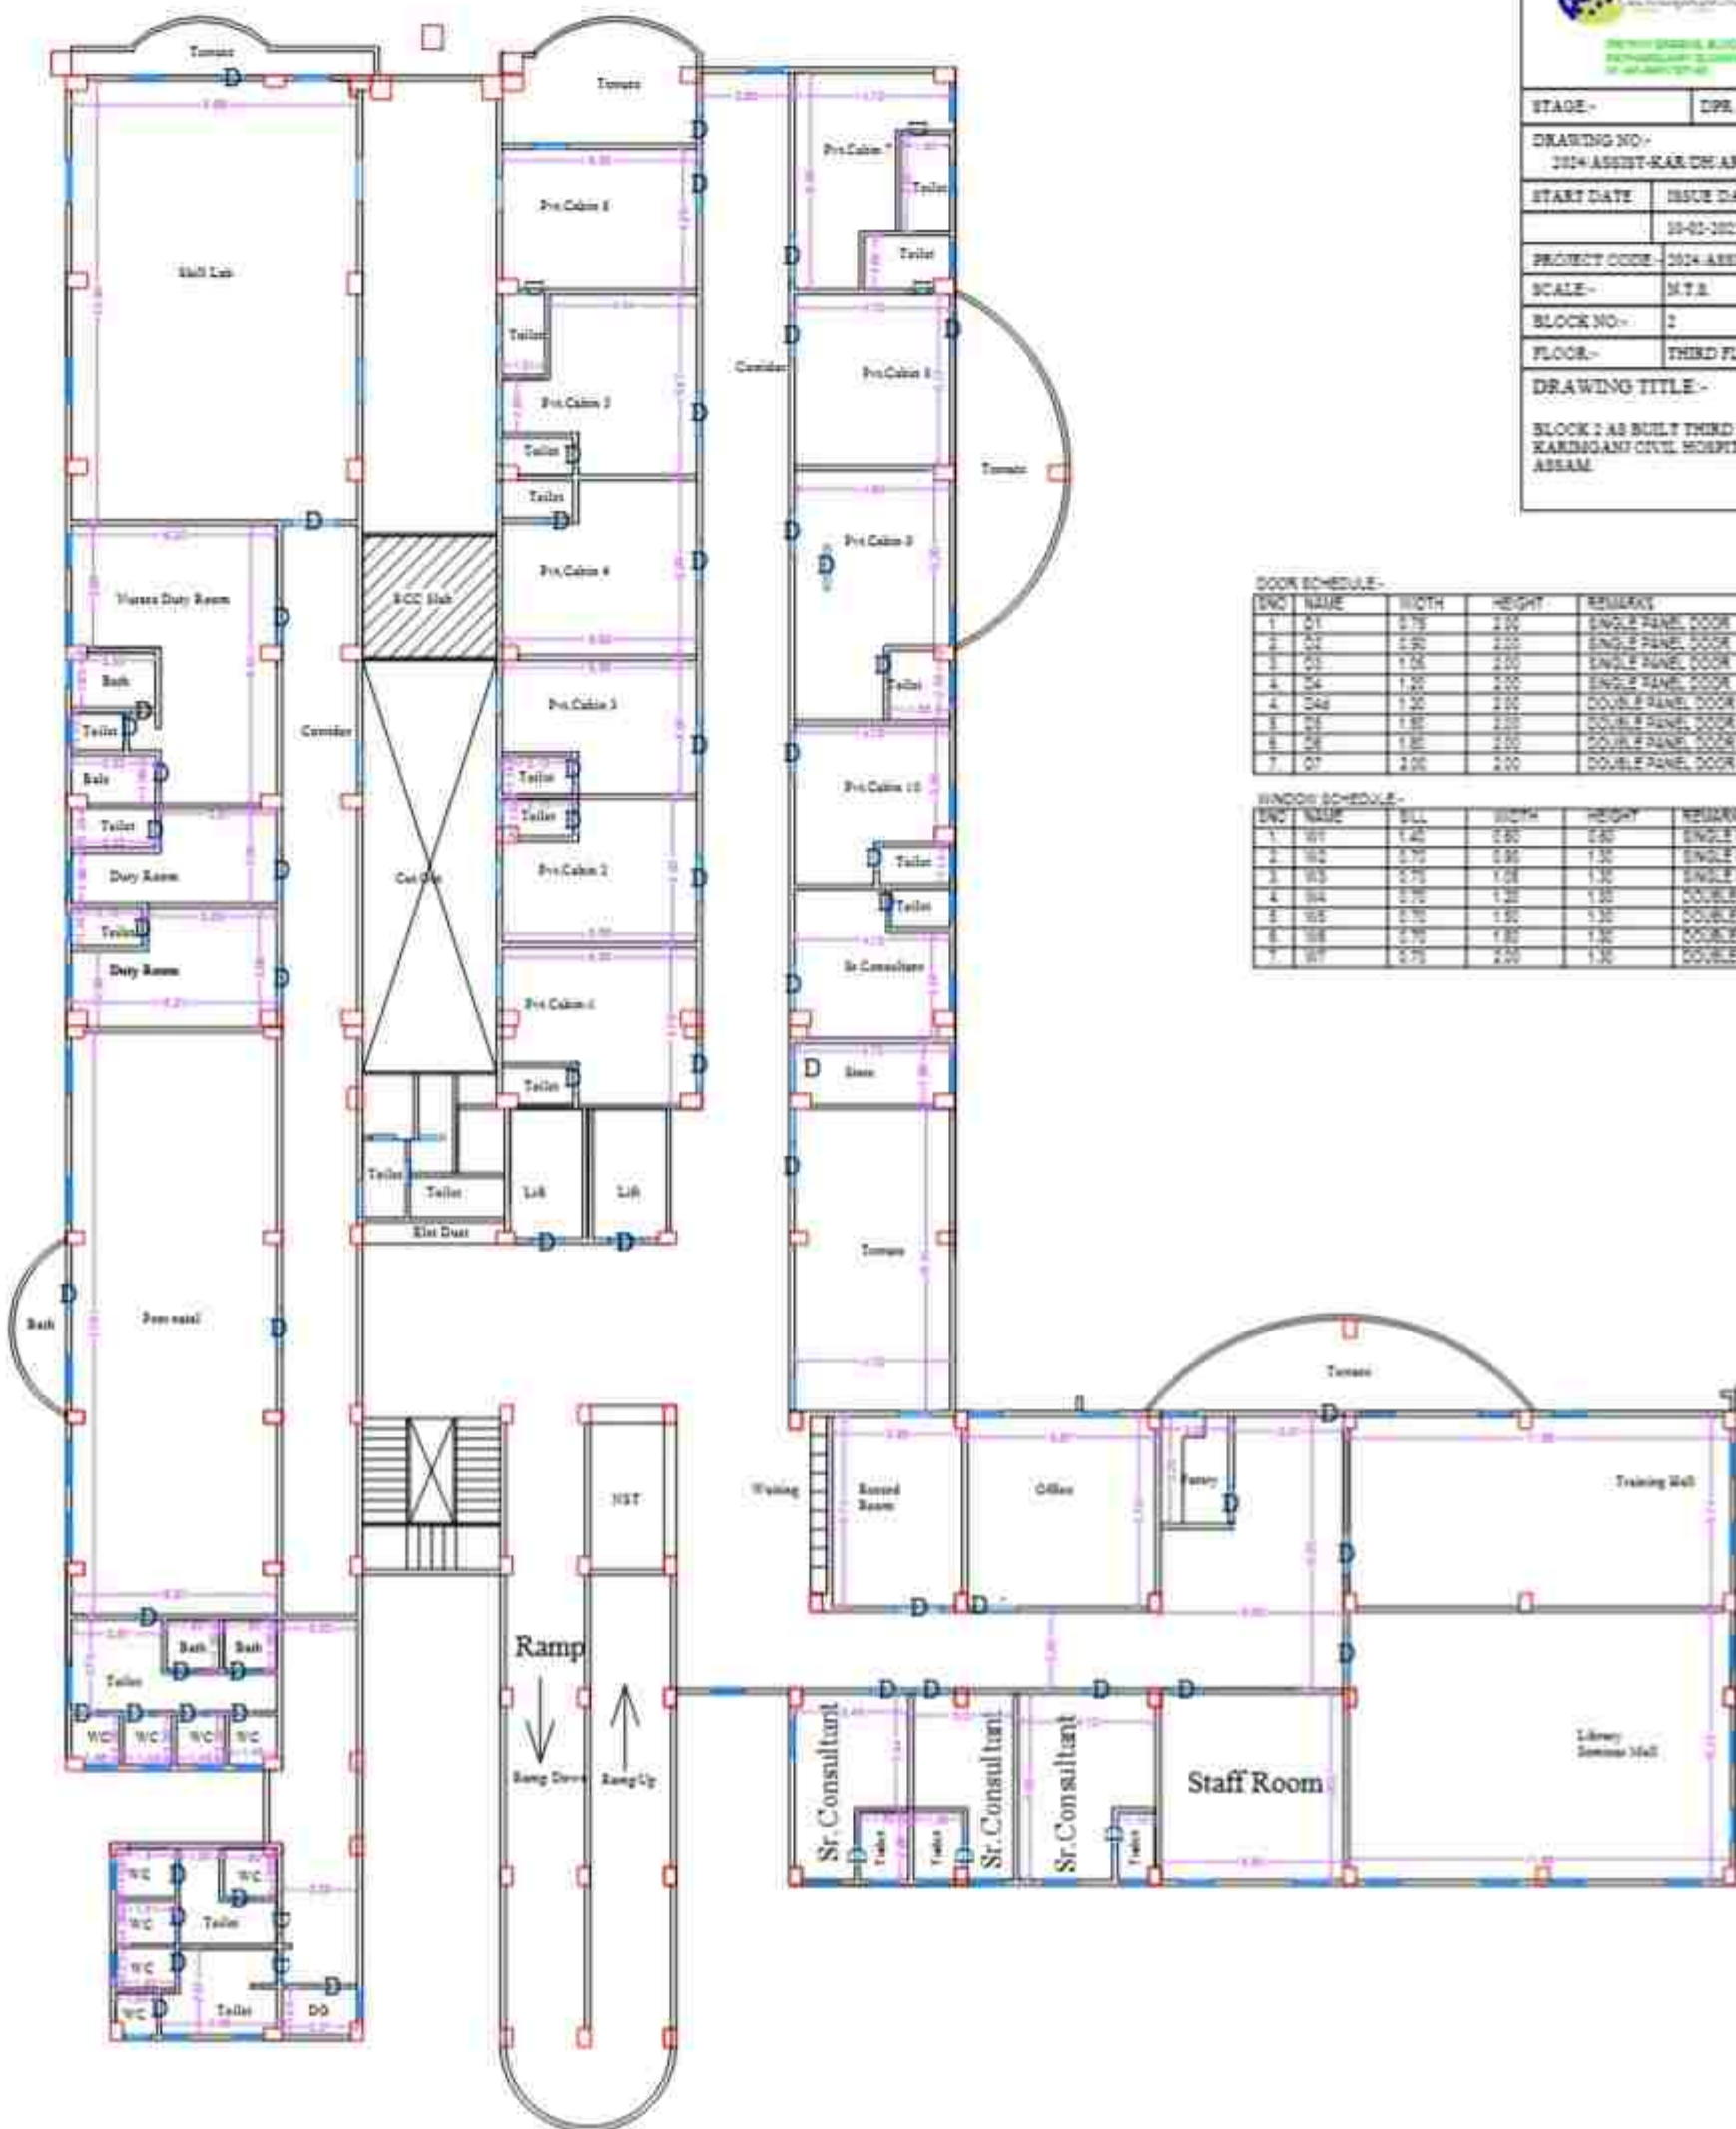

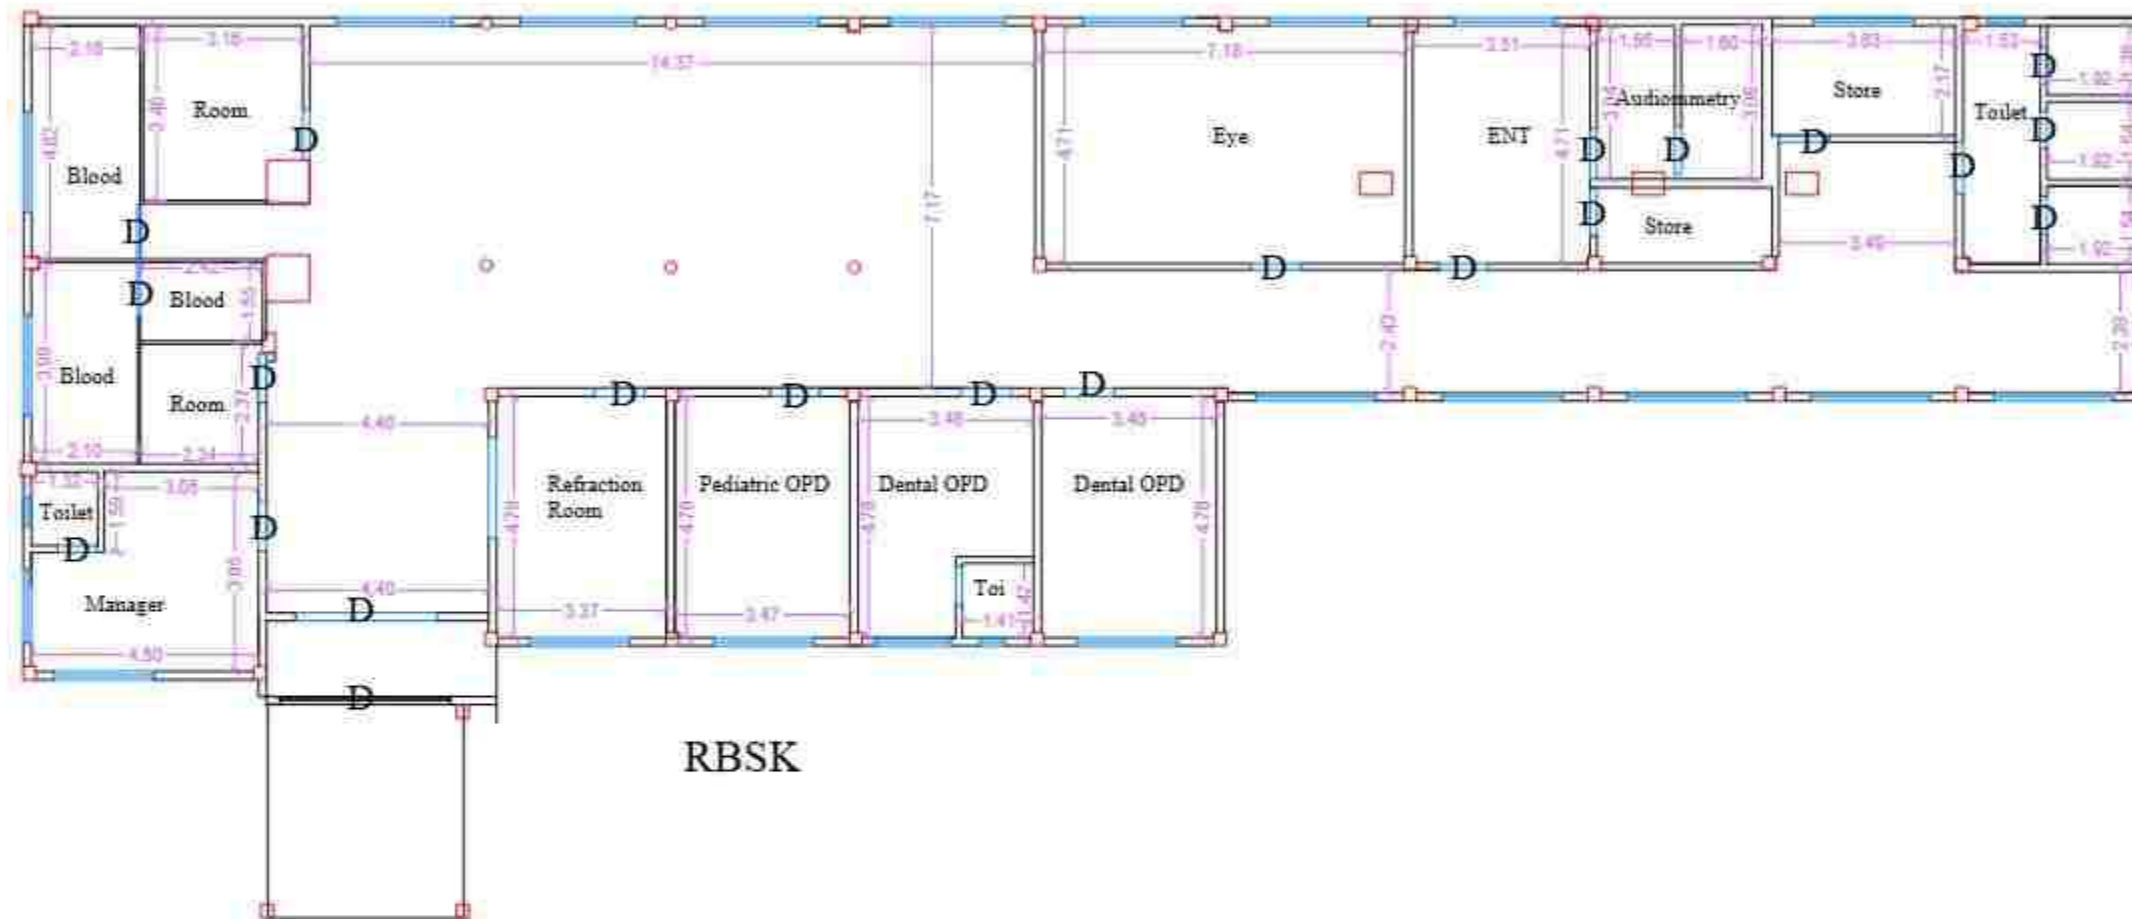

RBSK

DOOR SCHEDULE -

SNO	NAME	WIDTH	HEIGHT	REMARKS
1.	D1	0.75	2.00	SINGLE PANEL DOOR
2.	D2	0.90	2.00	SINGLE PANEL DOOR
3.	D3	1.05	2.00	SINGLE PANEL DOOR
4.	D4	1.20	2.00	SINGLE PANEL DOOR
4.	D4a	1.20	2.00	DOUBLE PANEL DOOR
5.	D5	1.50	2.00	DOUBLE PANEL DOOR
6.	D6	1.80	2.00	DOUBLE PANEL DOOR
7.	D7	2.00	2.00	DOUBLE PANEL DOOR

WINDOW SCHEDULE -

SNO	NAME	SILL	WIDTH	HEIGHT	REMARKS
1.	W1	1.40	0.60	2.20	SINGLE PANEL WINDOW
2.	W2	0.70	0.90	1.30	SINGLE PANEL WINDOW
3.	W3	0.70	1.05	1.30	SINGLE PANEL WINDOW
4.	W4	0.70	1.20	1.30	DOUBLE PANEL WINDOW
5.	W5	0.70	1.50	1.30	DOUBLE PANEL WINDOW
6.	W6	0.70	1.80	1.30	DOUBLE PANEL WINDOW
7.	W7	0.70	2.00	1.30	DOUBLE PANEL WINDOW

PROJECT -
ASSAM STATE SECONDARY HEALTHCARE
INITIATIVE FOR SERVICE DELIVERY
TRANSFORMATION (ASSHT)

CLIENT -
ASSAM HEALTH INFRASTRUCTURE
DEVELOPMENT & MANAGEMENT SOCIETY
(AHIDMS)

PRINCIPAL CONSULTANT -



STAGE - DPR

DRAWING NO -
2024/ASSHT-KAR/DH/AR/AS BUILT/03

START DATE	ISSUE DATE	SHEET SIZE
	10-02-2025	A3

PROJECT CODE - 2024/ASSHT-KAR/DH

SCALE - N.T.S

BLOCK NO - 3

FLOOR - GROUND FLOOR

DRAWING TITLE -

BLOCK 3 AS BUILT GROUND FLOOR PLAN,
KARIMGANJ CIVIL HOSPITAL, KARIMGANJ,
ASSAM



SL.NO	TYPE	NOS.	TYPE		LINTEL HT.	DESCRIPTION
			W	H		
1	D1	1	1000	2300	2100	SINGLE SHUTTER FLUSH DOOR WITH PRESSED STEEL FRAME


SL NO.	TYPE	NOS	TYPE		SILL HT.	LINTEL HT.	DESCRIPTION
			W	H			
1	W1	1	1200	1200	900	2100	POWDER COATED ALUMINIUM THREE TRACK SLIDING GLASS VENTILATOR
2	FG	1	1650	1200	900	2100	POWDER COATED ALUMINIUM FIXED GLASS

- [illegible]

PROJECT:-
ASSAM STATE SECONDARY HEALTHCARE
INITIATIVE FOR SERVICE DELIVERY
TRANSFORMATION (ASSTI)

CLIENT:-
ASSAM HEALTH INFRASTRUCTURE
DEVELOPMENT & MANAGEMENT SOCIETY
(AHIMS)

 PRINCIPAL CONSULTANT:



PROFIT SHARING IS NOT A DISINCENTIVE
TO INNOVATION OR TO INVESTMENT
IN NEW TECHNOLOGY

STAGE	DPR
-------	-----

DRAWING NO.

START DATE	TRAIL DATE	SHEET SIZE
------------	------------	------------

10-01-2021	43
------------	----

DEPT/ST/CD/ID	1034-ARREST-WA-113
---------------	--------------------

DATE:	NAME:
-------	-------


1	2	3	100
---	---	---	---	---	---	---	---	---	----	----	-----

[illegible]

DRAWING TITLE:-

MAIN GATE WITH SECURITY BOOTH PLAN,
SECTION & ELEVATION,
KARIMGANGI CIVIL HOSPITAL, KARIMGANGI,
ASSAM

MAIN GATE DETAIL DRAWING
KARIMGANJ CIVIL HOSPITAL, KARIMGANJ,
ASSAM

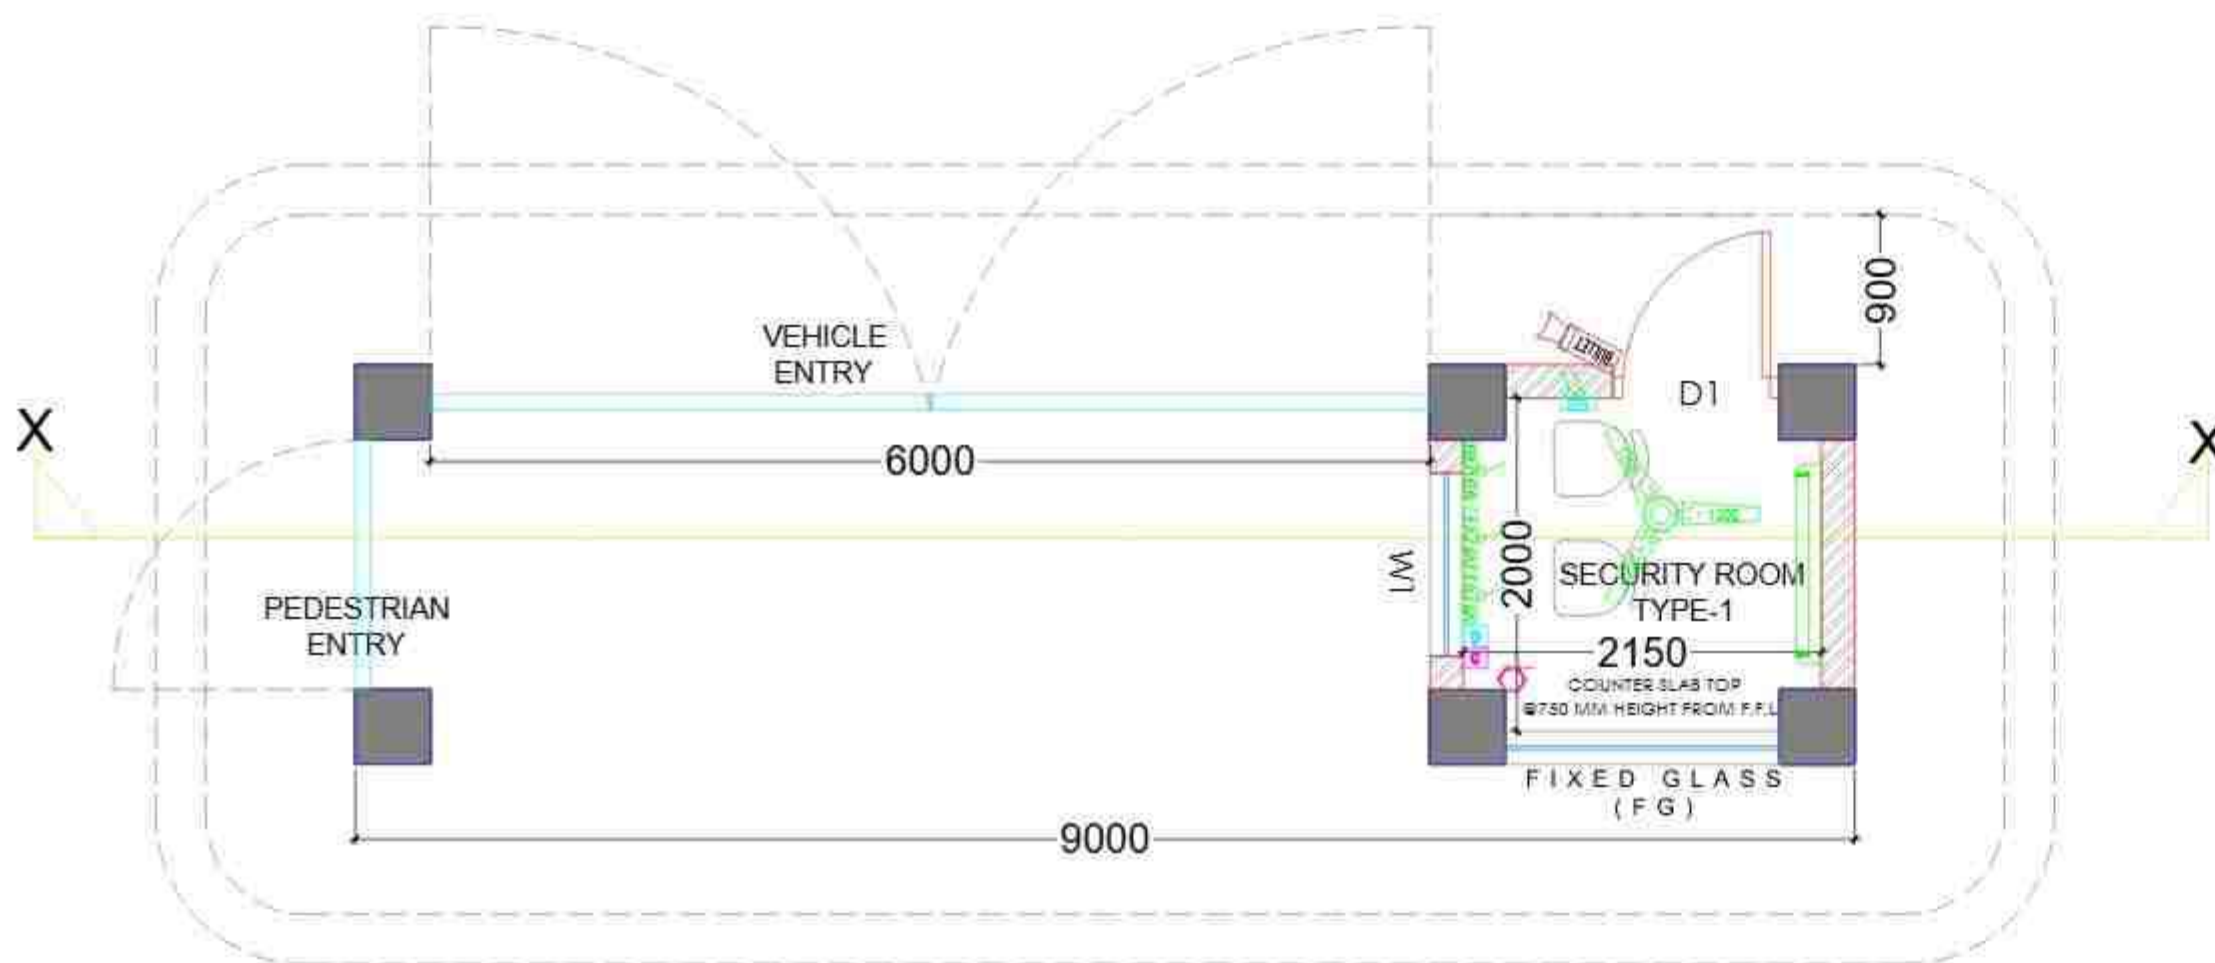

MAIN GATE PLAN-1

ELECTRICAL LEGENDS

SYMBOL	DESCRIPTION
	20W LED TUBE LIGHT
	SWITCH BOARD
	5/6 AMP SWITCH SOCKET OUTLET
	DOME CAMERA
	BULLET CAMERA
	TELEPHONE POINT
	LAN POINT

- NOTES:
1. ALL DIMENSIONS ARE IN MILLIMETERS.
 2. THIS DRAWING SHALL BE READ WITH ALL RELEVANT ARCH. DRAWING.
 3. DO NOT SCALE, FOLLOW WRITTEN DIMENSIONS ONLY.
 4. ALL E.C.C. WORK SHALL BE DONE AS (IS:456) WITH LATEST AMENDMENTS.
 5. STRUCTURAL DESIGN IS CARRIED OUT FOR SEISMIC ZONE IV AS PER IS:1885-2016 & IS:456-2000.
 6. GRADE OF CONCRETE WILL BE M25.
 7. CLEAR COVER TO REINFORCEMENT SHALL BE AS PER IS: 456-2000 WHICH ARE AS FOLLOWS :-
 - A) FOOTING : 50 MM
 - B) BEAMS : 30 MM
 - C) SLAB : 20 MM
 - D) COLUMN : 40 MM
 8. ANY DISCREPANCY IN DIMENSIONS SHALL BE BROUGHT TO THE NOTICE OF ARCHITECT & ENGINEER BEFORE START OF WORK.
 9. HIGH YIELD STRENGTH DEFORMED BARS WITH CHARACTERISTIC STRENGTH OF 500N/mm² CONFORMING TO (IS:1786-1985) SHALL BE USED (HOT STEEL).
 10. NOT MORE THAN 50% OF BARS SHALL BE SPICED AT ONE SECTION.
 11. LAP LENGTH FOR HIGH YIELD STRENGTH DEFORMED BARS SHALL AS PER IS:456.
 - BARS IN COMPRESSION $47 \times d$
 - BARS IN TENSION $56 \times d$
 - WHERE d IS BAR DIAMETER.
 12. FGL INDICATES EXISTING GROUND LEVEL.
 13. FFL INDICATES FINISHED GROUND LEVEL.
 14. IN ALL THE BEAMS, WHERE THERE ARE TWO ROWS OF BARS, EITHER IN TOP OR IN BOTTOM BARS, THE BARS IN EACH SPACING OF 25MM BY PROVISION OF 25MM SPACER BAR.
 15. WELL COMPACTED EARTH UP TO 300 MM STANDARD PROCTOR DENSITY REQUIRED BELOW THE FOUNDATION & FLOOR LVL.

PROJECT:-
ASSAM STATE SECONDARY HEALTHCARE
INITIATIVE FOR SERVICE DELIVERY
TRANSFORMATION (ASSIST)

CLIENT:-
ASSAM HEALTH INFRASTRUCTURE
DEVELOPMENT & MANAGEMENT SOCIETY
(AHIDMS)

PRINCIPAL CONSULTANT:


PRITHVI GREENS, BLOCK A GROUND FLOOR
KATHANQUARY GUWAHATI-781013, ASSAM
M: +91-9401727163

STAGE:-		DPR
DRAWING NO:- 2024/ASSIST-KAR/DH/SEC/E/01		
START DATE	ISSUE DATE	SHEET SIZE
	10-02-2025	A3
PROJECT CODE:-	2024/ASSIST-KAR/DH	
SCALE:-	N.T.S.	
DRAWING TITLE:-		
PROPOSED SECURITY ROOM ELECTRICAL LAYOUT, KARIMGANJ CIVIL HOSPITAL, KARIMGANJ, ASSAM		

1. ALL DIMENSIONS ARE IN METERS.
2. THE DRAWING SHALL BE READ WITH THE RELEVANT SPECIFICATIONS.
3. ALL WORK SHALL BE DONE AS PER THE LATEST AMENDMENTS.
4. THE DESIGN IS BASED ON THE DATA PROVIDED BY THE CLIENT.
5. THE DESIGN IS BASED ON THE DATA PROVIDED BY THE CLIENT.
6. THE DESIGN IS BASED ON THE DATA PROVIDED BY THE CLIENT.
7. THE DESIGN IS BASED ON THE DATA PROVIDED BY THE CLIENT.
8. THE DESIGN IS BASED ON THE DATA PROVIDED BY THE CLIENT.
9. THE DESIGN IS BASED ON THE DATA PROVIDED BY THE CLIENT.
10. THE DESIGN IS BASED ON THE DATA PROVIDED BY THE CLIENT.
11. THE DESIGN IS BASED ON THE DATA PROVIDED BY THE CLIENT.
12. THE DESIGN IS BASED ON THE DATA PROVIDED BY THE CLIENT.
13. THE DESIGN IS BASED ON THE DATA PROVIDED BY THE CLIENT.
14. THE DESIGN IS BASED ON THE DATA PROVIDED BY THE CLIENT.
15. THE DESIGN IS BASED ON THE DATA PROVIDED BY THE CLIENT.

PROJECT:-
ASSAM STATE SECONDARY HEALTHCARE
INITIATIVE FOR SERVICE DELIVERY
TRANSFORMATION (ASSET)

 CLIENT:-
ASSAM HEALTH INFRASTRUCTURE
DEVELOPMENT & MANAGEMENT SOCIETY
(AHIMS)

PRINCIPAL CONSULTANT:-

INTEGRA VENTURES
CONSULTANTS & ENGINEERS
PVT. LTD.

STAGE:- DPR

DRAWING NO:-
2024/ASSIST-KARON ROAD 01


START DATE	ISSUE DATE	SHEET SIZE
10-01-2024	10-01-2024	A3

PROJECT CODE:- 2024/ASSIST-KARON


SCALE:- N.T.S.

DRAWING TITLE:-

SECTIONAL DRAWING OF ROAD,
KARIMANGAL CIVIL HOSPITAL, KARIMANGAL,
ASSAM

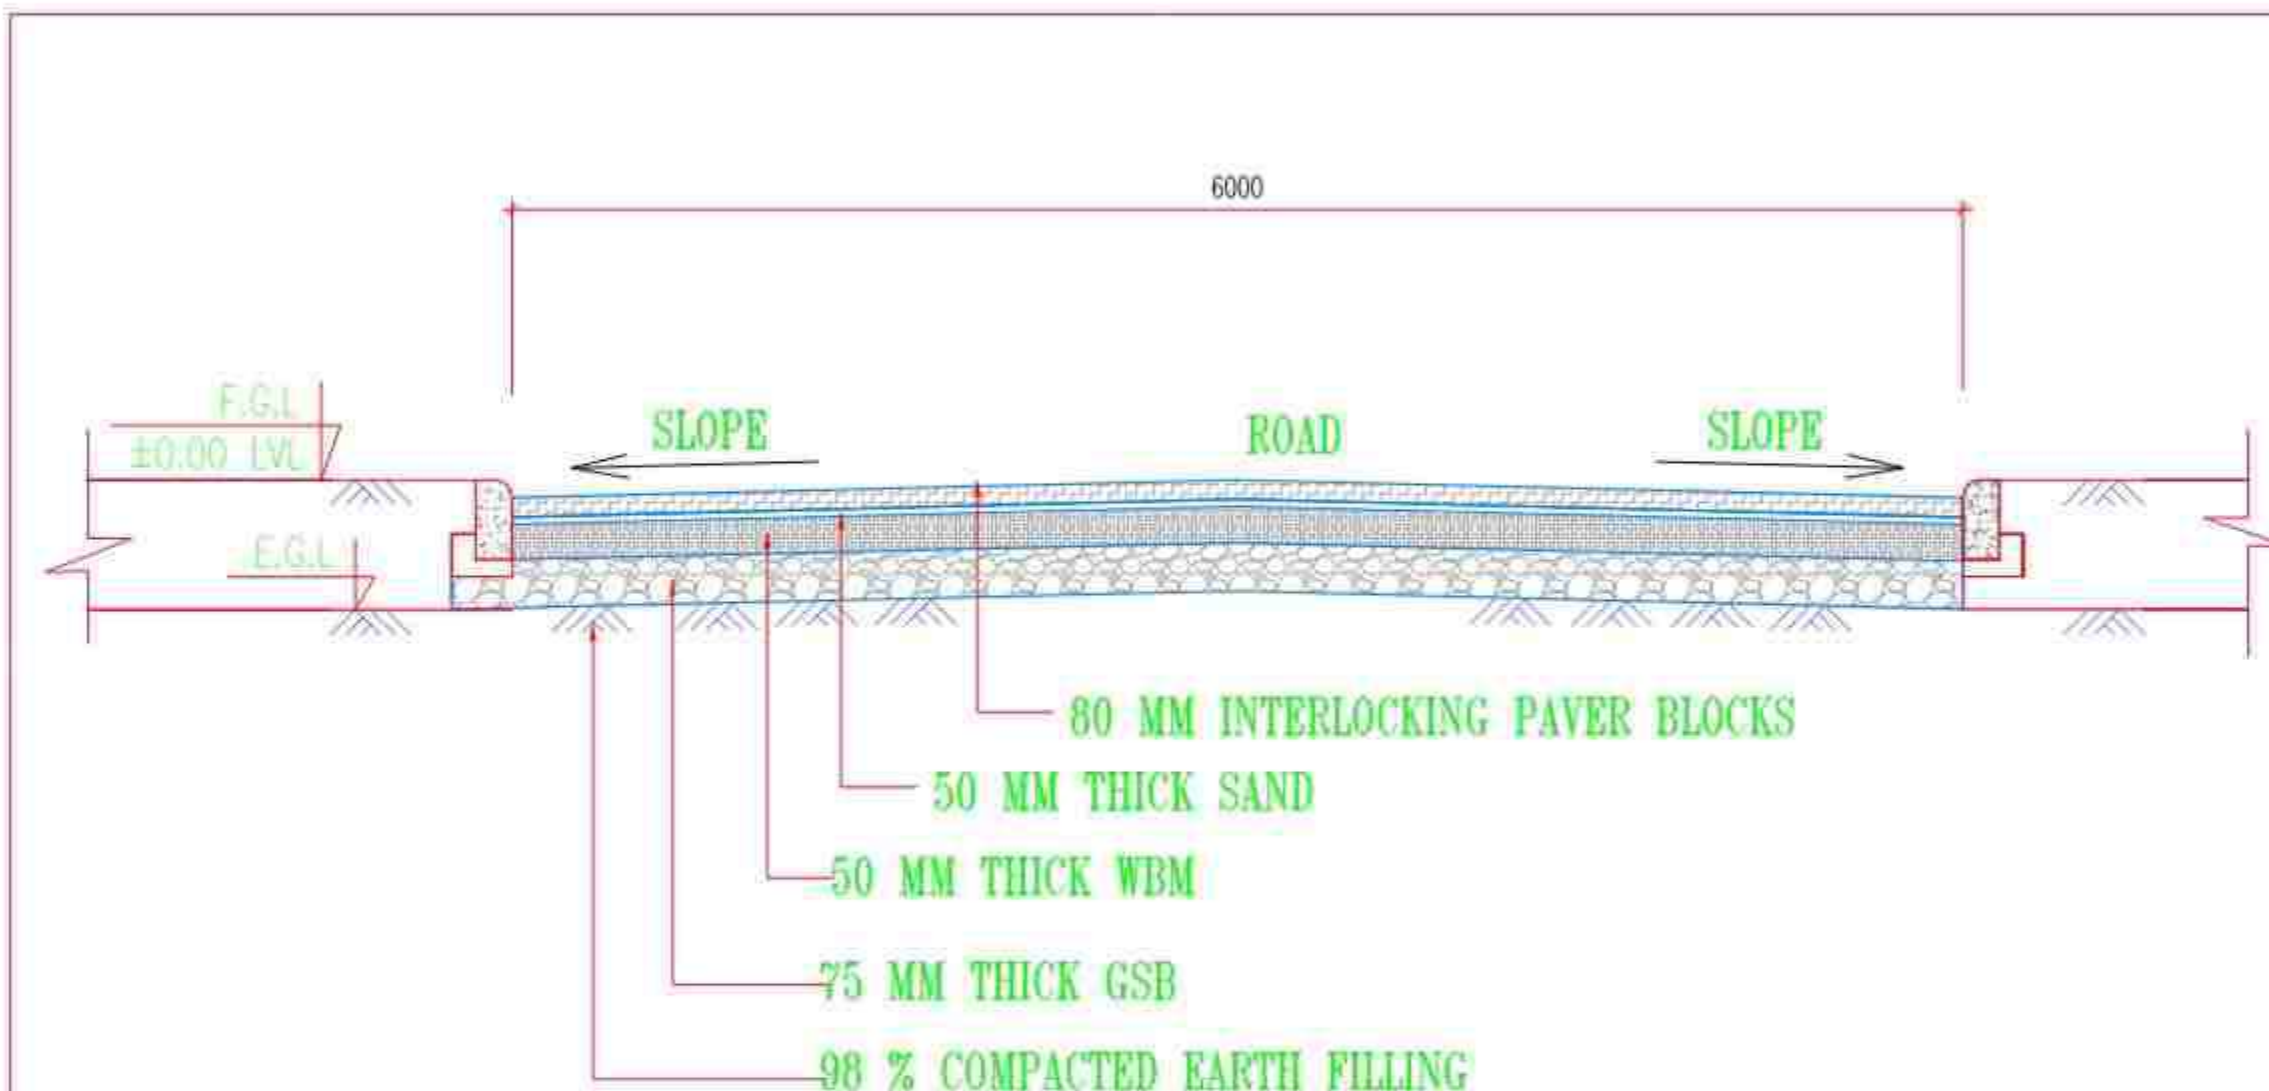

TYPICAL CROSS SECTION FOR PAVERS BLOCK ROAD

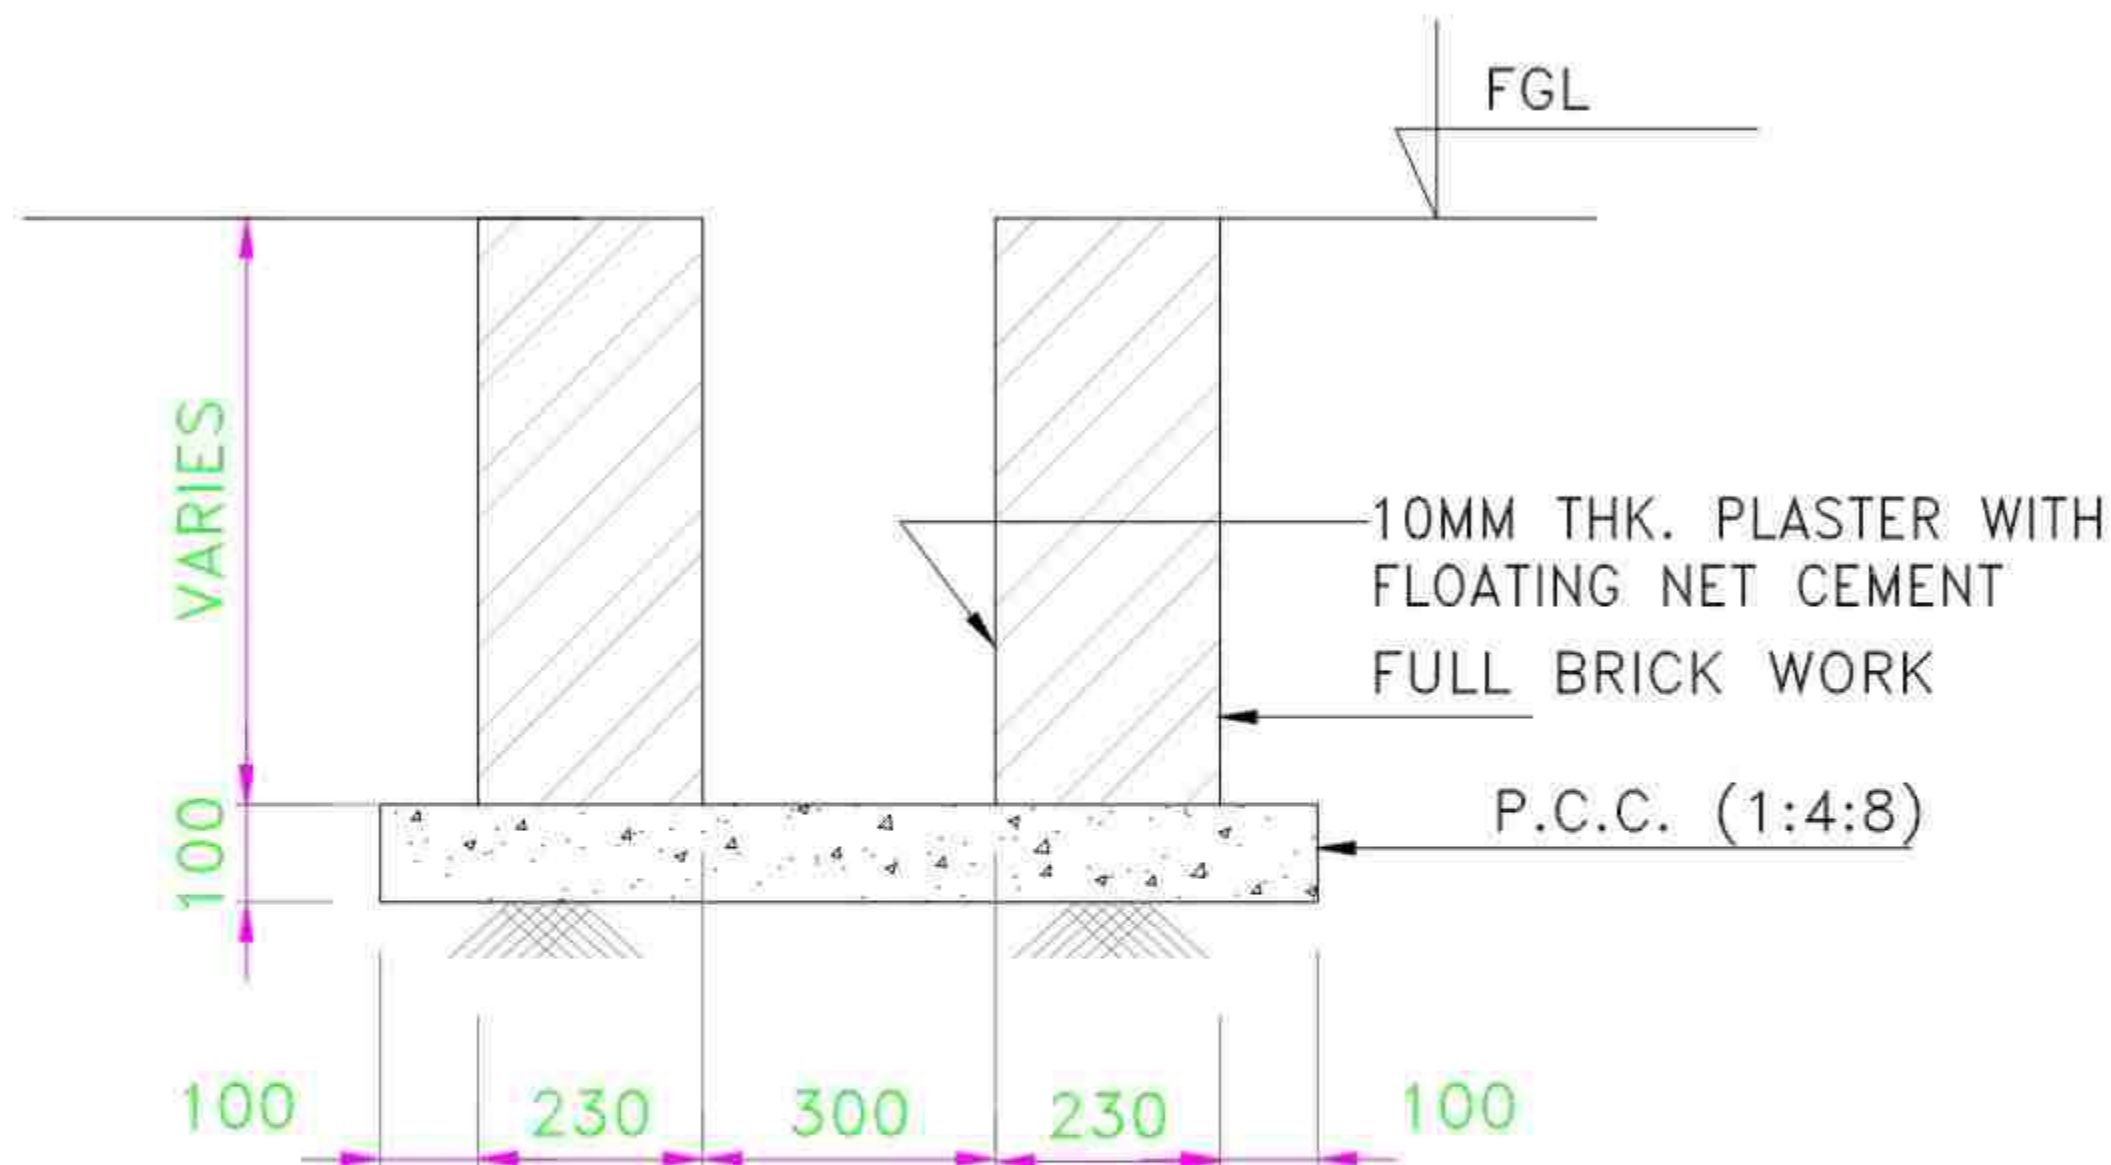

FULL BRICK DRAIN DETAIL (FOR 300MM WIDE DRAIN)

1. ALL DIMENSIONS ARE IN MILLIMETERS.
2. SOIL DRAINAGE SHALL BE DONE WITH AN
EFFECTIVE DRAIN SYSTEM.
3. ALL SOIL SHALL BE PROPERLY DRAINAGE AND
NOT ALLOWED TO ACCUMULATE.
4. ALL SOIL SHALL BE PROPERLY DRAINAGE AND
NOT ALLOWED TO ACCUMULATE.
5. DRAINAGE SHALL BE DONE WITH AN EFFECTIVE
DRAIN SYSTEM.
6. DRAINAGE SHALL BE DONE WITH AN EFFECTIVE
DRAIN SYSTEM.
7. DRAINAGE SHALL BE DONE WITH AN EFFECTIVE
DRAIN SYSTEM.
8. DRAINAGE SHALL BE DONE WITH AN EFFECTIVE
DRAIN SYSTEM.
9. DRAINAGE SHALL BE DONE WITH AN EFFECTIVE
DRAIN SYSTEM.
10. DRAINAGE SHALL BE DONE WITH AN EFFECTIVE
DRAIN SYSTEM.
11. DRAINAGE SHALL BE DONE WITH AN EFFECTIVE
DRAIN SYSTEM.
12. DRAINAGE SHALL BE DONE WITH AN EFFECTIVE
DRAIN SYSTEM.
13. DRAINAGE SHALL BE DONE WITH AN EFFECTIVE
DRAIN SYSTEM.
14. DRAINAGE SHALL BE DONE WITH AN EFFECTIVE
DRAIN SYSTEM.
15. DRAINAGE SHALL BE DONE WITH AN EFFECTIVE
DRAIN SYSTEM.
16. DRAINAGE SHALL BE DONE WITH AN EFFECTIVE
DRAIN SYSTEM.
17. DRAINAGE SHALL BE DONE WITH AN EFFECTIVE
DRAIN SYSTEM.
18. DRAINAGE SHALL BE DONE WITH AN EFFECTIVE
DRAIN SYSTEM.
19. DRAINAGE SHALL BE DONE WITH AN EFFECTIVE
DRAIN SYSTEM.
20. DRAINAGE SHALL BE DONE WITH AN EFFECTIVE
DRAIN SYSTEM.
21. DRAINAGE SHALL BE DONE WITH AN EFFECTIVE
DRAIN SYSTEM.
22. DRAINAGE SHALL BE DONE WITH AN EFFECTIVE
DRAIN SYSTEM.
23. DRAINAGE SHALL BE DONE WITH AN EFFECTIVE
DRAIN SYSTEM.
24. DRAINAGE SHALL BE DONE WITH AN EFFECTIVE
DRAIN SYSTEM.
25. DRAINAGE SHALL BE DONE WITH AN EFFECTIVE
DRAIN SYSTEM.
26. DRAINAGE SHALL BE DONE WITH AN EFFECTIVE
DRAIN SYSTEM.
27. DRAINAGE SHALL BE DONE WITH AN EFFECTIVE
DRAIN SYSTEM.
28. DRAINAGE SHALL BE DONE WITH AN EFFECTIVE
DRAIN SYSTEM.
29. DRAINAGE SHALL BE DONE WITH AN EFFECTIVE
DRAIN SYSTEM.
30. DRAINAGE SHALL BE DONE WITH AN EFFECTIVE
DRAIN SYSTEM.

PROJECT:-
ASSAM STATE SECONDARY HEALTHCARE
INITIATIVE FOR SERVICE DELIVERY
TRANSFORMATION (ASSIST)

CLIENT:-
ASSAM HEALTH INFRASTRUCTURE
DEVELOPMENT & MANAGEMENT SOCIETY
(AHIMS)

PRINCIPAL CONSULTANT:-

INTEGRA VENTURES
CONSULTANTS & PROJECT MANAGERS
PVT. LTD.

STAGE:- DPR

DRAWING NO:-
2024/ASSIST-KAR/DM/DRAIN/01




START DATE	ISSUE DATE	SHEET SIZE
10-02-2025	A3	

PROJECT CODE:- 2024/ASSIST-KAR/DM






SCALE:- N.T.S.

DRAWING TITLE:-

SECTIONAL DRAWING FOR DRAIN,
KARIMGANGI CIVIL HOSPITAL, KARIMGANGI,
ASSAM

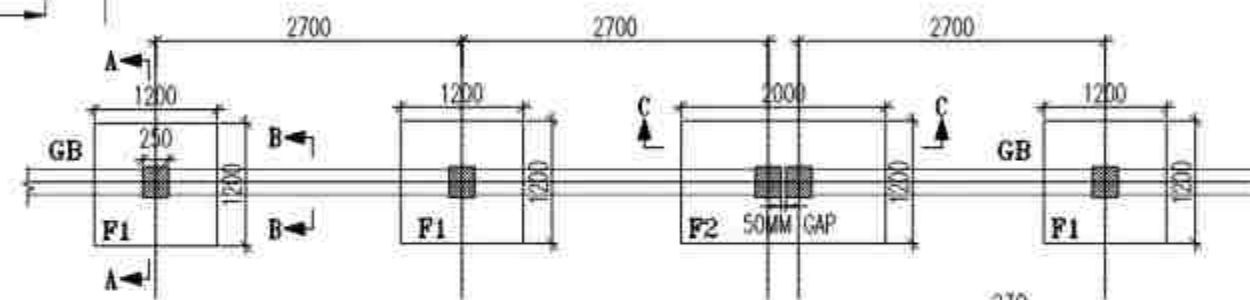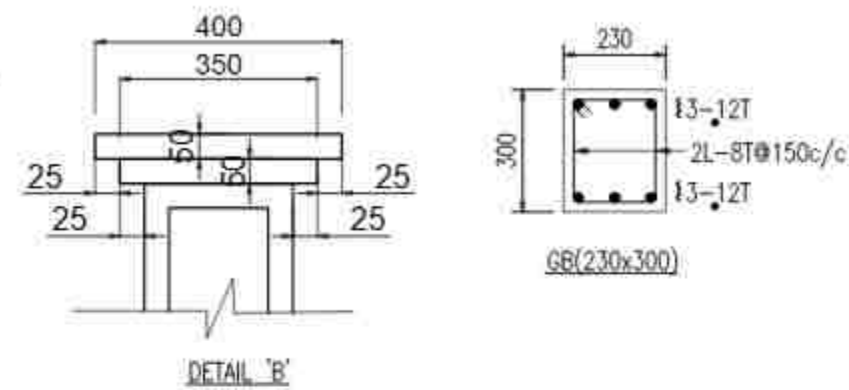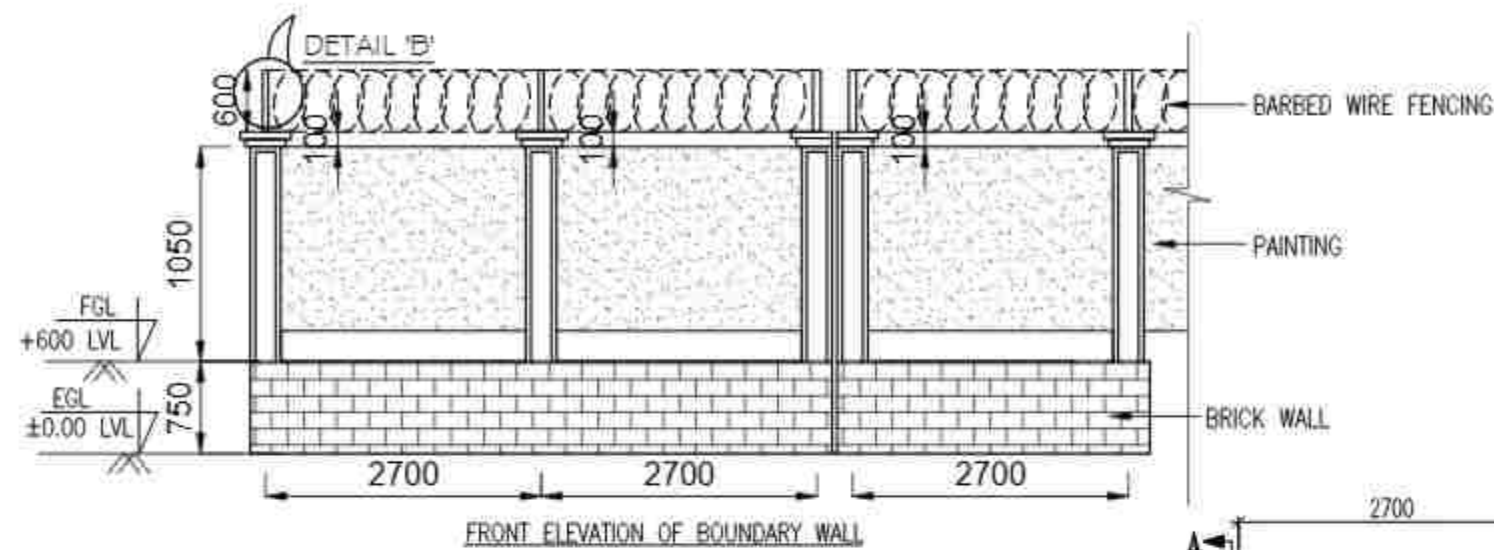

BOUNDARY WALL PLAN
* EXPANSION JOINT SHOULD BE PROVIDED AT EVERY 27 METER LENGTH

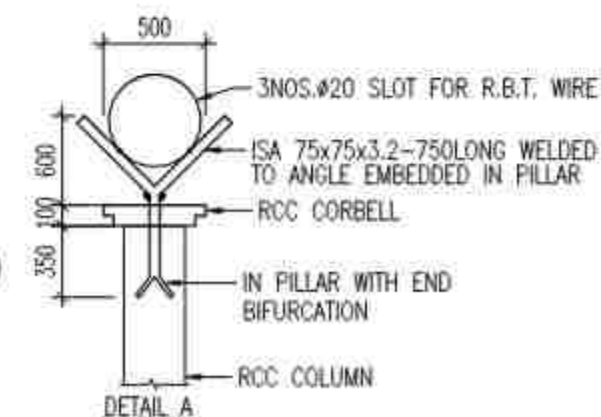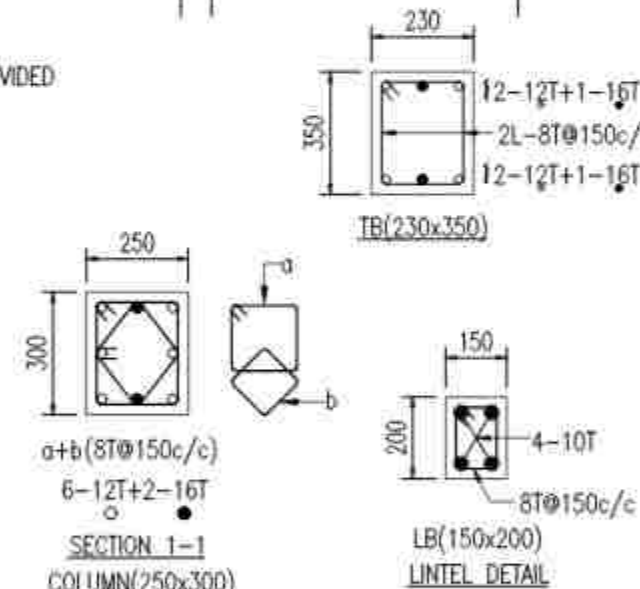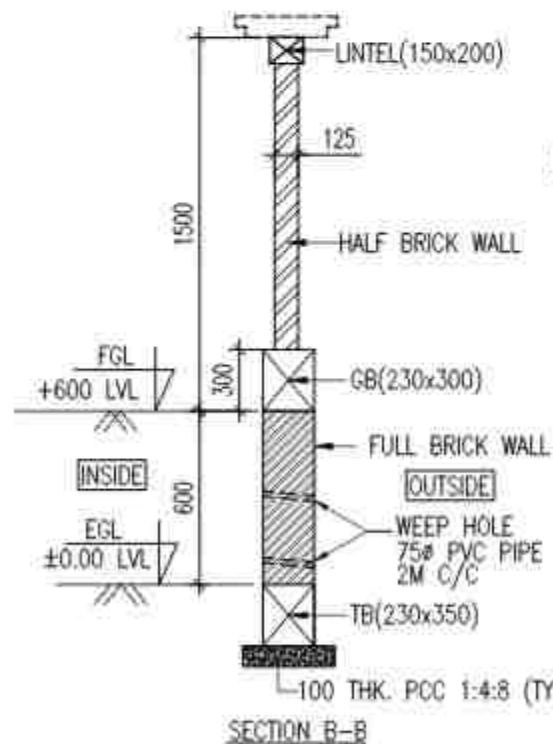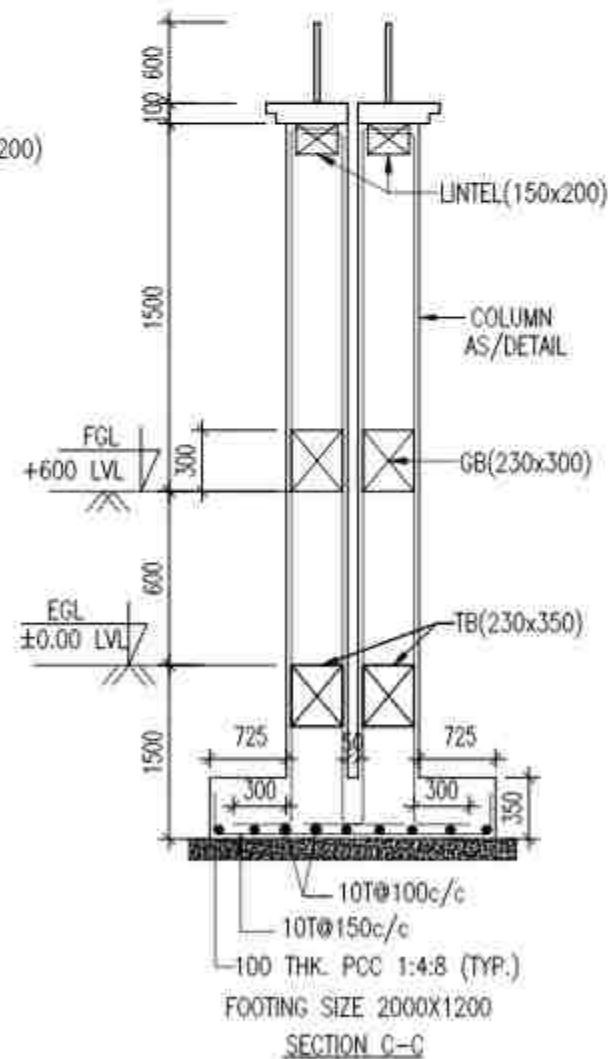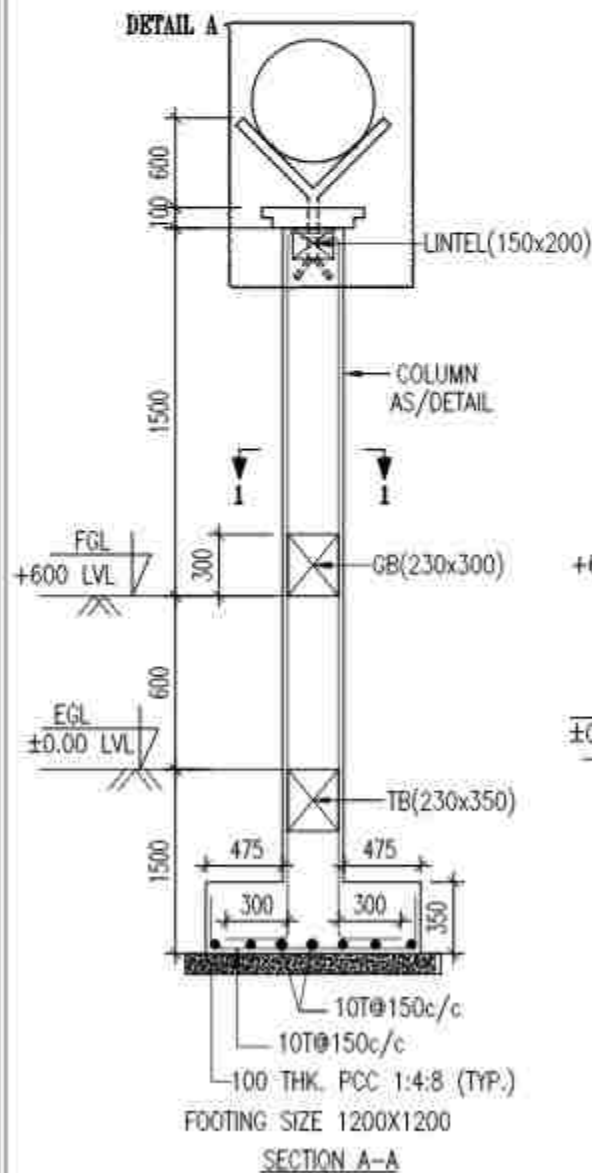

- NOTES**
1. ALL DIMENSIONS ARE IN MILLIMETERS.
 2. THIS DRAWING SHALL BE READ WITH ALL RELEVANT ARCH. DRAWING.
 3. DO NOT SCALE, FOLLOW WRITTEN DIMENSIONS ONLY.
 4. ALL K.C.C. WORK SHALL BE DONE AS (IS:456) WITH LATEST AMENDMENTS.
 5. STRUCTURAL DESIGN IS CARRIED OUT FOR SEISMIC ZONE V AS PER IS:1893-2016 & IS:456-2000.
 6. GRADE OF CONCRETE SHALL BE M25.
 7. CLEAR COVER TO REINFORCEMENT SHALL BE AS PER IS:456-2000 WHICH ARE AS FOLLOWS :-
A) FOOTINGS : 50 MM
B) BEAMS : 30 MM
C) SLAB : 20 MM
D) COLUMN : 40 MM
 8. ANY DISCREPANCY IN DIMENSIONS SHALL BE BROUGHT TO THE NOTICE OF ARCHITECT & ENGINEER BEFORE START OF WORK.
 9. HIGH YIELD STRENGTH DEFORMED BARS WITH CHARACTERISTIC STRENGTH OF 500N/mm² CONFORMING TO (IS:1786-1985) SHALL BE USED (HOT STEEL).
 10. NOT MORE THAN SIX OF BARS SHALL BE SPLICED AT ONE SECTION.
 11. LAP LENGTH FOR HIGH YIELD STRENGTH DEFORMED BARS SHALL AS PER CLAUSE. BARS IN COMPRESSION 40 x d BARS IN TENSION 60 x d WHERE d IS BAR DIAMETER.
 12. E.L. INDICATES EXISTING GROUND LEVEL.
 13. F.G.L. INDICATES FINISHED GROUND LEVEL.
 14. IN ALL THE BEAMS, WHERE THERE ARE TWO ROWS OF BARS, EITHER IN TOP OR IN BOTTOM BAR, THE BARS IN EACH SPACING OF 25MM BY PROVISION OF 25MM SPACER BAR.
 15. IN ALL THE BEAMS, WHERE THERE ARE TWO ROWS OF BARS, 120 MM/NO AT A DEPTH OF 2 METRES BELOW G.L.

PROJECT:-
ASSAM STATE SECONDARY HEALTHCARE INITIATIVE FOR SERVICE DELIVERY TRANSFORMATION (ASSIST)

CLIENT:-
ASSAM HEALTH INFRASTRUCTURE DEVELOPMENT & MANAGEMENT SOCIETY (AHIDSBS)



PRINCIPAL CONSULTANT:

INTEGRA VENTURES

DRYING DESIGN, BLOCK & GROUND FLOOR
PARTICULARLY: 2024-ASSIST-KAR/DH WALL

STAGE -	DPR	
DRAWING NO - 2024-ASSIST-KAR/DH-WALL-01		
START DATE	ISSUE DATE	SHEET SIZE
	10-02-2025	A3
PROJECT CODE -	2024-ASSIST-KAR/DH	
SCALE -	N.T.S	

DRAWING TITLE:-
TYPICAL SECTIONAL DRAWING FOR BOUNDARY WALL, KARJIGANI CIVIL HOSPITAL, KARJIGANI, ASSAM

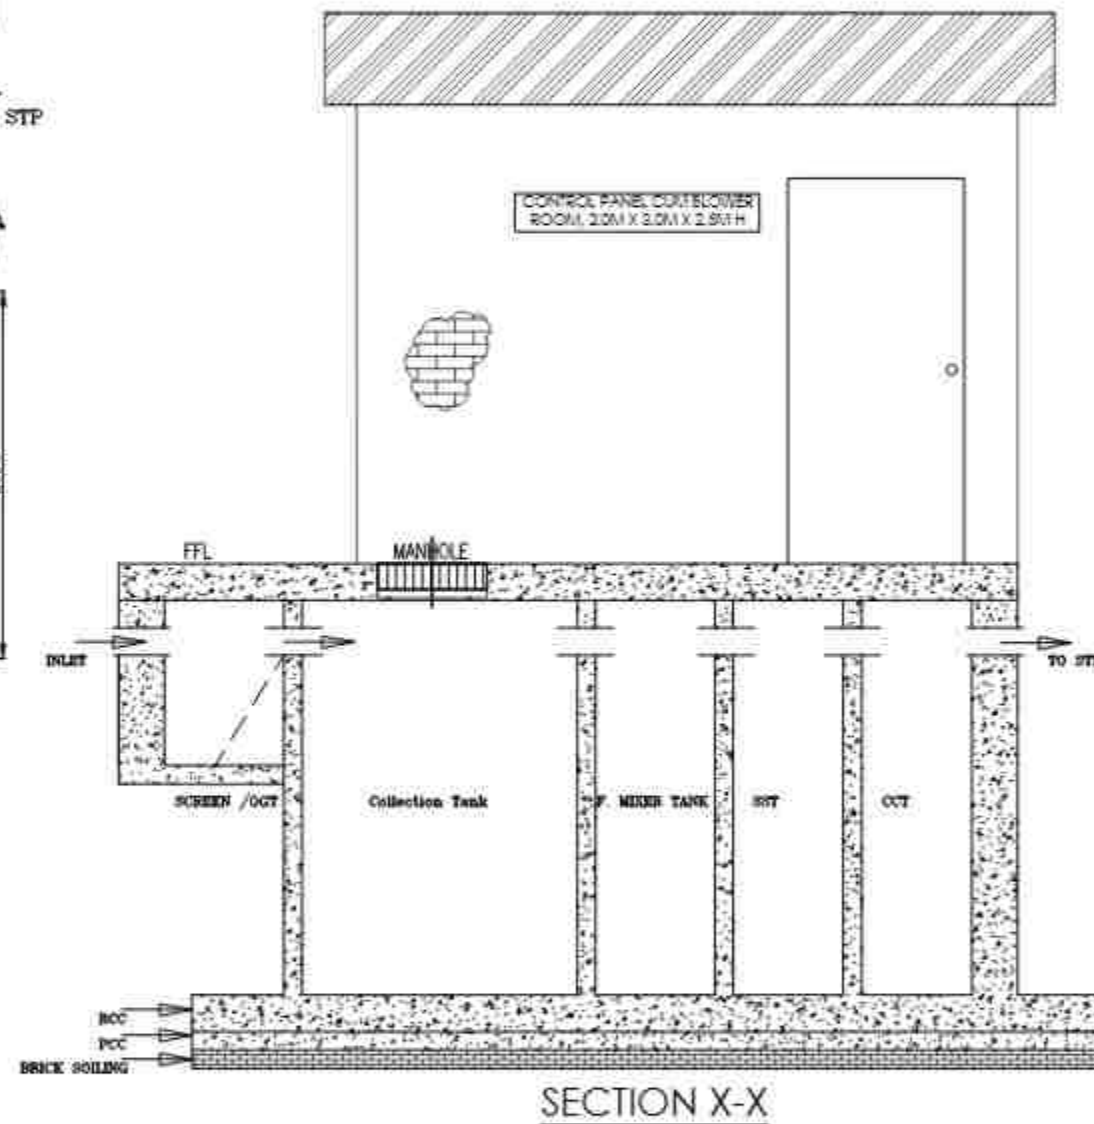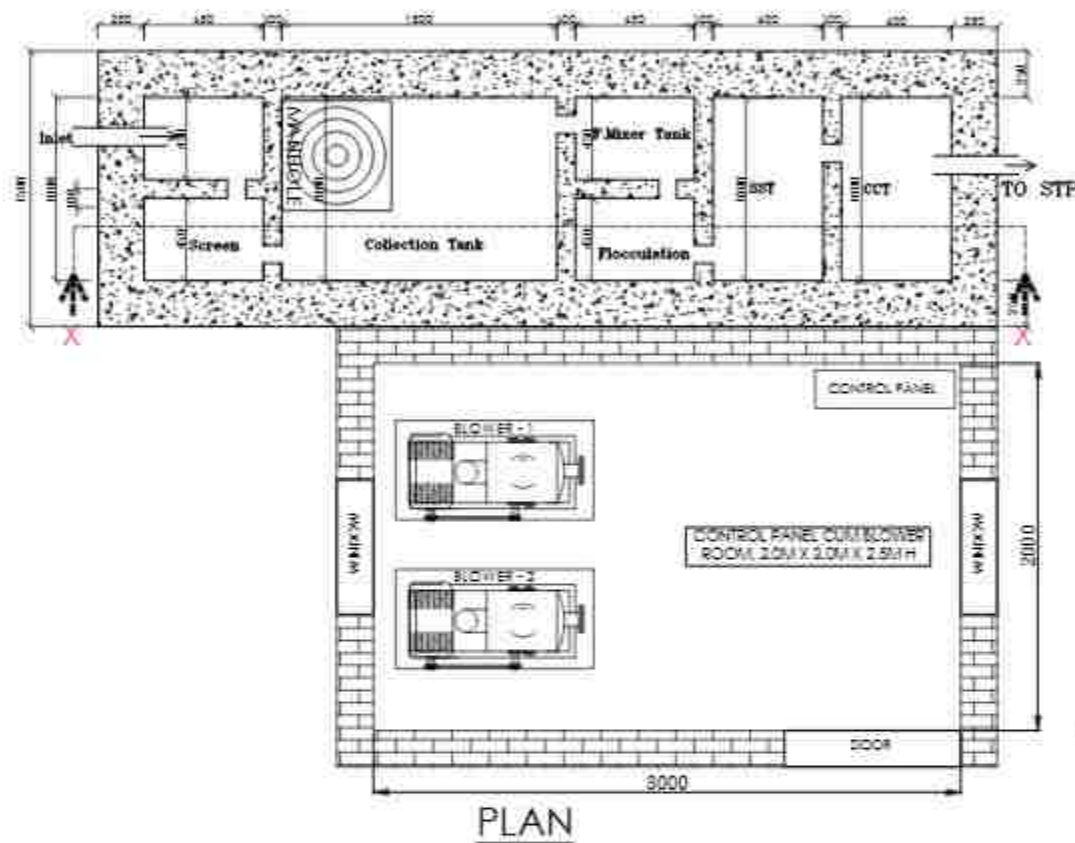

ETP CONTINUOUS FLOW
10 KLD

- NOTES
1. ALL DIMENSIONS ARE IN METERS UNLESS OTHERWISE SPECIFIED.
 2. ALL LEVELS INDICATED ARE IN MM UNLESS OTHERWISE SPECIFIED.
 3. DIMENSIONS - LEVELS INDICATED ARE STRUCTURAL UNLESS OTHERWISE SPECIFIED.
 4. ONLY WRITTEN DIMENSIONS TO BE FOLLOWED. DO NOT SCALE THE DRAWING.
 5. DIMENSIONS - LEVELS SHOWN TO BE VERIFIED AT SITE BEFORE COMMENCEMENT OF WORK. ANY DISCREPANCIES IF NOTED, SHOULD BE BROUGHT TO THE NOTICE OF ARCHITECT PRIOR TO COMMENCEMENT OF WORK.
 6. RELEVANT SERVICES DRAINAGES ARE TO BE RAN SEPARATELY AND PROVISION OF OUTFALL SLABES TO BE PROVIDED AS REQUIRED.
 7. ALL MATERIALS / FINISHES TO BE AS SPECIFIED AND APPROVED BY THE CONSULTANTS.
 8. ALL SHALL BE DONE IN ACCORDANCE WITH THE SPECIFICATIONS.

PROJECT:-
ASSAM STATE SECONDARY HEALTHCARE
INITIATIVE FOR SERVICE DELIVERY
TRANSFORMATION (ASSIST)

CLIENT:-
ASSAM HEALTH INFRASTRUCTURE
DEVELOPMENT & MANAGEMENT SOCIETY
(AHIDMS)

PRINCIPAL CONSULTANT:-



PRITHVI GREENS, BLOCK A, GROUND FLOOR,
PATHARDIGARY GUWAHATI-781171, ASSAM
M: +91-9401727143

STAGE:- DPR

DRAWING NO:-
2024/ASSIST-KAR/DH/ETP 01





START DATE	ISSUE DATE	SHEET SIZE
	10-02-2023	A3

PROJECT CODE:- 2024/ASSIST-KAR/DH

SCALE:- N.T.S.

DRAWING TITLE:-

10KLD ETP LAYOUT,
KARIMGANJ CIVIL HOSPITAL, KARIMGANJ,
ASSAM

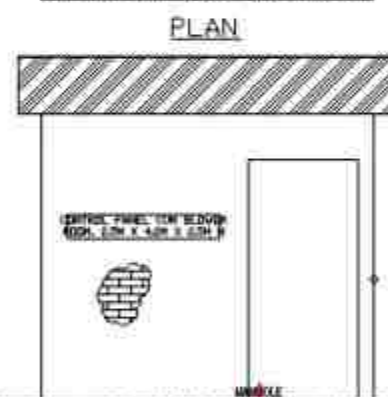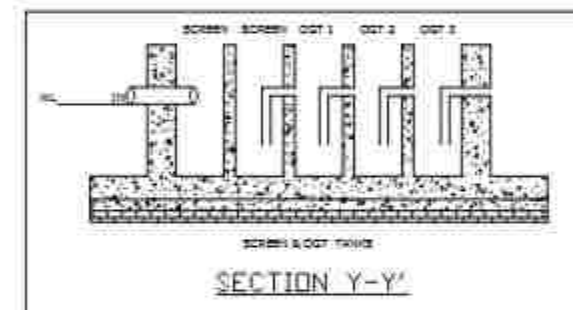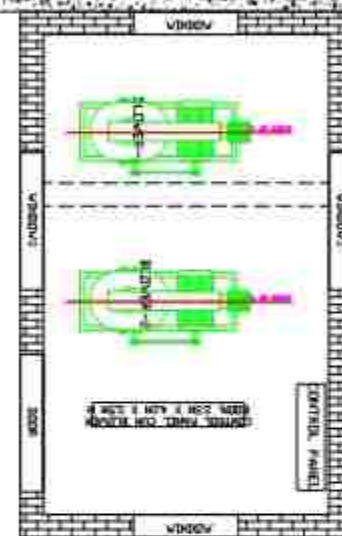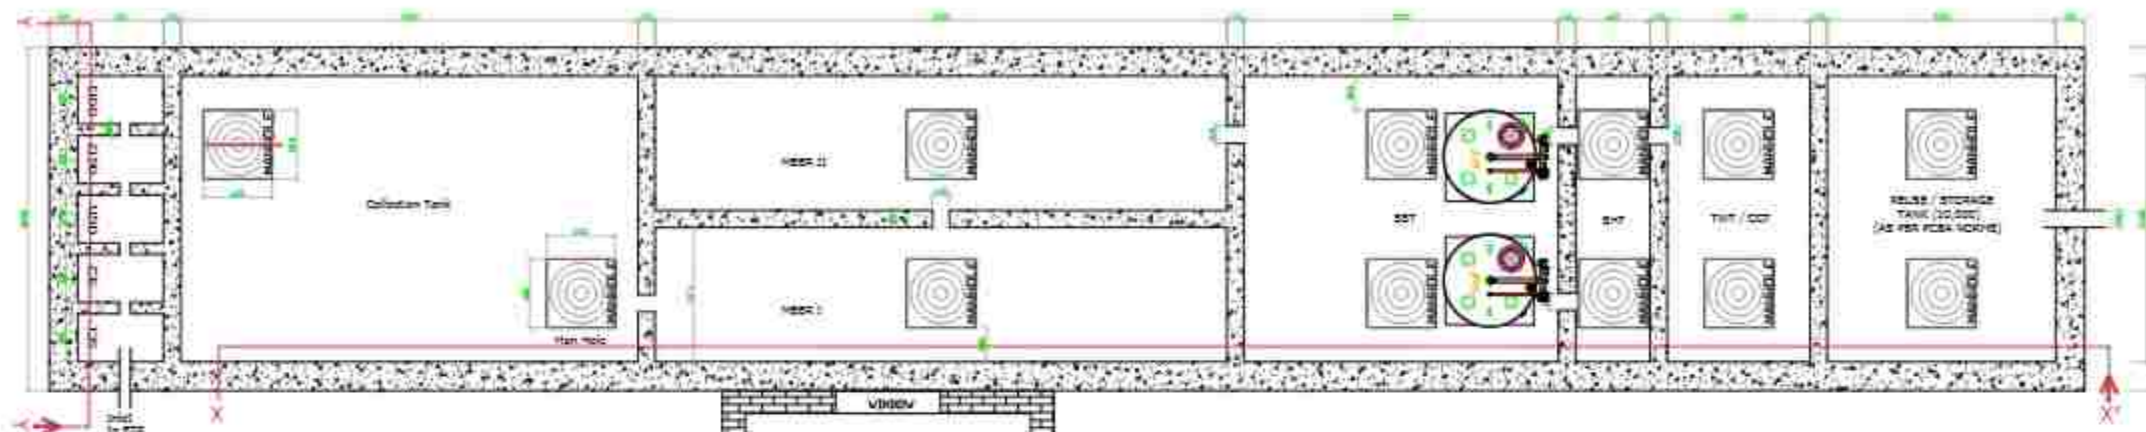

LEGEND:-	Volume (LTR.)	L (mm)	B (mm)	H (mm)
Tanks volume in LTR.				
Flow Rate (FR) 200/500mm				
(As per WLS condition)				
Screen and D & S Tanks (2 Nos.)	300 x 3	750	430 x 3	1000
Collection / Equalization Tank 1	20000	4000	2500	2000
Aerobic Tank	NOT APPLIED	NOT APPLIED	NOT APPLIED	NOT APPLIED
HBR Tank - 1	12500	5000	1175	2000
HBR Tank - 2	12500	5000	1175	2000
Settling Tank (2 hours for TS & 4 hours normal)	13750	2750	2500	2000
SBT - 1 No.	3000	800	2500	2000
OCT - 1 No.	5250	1250	2500	2000
Reuse / Storage Tank	10000	3000	2500	2000
Sludge Drying Bed (OVER GROUND ON BRICKS - 2 Nos.)	3375 x 3	1500	1500	1500

 
NOTES

1. ALL DIMENSIONS ARE IN MM UNLESS OTHERWISE SPECIFIED.
2. ALL TANKS ARE TO BE CONSTRUCTED AS PER THE SPECIFICATIONS.
3. ALL TANKS ARE TO BE CONSTRUCTED AS PER THE SPECIFICATIONS.
4. ALL TANKS ARE TO BE CONSTRUCTED AS PER THE SPECIFICATIONS.
5. ALL TANKS ARE TO BE CONSTRUCTED AS PER THE SPECIFICATIONS.
6. ALL TANKS ARE TO BE CONSTRUCTED AS PER THE SPECIFICATIONS.
7. ALL TANKS ARE TO BE CONSTRUCTED AS PER THE SPECIFICATIONS.
8. ALL TANKS ARE TO BE CONSTRUCTED AS PER THE SPECIFICATIONS.
9. ALL TANKS ARE TO BE CONSTRUCTED AS PER THE SPECIFICATIONS.
10. ALL TANKS ARE TO BE CONSTRUCTED AS PER THE SPECIFICATIONS.
11. ALL TANKS ARE TO BE CONSTRUCTED AS PER THE SPECIFICATIONS.
12. ALL TANKS ARE TO BE CONSTRUCTED AS PER THE SPECIFICATIONS.
13. ALL TANKS ARE TO BE CONSTRUCTED AS PER THE SPECIFICATIONS.
14. ALL TANKS ARE TO BE CONSTRUCTED AS PER THE SPECIFICATIONS.
15. ALL TANKS ARE TO BE CONSTRUCTED AS PER THE SPECIFICATIONS.
16. ALL TANKS ARE TO BE CONSTRUCTED AS PER THE SPECIFICATIONS.
17. ALL TANKS ARE TO BE CONSTRUCTED AS PER THE SPECIFICATIONS.
18. ALL TANKS ARE TO BE CONSTRUCTED AS PER THE SPECIFICATIONS.
19. ALL TANKS ARE TO BE CONSTRUCTED AS PER THE SPECIFICATIONS.
20. ALL TANKS ARE TO BE CONSTRUCTED AS PER THE SPECIFICATIONS.

PROJECT:-
ASSAM STATE SECONDARY HEALTHCARE
INITIATIVE FOR SERVICE DELIVERY
TRANSFORMATION (ASSIST)

CLIENT:-
ASSAM HEALTH INFRASTRUCTURE
DEVELOPMENT & MANAGEMENT SOCIETY
(AHIDMS)

PRINCIPAL CONSULTANT:-



PRITHVI GREENS, BLOCK-A GROUND FLOOR
PACHAGUZI, QUARTER-1, P.O. BOX
61, KHEMISTETI, NE

STAGE:- DPR

DRAWING NO:-
2024-ASSIST-KAR/DH/STP/01

START DATE 10-02-2025 **ISSUE DATE** **SHEET SIZE** A3

PROJECT CODE:- 2024-ASSIST-KAR/DH

SCALE:- N.T.S.

DRAWING TITLE:-

70KLD STP LAYOUT,
KARIMGANJ CIVIL HOSPITAL, KARIMGANJ,
ASSAM

SECTION X-X'

70 KLD STP



DOOR SCHEDULE:-

SNO	NAME	WIDTH	HEIGHT	REMARKS
1.	D1	0.75	2.00	SINGLE PANEL DOOR
2.	D2	0.90	2.00	SINGLE PANEL DOOR
3.	D3	1.05	2.00	SINGLE PANEL DOOR
4.	D4	1.20	2.00	SINGLE PANEL DOOR
4.	D4a	1.20	2.00	DOUBLE PANEL DOOR
5.	D5	1.50	2.00	DOUBLE PANEL DOOR
6.	D6	1.80	2.00	DOUBLE PANEL DOOR
7.	D7	2.00	2.00	DOUBLE PANEL DOOR

WINDOW SCHEDULE:-

SNO	NAME	SILL	WIDTH	HEIGHT	REMARKS
1.	W1	1.40	0.90	0.90	SINGLE PANEL WINDOW
2.	W2	0.70	0.90	1.30	SINGLE PANEL WINDOW
3.	W3	0.70	1.05	1.30	SINGLE PANEL WINDOW
4.	W4	0.70	1.20	1.30	DOUBLE PANEL WINDOW
5.	W5	0.70	1.30	1.30	DOUBLE PANEL WINDOW
6.	W6	0.70	1.80	1.30	DOUBLE PANEL WINDOW
7.	W7	0.70	2.00	1.30	DOUBLE PANEL WINDOW

LEGEND:

 	EXISTING
 	PROPOSED

PROJECT:-
ASSAM STATE SECONDARY HEALTHCARE
INITIATIVE FOR SERVICE DELIVERY
TRANSFORMATION (ASSIST)

CLIENT:-
ASSAM HEALTH INFRASTRUCTURE
DEVELOPMENT & MANAGEMENT SOCIETY
(AHIDMS)

PRINCIPAL CONSULTANT:-



ASSAM STATE SECONDARY HEALTHCARE
INITIATIVE FOR SERVICE DELIVERY
TRANSFORMATION (ASSIST)

STAGE:- DPR

DRAWING NO:-
2024/ASSIST-KAR/DH/PROP/01/FF

START DATE	ISSUE DATE	SHEET SIZE
	10-01-2025	A3


PROJECT CODE:- 2024/ASSIST-KAR/DH

SCALE:- N.T.S

BLOCK NO:- 1

FLOOR:- FIRST FLOOR

DRAWING TITLE:-
BLOCK 1 FIRST FLOOR PLAN PLUMBING
LAYOUT,
KARIMGANJ CIVIL HOSPITAL, KARIMGANJ,
ASSAM

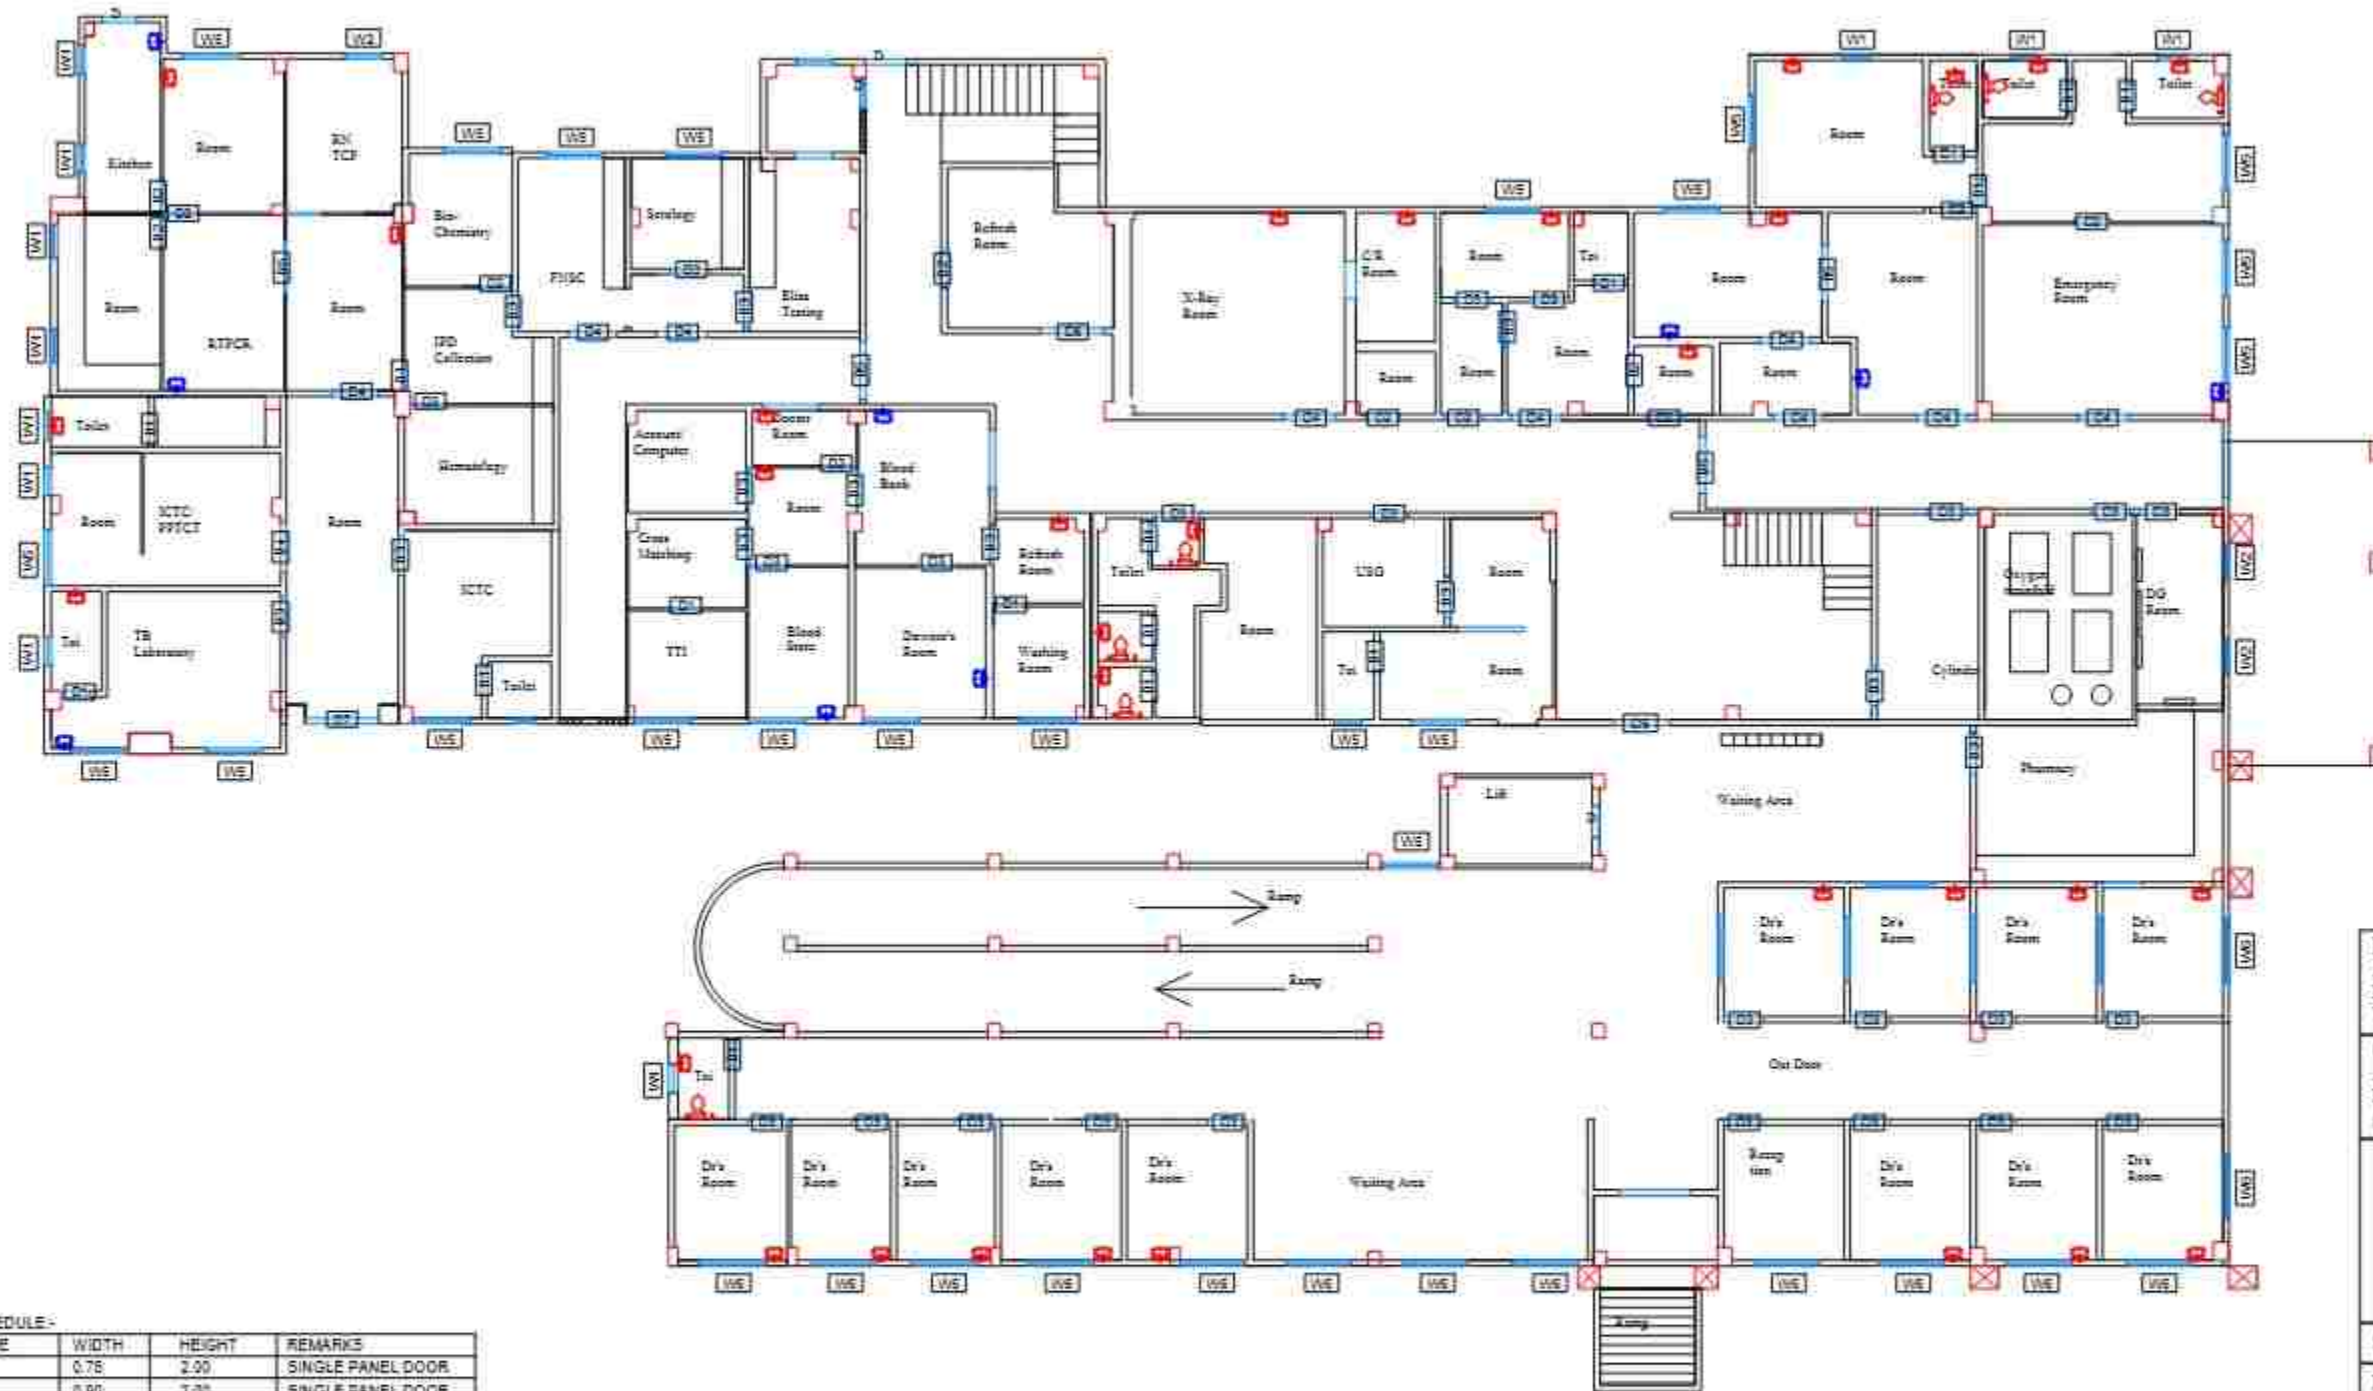

DOOR SCHEDULE:-

SNO	NAME	WIDTH	HEIGHT	REMARKS
1.	D1	0.75	2.00	SINGLE PANEL DOOR
2.	D2	0.90	2.00	SINGLE PANEL DOOR
3.	D3	1.05	2.00	SINGLE PANEL DOOR
4.	D4	1.20	2.00	SINGLE PANEL DOOR
4.	D4B	1.20	2.00	DOUBLE PANEL DOOR
5.	D5	1.50	2.00	DOUBLE PANEL DOOR
6.	D6	1.80	2.00	DOUBLE PANEL DOOR
7.	D7	2.05	2.00	DOUBLE PANEL DOOR

WINDOW SCHEDULE:-

SNO	NAME	SILL	WIDTH	HEIGHT	REMARKS
1.	W1	1.40	0.60	0.60	SINGLE PANEL WINDOW
2.	W2	0.70	0.90	1.30	SINGLE PANEL WINDOW
2.	W3	0.70	1.05	1.30	SINGLE PANEL WINDOW
4.	W4	0.70	1.20	1.30	DOUBLE PANEL WINDOW
5.	W5	0.70	1.50	1.80	DOUBLE PANEL WINDOW
6.	W6	0.70	1.80	1.30	DOUBLE PANEL WINDOW
7.	W7	0.70	2.30	1.30	DOUBLE PANEL WINDOW

LEGEND:

■	EXISTING
■	PROPOSED

PROJECT:-
ASSAM STATE SECONDARY HEALTHCARE
INITIATIVE FOR SERVICE DELIVERY
TRANSFORMATION (ASSIST)

CLIENT:-
ASSAM HEALTH INFRASTRUCTURE
DEVELOPMENT & MANAGEMENT SOCIETY
(AHIDMS)

PRINCIPAL CONSULTANT:



INTEGRA VENTURES
CONSULTING & PROJECT MANAGEMENT
PVT. LTD. ASSAM
B-10, KAMRUP NAGAR, DISPUR, ASSAM
781 005

STAGE:- DPR

DRAWING NO:-
2024/ASSIST-KAR/DH/PROP/01/GF

START DATE	ISSUE DATE	SHEET SIZE
	10-02-2025	A3


PROJECT CODE:- 2024/ASSIST-KAR/DH

SCALE:- N.T.S

BLOCK NO:- 1

FLOOR:- GROUND FLOOR

DRAWING TITLE:-
BLOCK 1 GROUND FLOOR PLAN PLUMBING
LAYOUT,
KARIMGANJ CIVIL HOSPITAL, KARIMGANJ,
ASSAM

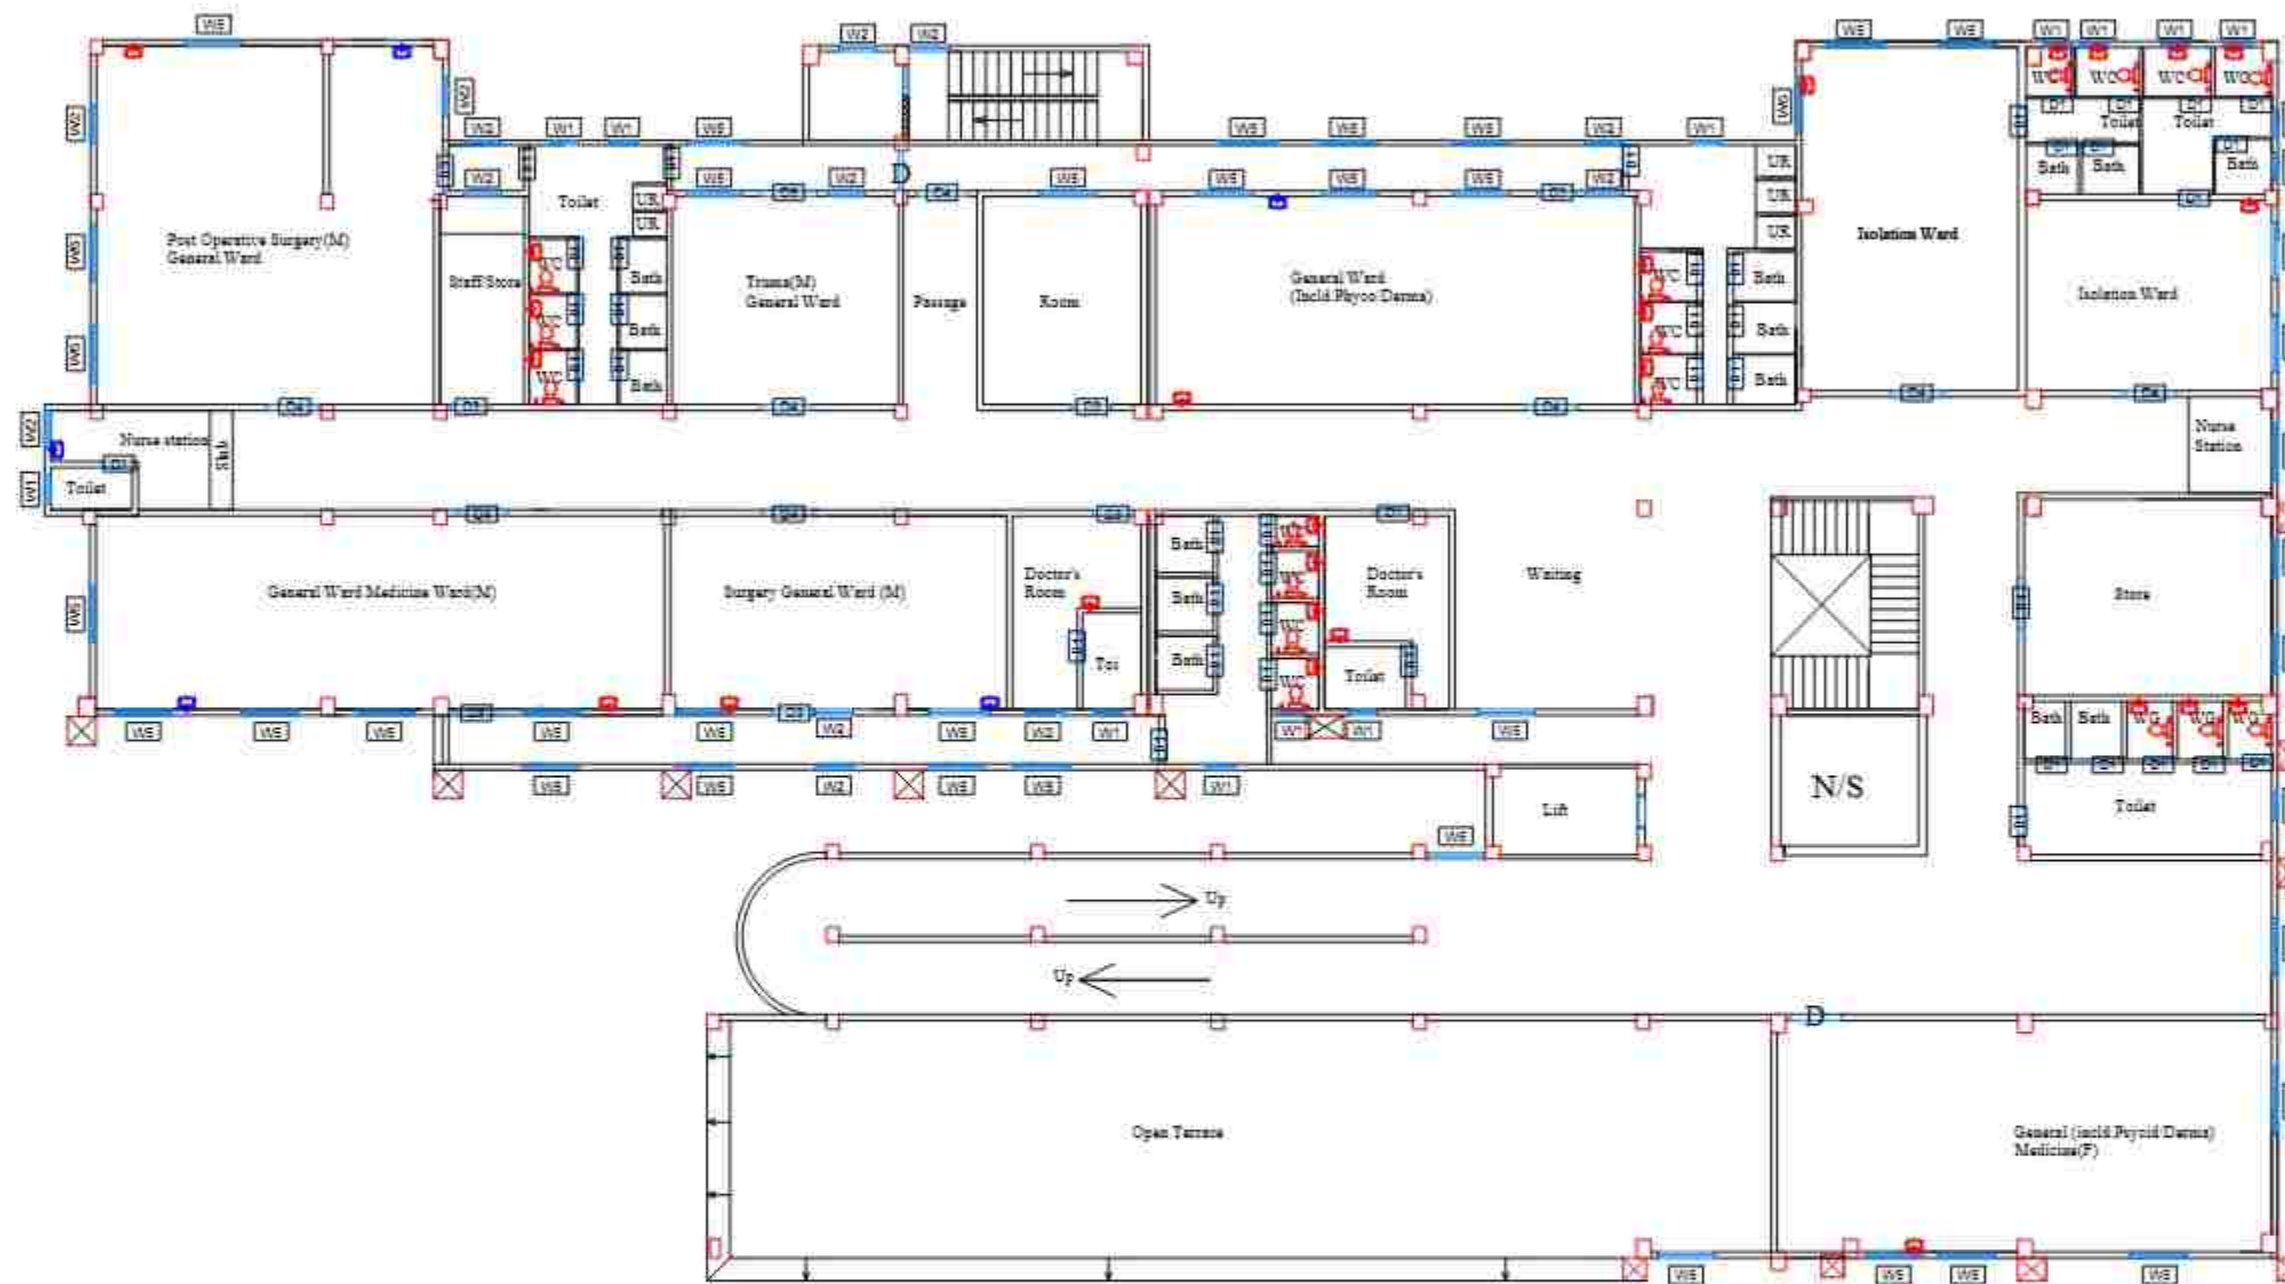

DOOR SCHEDULE:-

SNO	NAME	WIDTH	HEIGHT	REMARKS
1.	D1	0.75	2.00	SINGLE PANEL DOOR
2.	D2	0.90	2.00	SINGLE PANEL DOOR
3.	D3	1.05	2.00	SINGLE PANEL DOOR
4.	D4	1.20	2.00	SINGLE PANEL DOOR
4.	D4d	1.20	2.00	DOUBLE PANEL DOOR
5.	D5	1.50	2.00	DOUBLE PANEL DOOR
6.	D6	1.80	2.00	DOUBLE PANEL DOOR
7.	D7	2.00	2.00	DOUBLE PANEL DOOR

WINDOW SCHEDULE:-

SNO	NAME	SLL	WIDTH	HEIGHT	REMARKS
1.	W1	1.40	0.90	0.90	SINGLE PANEL WINDOW
2.	W2	0.70	0.90	1.30	SINGLE PANEL WINDOW
3.	W3	0.70	1.05	1.30	SINGLE PANEL WINDOW
4.	W4	0.70	1.20	1.30	DOUBLE PANEL WINDOW
5.	W5	0.70	1.50	1.30	DOUBLE PANEL WINDOW
6.	W6	0.70	1.80	1.30	DOUBLE PANEL WINDOW
7.	W7	0.70	2.20	1.30	DOUBLE PANEL WINDOW

LEGEND:



PROJECT:-
ASSAM STATE SECONDARY HEALTHCARE
INITIATIVE FOR SERVICE DELIVERY
TRANSFORMATION (ASSIST)

CLIENT:-
ASSAM HEALTH INFRASTRUCTURE
DEVELOPMENT & MANAGEMENT SOCIETY
(AHIDMS)

PRINCIPAL CONSULTANT:



PROFESSIONAL SEAL AND SIGNATURE OF THE
REGISTERED ARCHITECT/ENGINEER/PLUMBER
IN THE STATE OF ASSAM
NO. 100/2017/100

STAGE:- DPR

DRAWING NO:-
2024/ASSIST-KAR/DHP-PROP/01/SF

START DATE: 10-02-2025
ISSUE DATE: 10-02-2025
SHEET SIZE: A3


PROJECT CODE:- 2024/ASSIST-KAR/DH

SCALE:- N.T.S

BLOCK NO:- 1

FLOOR:- SECOND FLOOR

DRAWING TITLE:-
BLOCK 1 SECOND FLOOR PLAN PLUMBING
LAYOUT,
KARIMGANJ CIVIL HOSPITAL, KARIMGANJ,
ASSAM

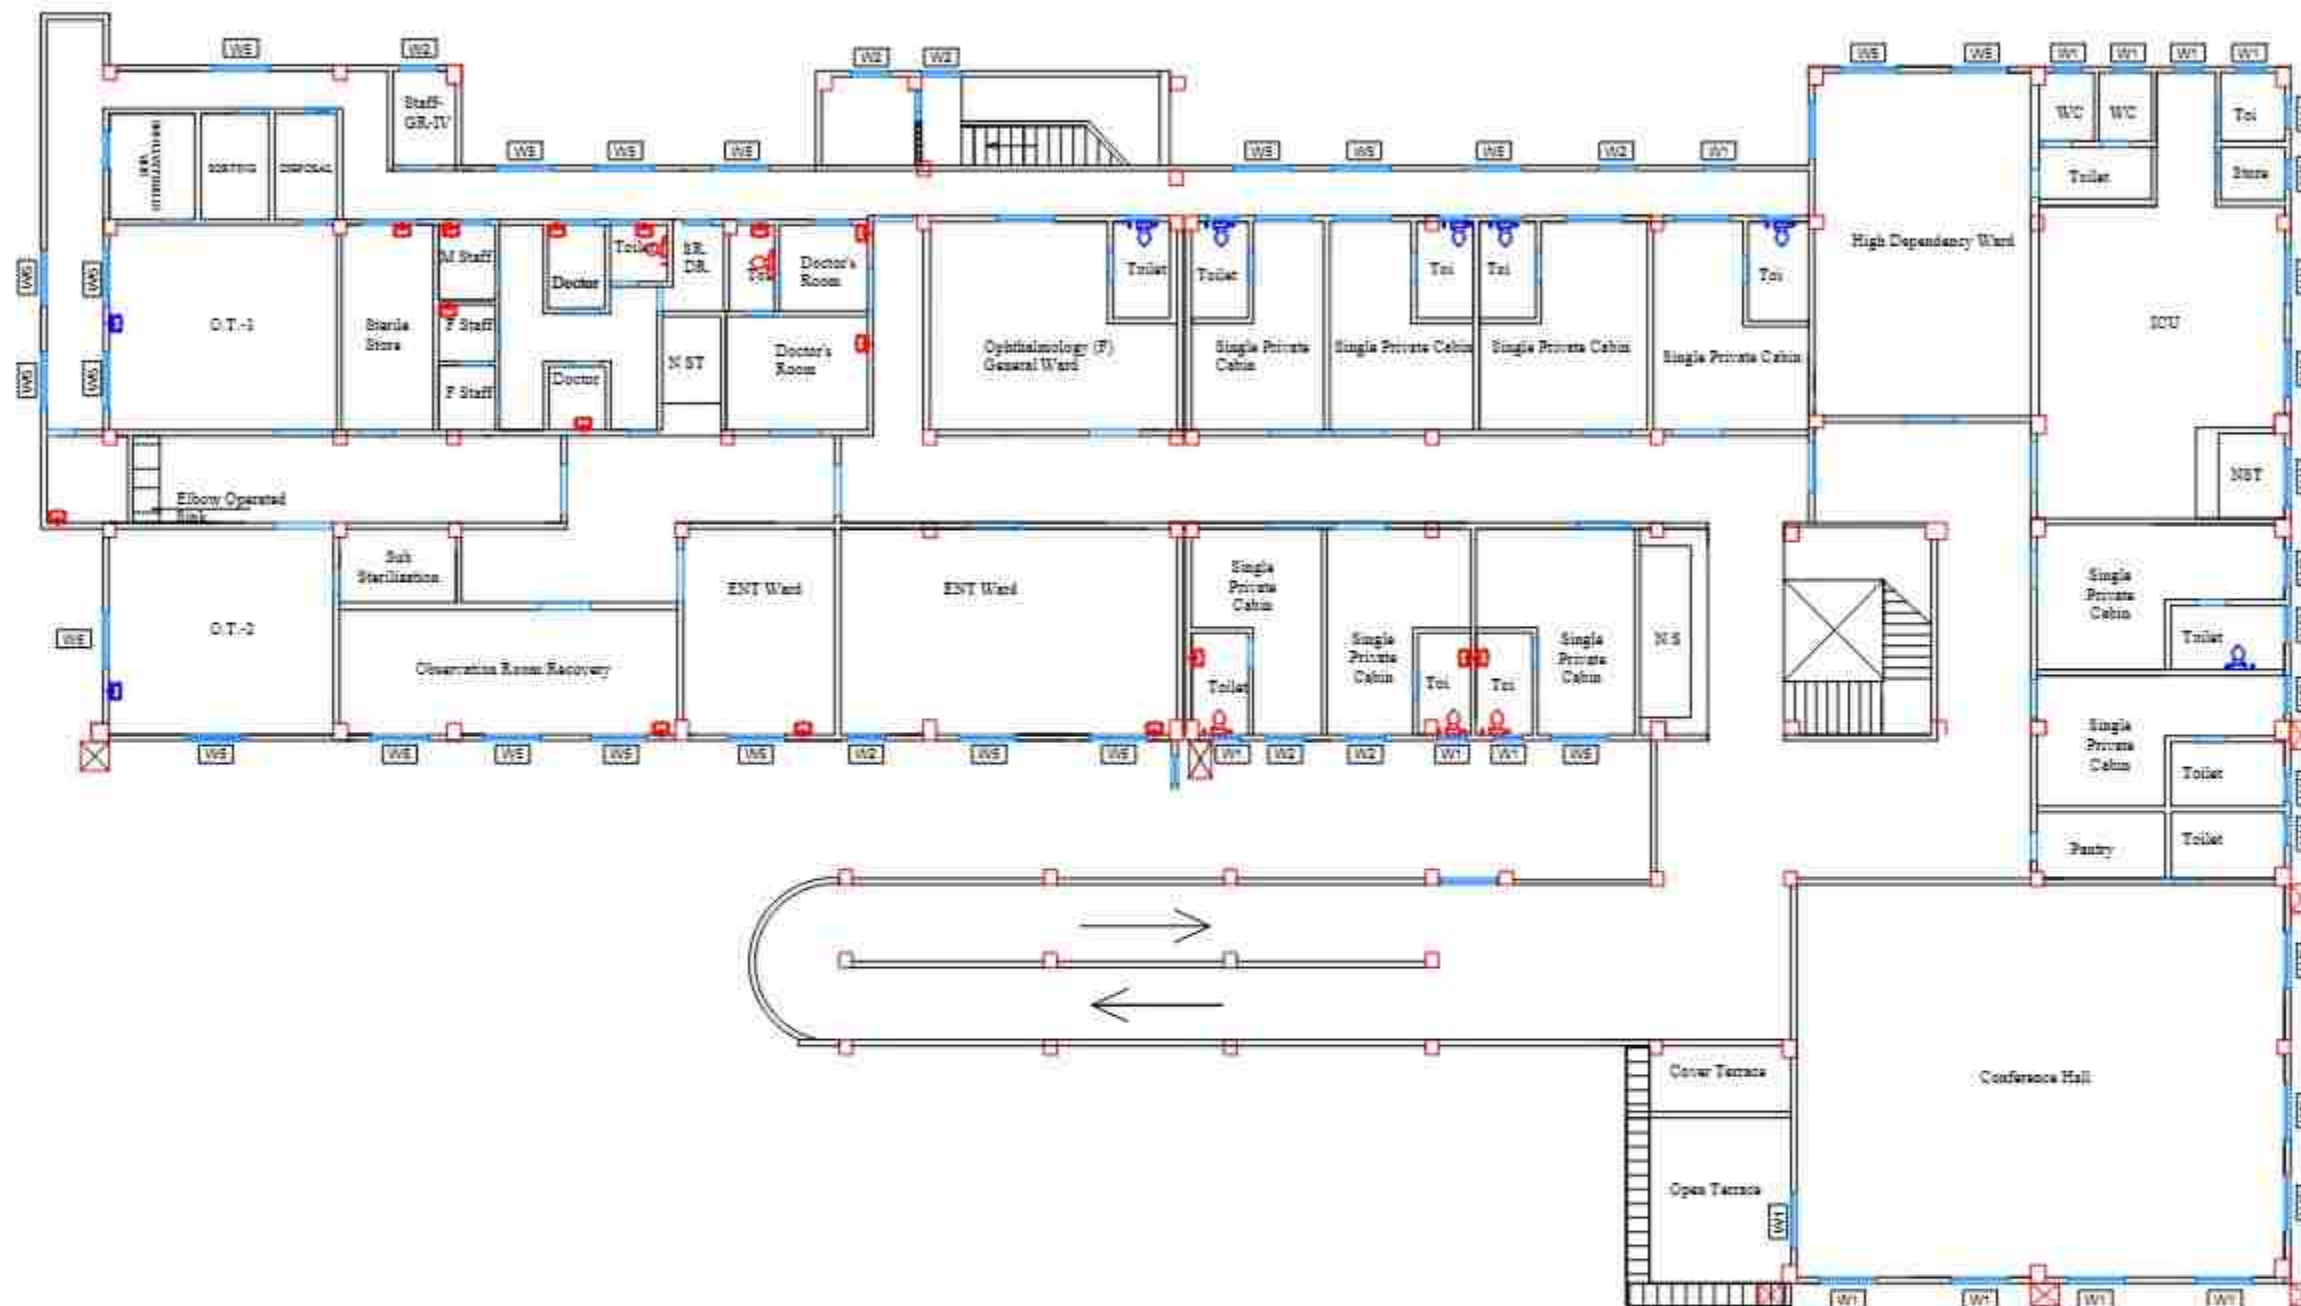

DOOR SCHEDULE:-

SNO	NAME	WIDTH	HEIGHT	REMARKS
1.	D1	0.75	2.00	SINGLE PANEL DOOR
2.	D2	0.90	2.00	SINGLE PANEL DOOR
3.	D3	1.05	2.00	SINGLE PANEL DOOR
4.	D4	1.20	2.00	SINGLE PANEL DOOR
4.	D4d	1.20	2.00	DOUBLE PANEL DOOR
5.	D5	1.50	2.00	DOUBLE PANEL DOOR
6.	D6	1.80	2.00	DOUBLE PANEL DOOR
7.	D7	2.00	2.00	DOUBLE PANEL DOOR

WINDOW SCHEDULE:-

SNO	NAME	SILL	WIDTH	HEIGHT	REMARKS
1.	W1	1.40	0.60	2.80	SINGLE PANEL WINDOW
2.	W2	0.70	0.90	1.30	SINGLE PANEL WINDOW
3.	W3	0.70	1.05	1.30	SINGLE PANEL WINDOW
4.	W4	0.70	1.20	1.30	DOUBLE PANEL WINDOW
5.	W5	0.70	1.50	1.30	DOUBLE PANEL WINDOW
6.	W6	0.70	1.80	1.30	DOUBLE PANEL WINDOW
7.	W7	0.70	2.00	1.30	DOUBLE PANEL WINDOW

LEGEND:-

 	EXISTING
 	PROPOSED

PROJECT:-
ASSAM STATE SECONDARY HEALTHCARE
INITIATIVE FOR SERVICE DELIVERY
TRANSFORMATION (ASSIST)

CLIENT:-
ASSAM HEALTH INFRASTRUCTURE
DEVELOPMENT & MANAGEMENT SOCIETY
(AHIDMS)

PRINCIPAL CONSULTANT:-



STAGE:- DPR

DRAWING NO:-
2024/ASSIST-KAR/DH/P/PROP/01/TF

START DATE **ISSUE DATE** **SHEET SIZE**
 10-02-2025 A3

PROJECT CODE:- 2024/ASSIST-KAR/DH

SCALE:- N.T.S.

BLOCK NO:- 1

FLOOR:- THIRD FLOOR

DRAWING TITLE:-
BLOCK 1 THIRD FLOOR PLAN PLUMBING
LAYOUT,
KARIMGANJ CIVIL HOSPITAL, KARIMGANJ,
ASSAM

PROJECT:-
ASSAM STATE SECONDARY HEALTHCARE
INITIATIVE FOR SERVICE DELIVERY
TRANSFORMATION (ASSIST)

CLIENT:-
ASSAM HEALTH INFRASTRUCTURE
DEVELOPMENT & MANAGEMENT SOCIETY
(AHIDMS)

PRINCIPAL CONSULTANT:-



HEALTHCARE DESIGN & CONSTRUCTION
ARCHITECTURE, INTERIORS, MEP, ELECTRICAL & CIVIL ENGINEERING

STAGE:- DPR

DRAWING NO:-
2024/ASSIST-KARDH/PROP/02/FF

START DATE	ISSUE DATE	SHEET SIZE
	10-02-2025	A3

PROJECT CODE:- 2024/ASSIST-KARDH

SCALE:- N.T.S.


BLOCK NO:- 2

FLOOR:- FIRST FLOOR

DRAWING TITLE:-
BLOCK 2 FIRST FLOOR PLAN PLUMBING
LAYOUT,
KARDIGANI CIVIL HOSPITAL, KARDIGANI,
ASSAM

LEGEND:

	EXISTING
	PROPOSED

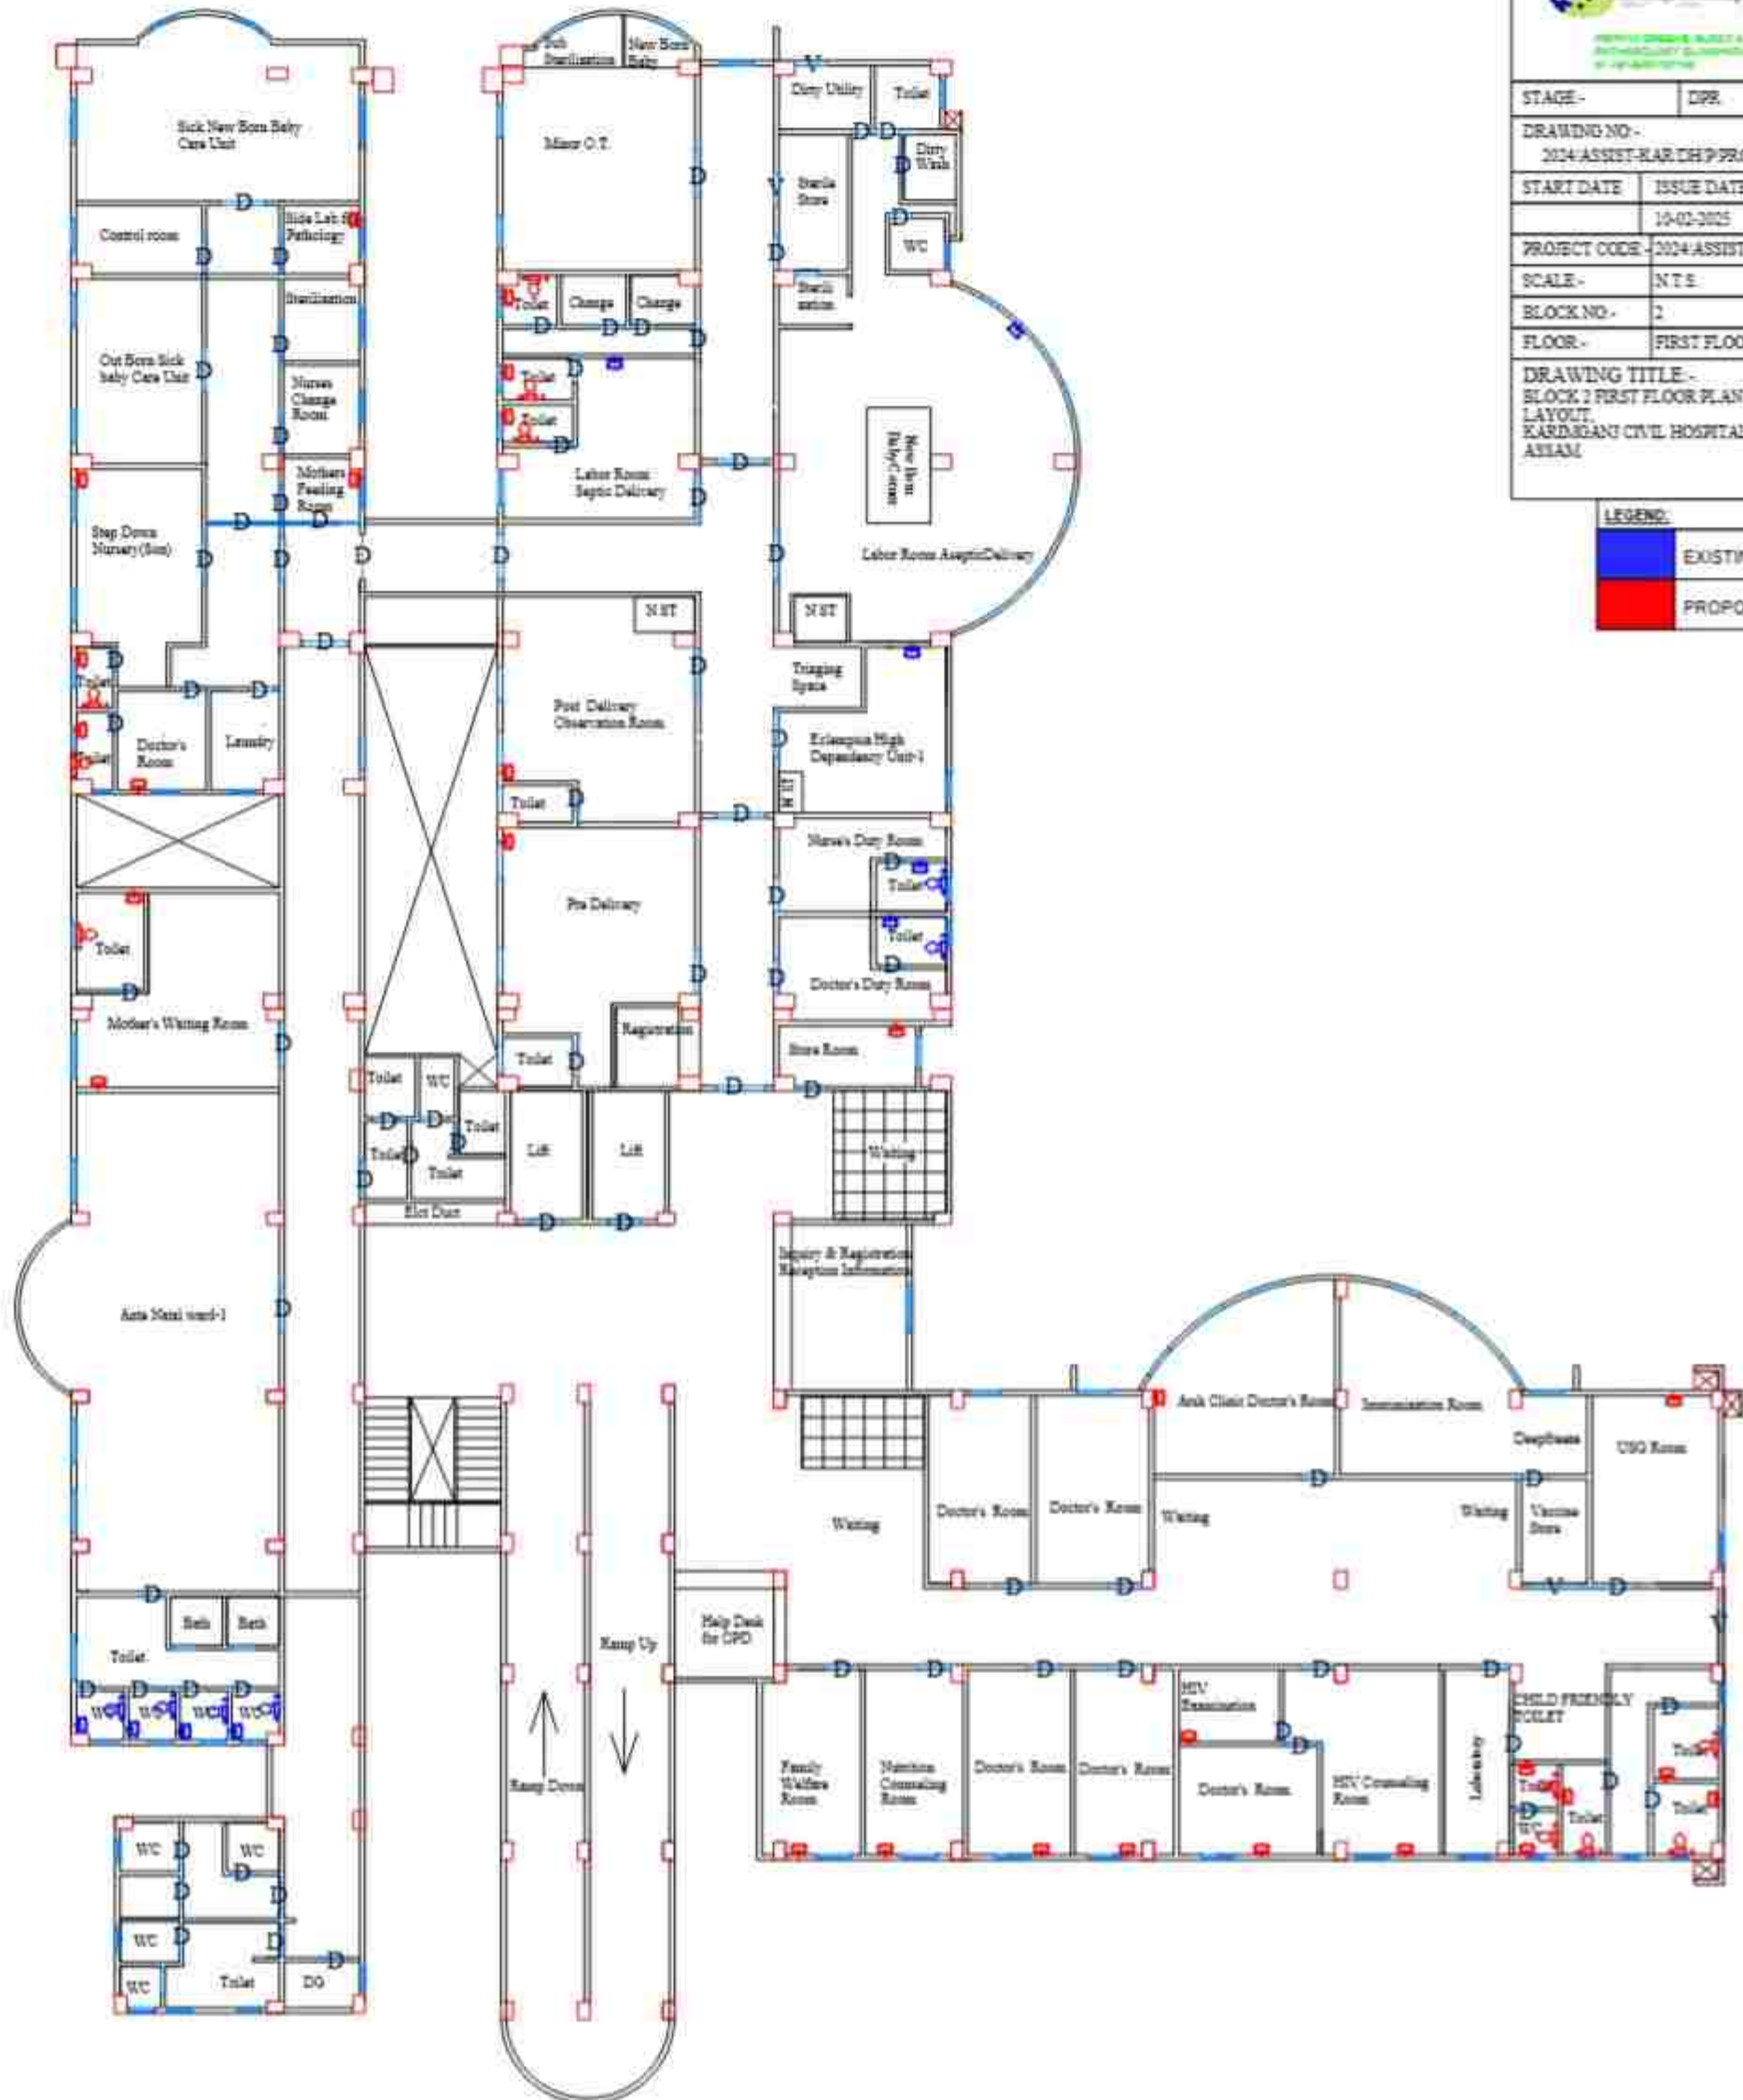

PROJECT:-
ASSAM STATE SECONDARY HEALTHCARE
INITIATIVE FOR SERVICE DELIVERY
TRANSFORMATION (ASSIST)

CLIENT:-
ASSAM HEALTH INFRASTRUCTURE
DEVELOPMENT & MANAGEMENT SOCIETY
(AHIDMS)

PRINCIPAL CONSULTANT:



INTEGRA VENTURES
Healthcare Planning & Design
Healthcare Planning & Design Pvt. Ltd.
10/10, Sector 10, Gurgaon, Haryana

STAGE - DPR

DRAWING NO -
2024/ASSIST-KARDH/PROP-02/GF

START DATE	ISSUE DATE	SHEET SIZE
	10-02-2025	A3

PROJECT CODE - 2024/ASSIST-KARDH

SCALE - N.T.S.


BLOCK NO - 2

FLOOR - GROUND FLOOR

DRAWING TITLE -
BLOCK 2 GROUND FLOOR PLAN PLUMBING
LAYOUT,
KARDIGANI CIVIL HOSPITAL, KARDIGANI,
ASSAM.

LEGEND

	EXISTING
	PROPOSED

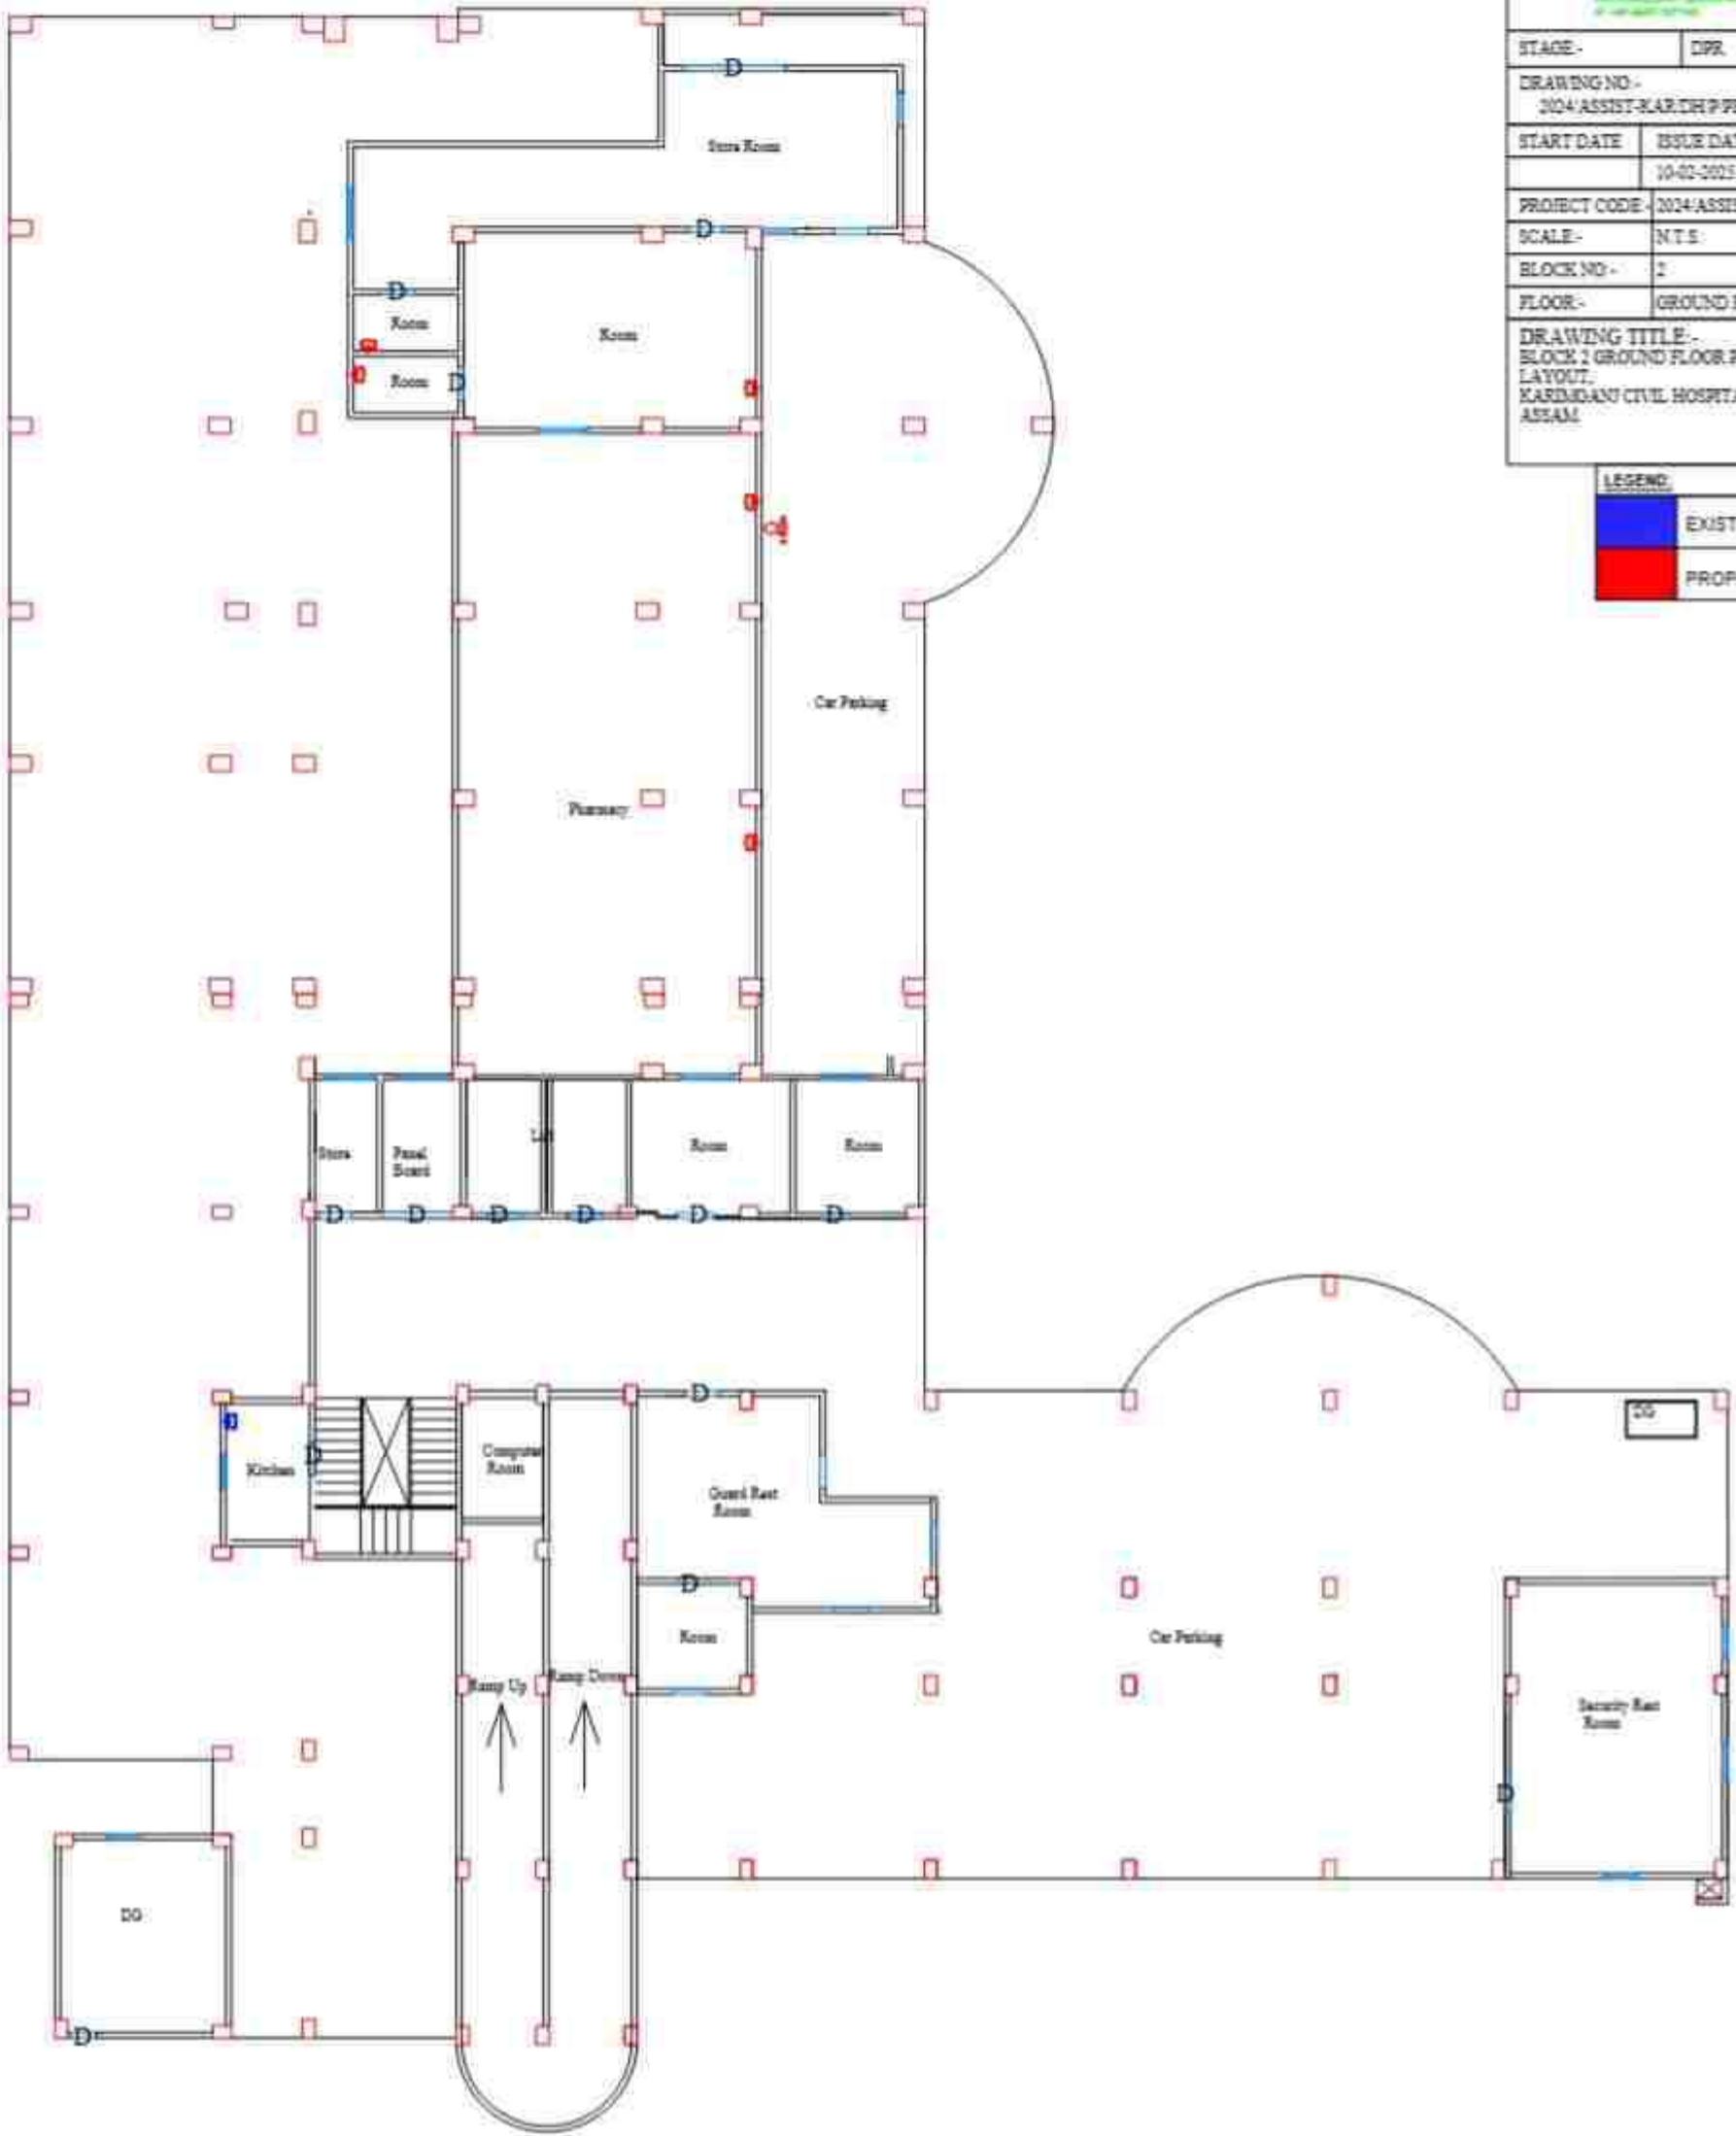

PROJECT:-
ASSAM STATE SECONDARY HEALTHCARE
INITIATIVE FOR SERVICE DELIVERY
TRANSFORMATION (ASSIST)

CLIENT:-
ASSAM HEALTH INFRASTRUCTURE
DEVELOPMENT & MANAGEMENT SOCIETY
(AHIMS)

PRINCIPAL CONSULTANT:



HEALTHCARE & BUILDING DESIGN & CONSTRUCTION
SOLUTIONS

STAGE:-

DPR

DRAWING NO:-

2024-ASSIST-KAR.DH.P-PROP-02-SF

START DATE

ISSUE DATE

SHEET SIZE

19-02-2025

A3

PROJECT CODE

2024-ASSIST-KAR.DH

SCALE:-

N.T.S.

BLOCK NO:-

2

FLOOR:-

SECOND FLOOR

DRAWING TITLE:-

BLOCK 2 SECOND FLOOR PLAN PLUMBING
LAYOUT,
KARDIGANI CIVIL HOSPITAL, KARDIGANI,
ASSAM

LEGEND:

	EXISTING
	PROPOSED



PROJECT:-
ASSAM STATE SECONDARY HEALTHCARE
INITIATIVE FOR SERVICE DELIVERY
TRANSFORMATION (ASSIST)

CLIENT:-
ASSAM HEALTH INFRASTRUCTURE
DEVELOPMENT & MANAGEMENT SOCIETY
(AHIMS)

PRINCIPAL CONSULTANT:-



PROVIDING DESIGN, BUILD & MAINTENANCE
CONTRACTS FOR HEALTHCARE
IN ASSAM

STAGE:- DPR

DRAWING NO:-
2024/ASSIST-KAR.DH/PROP/02/TF

START DATE	ISSUE DATE	SHEET SIZE
	10-02-2025	A3

PROJECT CODE:- 2024/ASSIST-KAR.DH

SCALE:- N.T.S.


BLOCK NO:- 2


FLOOR:- THIRD FLOOR

DRAWING TITLE:-
BLOCK 2 THIRD FLOOR PLAN PLUMBING
LAYOUT,
KARIMJANU CIVIL HOSPITAL, KARIMJANU,
ASSAM

LEGEND:

	EXISTING
	PROPOSED

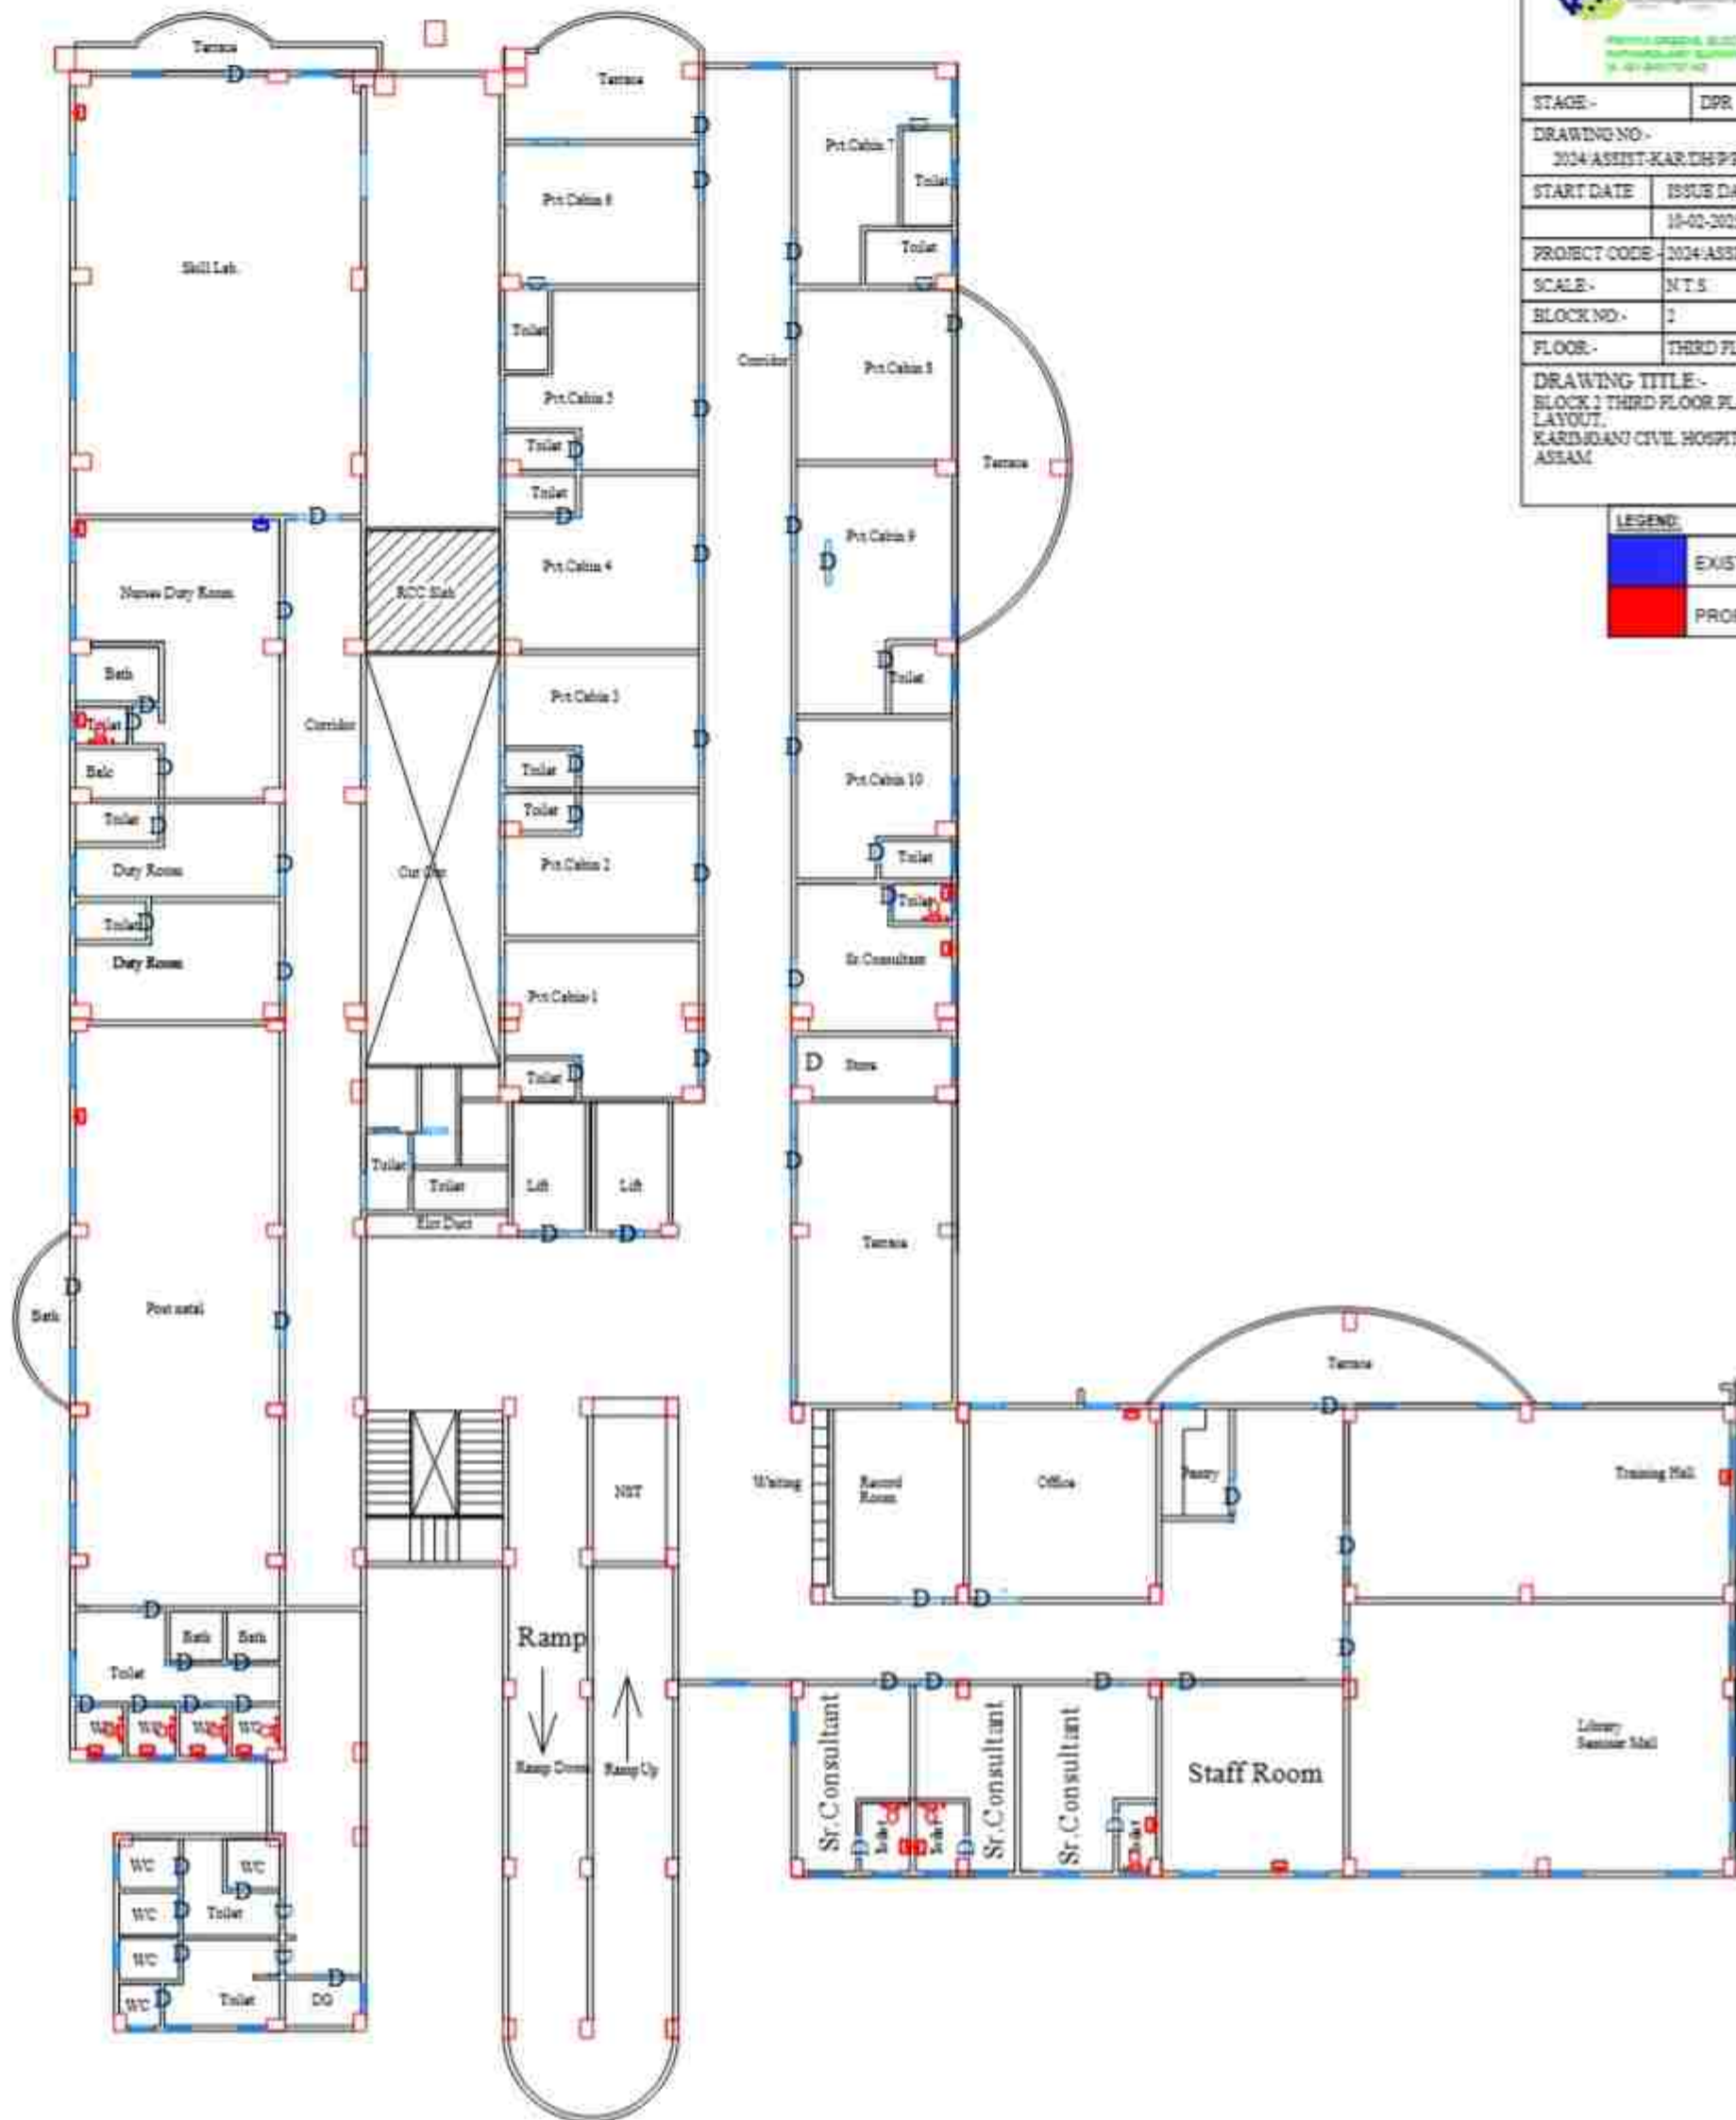

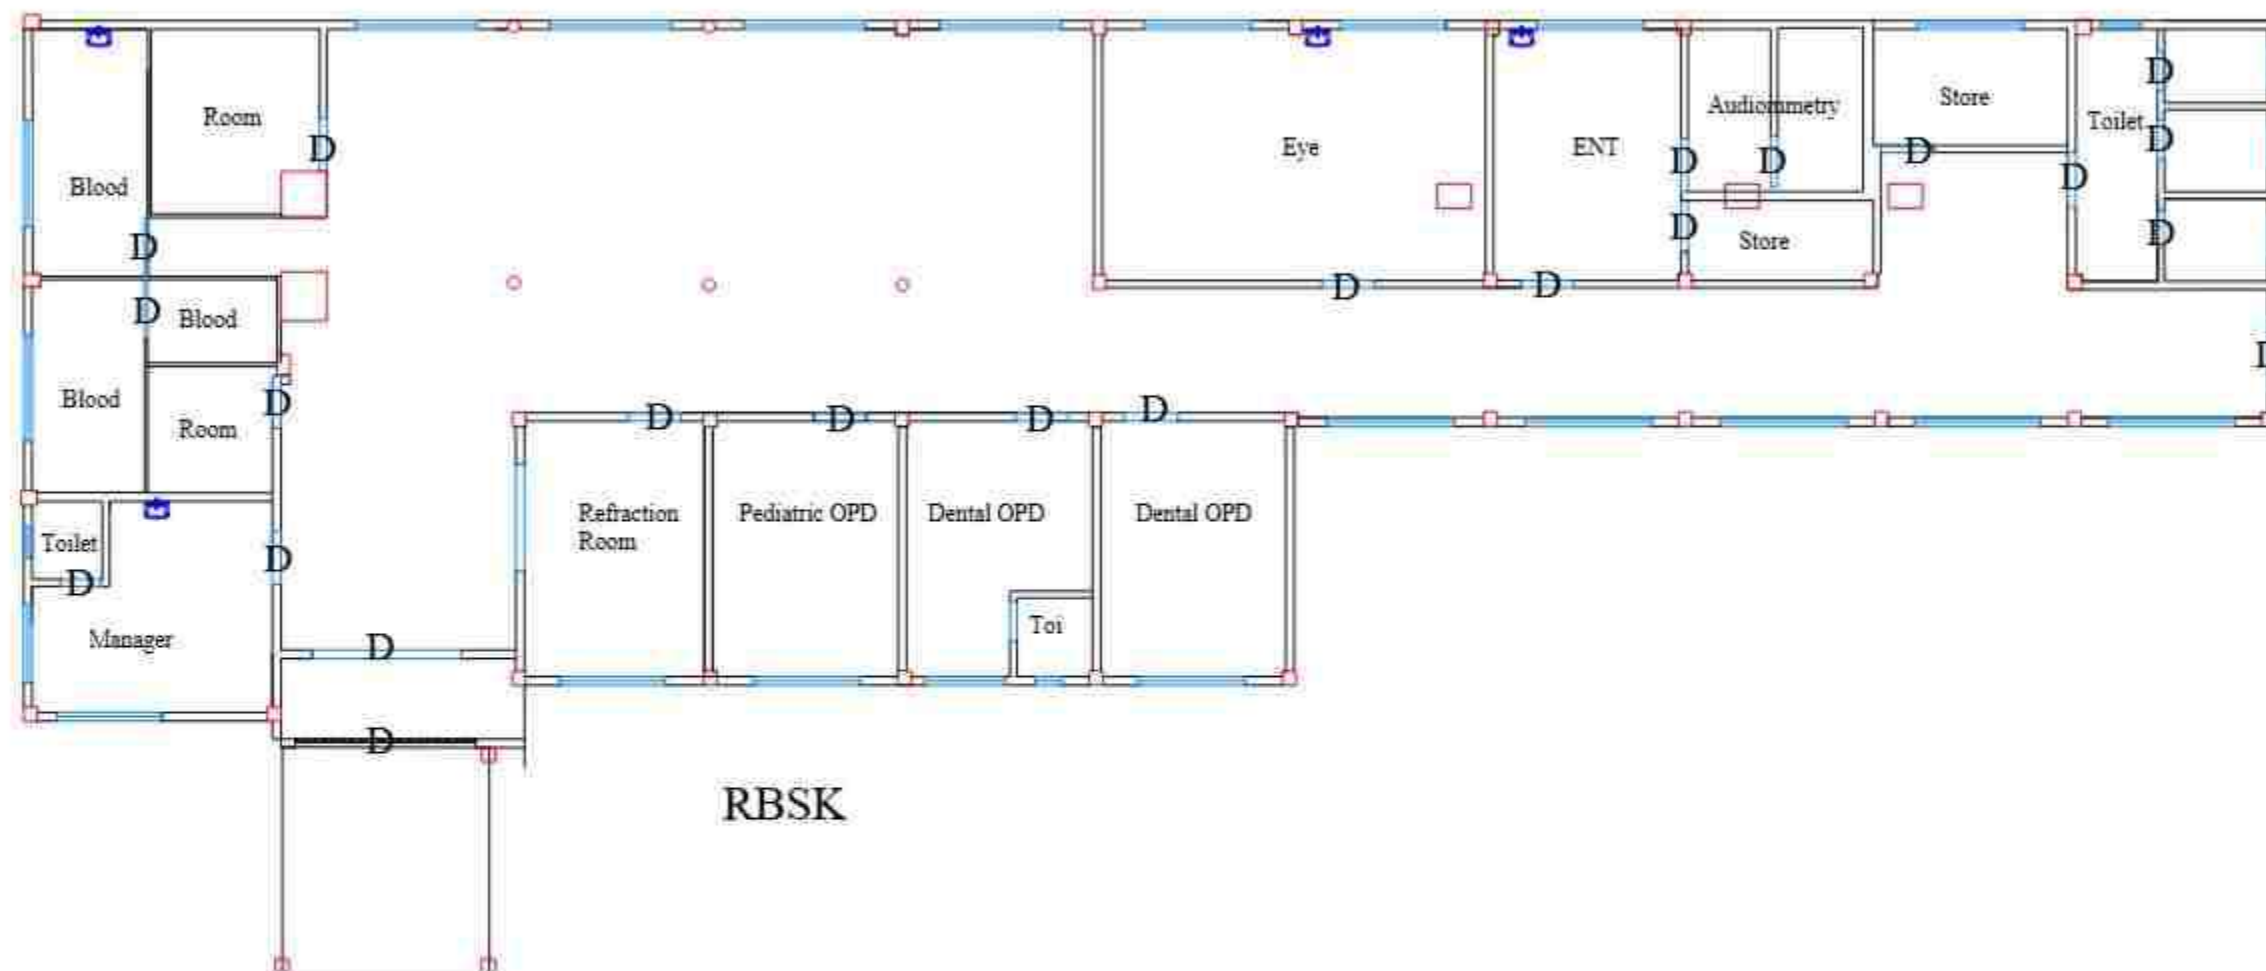

RBSK

LEGEND:

	EXISTING
	PROPOSED

PROJECT:-
ASSAM STATE SECONDARY HEALTHCARE
INITIATIVE FOR SERVICE DELIVERY
TRANSFORMATION (ASSIST)

CLIENT:-
ASSAM HEALTH INFRASTRUCTURE
DEVELOPMENT & MANAGEMENT SOCIETY
(AHIDMS)

PRINCIPAL CONSULTANT:



STAGE:- DPR

DRAWING NO:-
2024/ASSIST-KAR/DH/PROP/03

START DATE	ISSUE DATE	SHEET SIZE
	10-02-2025	A3


PROJECT CODE:- 2024/ASSIST-KAR/DH

SCALE:- N.T.S.

BLOCK NO:- 3

FLOOR:- GROUND FLOOR

DRAWING TITLE:-
BLOCK 3 GROUND FLOOR PLAN PLUMBING
LAYOUT,
KARDIGANJ CIVIL HOSPITAL, KARIMGANJ,
ASSAM

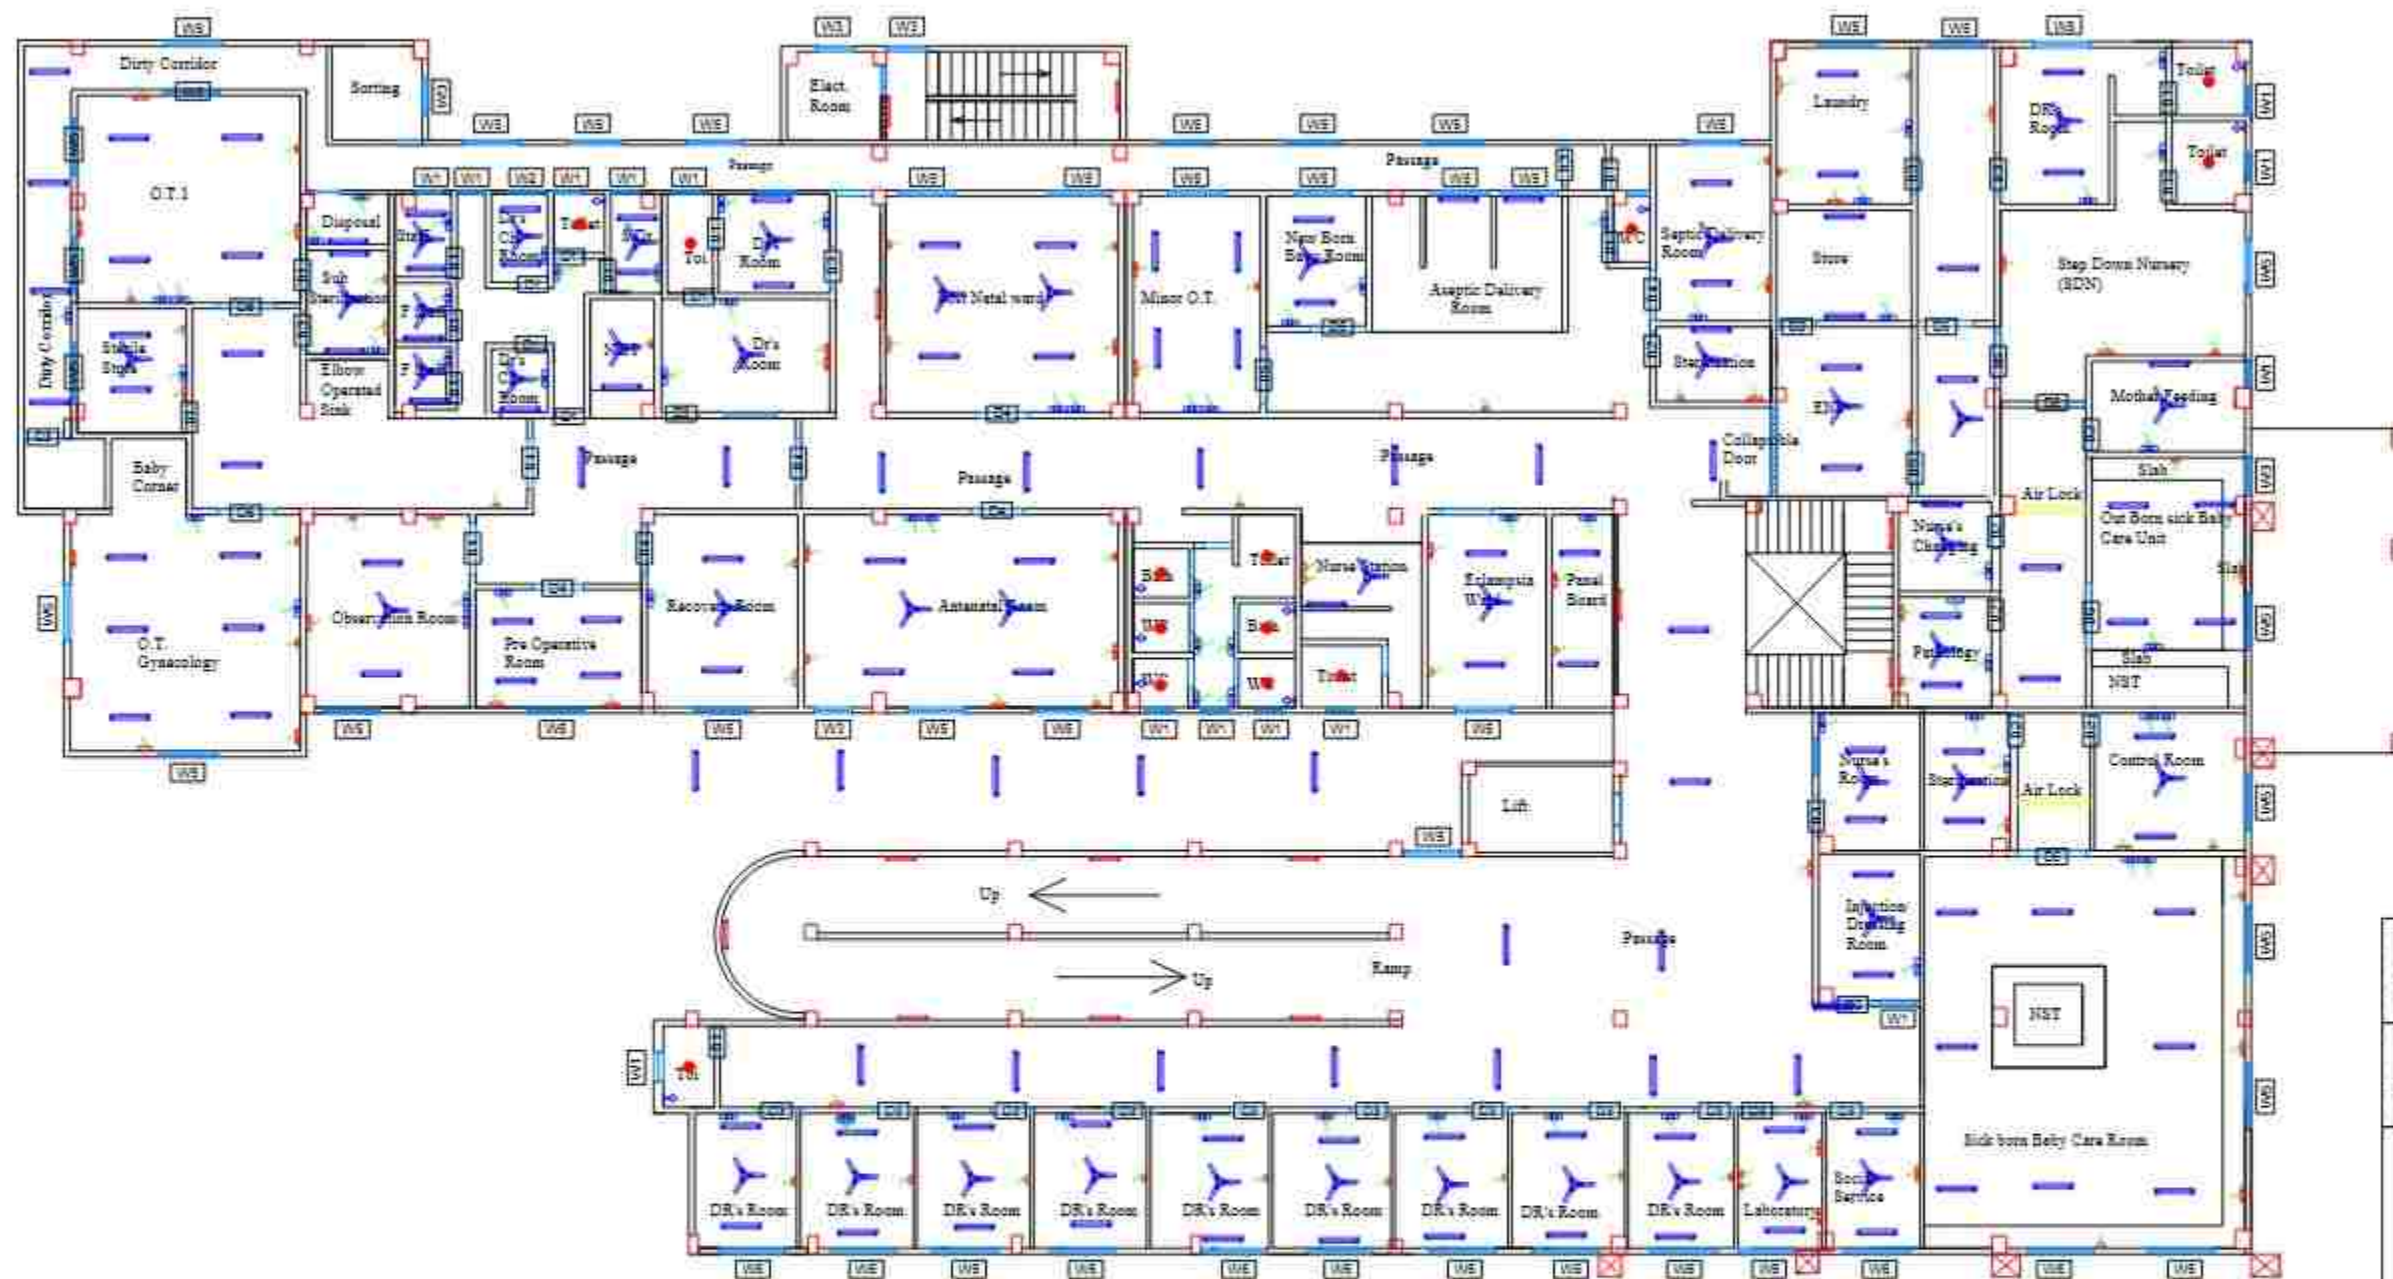

DOOR SCHEDULE:-

SNO	NAME	WIDTH	HEIGHT	REMARKS
1.	D1	0.75	2.00	SINGLE PANEL DOOR
2.	D2	0.90	2.00	SINGLE PANEL DOOR
3.	D3	1.05	2.00	SINGLE PANEL DOOR
4.	D4	1.20	2.00	SINGLE PANEL DOOR
4.	D4a	1.20	2.00	DOUBLE PANEL DOOR
5.	D5	1.50	2.00	DOUBLE PANEL DOOR
6.	D6	1.80	2.00	DOUBLE PANEL DOOR
7.	D7	2.00	2.00	DOUBLE PANEL DOOR

WINDOW SCHEDULE:-

SNO	NAME	SILL	WIDTH	HEIGHT	REMARKS
1.	W1	1.40	0.80	0.80	SINGLE PANEL WINDOW
2.	W2	0.75	0.90	1.30	SINGLE PANEL WINDOW
2.	W3	0.70	1.05	1.30	SINGLE PANEL WINDOW
4.	W4	0.70	1.20	1.30	DOUBLE PANEL WINDOW
5.	W5	0.70	1.50	1.30	DOUBLE PANEL WINDOW
6.	W6	0.70	1.80	1.30	DOUBLE PANEL WINDOW
7.	W7	0.75	2.00	1.30	DOUBLE PANEL WINDOW

AS BUILT LEGEND:

	1200 MM CEILING FAN
	20W LED TUBE LIGHT
	SWITCH BOARD
	BULB
	WALL FAN
	ROUND DOWN LIGHT

PROPOSED LEGEND:

	6A POWER POINT
	16A POWER POINT
	8/16A POWER POINT
	SWITCH BOARD
	20W LED TUBE LIGHT
	1200 MM CEILING FAN
	12W DOWNLIGHT
	300 MM EXHAUST FAN

PROJECT:-
ASSAM STATE SECONDARY HEALTHCARE
INITIATIVE FOR SERVICE DELIVERY
TRANSFORMATION (ASSIST)

CLIENT:-
ASSAM HEALTH INFRASTRUCTURE
DEVELOPMENT & MANAGEMENT SOCIETY
(AHIDMS)

PRINCIPAL CONSULTANT:
INTEGRA VENTURES
PVT. LTD.
B-10, SECTOR-10, KATRA, JALPAIGURI, WEST BENGAL
(PIN-743122)

STAGE:- DPR

DRAWING NO:-
2024/ASSIST-KAR/DH/PROP/01/FF

START DATE	ISSUE DATE	SHEET SIZE
	10-02-2023	A3
PROJECT CODE - 2024/ASSIST-KAR/DH		
SCALE - N.T.S		
BLOCK NO - 1		
FLOOR - FIRST FLOOR		

DRAWING TITLE:-
BLOCK 1 FIRST FLOOR PLAN ELECTRICAL
LAYOUT,
KARIMGANJ CIVIL HOSPITAL, KARIMGANJ,
ASSAM



DOOR SCHEDULE:-

SNO	NAME	WIDTH	HEIGHT	REMARKS
1.	D1	0.75	2.00	SINGLE PANEL DOOR
2.	D2	0.90	2.00	SINGLE PANEL DOOR
3.	D3	1.00	2.00	SINGLE PANEL DOOR
4.	D4	1.20	2.00	DOUBLE PANEL DOOR
5.	D5	1.50	2.00	DOUBLE PANEL DOOR
6.	D6	1.80	2.00	DOUBLE PANEL DOOR
7.	D7	2.00	2.00	DOUBLE PANEL DOOR

WINDOW SCHEDULE:-

SNO	NAME	SILL	WIDTH	HEIGHT	REMARKS
1.	W1	1.40	0.60	0.80	SINGLE PANEL WINDOW
2.	W2	0.70	0.90	1.30	SINGLE PANEL WINDOW
3.	W3	0.70	1.00	1.50	SINGLE PANEL WINDOW
4.	W4	0.70	1.20	1.50	DOUBLE PANEL WINDOW
5.	W5	0.70	1.50	1.30	DOUBLE PANEL WINDOW
6.	W6	0.70	1.80	1.30	DOUBLE PANEL WINDOW
7.	W7	0.70	2.00	1.30	DOUBLE PANEL WINDOW

A5 BUILT LEGEND:

	1200 MM CEILING FAN
	20W LED TUBELIGHT
	SWITCH BOARD
	BULB
	WALL FAN
	ROUND DOWN LIGHT

PROPOSED LEGEND:

	6A POWER POINT
	15A POWER POINT
	6/15A POWER POINT
	SWITCH BOARD
	20W LED TUBELIGHT
	1200 MM CEILING FAN
	12W DOWNLIGHT
	300 MM EXHAUST FAN

PROJECT:-
ASSAM STATE SECONDARY HEALTHCARE
INITIATIVE FOR SERVICE DELIVERY
TRANSFORMATION (ASSIST)

CLIENT:-
ASSAM HEALTH INFRASTRUCTURE
DEVELOPMENT & MANAGEMENT SOCIETY
(AHIDMS)

PRINCIPAL CONSULTANT:-



STAGE:- DPR

DRAWING NO.:-
2024/ASSIST-KAR/DH/PROP/01/GF

START DATE	ISSUE DATE	SHEET SIZE
	10-07-2025	A5


PROJECT CODE:- 2024/ASSIST-KAR/DH

SCALE:- N.T.S.

BLOCK NO.:- I

FLOOR:- GROUND FLOOR

DRAWING TITLE:-
BLOCK 1 GROUND FLOOR PLAN
ELECTRICAL LAYOUT,
KARIMGANJ CIVIL HOSPITAL, KARIMGANJ,
ASSAM.

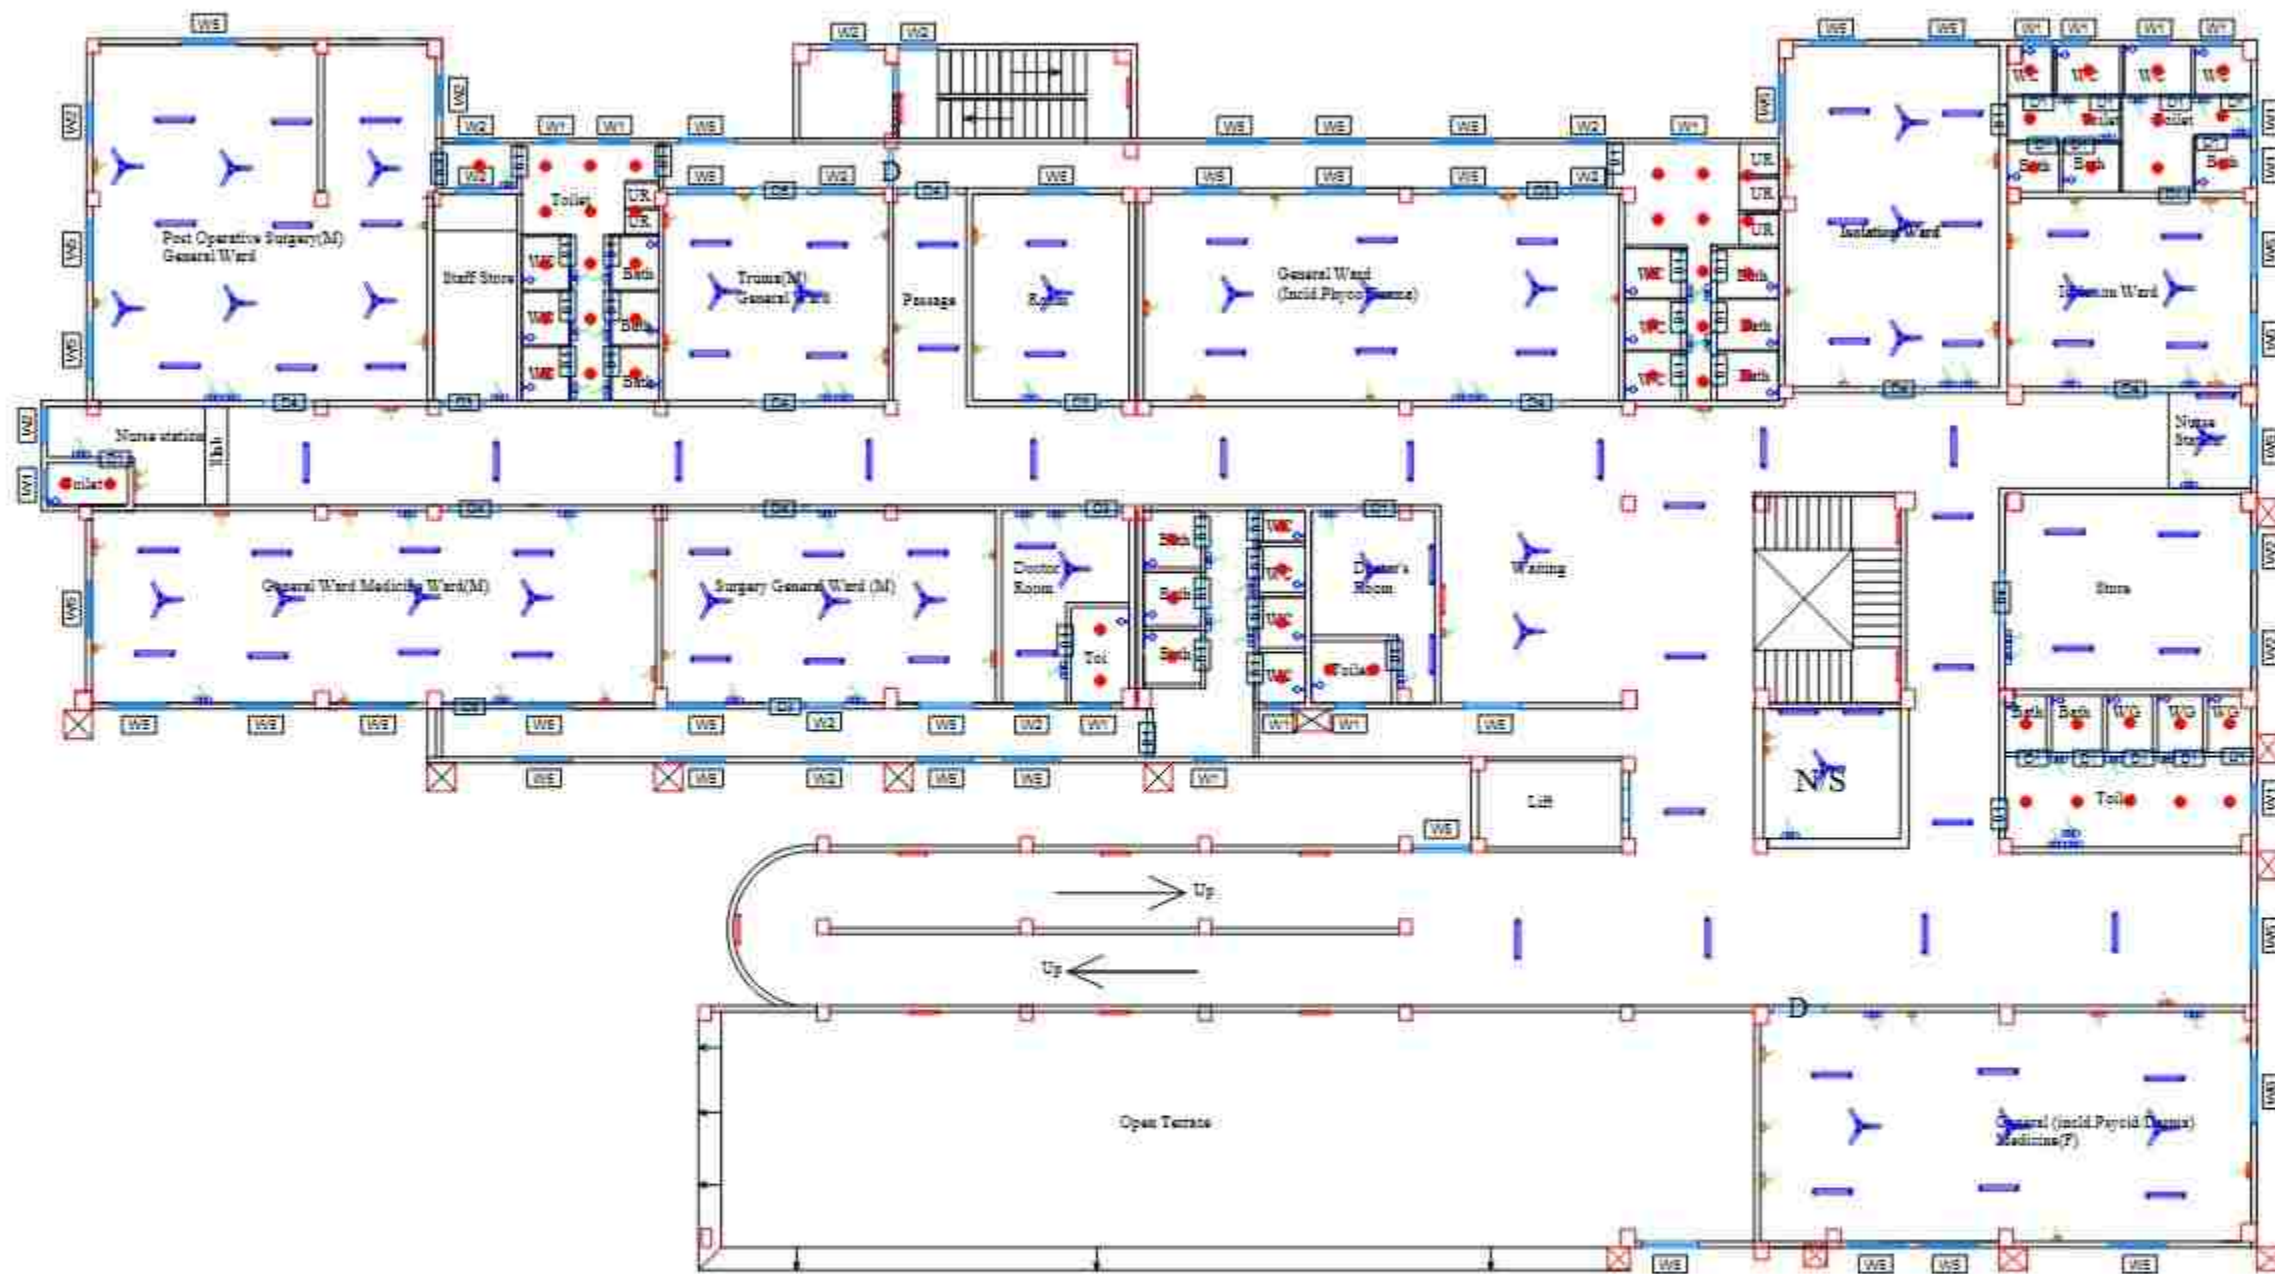

DOOR SCHEDULE:-

SNO	NAME	WIDTH	HEIGHT	REMARKS
1.	D1	0.75	2.00	SINGLE PANEL DOOR
2.	D2	0.90	2.00	SINGLE PANEL DOOR
3.	D3	1.05	2.00	SINGLE PANEL DOOR
4.	D4	1.20	2.00	SINGLE PANEL DOOR
4.	D4a	1.20	2.00	DOUBLE PANEL DOOR
5.	D5	1.50	2.00	DOUBLE PANEL DOOR
6.	D6	1.80	2.00	DOUBLE PANEL DOOR
7.	D7	2.00	2.00	DOUBLE PANEL DOOR

WINDOW SCHEDULE:-

SNO	NAME	SILL	WIDTH	HEIGHT	REMARKS
1.	W1	1.40	0.80	0.80	SINGLE PANEL WINDOW
2.	W2	0.70	0.90	1.30	SINGLE PANEL WINDOW
3.	W3	0.70	1.05	1.30	SINGLE PANEL WINDOW
4.	W4	0.70	1.20	1.30	DOUBLE PANEL WINDOW
5.	W5	0.70	1.50	1.30	DOUBLE PANEL WINDOW
6.	W6	0.70	1.80	1.30	DOUBLE PANEL WINDOW
7.	W7	0.70	2.00	1.30	DOUBLE PANEL WINDOW

AS BUILT LEGEND:

	1200 MM CEILING FAN
	20W LED TUBELIGHT
	SWITCH BOARD
	BULB
	WALL FAN
	ROUND DOWN LIGHT

PROPOSED LEGEND:

	6A POWER POINT
	16A POWER POINT
	8/16A POWER POINT
	SWITCH BOARD
	20W LED TUBELIGHT
	1200 MM CEILING FAN
	12W DOWNLIGHT
	300 MM EXHAUST FAN

PROJECT:-
ASSAM STATE SECONDARY HEALTHCARE
INITIATIVE FOR SERVICE DELIVERY
TRANSFORMATION (ASSIST)

CLIENT:-
ASSAM HEALTH INFRASTRUCTURE
DEVELOPMENT & MANAGEMENT SOCIETY
(AHIDMS)

PRINCIPAL CONSULTANT:



PROJECT OFFICE: BLOCK 1 SECOND FLOOR
KARINGANJI CIVIL HOSPITAL, KARINGANJI, ASSAM
IN-141001707045

STAGE:- DPR

DRAWING NO:-
2024/ASSIST-KAR/DH/B/PROP/01/5F

START DATE	ISSUE DATE	SHEET SIZE
	10-01-2025	A3


PROJECT CODE:- 2024/ASSIST-KAR/DH

SCALE:- N.T.S.

BLOCK NO:- 1

FLOOR:- SECOND FLOOR

DRAWING TITLE:-
BLOCK 1 SECOND FLOOR PLAN
ELECTRICAL LAYOUT,
KARINGANJI CIVIL HOSPITAL, KARINGANJI,
ASSAM

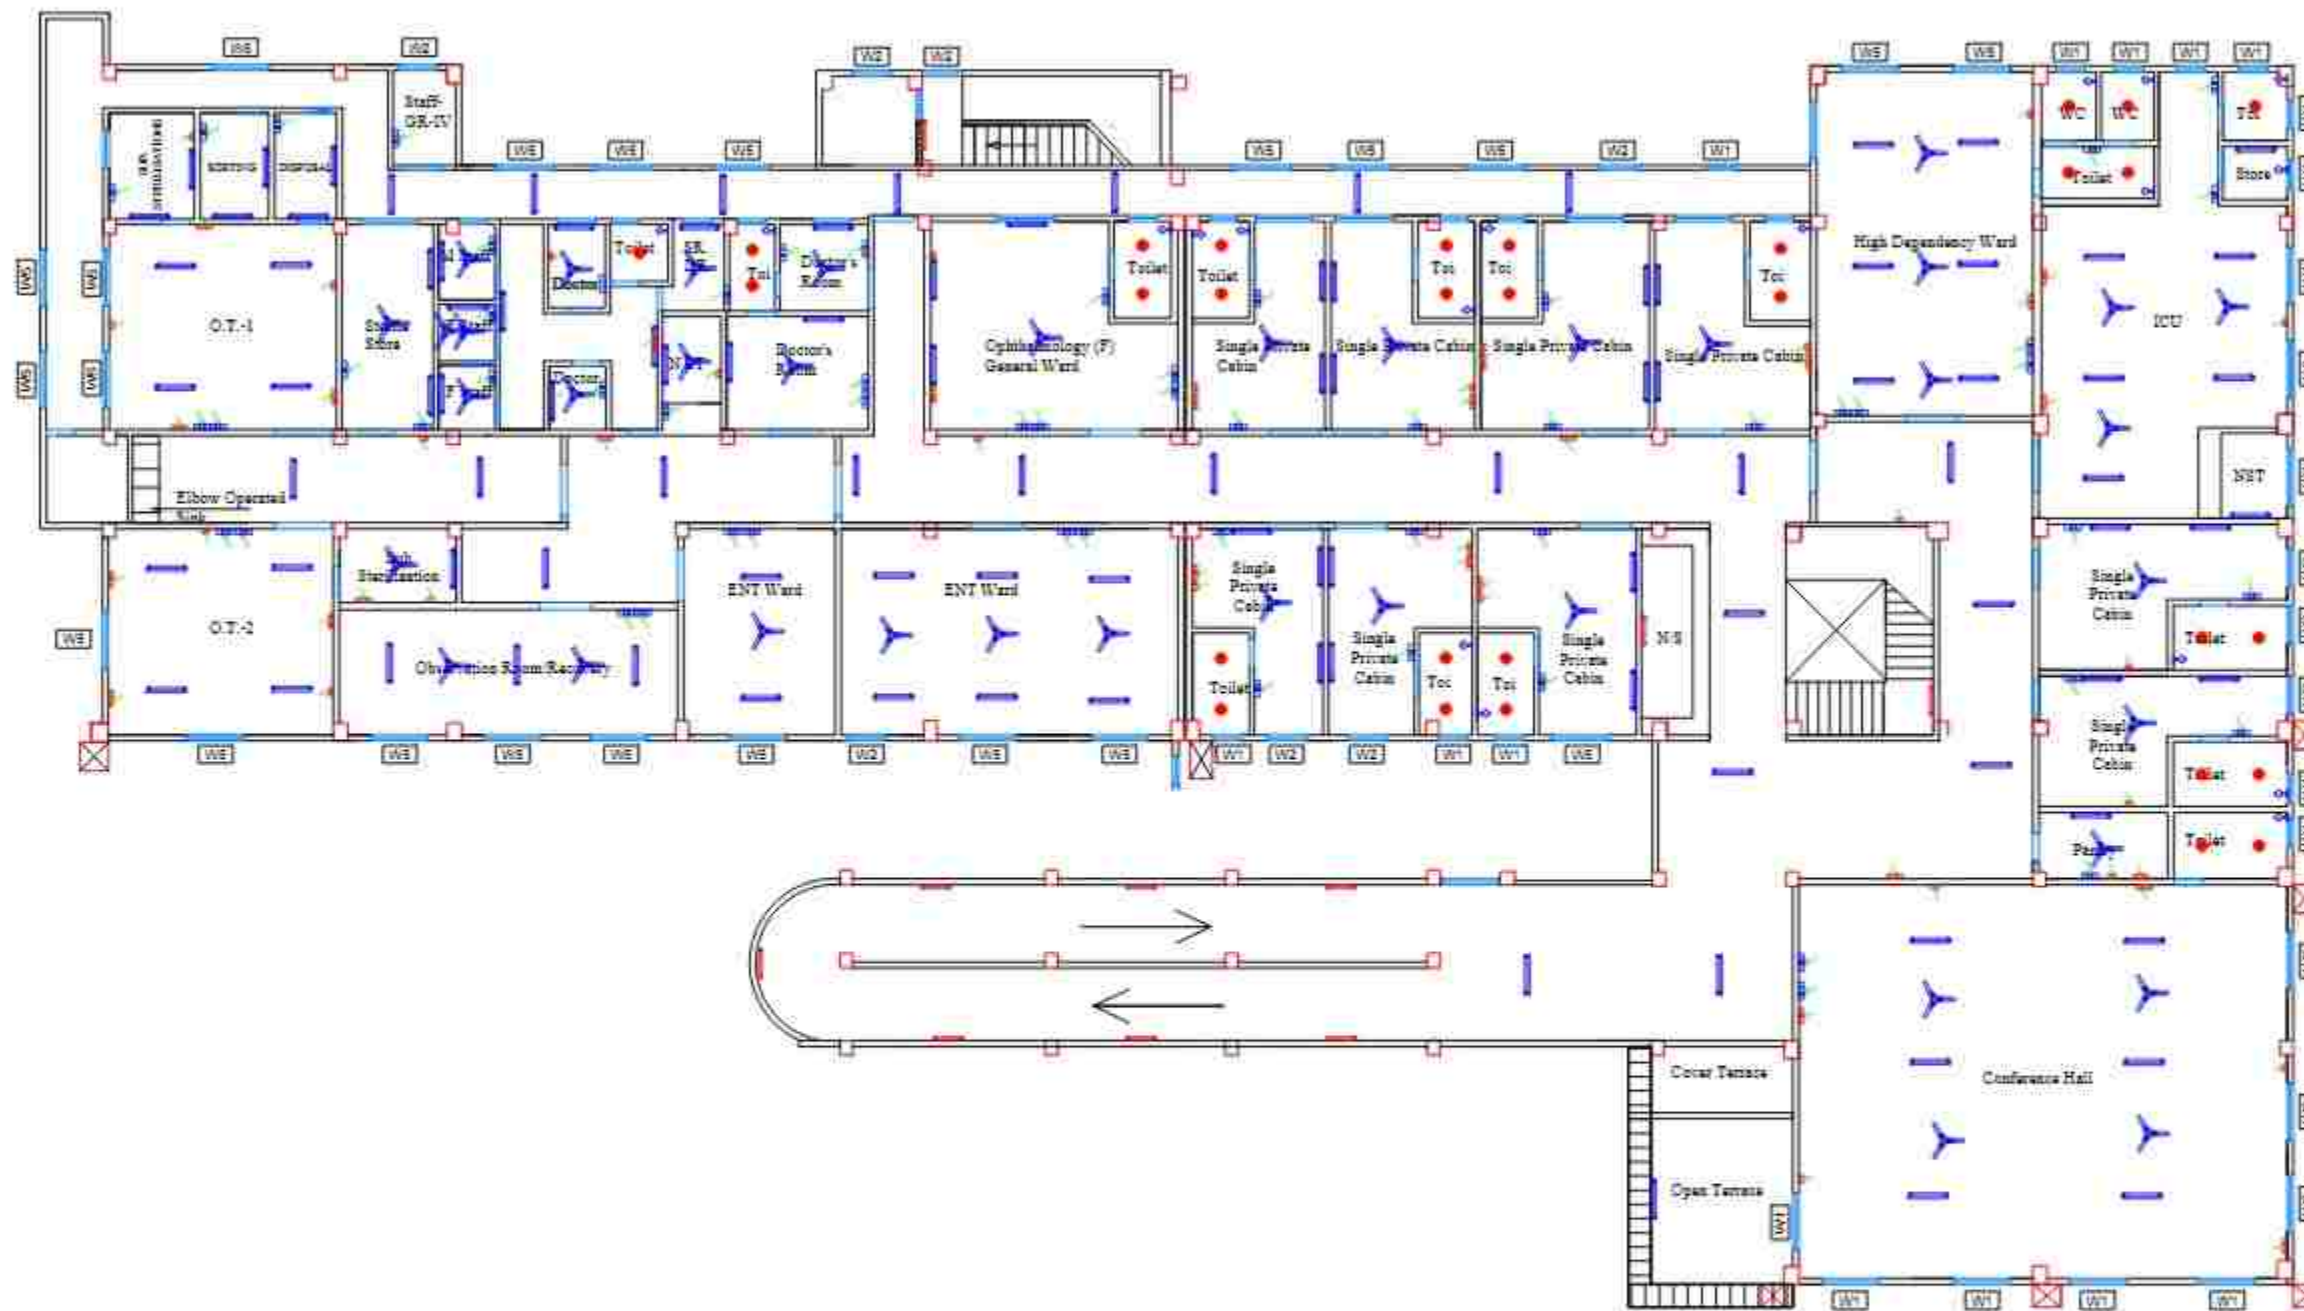

DOOR SCHEDULE:-

SNO	NAME	WIDTH	HEIGHT	REMARKS
1	D1	0.75	2.00	SINGLE PANEL DOOR
2	D2	0.90	2.00	SINGLE PANEL DOOR
3	D3	1.05	2.00	SINGLE PANEL DOOR
4	D4	1.20	2.00	SINGLE PANEL DOOR
4	D4a	1.20	2.00	DOUBLE PANEL DOOR
5	D5	1.50	2.00	DOUBLE PANEL DOOR
6	D6	1.80	2.00	DOUBLE PANEL DOOR
7	D7	2.00	2.00	DOUBLE PANEL DOOR

WINDOW SCHEDULE:-

SNO	NAME	SILL	WIDTH	HEIGHT	REMARKS
1	W1	1.40	0.80	0.80	SINGLE PANEL WINDOW
2	W2	0.75	0.80	1.30	SINGLE PANEL WINDOW
3	W3	0.70	1.05	1.30	SINGLE PANEL WINDOW
4	W4	0.70	1.20	1.30	DOUBLE PANEL WINDOW
5	W5	0.70	1.50	1.30	DOUBLE PANEL WINDOW
6	W6	0.70	1.80	1.30	DOUBLE PANEL WINDOW
7	W7	0.75	2.30	1.30	DOUBLE PANEL WINDOW

AS BUILT LEGEND:

	1200 MM CEILING FAN
	20W LED TUBELIGHT
	SWITCH BOARD
	BULB
	WALL FAN
	ROUND DOWN LIGHT


PROPOSED LEGEND:

	6A POWER POINT
	18A POWER POINT
	6/10A POWER POINT
	SWITCH BOARD
	20W LED TUBELIGHT
	1200 MM CEILING FAN
	12W DOWNLIGHT
	300 MM EXHAUST FAN

PROJECT:-
ASSAM STATE SECONDARY HEALTHCARE
INITIATIVE FOR SERVICE DELIVERY
TRANSFORMATION (ASSIST)

CLIENT:-
ASSAM HEALTH INFRASTRUCTURE
DEVELOPMENT & MANAGEMENT SOCIETY
(AHIDMS)

 PRINCIPAL CONSULTANT:



WITHIN GREEN, BLUE & BROWN ZONES
FORWARD ONLY. CHANGES TO BE MADE
IN-180-8807127140

STAGE:- D9R

DRAWING NO:-
2024/ASSIST-KAR/DH/E/PROP/01/TF

START DATE	ISSUE DATE	SHEET SIZE
	10-02-2025	A3
PROJECT CODE:-	2024/ASSIST-KAR/DH	
SCALE:-	N.T.S.	
BLOCK NO:-	1	
FLOOR:-	THIRD FLOOR	

DRAWING TITLE:-
BLOCK 1 THIRD FLOOR PLAN ELECTRICAL
LAYOUT,
KARIMGANJ CIVIL HOSPITAL, KARIMGANJ,
ASSAM.

PROJECT:-
ASSAM STATE SECONDARY HEALTHCARE
INITIATIVE FOR SERVICE DELIVERY
TRANSFORMATION (ASSIST)

CLIENT:-
ASSAM HEALTH INFRASTRUCTURE
DEVELOPMENT & MANAGEMENT SOCIETY
(AHIDMS)

PRINCIPAL CONSULTANT:



HEALTH SERVICES BLOCK 1 GROUND FLOOR
KARDIGANT CIVIL HOSPITAL, KARDIGANT, ASSAM
IN 781002, INDIA

STAGE:- DPR

DRAWING NO:-
2024-ASSIST-KARDIGANT-PROP-02-GF

START DATE	ISSUE DATE	SHEET SIZE
	10-02-2025	A3

PROJECT CODE:- 2024-ASSIST-KARDIGANT

SCALE:- N.T.S.

BLOCK NO:- 1

FLOOR:- GROUND FLOOR

DRAWING TITLE:-
BLOCK 1 GROUND FLOOR PLAN
ELECTRICAL LAYOUT,
KARDIGANT CIVIL HOSPITAL, KARDIGANT,
ASSAM

AS BUILT LEGEND:	
	1200 MM CEILING FAN
	30W LED TUBE LIGHT
	SWITCH BOARD
	BULB
	WALL FAN
	ROUND DOWN LIGHT

PROPOSED LEGEND:	
	5A POWER POINT
	15A POWER POINT
	5/15A POWER POINT
	SWITCH BOARD
	20W LED TUBE LIGHT
	1200 MM CEILING FAN
	12W DOWNLIGHT
	300 MM EXHAUST FAN



PROJECT:-
ASSAM STATE SECONDARY HEALTHCARE
INITIATIVE FOR SERVICE DELIVERY
TRANSFORMATION (ASSIST)

CLIENT:-
ASSAM HEALTH INFRASTRUCTURE
DEVELOPMENT & MANAGEMENT SOCIETY
(AHIMS)

PRINCIPAL CONSULTANT:



HEAD OFFICE: 2ND FLOOR, 40/41, KARDIGANI, KARDIGANI, ASSAM
TELEPHONE: 98361 12710

STAGE:- DPR

DRAWING NO:-
2024/ASSIST-KARDIGANI/PROP/02/SF

START DATE: 10-02-2025
ISSUE DATE: A3
SHEET SIZE:

PROJECT CODE:- 2024/ASSIST-KARDIGANI

SCALE:- N.T.S.


BLOCK NO:- 2

FLOOR:- SECOND FLOOR

DRAWING TITLE:-
BLOCK 2 SECOND FLOOR PLAN
ELECTRICAL LAYOUT
KARDIGANI CIVIL HOSPITAL, KARDIGANI,
ASSAM

AS BUILT LEGEND:	
	1200 MM CEILING FAN
	20W LED TUBELIGHT
	SWITCH BOARD
	BULB
	WALL FAN
	ROUND DOWN LIGHT

PROPOSED LEGEND:	
	6A POWER POINT
	16A POWER POINT
	6/16A POWER POINT
	SWITCH BOARD
	20W LED TUBELIGHT
	1200 MM CEILING FAN
	12W DOWNLIGHT
	300 MM EXHAUST FAN

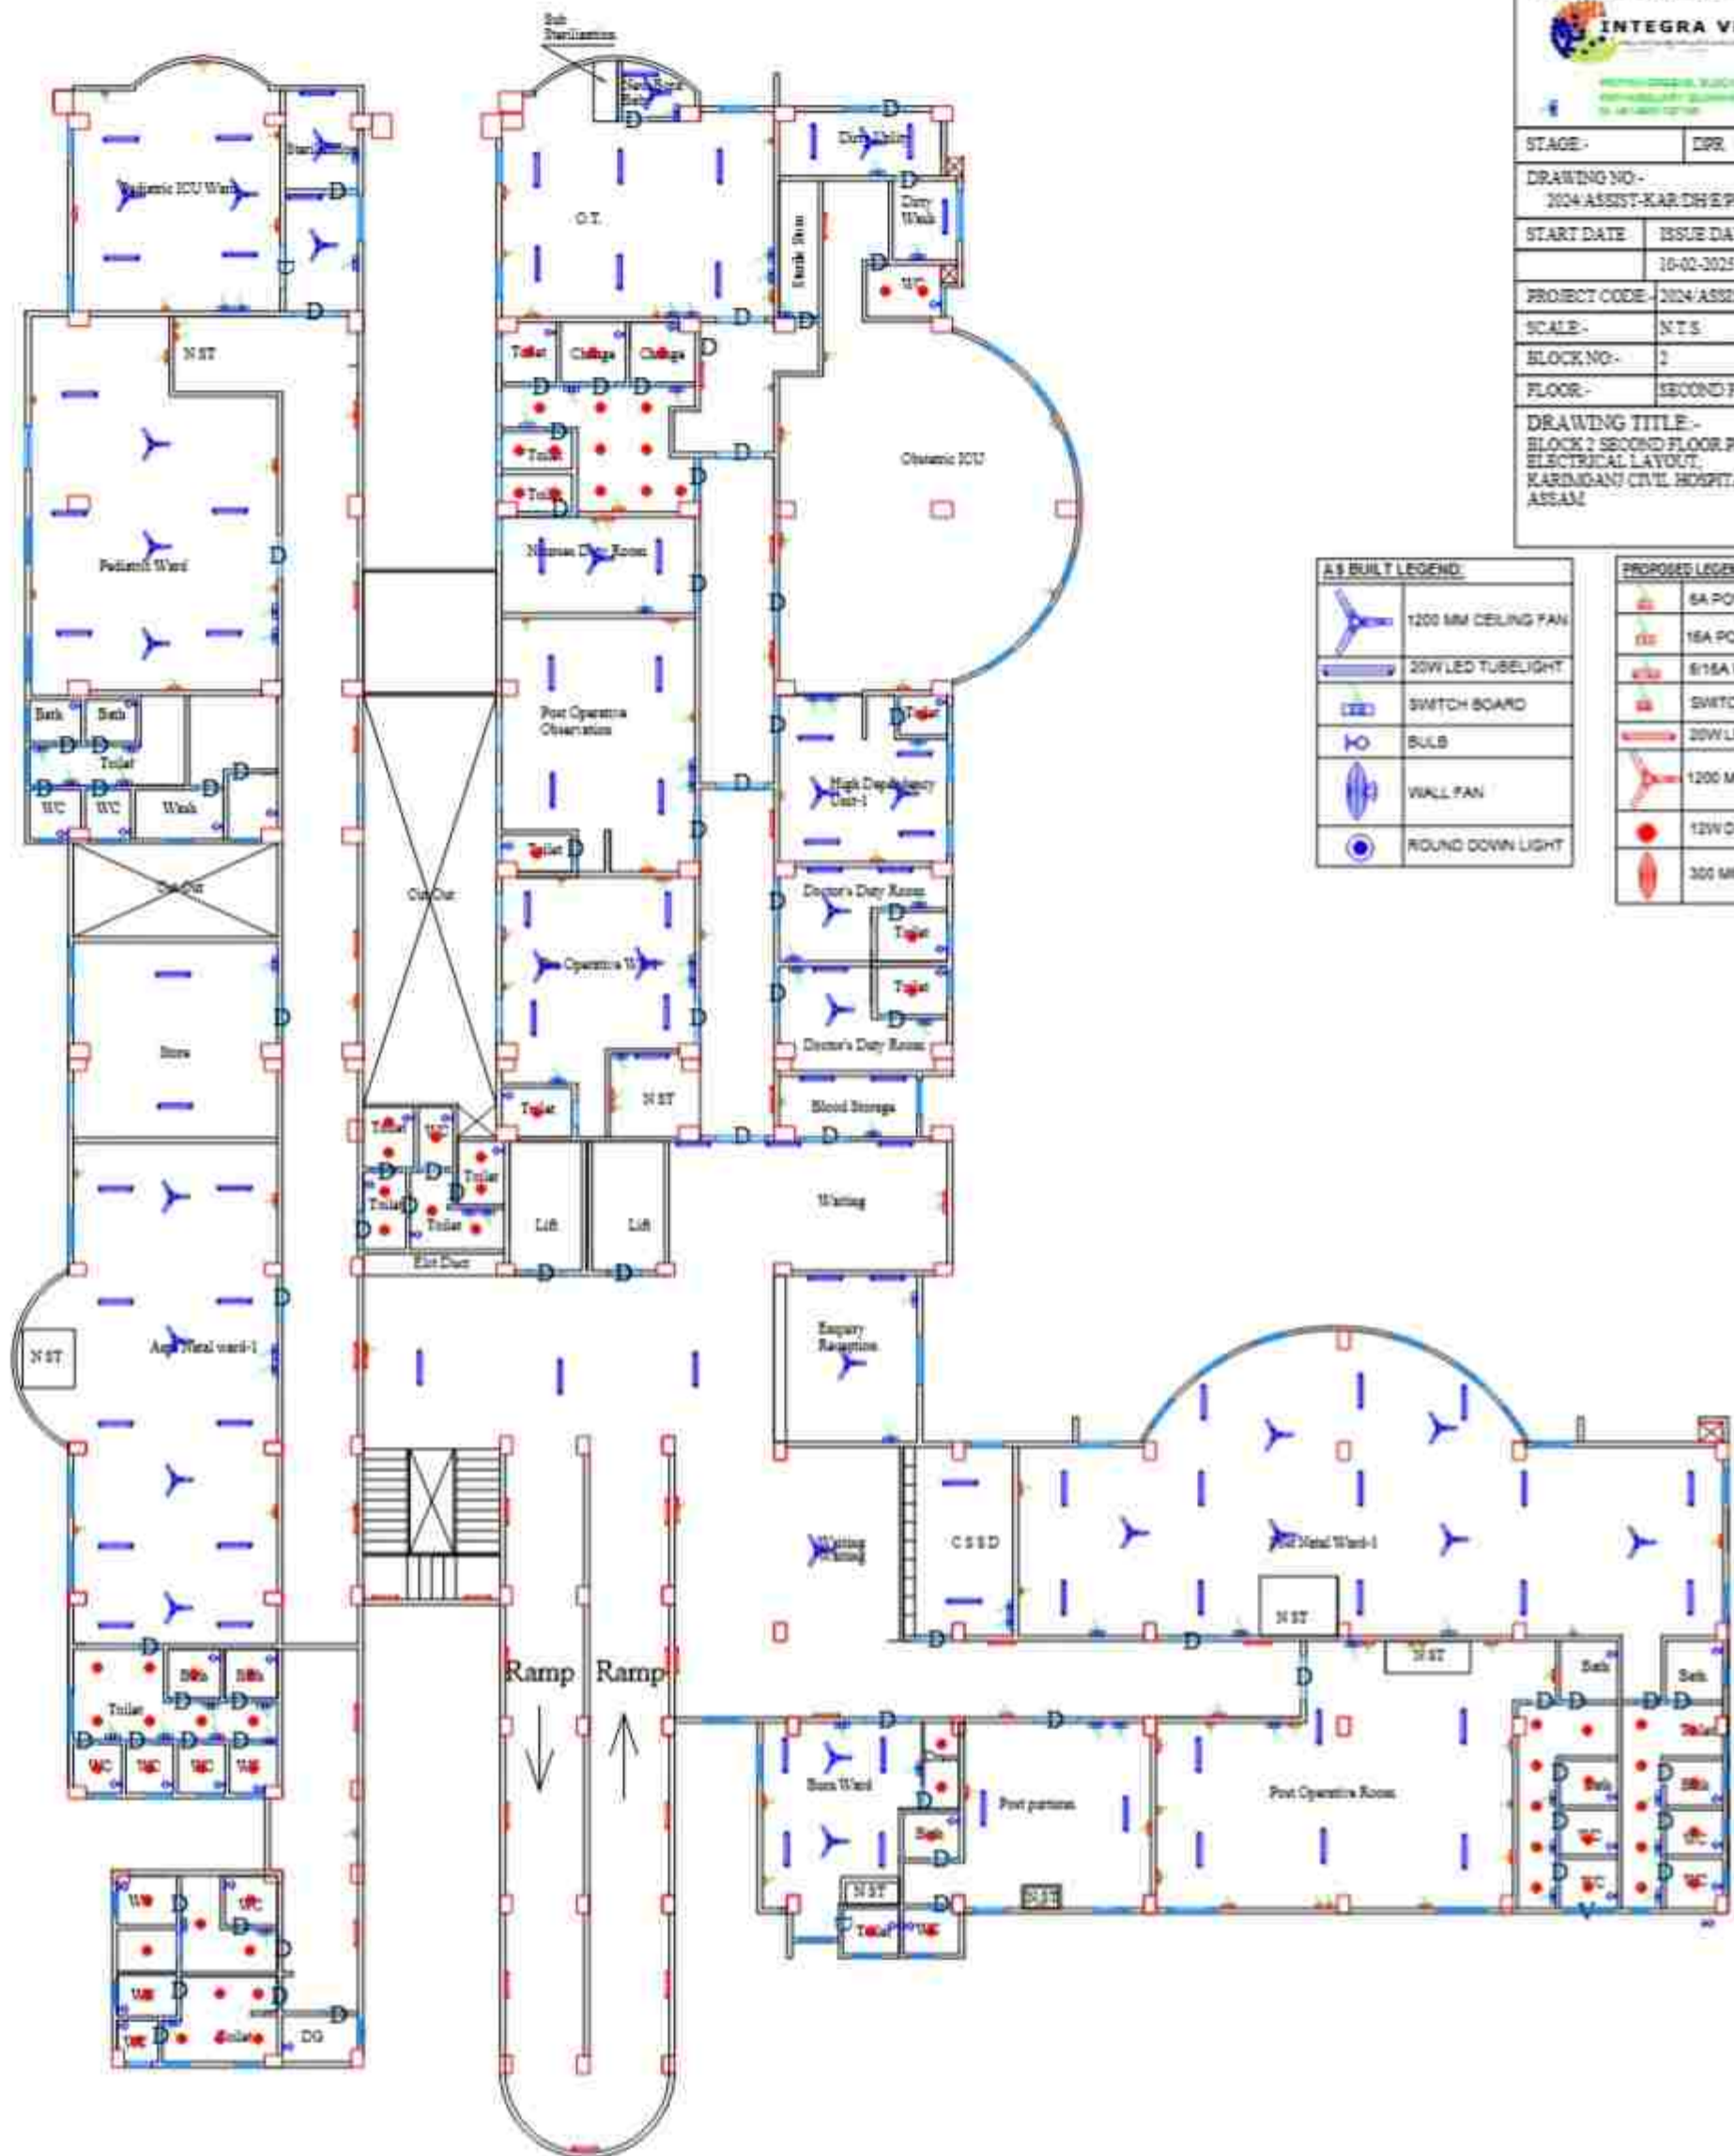

PROJECT:-
ASSAM STATE SECONDARY HEALTHCARE
INITIATIVE FOR SERVICE DELIVERY
TRANSFORMATION (ASSIST)

CLIENT:-
ASSAM HEALTH INFRASTRUCTURE
DEVELOPMENT & MANAGEMENT SOCIETY
(AHIMS)

PRINCIPAL CONSULTANT:



100 PPM, 100000 LTR, 100000 LTR, 100000 LTR
100 PPM, 100000 LTR, 100000 LTR, 100000 LTR
100 PPM, 100000 LTR, 100000 LTR, 100000 LTR

STAGE - DPR

DRAWING NO -
2024/ASSIST-KARDH/PROP-001/F

START DATE 10-02-2025 SHEET SIZE A3

PROJECT CODE - 2024/ASSIST-KARDH

SCALE - N.T.S.

BLOCK NO - 2


FLOOR - THIRD FLOOR

DRAWING TITLE:-
BLOCK 2 THIRD FLOOR PLAN ELECTRICAL
LAYOUT,
KARDAGANI CIVIL HOSPITAL, KARDAGANI,
ASSAM

AS BUILT LEGEND:	
	1200 MM CEILING FAN
	20W LED TUBE LIGHT
	SWITCH BOARD
	BULB
	WALL FAN
	ROUND DOWN LIGHT

PROPOSED LEGEND:	
	6A POWER POINT
	16A POWER POINT
	6/15A POWER POINT
	SWITCH BOARD
	20W LED TUBE LIGHT
	1200 MM CEILING FAN
	12W DOWNLIGHT
	300 MM EXHAUST FAN



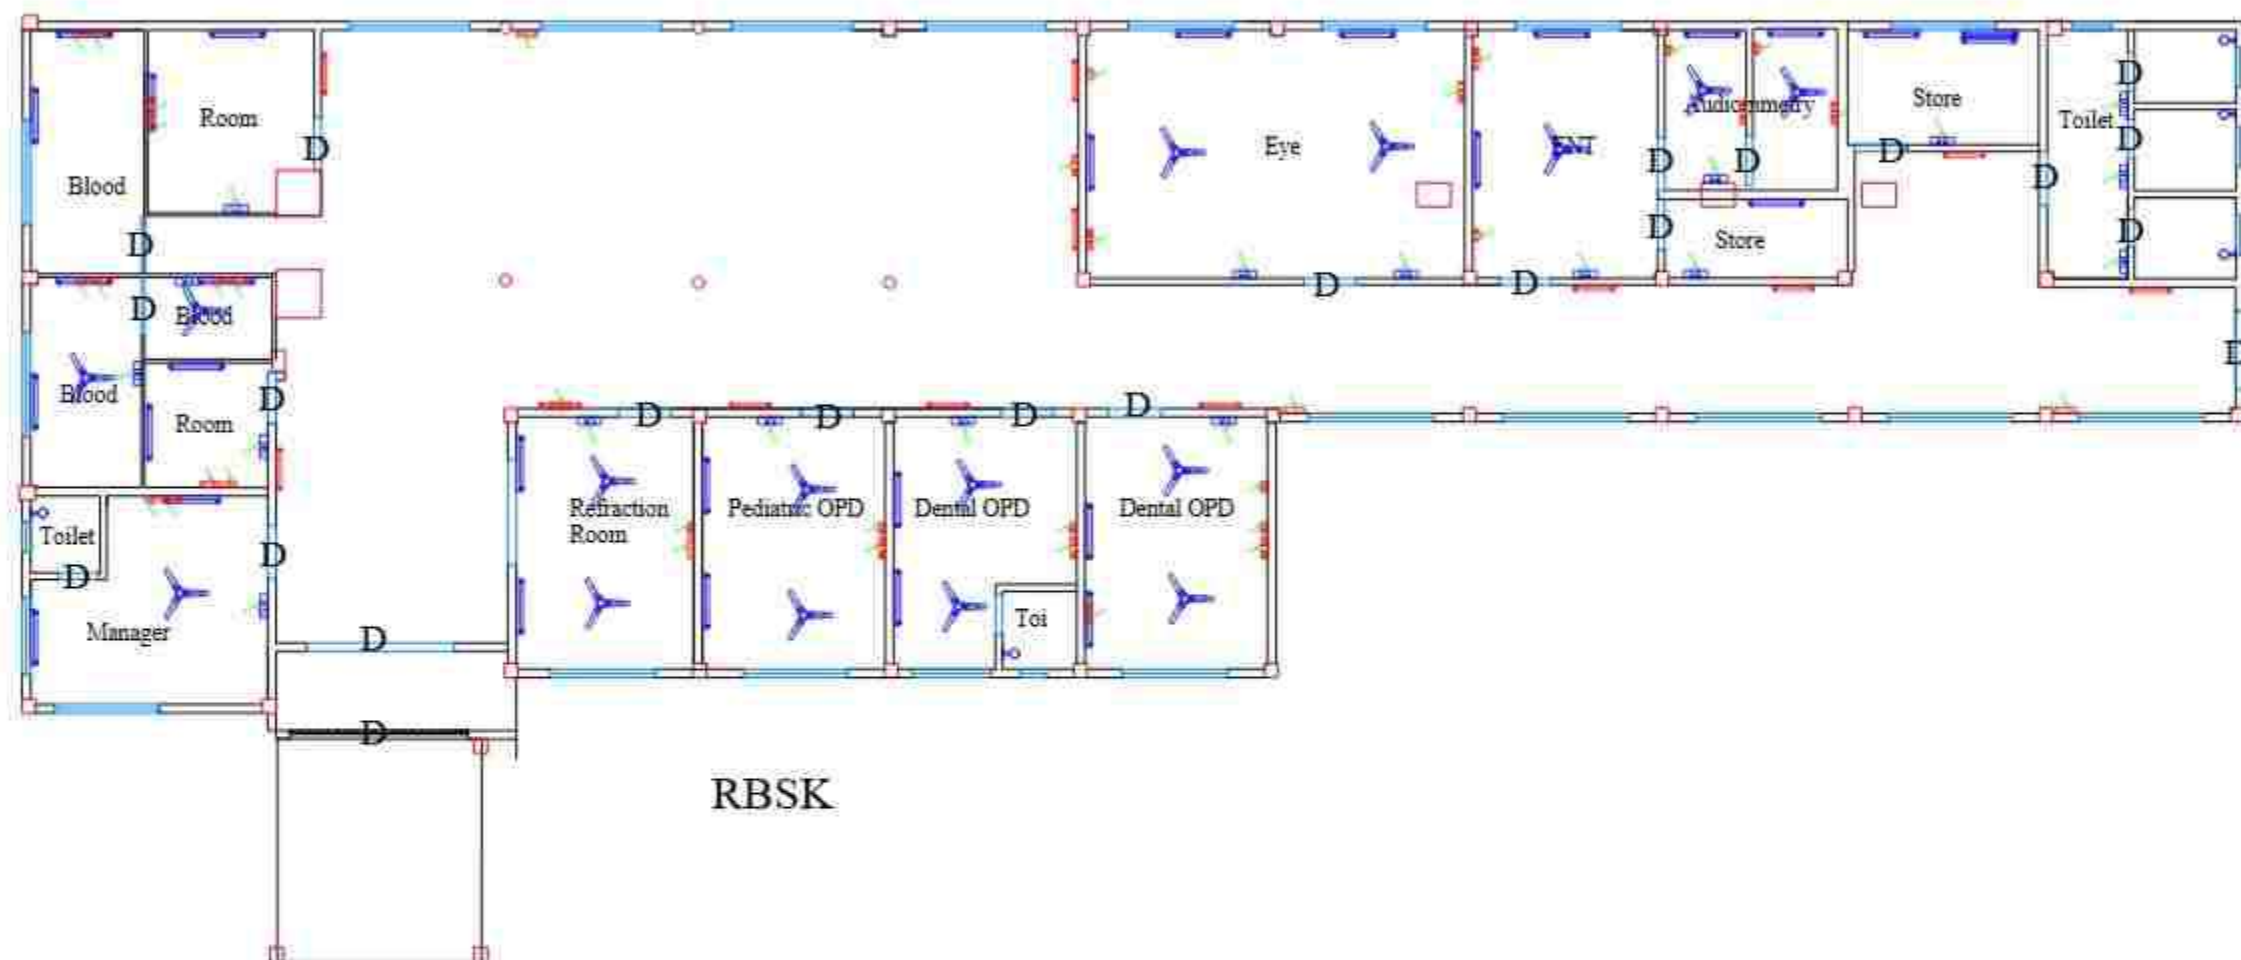

RBSK

AS BUILT LEGEND:

	1200 MM CEILING FAN
	20W LED TUBELIGHT
	SWITCH BOARD
	BULB
	WALL FAN
	ROUND DOWN LIGHT

PROPOSED LEGEND:

	6A POWER POINT
	16A POWER POINT
	6/16A POWER POINT
	SWITCH BOARD
	20W LED TUBELIGHT
	1200 MM CEILING FAN
	12W DOWNLIGHT
	300 MM EXHAUST FAN

PROJECT:-
ASSAM STATE SECONDARY HEALTHCARE
INITIATIVE FOR SERVICE DELIVERY
TRANSFORMATION (ASSIST)

CLIENT:-
ASSAM HEALTH INFRASTRUCTURE
DEVELOPMENT & MANAGEMENT SOCIETY
(AHIDMS)

PRINCIPAL CONSULTANT:



PROPOSED LEGEND: BLOCK 3 GROUND FLOOR
ELECTRICAL LAYOUT, KARIMGANJ CIVIL HOSPITAL, KARIMGANJ, ASSAM
(10-01-2025)

STAGE:- DPR

DRAWING NO:-
2024/ASSIST-KAR/DH/E/PROP/03

START DATE	ISSUE DATE	SHEET SIZE
	10-01-2025	A3

PROJECT CODE:- 2024/ASSIST-KAR/DH

SCALE:- N.T.S.

BLOCK NO:- 3

FLOOR:- GROUND FLOOR

DRAWING TITLE:-
BLOCK 3 GROUND FLOOR PLAN
ELECTRICAL LAYOUT,
KARIMGANJ CIVIL HOSPITAL, KARIMGANJ,
ASSAM



ELECTRICAL LEGEND	
SYMBOL	DESCRIPTION
	20W LED STREET LIGHT
	EXT. LIGHT WIRING TO LIGHT FIXTURE 4 sq. mm. 3 core Cu. Area. 10/PE cable (PVC), (conforming IS-2046 Part-01) 1100 volt grade, 1 core/2 core/3 core/4 core IS marked with die. stranded /solid conductor
	EXTERNAL LIGHTING FEEDER PANEL

PROJECT:-
ASSAM STATE SECONDARY HEALTHCARE
INITIATIVE FOR SERVICE DELIVERY
TRANSFORMATION (ASSIST)

CLIENT:-
ASSAM HEALTH INFRASTRUCTURE
DEVELOPMENT & MANAGEMENT SOCIETY
(AHIDMS)

PRINCIPAL CONSULTANT:
 **INTEGRA VENTURES**
PVT. LTD. (A COMPANY INCORPORATED IN INDIA)
PLOT NO. 1, SECTOR 1, BLOCK A, GROUND FLOOR,
KATARGUANY BURNING-171171, ASSAM
IN-781005 (INDIA)

STAGE:- DPR


DRAWING NO:-
2024/ASSIST-KAR/DH/EE/PROP/01


START DATE	ISSUE DATE	SHEET SIZE
	10-02-2025	A3

PROJECT CODE:- 2024/ASSIST-KAR/DH

SCALE:- N.T.S.

DRAWING TITLE:-
ELECTRICAL EXTERNAL LAYOUT,
KARIMGANJ CIVIL HOSPITAL, KARIMGANJ,
ASSAM.

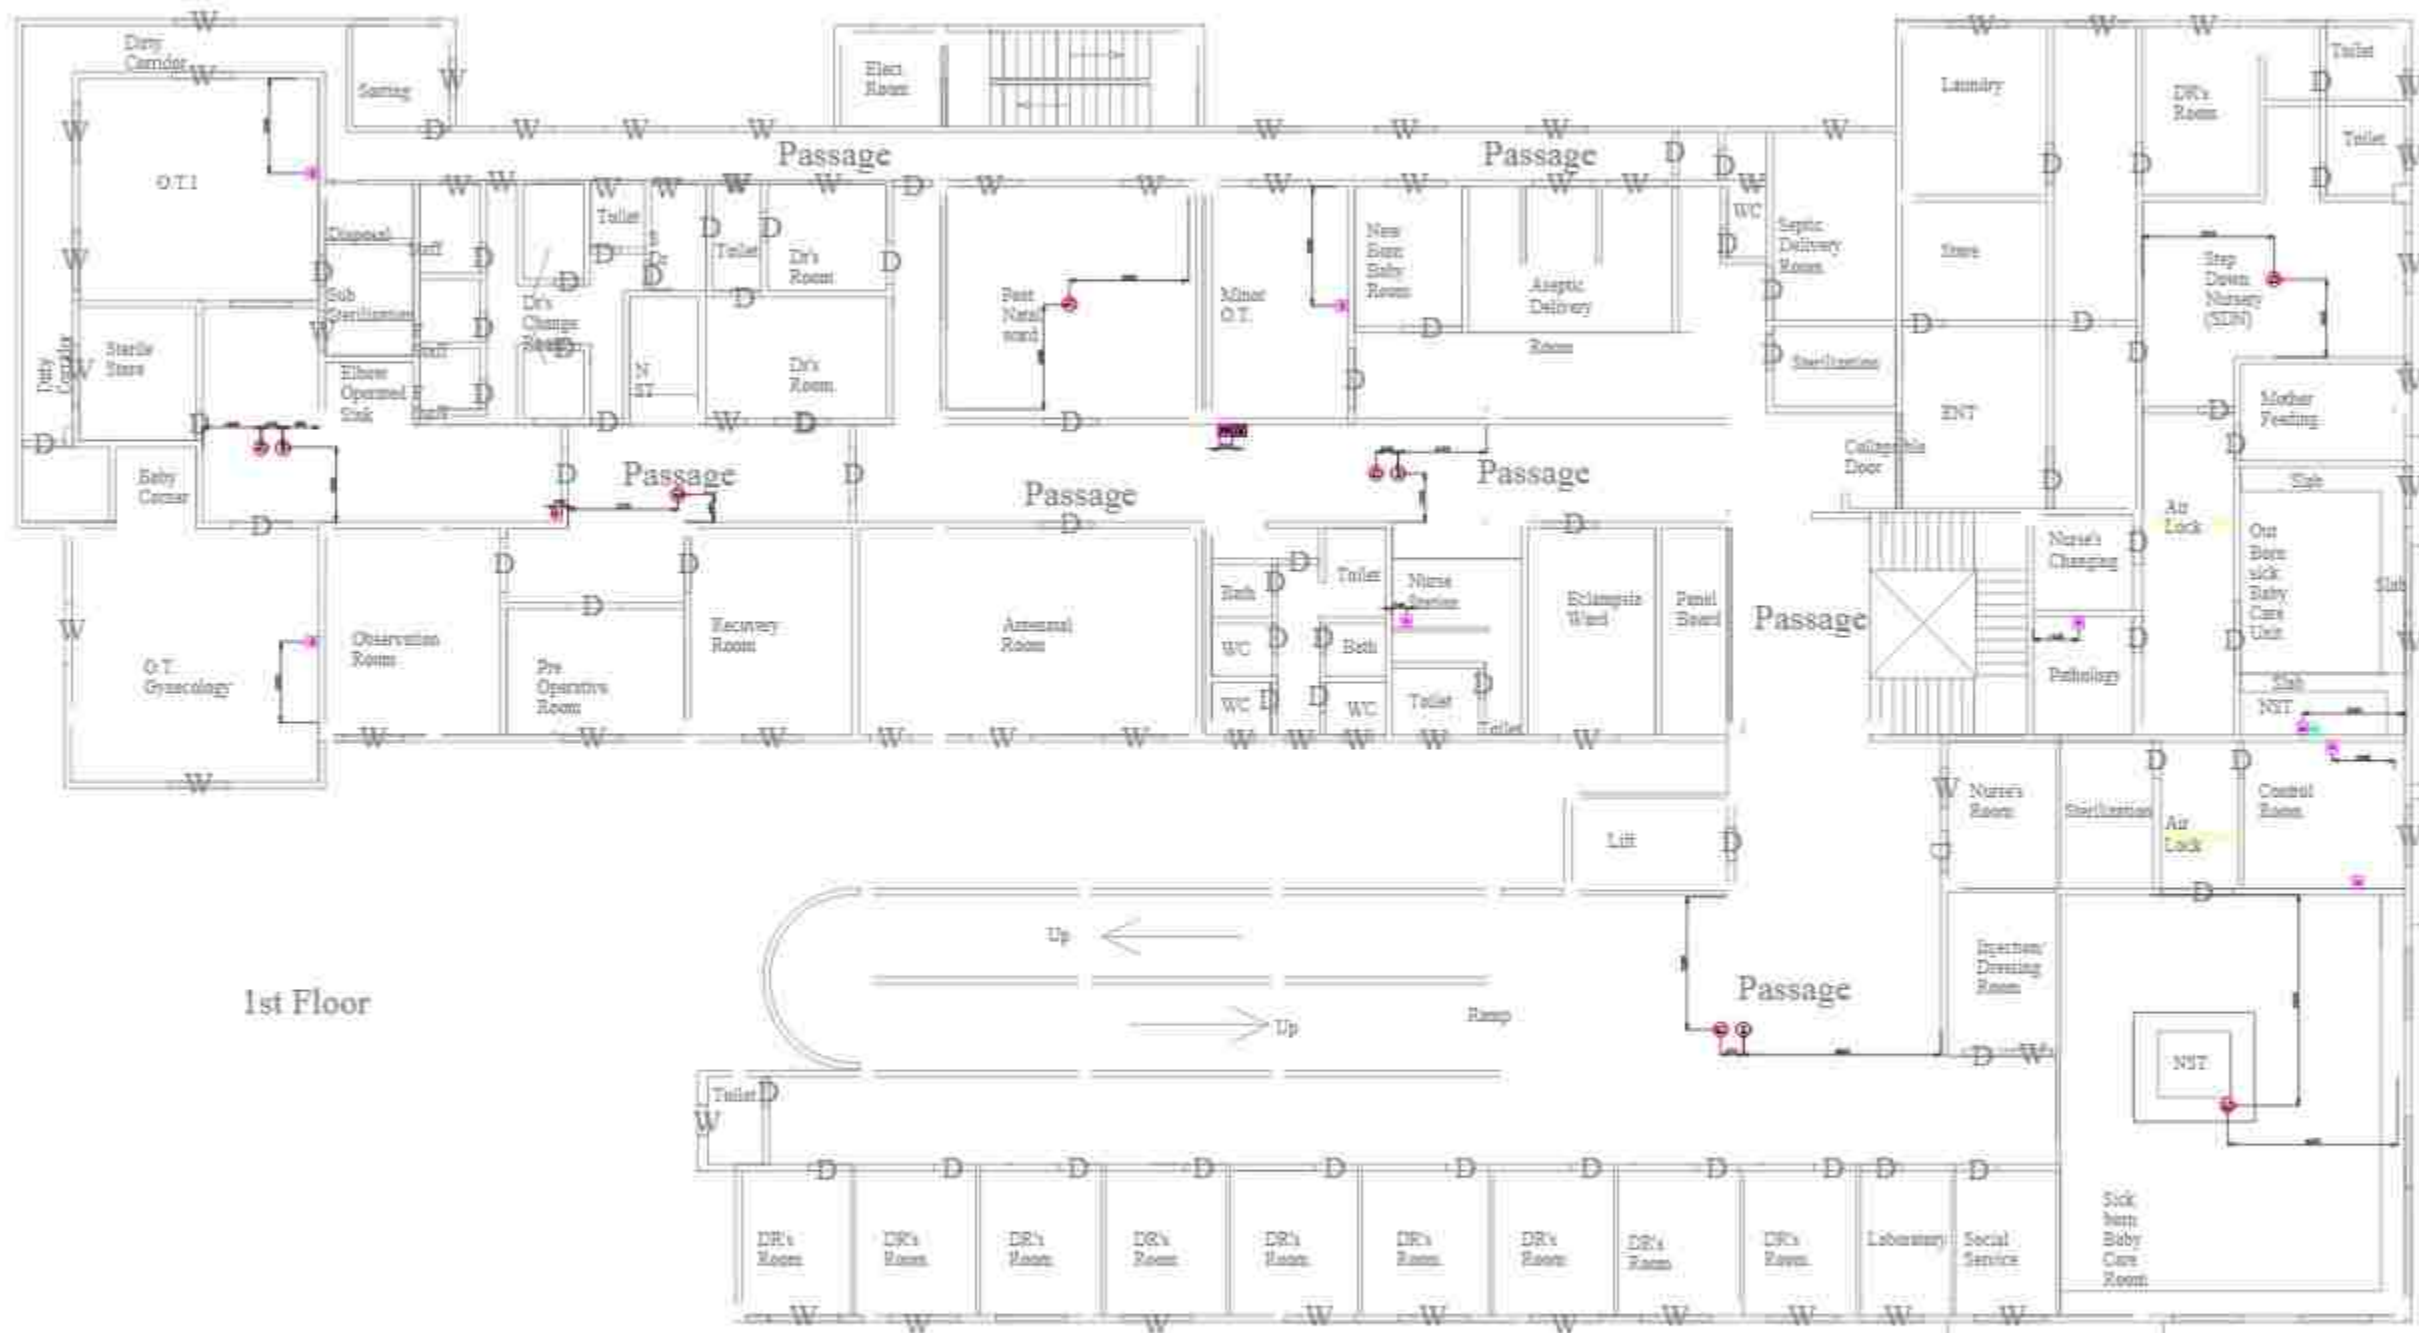

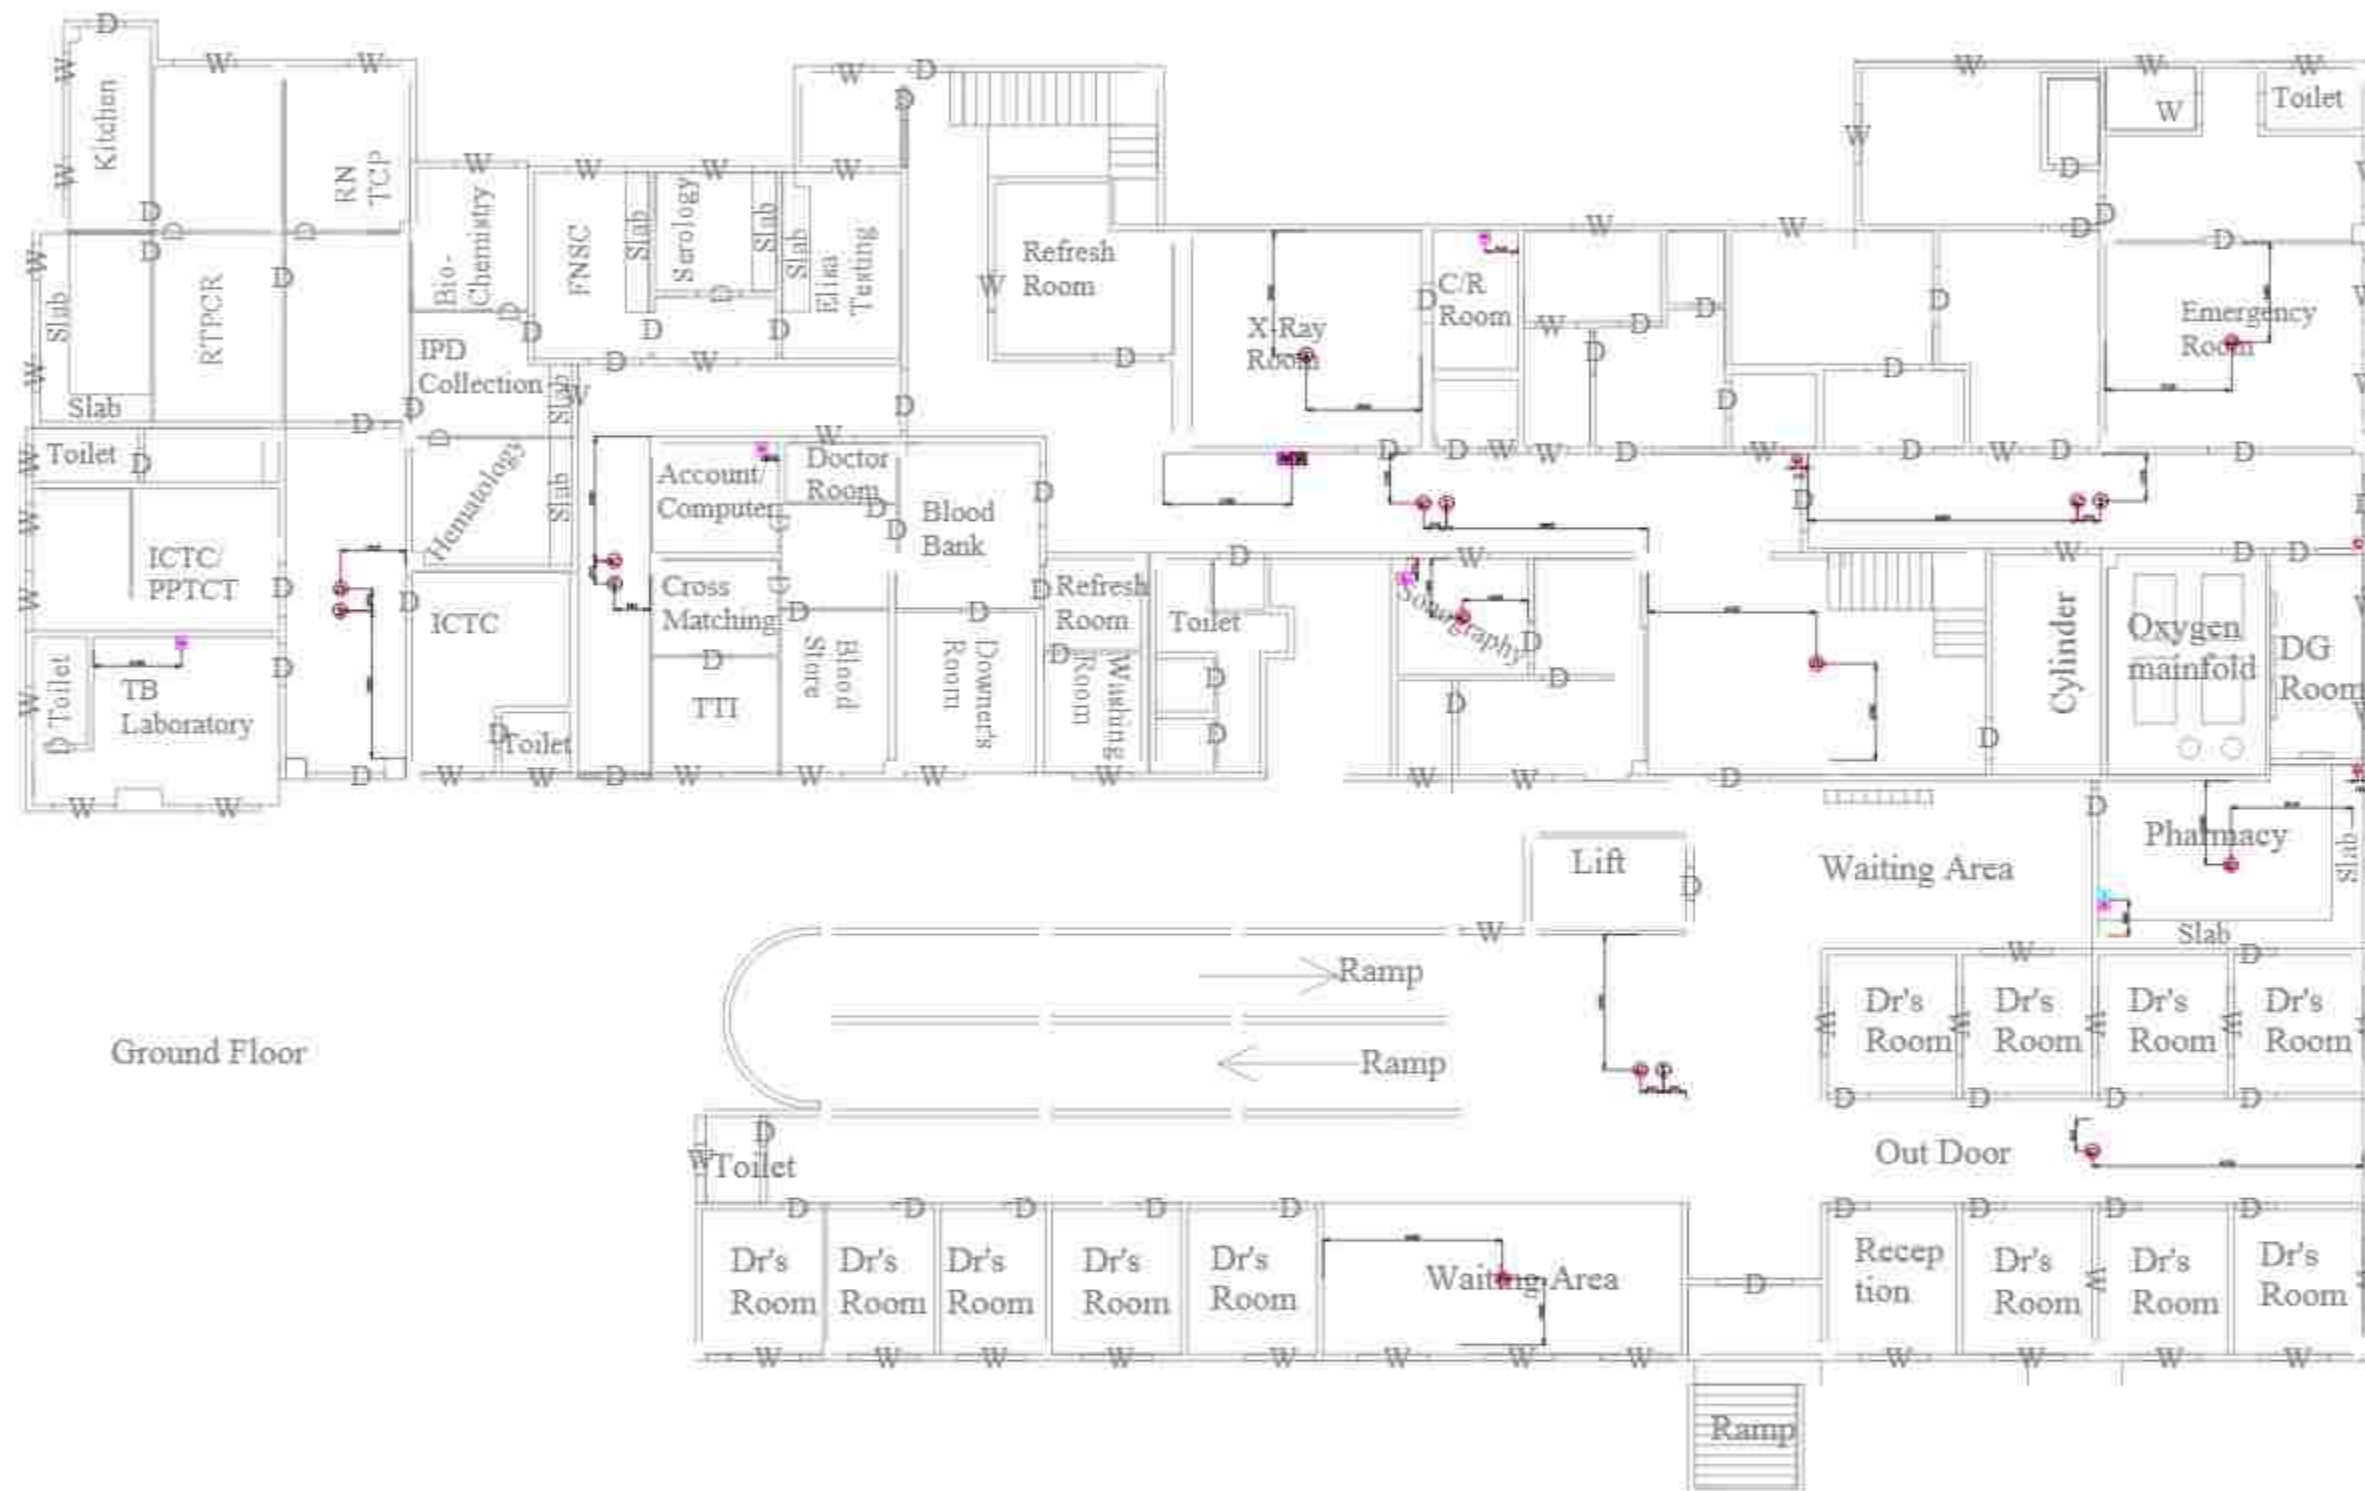

Ground Floor

FIRE DETECTION SYSTEM LEGENDS

SYMBOL	DESCRIPTION
	SMOKE DETECTOR IN TRUE CEILING
	CONTROL MODULE
	MANUAL CALL POINT
	FAULT ISOLATOR MODULE
	HOME CAMERA
	BULLET CAMERA
	CEILING MOUNTED SPEAKER
	TELEPHONE POINT
	LAN POINT
	MICROPHONE POINT
	TV POINT

PROJECT:-
ASSAM STATE SECONDARY HEALTHCARE
INITIATIVE FOR SERVICE DELIVERY
TRANSFORMATION (ASSIST)

CLIENT:-
ASSAM HEALTH INFRASTRUCTURE
DEVELOPMENT & MANAGEMENT SOCIETY
(AHIDMS)

PRINCIPAL CONSULTANT:



STAGE:- DPR

DRAWING NO:-
2024/ASSIST-KAR/DH/ELV/01/GF

START DATE	ISSUE DATE	SHEET SIZE
	10-02-2025	A3


PROJECT CODE:- 2024/ASSIST-KAR/DH

SCALE:- N.T.S.

BLOCK NO:- 1

FLOOR NAME:- GROUND FLOOR

DRAWING TITLE:-
ELV LAYOUT, BLOCK 1 GROUND FLOOR,
KARIMGANJ CIVIL HOSPITAL, KARIMGANJ,
ASSAM

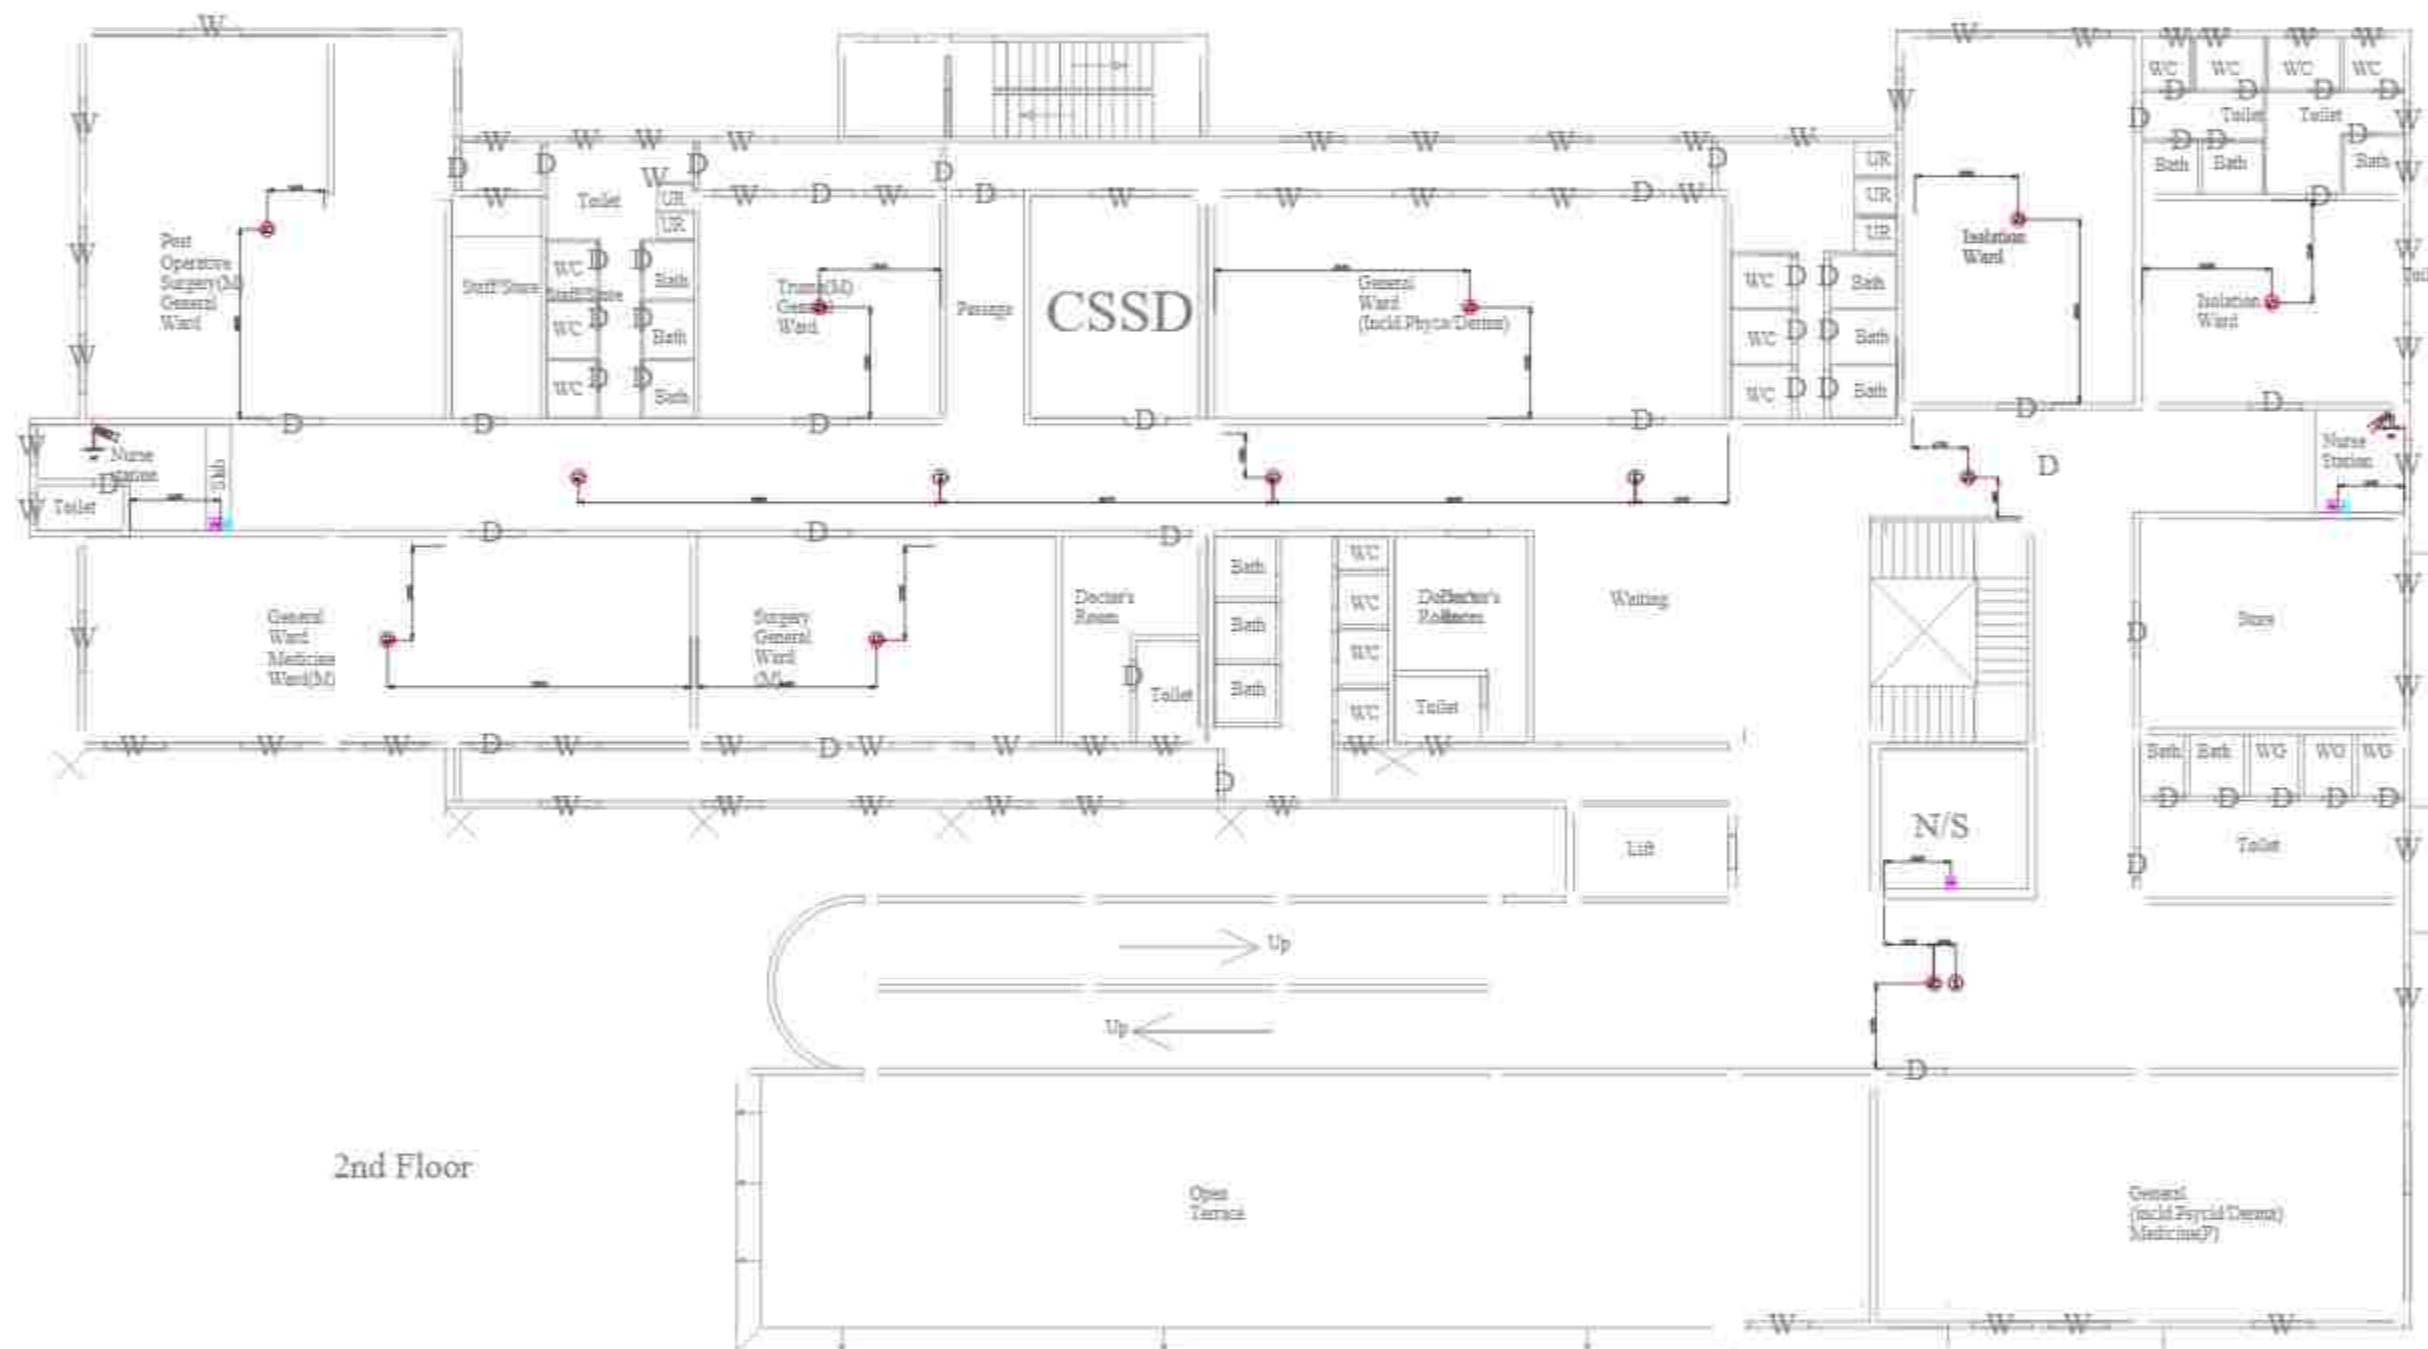

FIRE DETECTION SYSTEM LEGENDS

SYMBOL	DESCRIPTION
	SMOKE DETECTOR IN TRUE CEILING
	CONTROL MODULE
	MANUAL CALL POINT
	FAULT ISOLATOR MODULE
	DOME CAMERA
	BULLET CAMERA
	CEILING MOUNTED SPEAKER
	TELEPHONE POINT
	LAN POINT
	MICROPHONE POINT
	TV POINT

PROJECT:-
ASSAM STATE SECONDARY HEALTHCARE
INITIATIVE FOR SERVICE DELIVERY
TRANSFORMATION (ASST)

CLIENT:-
ASSAM HEALTH INFRASTRUCTURE
DEVELOPMENT & MANAGEMENT SOCIETY
(AHIDMS)

PRINCIPAL CONSULTANT:-

INTEGRA VENTURES
PVT. LTD.
PLOT NO. 10, BLOCK A, GROUND FLOOR,
INDUSTRIAL AREA, DISpur, GUWAHATI, ASSAM
PIN-781005

STAGE:-
DPP

DRAWING NO:-
2024/ASSIST-KAR/DH/ELV/01/SF

START DATE	ISSUE DATE	SHEET SIZE
	10-02-2025	A3


PROJECT CODE:-2024/ASSIST-KAR/DH

SCALE:-
N.T.S.

BLOCK NO :-
1

FLOOR NAME:-
SECOND FLOOR

DRAWING TITLE:-
ELV LAYOUT, BLOCK 1 SECOND FLOOR,
KARIMGANJ CIVIL HOSPITAL, KARIMGANJ,
ASSAM

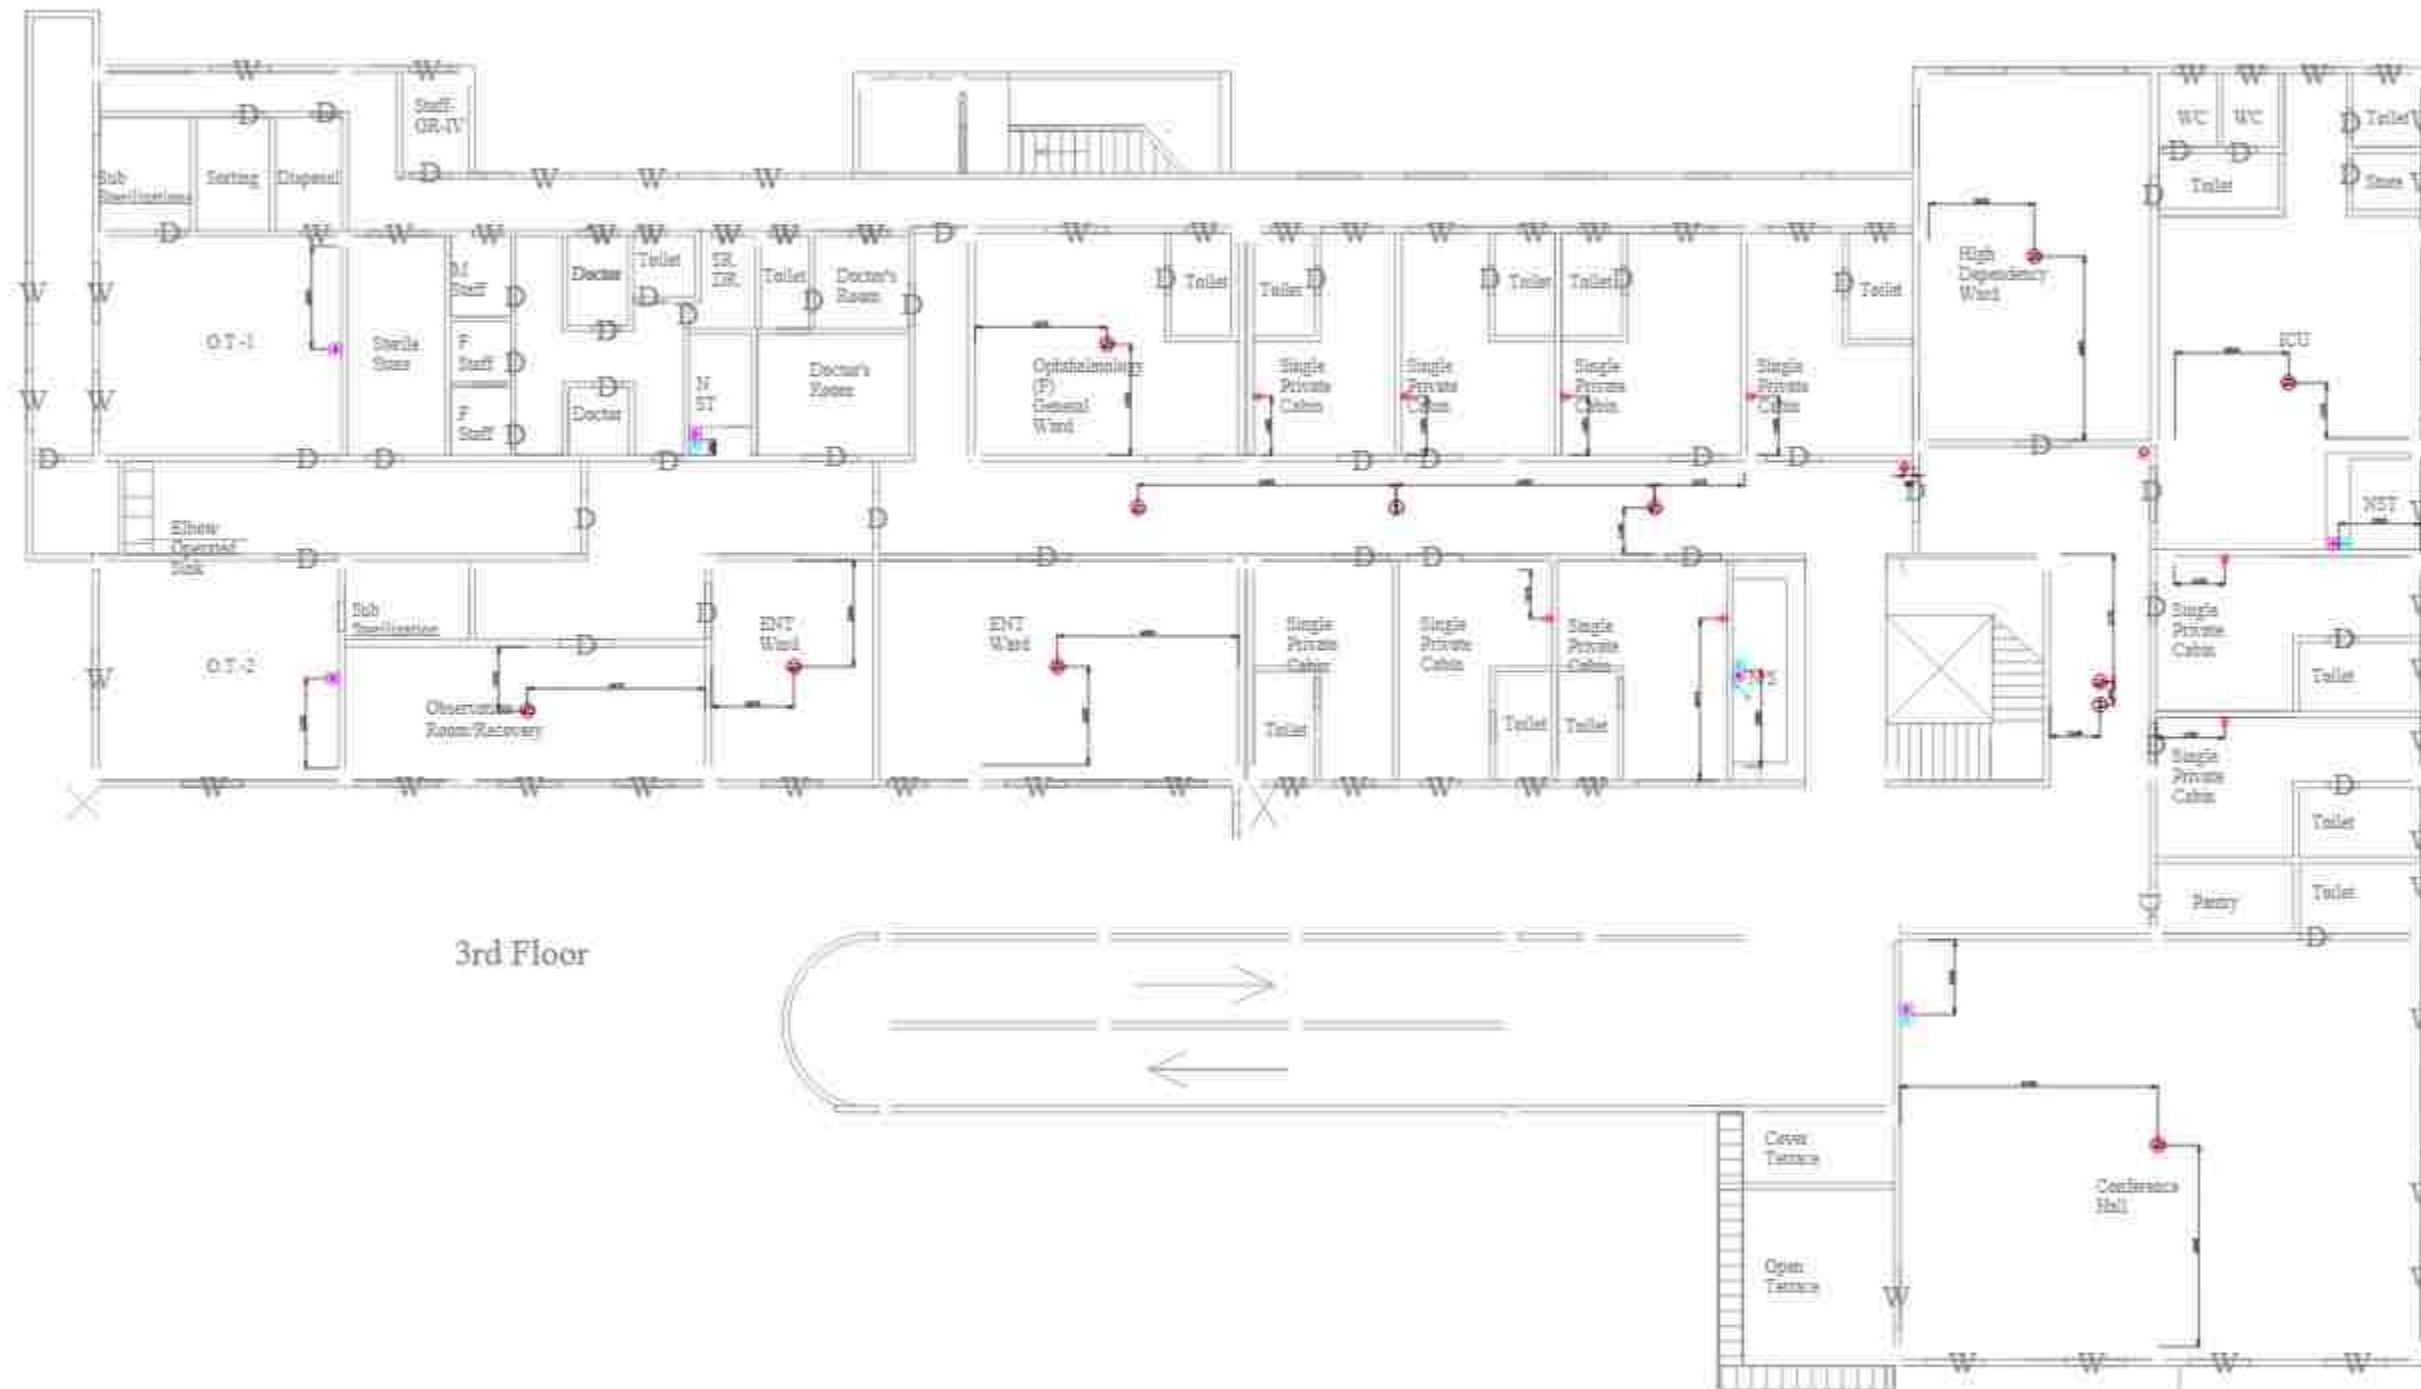

FIRE DETECTION SYSTEM LEGENDS

SYMBOL	DESCRIPTION
	SMOKE DETECTOR IN TRUE CEILING
	CONTROL MODULE
	MANUAL CALL POINT
	FAULT ISOLATOR MODULE
	DOME CAMERA
	BULLET CAMERA
	CEILING MOUNTED SPEAKER
	TELEPHONE POINT
	LAN POINT
	MICROPHONE POINT
	TV POINT

PROJECT:-
ASSAM STATE SECONDARY HEALTHCARE
INITIATIVE FOR SERVICE DELIVERY
TRANSFORMATION (ASSIST)

CLIENT:-
ASSAM HEALTH INFRASTRUCTURE
DEVELOPMENT & MANAGEMENT SOCIETY
(AHIDMS)

PRINCIPAL CONSULTANT:

INTEGRA VENTURES
PVT. LTD.
HEAD OFFICE: BLOCK A, GROUND FLOOR,
KARIMGANJ CIVIL HOSPITAL, KARIMGANJ, ASSAM
PIN-781001

STAGE:-
DPP

DRAWING NO:-
2024/ASSIST-KAR/DH/ELV/01/TF

START DATE	ISSUE DATE	SHEET SIZE
	10-02-2025	A3


PROJECT CODE:- 2024/ASSIST-KAR/DH

SCALE:-
N.T.S.

BLOCK NO :-
1

FLOOR NAME
THIRD FLOOR

DRAWING TITLE:-
ELV LAYOUT, BLOCK 1 THIRD FLOOR,
KARIMGANJ CIVIL HOSPITAL, KARIMGANJ,
ASSAM

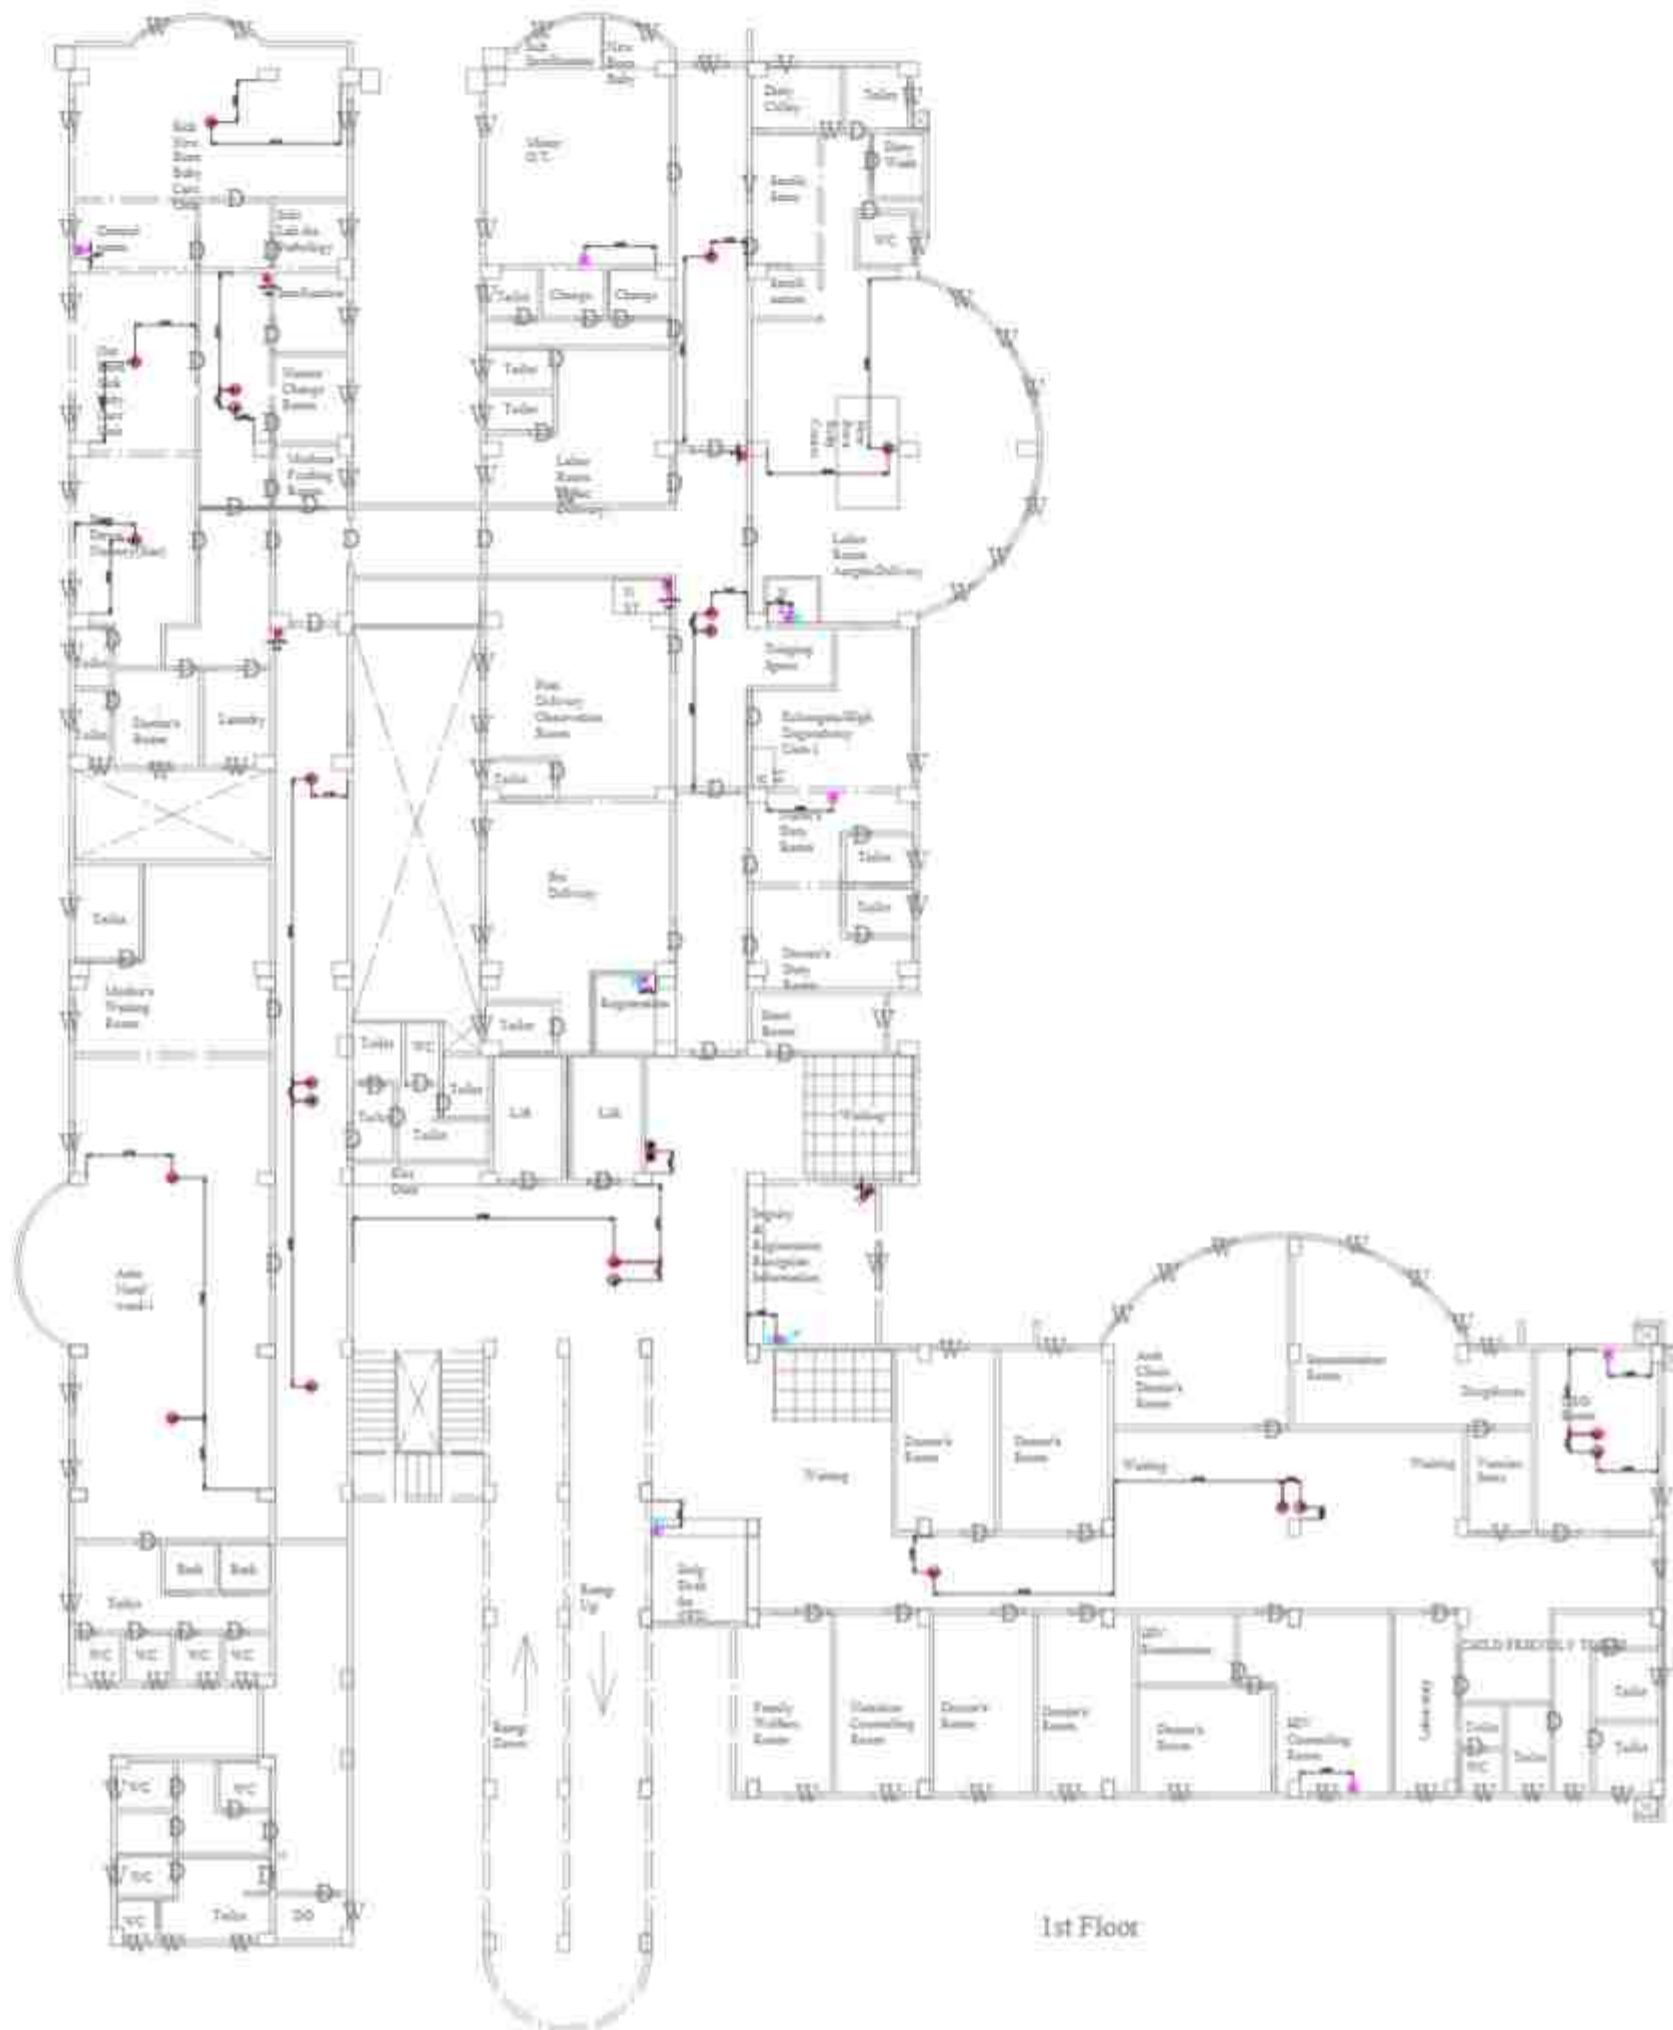

FIRE DETECTION SYSTEM LEGENDS	
SYMBOL	DESCRIPTION
	SMOKE DETECTOR IN TRUE CEILING
	CONTROL MODULE
	MANUAL CALL POINT
	FIRE ISOLATOR MODULE
	DOMO CAMERA
	BULLET CAMERA
	CEILING MOUNTED SPEAKER
	TELEPHONE POINT
	LAN POINT
	MICROPHONE POINT
	TV POINT

PROJECT -
 ASSAM STATE SECONDARY HEALTHCARE
 INITIATIVE FOR SERVICE DELIVERY
 TRANSFORMATION (ASIST)


CLIENT -
 ASSAM HEALTH INFRASTRUCTURE
 DEVELOPMENT & MANAGEMENT SOCIETY
 (AHIDMS)


PRINCIPAL CONSULTANT

 INTEGRAL VENTURES
 PROJECTS, DESIGN, PLANNING & CONSTRUCTION
 CONSULTANTS

STAGE -	DPR
DRAWING NO. - 2024-ASIST-KARIDAGANI-01	
START DATE	ISSUE DATE
	18-02-2024
PROJECT CODE - 2024-ASIST-KARIDAGANI	
SCALE -	1:1
BLOCK NO -	1
FLOOR NAME -	FIRST FLOOR

DRAWING TITLE -
 EHV LAYOUT, BLOCK 1 FIRST FLOOR,
 KARIDAGANI CIVIL HOSPITAL, KARIDAGANI,
 ASSAM

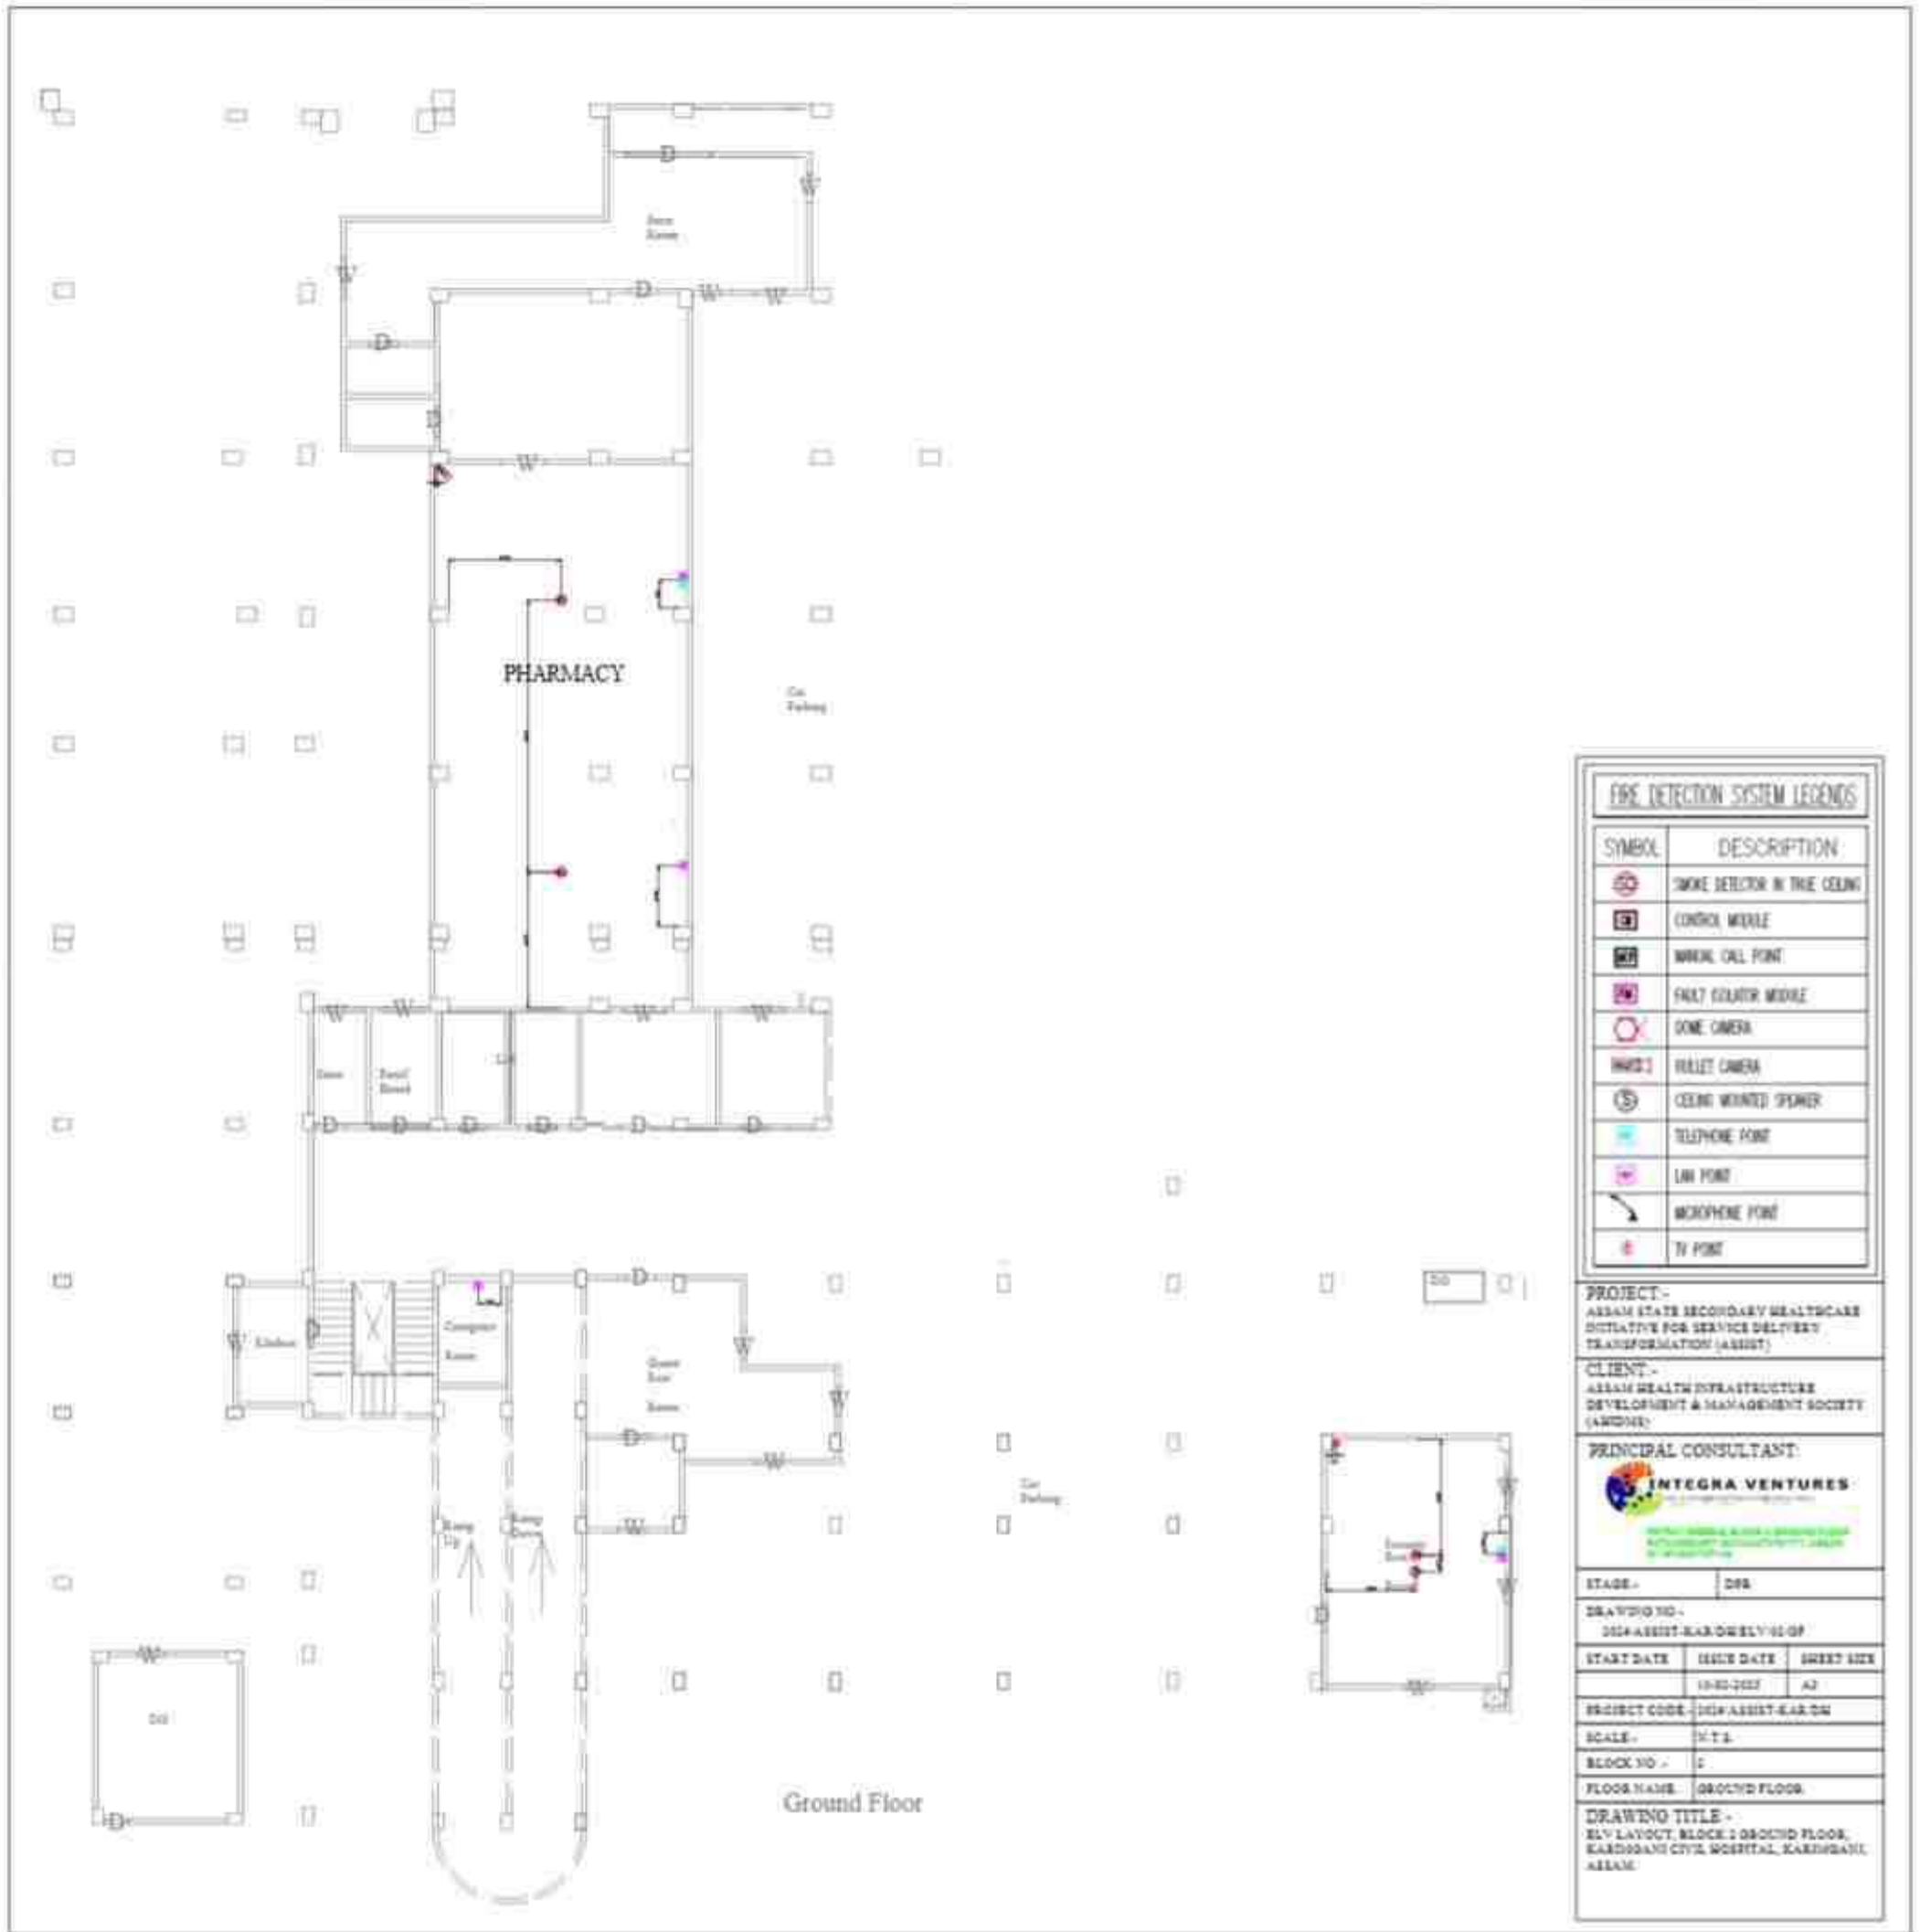

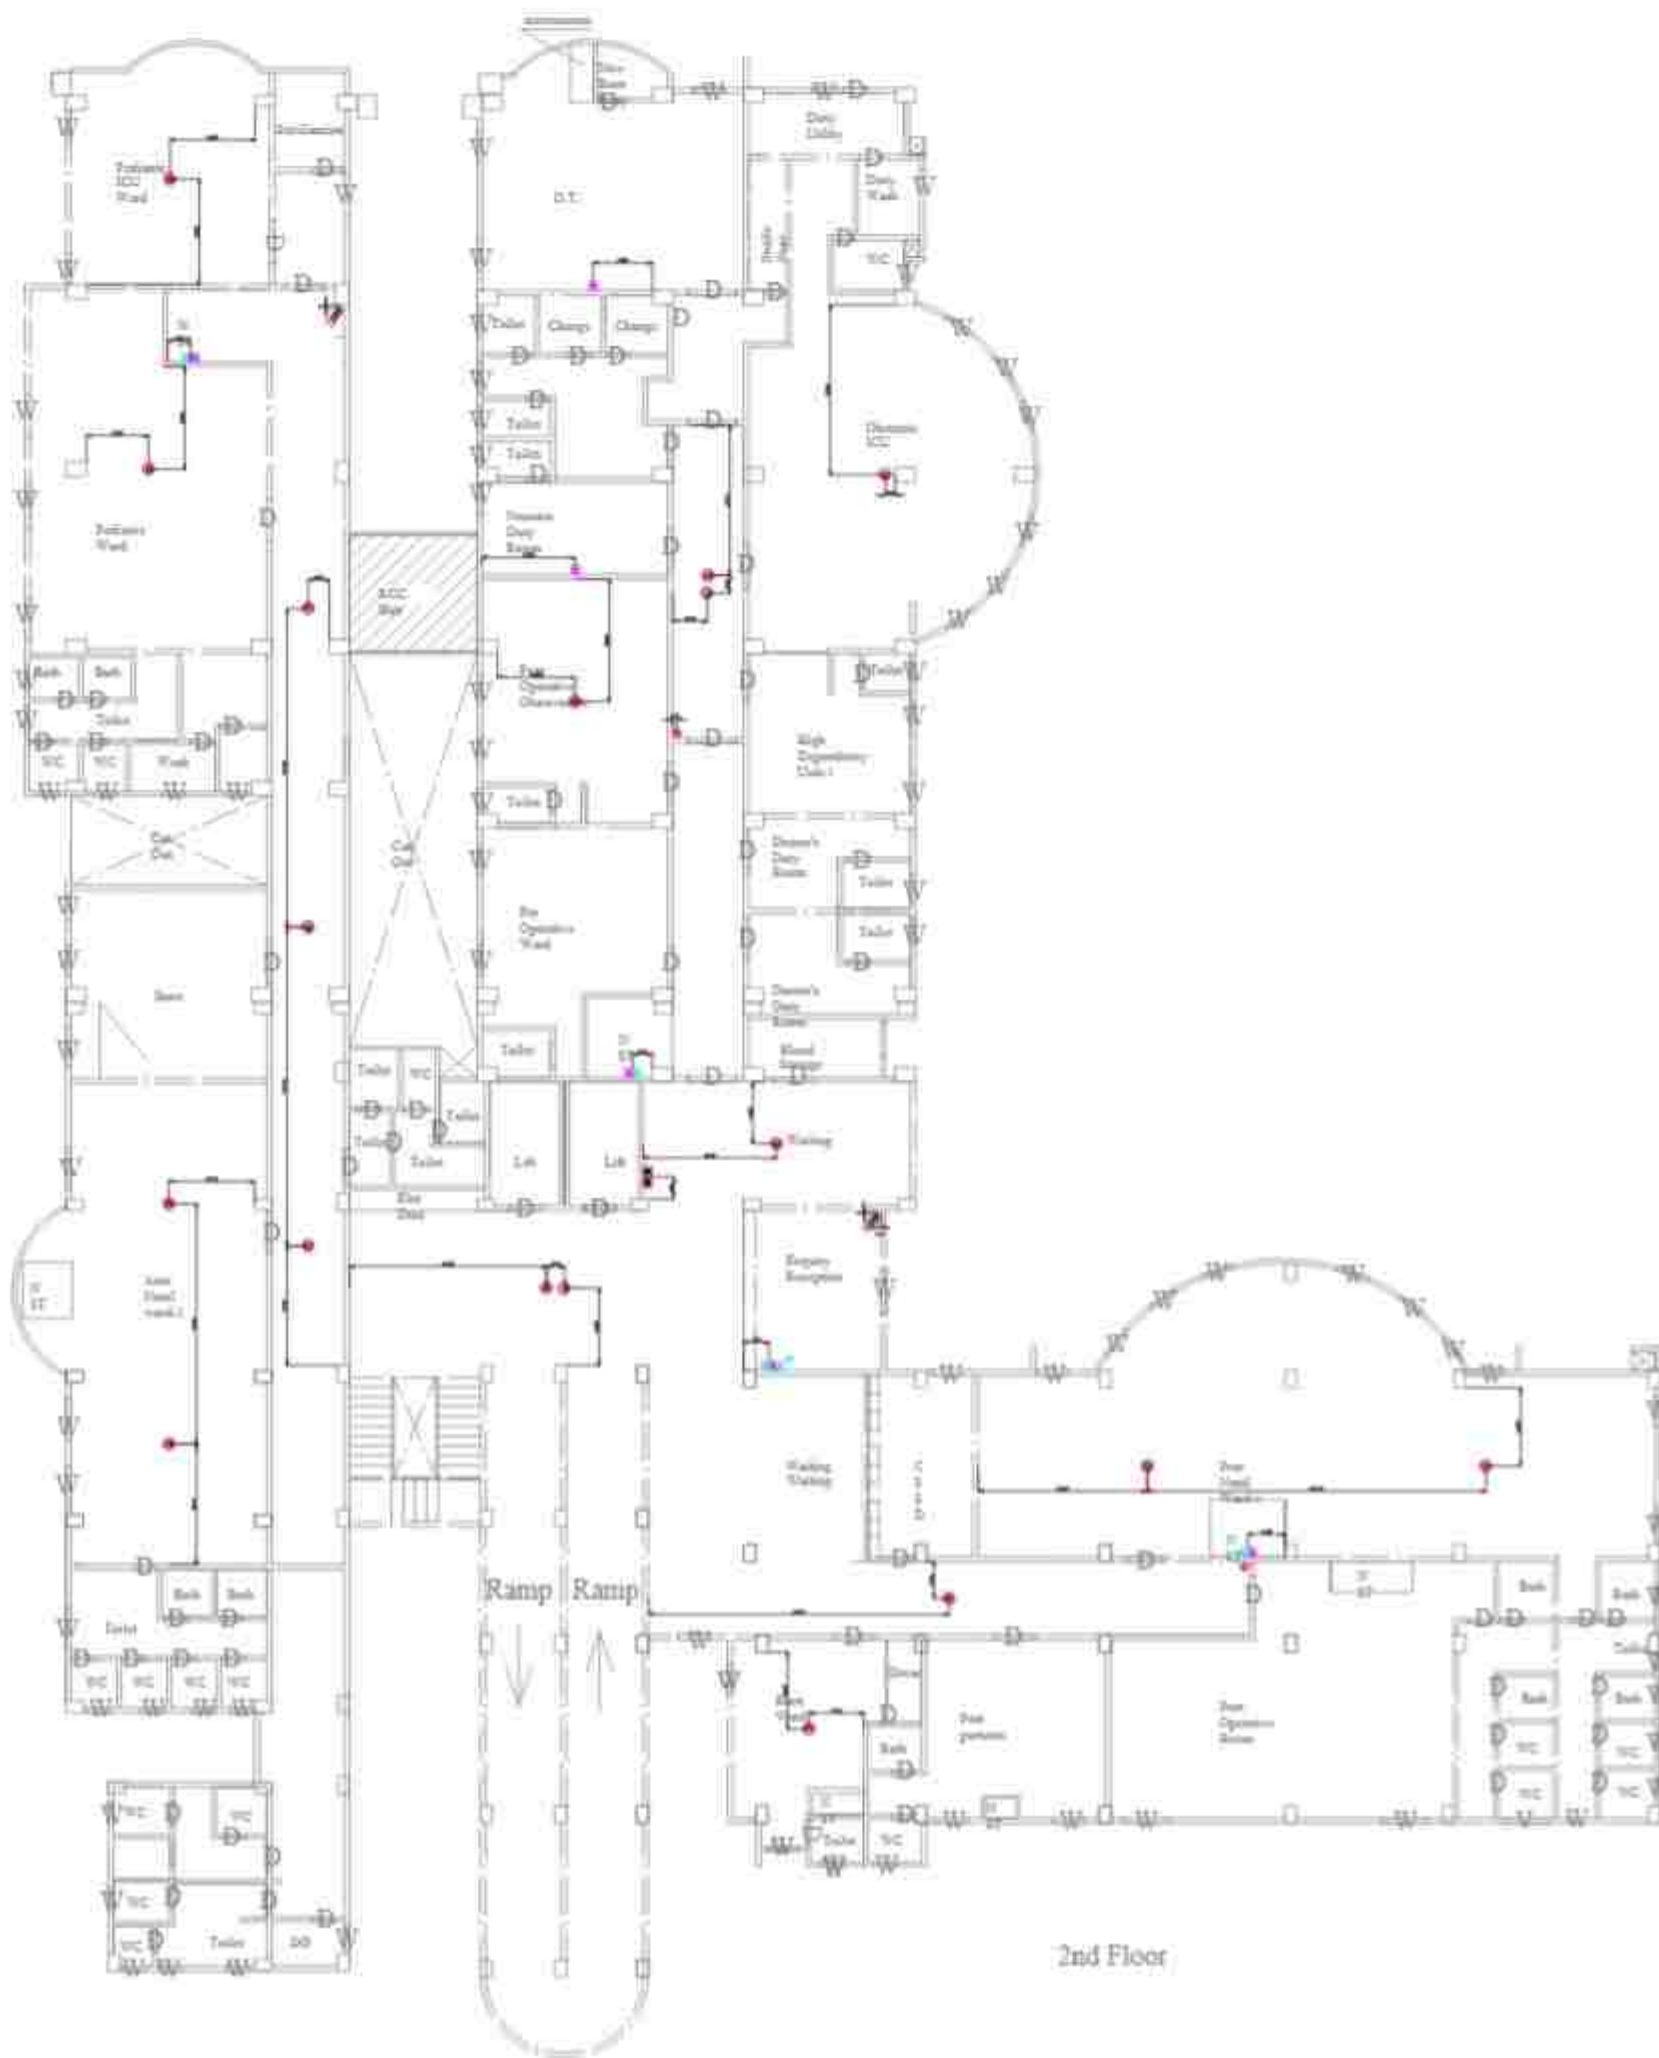

2nd Floor

FIRE DETECTION SYSTEM LEGENDS

SYMBOL	DESCRIPTION
	SMOKE DETECTOR IN TRUE CEILING
	CONTROL MODULE
	MANUAL CALL POINT
	FAULT ISOLATION MODULE
	DOME CAMERA
	BULLET CAMERA
	CEILING WIRELESS SPEAKER
	TELEPHONE POINT
	LAN POINT
	MICROPHONE POINT
	TV POINT

PROJECT -
ASSAM STATE SECONDARY HEALTHCARE
INITIATIVE FOR SERVICE DELIVERY
TRANSFORMATION (ASIST)

CLIENT -
ASSAM HEALTH INFRASTRUCTURE
DEVELOPMENT & MANAGEMENT SOCIETY
(AHIDMS)

PRINCIPAL CONSULTANT
 INTEGRA VENTURES
ARCHITECTURE, INTERIOR DESIGN & PROJECT MANAGEMENT
PUNE, INDIA

STAGE - DFE

DRAWING NO. - 2024-ASIST-KAR-DW-ELV-02-SF

START DATE	ISSUE DATE	SHEET SIZE
	18-02-2025	A3


PROJECT CODE - 2024-ASIST-KAR-DW

SCALE - 1:1

BLOCK NO - 2

FLOOR NAME - SECOND FLOOR

DRAWING TITLE -
ELV LAYOUT, BLOCK 2 SECOND FLOOR,
KARIKAU CIVIL HOSPITAL, KARIKAWA,
ASSAM

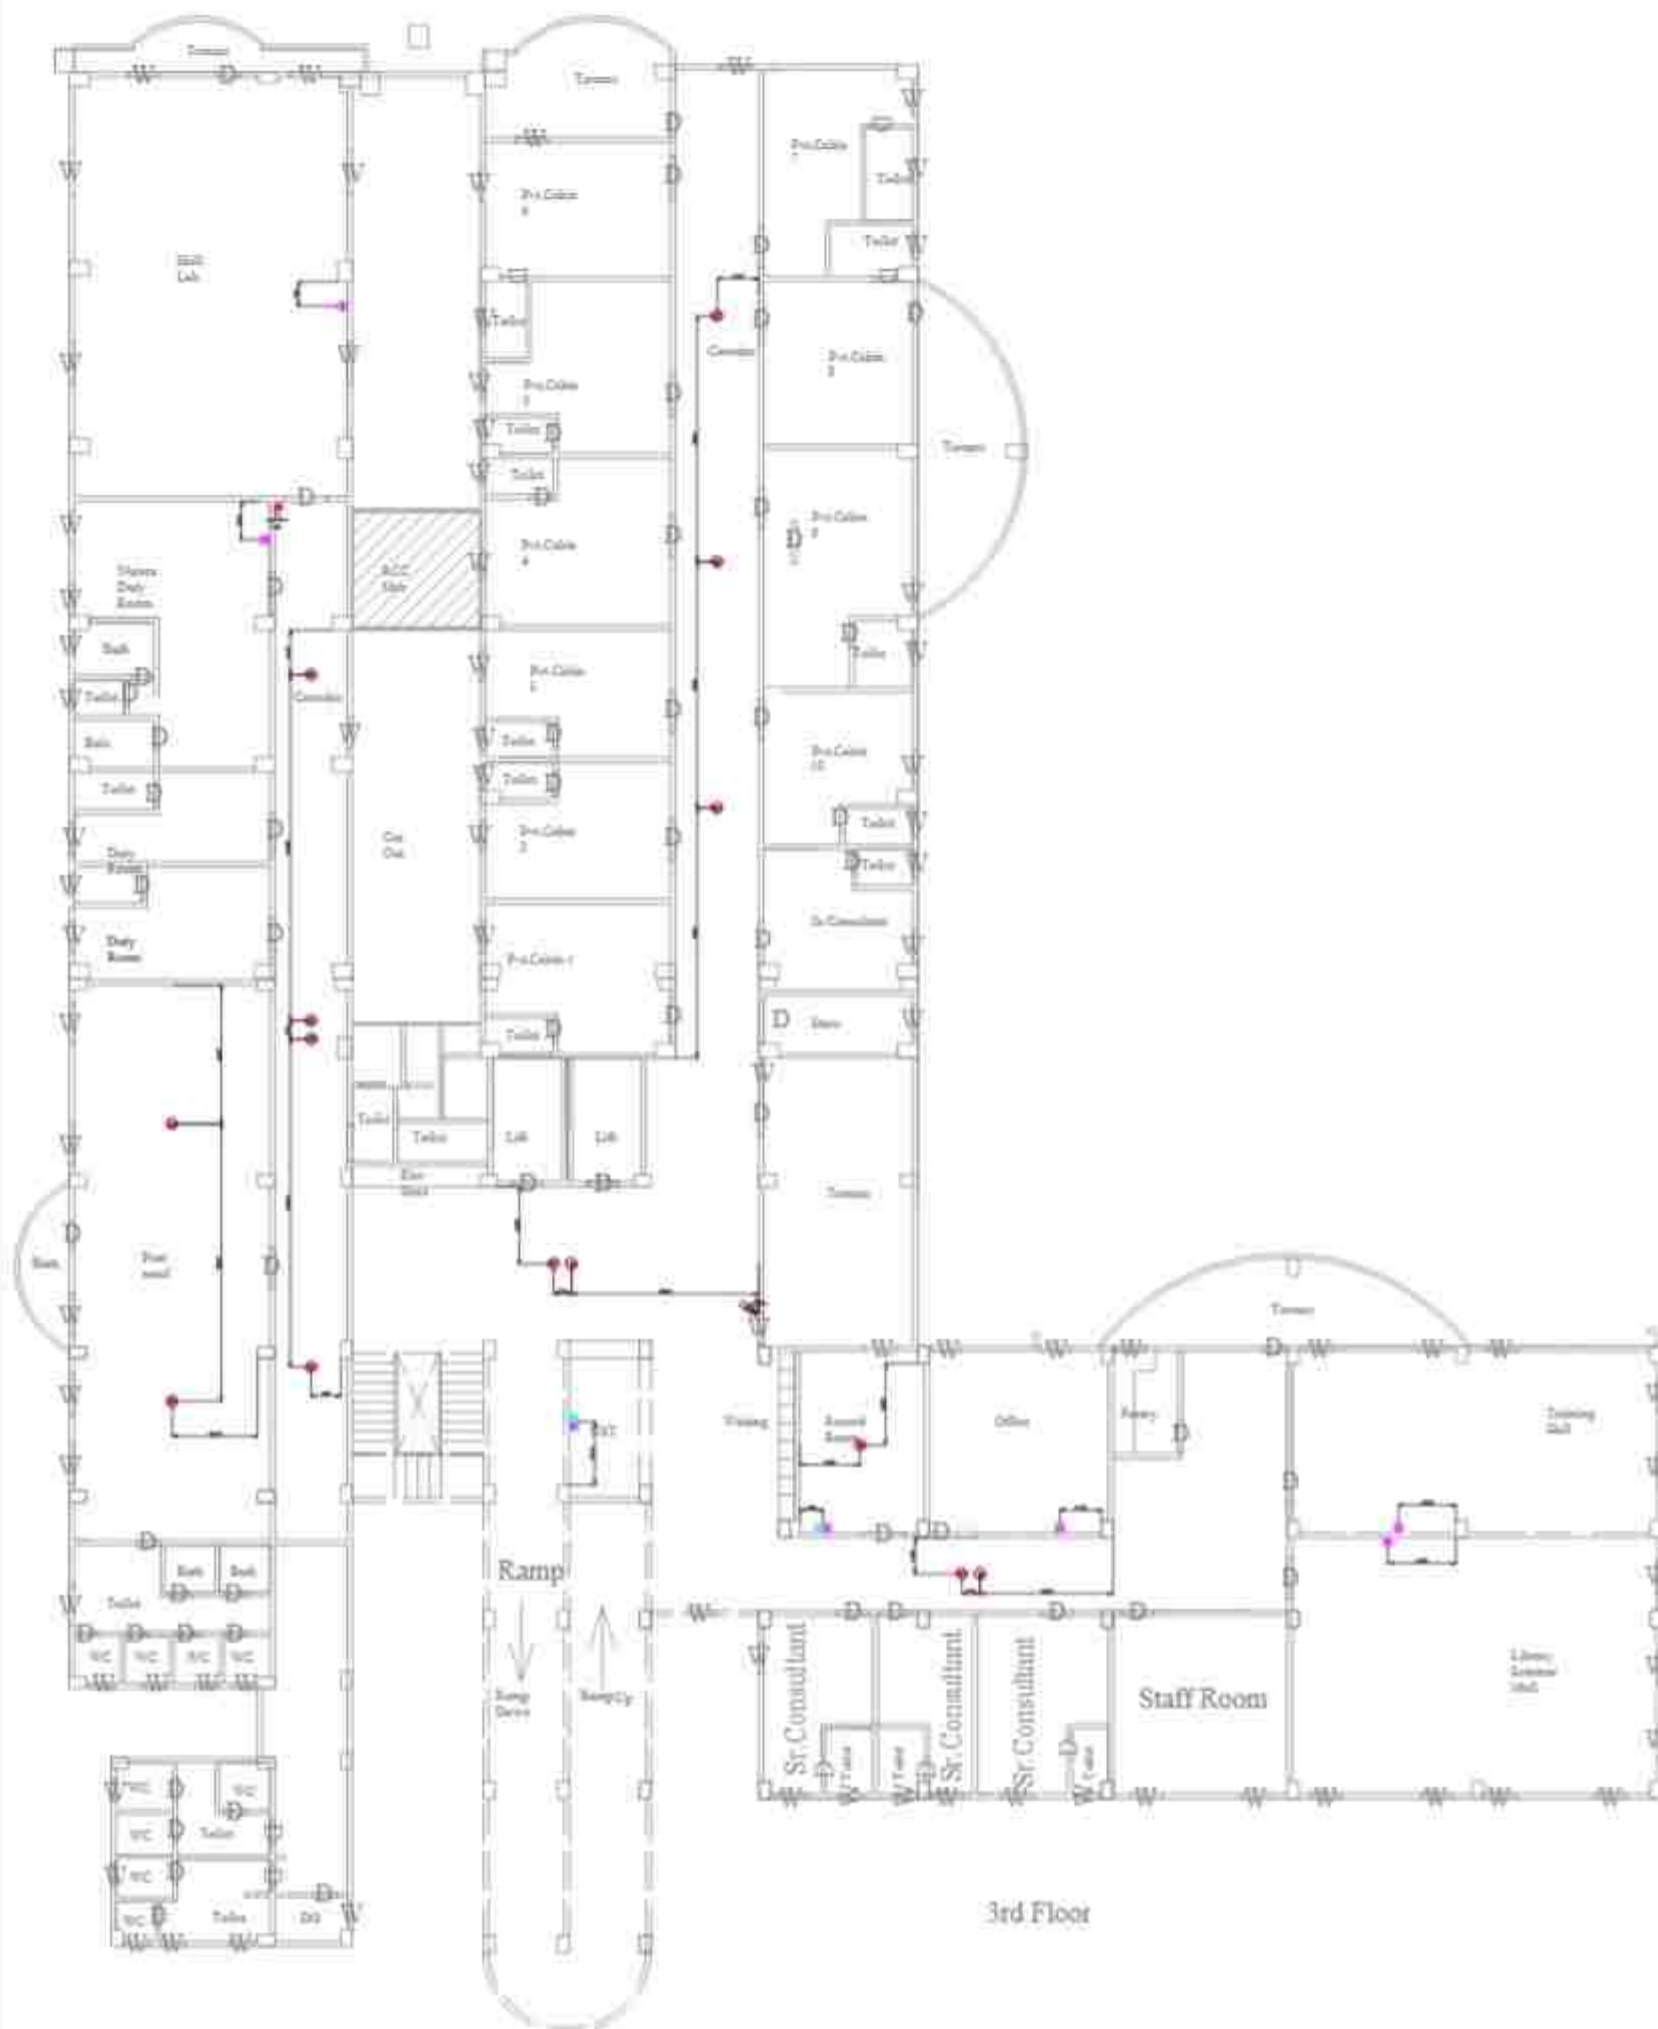

FIRE DETECTION SYSTEM LEGENDS

SYMBOL	DESCRIPTION
	SMOKE DETECTOR IN TRUE CEILING
	CONTROL MODULE
	MANUAL CALL POINT
	FIXED EXTRACTOR MODULE
	DOMO CAMERA
	BULLET CAMERA
	CEILING MOUNTED SPEAKER
	TELEPHONE POINT
	LAN POINT
	MICROPHONE POINT
	TV POINT

PROJECT:-
ASSAM STATE SECONDARY HEALTHCARE
INITIATIVE FOR SERVICE DELIVERY
TRANSFORMATION (ASST)

CLIENT:-
ASSAM HEALTH INFRASTRUCTURE
DEVELOPMENT & MANAGEMENT SOCIETY
(AHIMS)

PRINCIPAL CONSULTANT:-

INTEGRA VENTURES
PVT. LTD. (A PRIVATE LIMITED COMPANY)
REGISTERED IN INDIA UNDER THE COMPANIES ACT, 2013
CIN: U74100AS2015PTC000000

STAGE:- D00

DRAWING NO:-
204/ASST-KAR-D0/ELV-02.TY

START DATE	ISSUE DATE	SHEET SIZE
	10-03-2021	A2


PROJECT CODE:- 204/ASST-KAR-D0

SCALE:- N.T.S.

BLOCK NO:- 1

FLOOR NAME:- THIRD FLOOR

DRAWING TITLE:-
ELV LAYOUT, BLOCK 1 THIRD FLOOR,
KARDAGANU CIVIL HOSPITAL, KARDAGANU,
ASSAM.

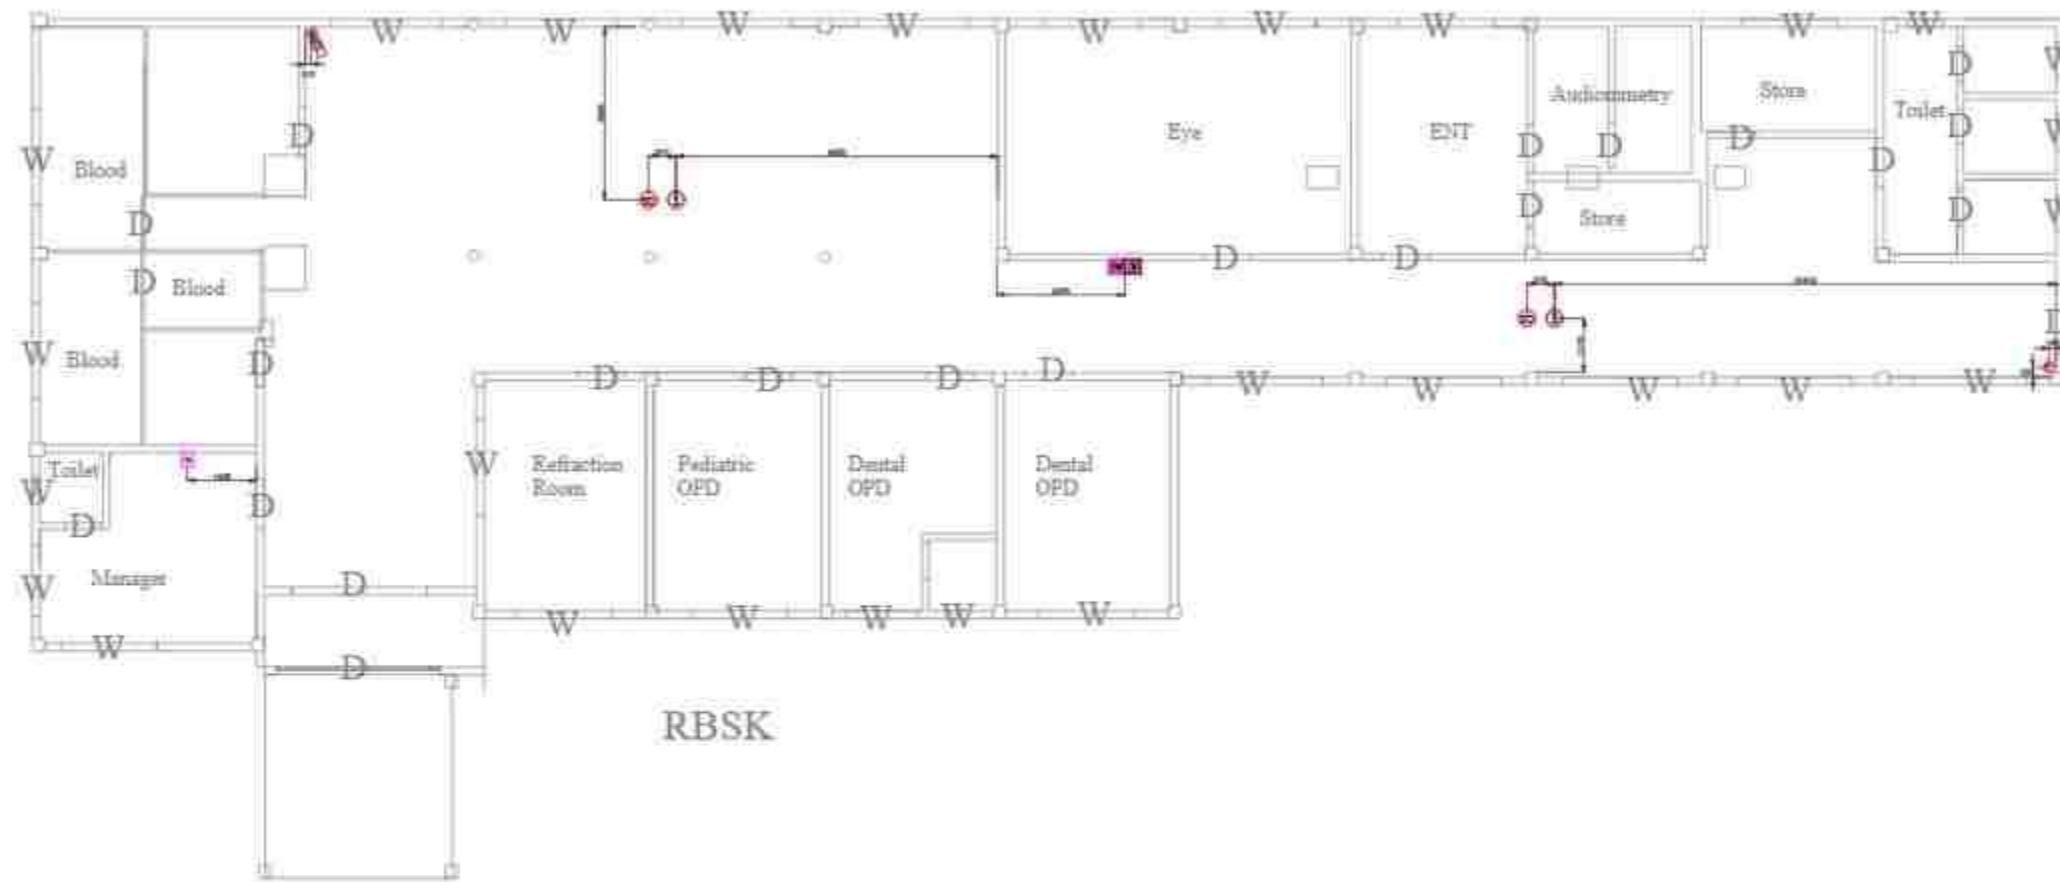

RBSK

FIRE DETECTION SYSTEM LEGENDS

SYMBOL	DESCRIPTION
	SMOKE DETECTOR IN TRUE CEILING
	CONTROL MODULE
	MANUAL CALL POINT
	FAULT ISOLATOR MODULE
	DOMO CAMERA
	BULLET CAMERA
	CEILING MOUNTED SPEAKER
	TELEPHONE POINT
	LAN POINT
	MICROPHONE POINT
	TV POINT

PROJECT:-
ASSAM STATE SECONDARY HEALTHCARE
INITIATIVE FOR SERVICE DELIVERY
TRANSFORMATION (ASSIST)

CLIENT:-
ASSAM HEALTH INFRASTRUCTURE
DEVELOPMENT & MANAGEMENT SOCIETY
(AHIDMS)

PRINCIPAL CONSULTANT:



PRITHVI GREENS, BLOCK A GROUND FLOOR
KATHARJALAY, GUWAHATI-781011, ASSAM
IN: +91-9401727145

STAGE:- DPR

DRAWING NO:-
2024/ASSIST-KAR/DH/ELV/03

START DATE	ISSUE DATE	SHEET SIZE
	10-02-2025	A3

PROJECT CODE:- 2024/ASSIST-KAR/DH


SCALE:- N.T.S.


BLOCK NO :- 3

FLOOR NAME: GROUND FLOOR

DRAWING TITLE:-
ELV LAYOUT, BLOCK 3 GROUND FLOOR,
KARIMGANJ CIVIL HOSPITAL, KARIMGANJ,
ASSAM.

UGR PUDDLE FLANGE DETAILS LAYOUT,
KARIMGANJ CIVIL HOSPITAL, KARIMGANJ,
ASSAM.

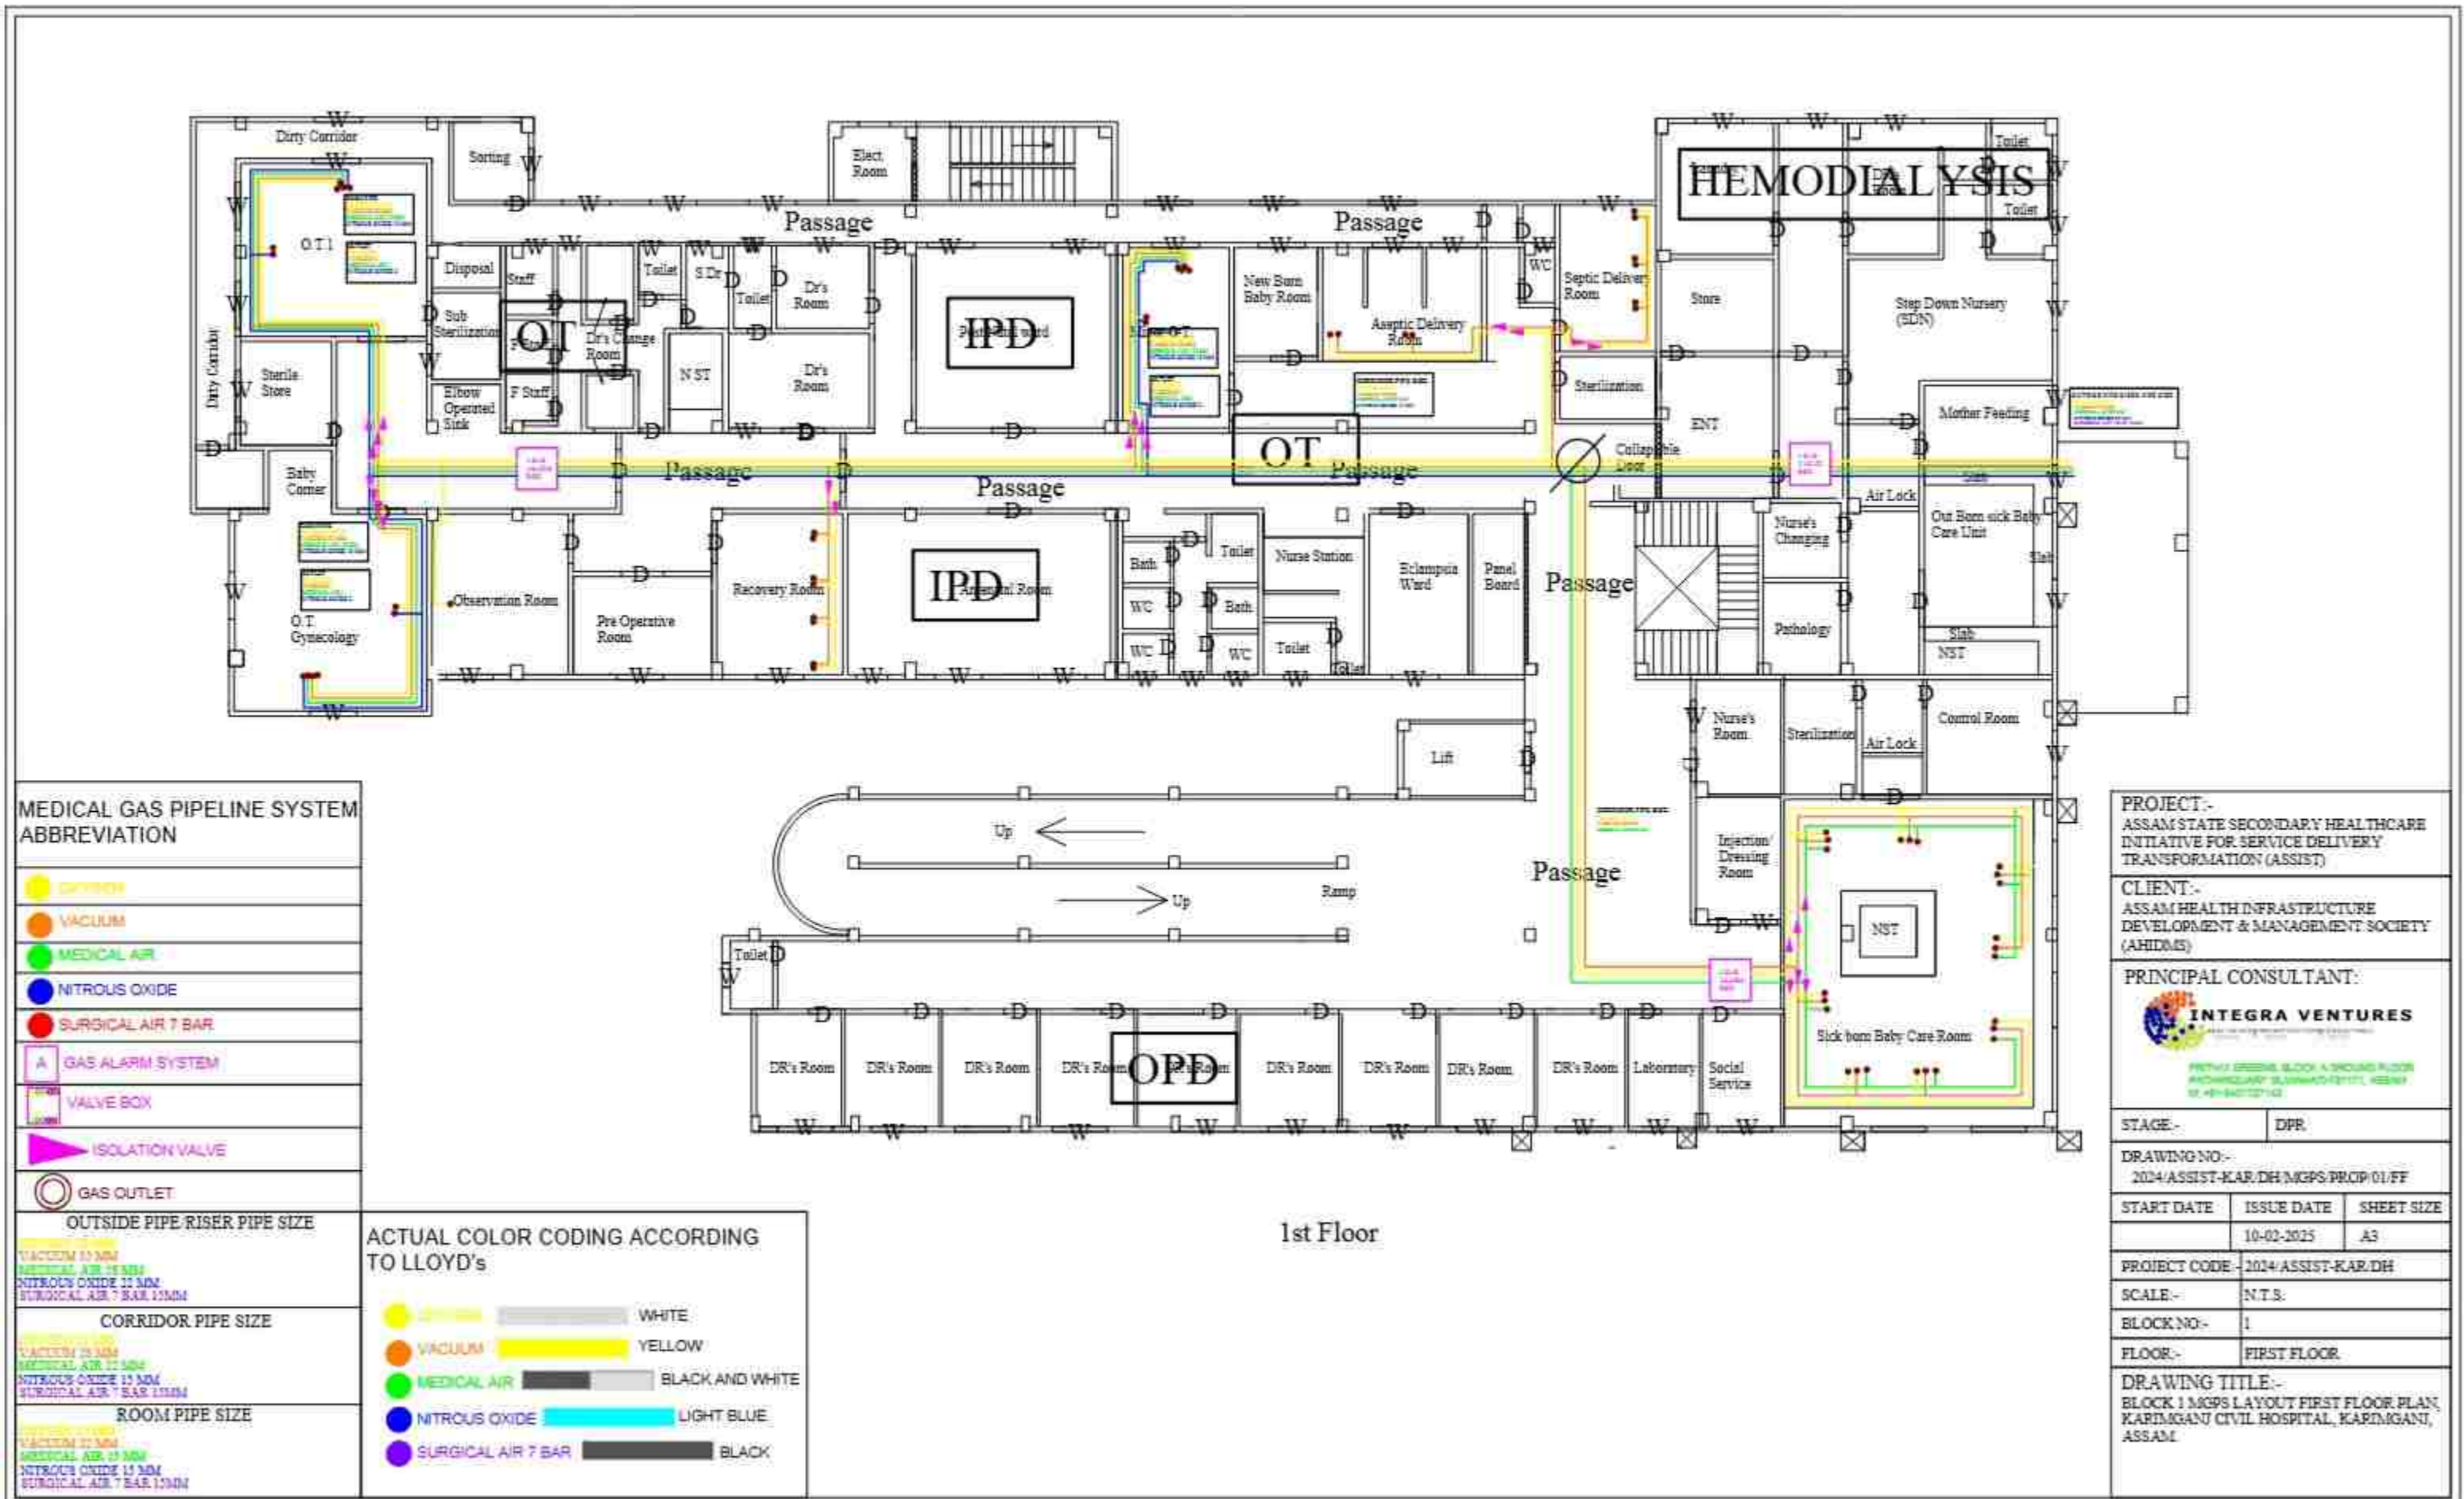

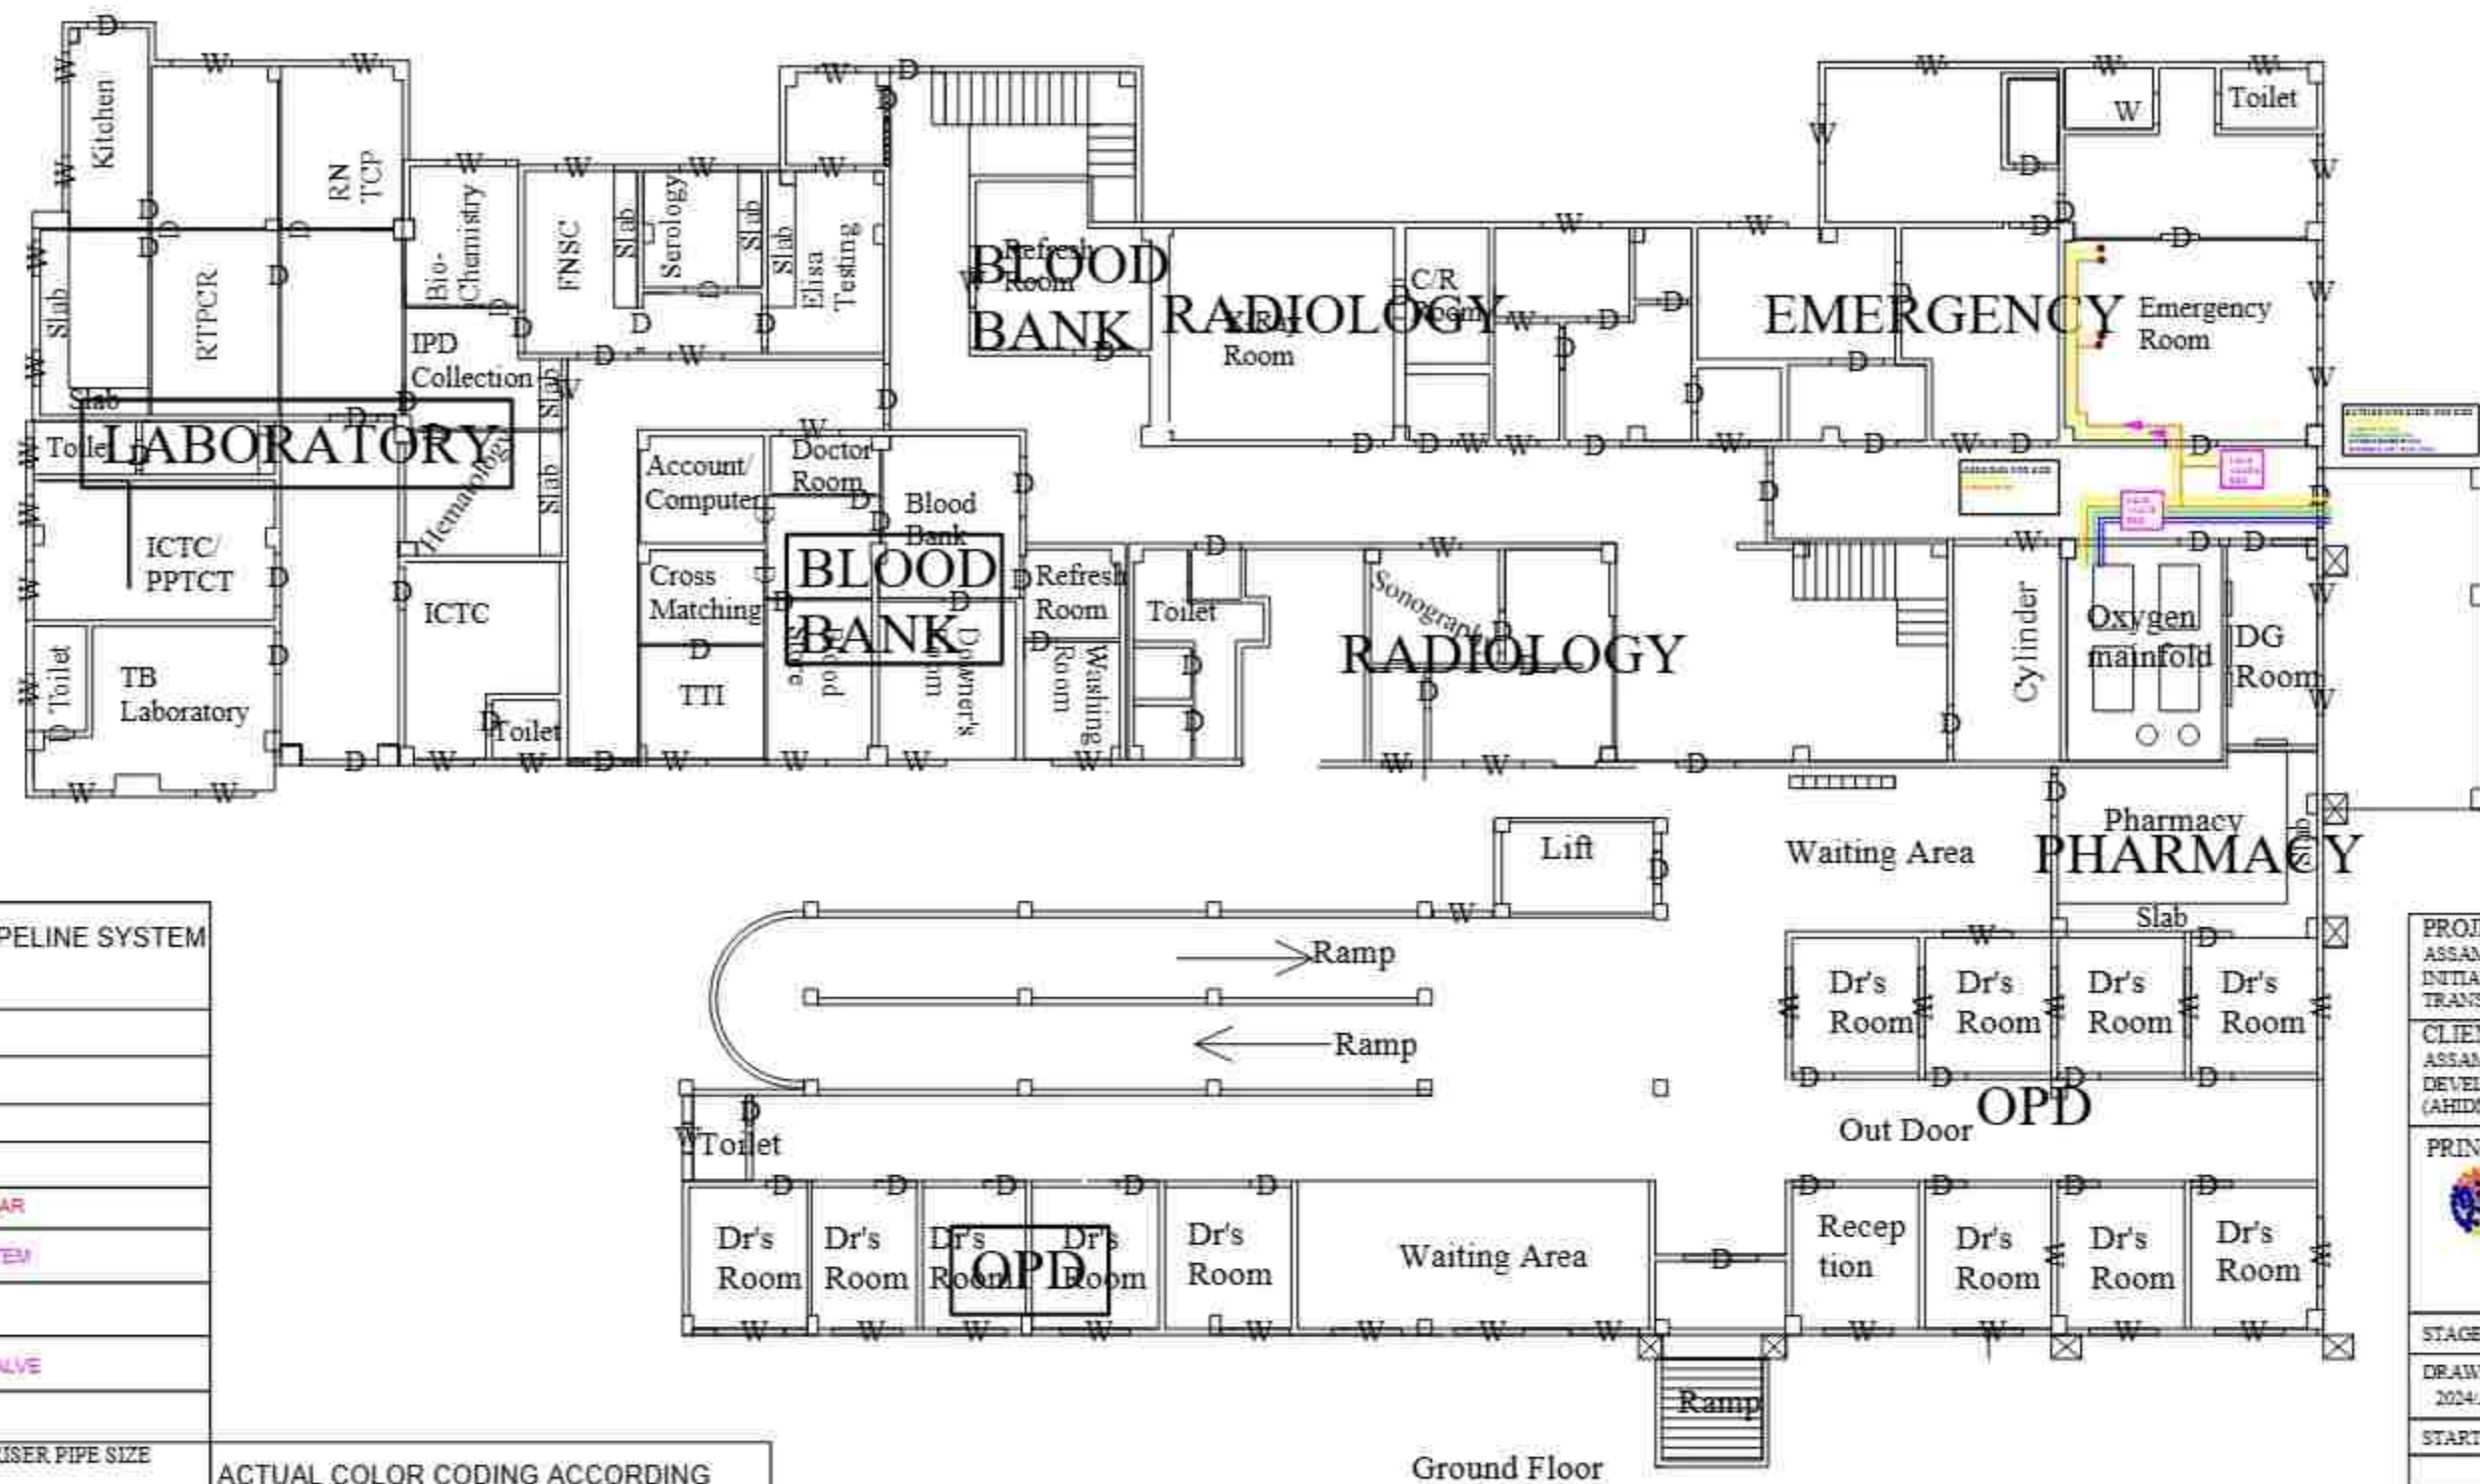

MEDICAL GAS PIPELINE SYSTEM ABBREVIATION

●	VACUUM
●	MEDICAL AIR
●	NITROUS OXIDE
●	SURGICAL AIR 7 BAR
A	GAS ALARM SYSTEM
V	VALVE BOX
I	ISOLATION VALVE
G	GAS OUTLET

OUTSIDE PIPE/RISER PIPE SIZE
VACUUM 15 MM
MEDICAL AIR 15 MM
NITROUS OXIDE 15 MM
SURGICAL AIR 7 BAR 15MM
CORRIDOR PIPE SIZE
VACUUM 15 MM
MEDICAL AIR 15 MM
NITROUS OXIDE 15 MM
SURGICAL AIR 7 BAR 15MM
ROOM PIPE SIZE
VACUUM 15 MM
MEDICAL AIR 15 MM
NITROUS OXIDE 15 MM
SURGICAL AIR 7 BAR 15MM

ACTUAL COLOR CODING ACCORDING TO LLOYD'S

●	WHITE
●	YELLOW
●	BLACK AND WHITE
●	LIGHT BLUE
●	BLACK

PROJECT:-
ASSAM STATE SECONDARY HEALTHCARE INITIATIVE FOR SERVICE DELIVERY TRANSFORMATION (ASSIST)

CLIENT:-
ASSAM HEALTH INFRASTRUCTURE DEVELOPMENT & MANAGEMENT SOCIETY (AHIDMS)

PRINCIPAL CONSULTANT:-
INTEGRA VENTURES
ASSAM HEALTH INFRASTRUCTURE DEVELOPMENT & MANAGEMENT SOCIETY (AHIDMS)

STAGE:- DPR

DRAWING NO:-
2024/ASSIST-KAR/DH/MGPS/PROP/01/GF

START DATE	ISSUE DATE	SHEET SIZE
	10-02-2025	A3


PROJECT CODE:- 2024/ASSIST-KAR/DH

SCALE:- N.T.S.

BLOCK NO:- 1

FLOOR:- GROUND FLOOR

DRAWING TITLE:-
BLOCK 1 MGPS LAYOUT GROUND FLOOR
PLAN
KARIMGANJ CIVIL HOSPITAL, KARIMGANJ, ASSAM

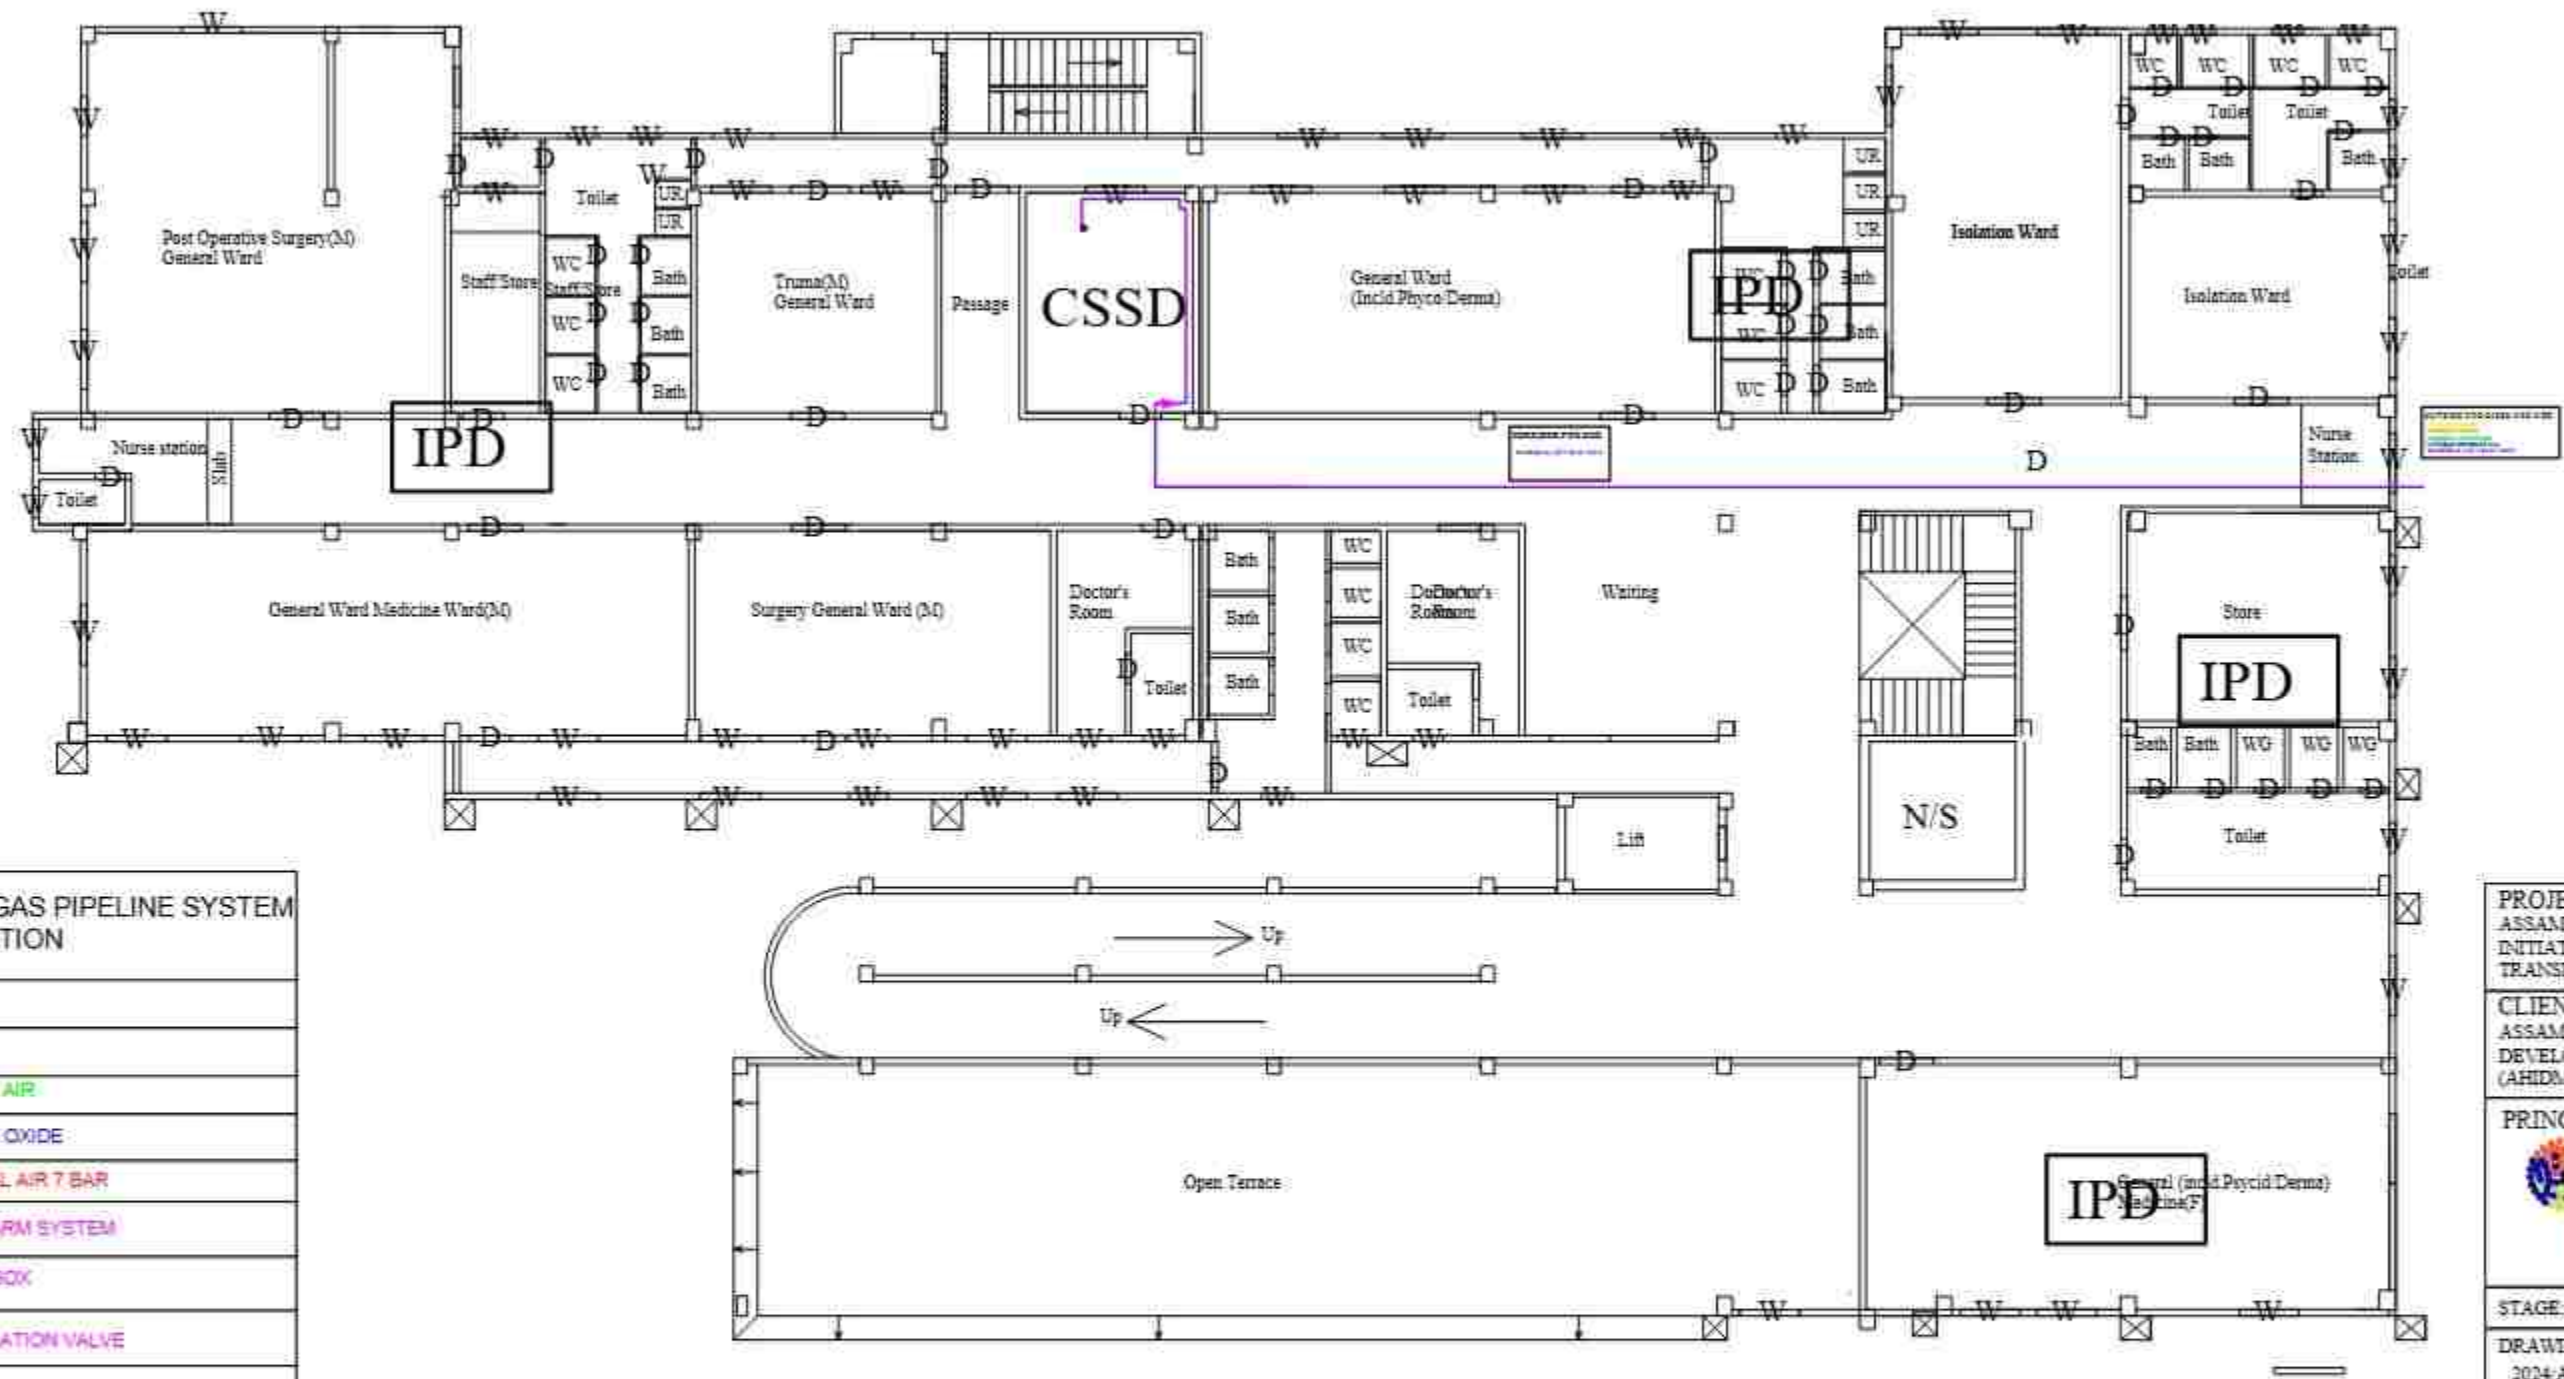

2nd Floor

MEDICAL GAS PIPELINE SYSTEM ABBREVIATION

	VACUUM
	MEDICAL AIR
	NITROUS OXIDE
	SURGICAL AIR 7 BAR
	GAS ALARM SYSTEM
	VALVE BOX
	ISOLATION VALVE
	GAS OUTLET

OUTSIDE PIPE/RISER PIPE SIZE
VACUUM 15 MM
MEDICAL AIR 15 MM
NITROUS OXIDE 15 MM
SURGICAL AIR 7 BAR 15MM
CORRIDOR PIPE SIZE
VACUUM 15 MM
MEDICAL AIR 15 MM
NITROUS OXIDE 15 MM
SURGICAL AIR 7 BAR 15MM
ROOM PIPE SIZE
VACUUM 15 MM
MEDICAL AIR 15 MM
NITROUS OXIDE 15 MM
SURGICAL AIR 7 BAR 15MM

ACTUAL COLOR CODING ACCORDING TO LLOYD'S

	VACUUM	WHITE
	MEDICAL AIR	YELLOW
	NITROUS OXIDE	BLACK AND WHITE
	SURGICAL AIR 7 BAR	LIGHT BLUE
	ISOLATION VALVE	BLACK

PROJECT:-
ASSAM STATE SECONDARY HEALTHCARE INITIATIVE FOR SERVICE DELIVERY TRANSFORMATION (ASSIST)

CLIENT:-
ASSAM HEALTH INFRASTRUCTURE DEVELOPMENT & MANAGEMENT SOCIETY (AHIDMS)

PRINCIPAL CONSULTANT:

PRINCIPAL DESIGNER, BLOCK 4 SECOND FLOOR
KARIMGANJ CIVIL HOSPITAL, KARIMGANJ, ASSAM
MO: 9871211142

STAGE:- DPR

DRAWING NO:-
2024-ASSIST-KAR/DH/MGPS/PROP/01/SF

START DATE	ISSUE DATE	SHEET SIZE
	10-02-2025	A3


PROJECT CODE:- 2024-ASSIST-KAR/DH

SCALE:- N.T.S.

BLOCK NO:- 1


FLOOR:- SECOND FLOOR

DRAWING TITLE:-
BLOCK 1 MGPS LAYOUT SECOND FLOOR
PLAN,
KARIMGANJ CIVIL HOSPITAL, KARIMGANJ, ASSAM

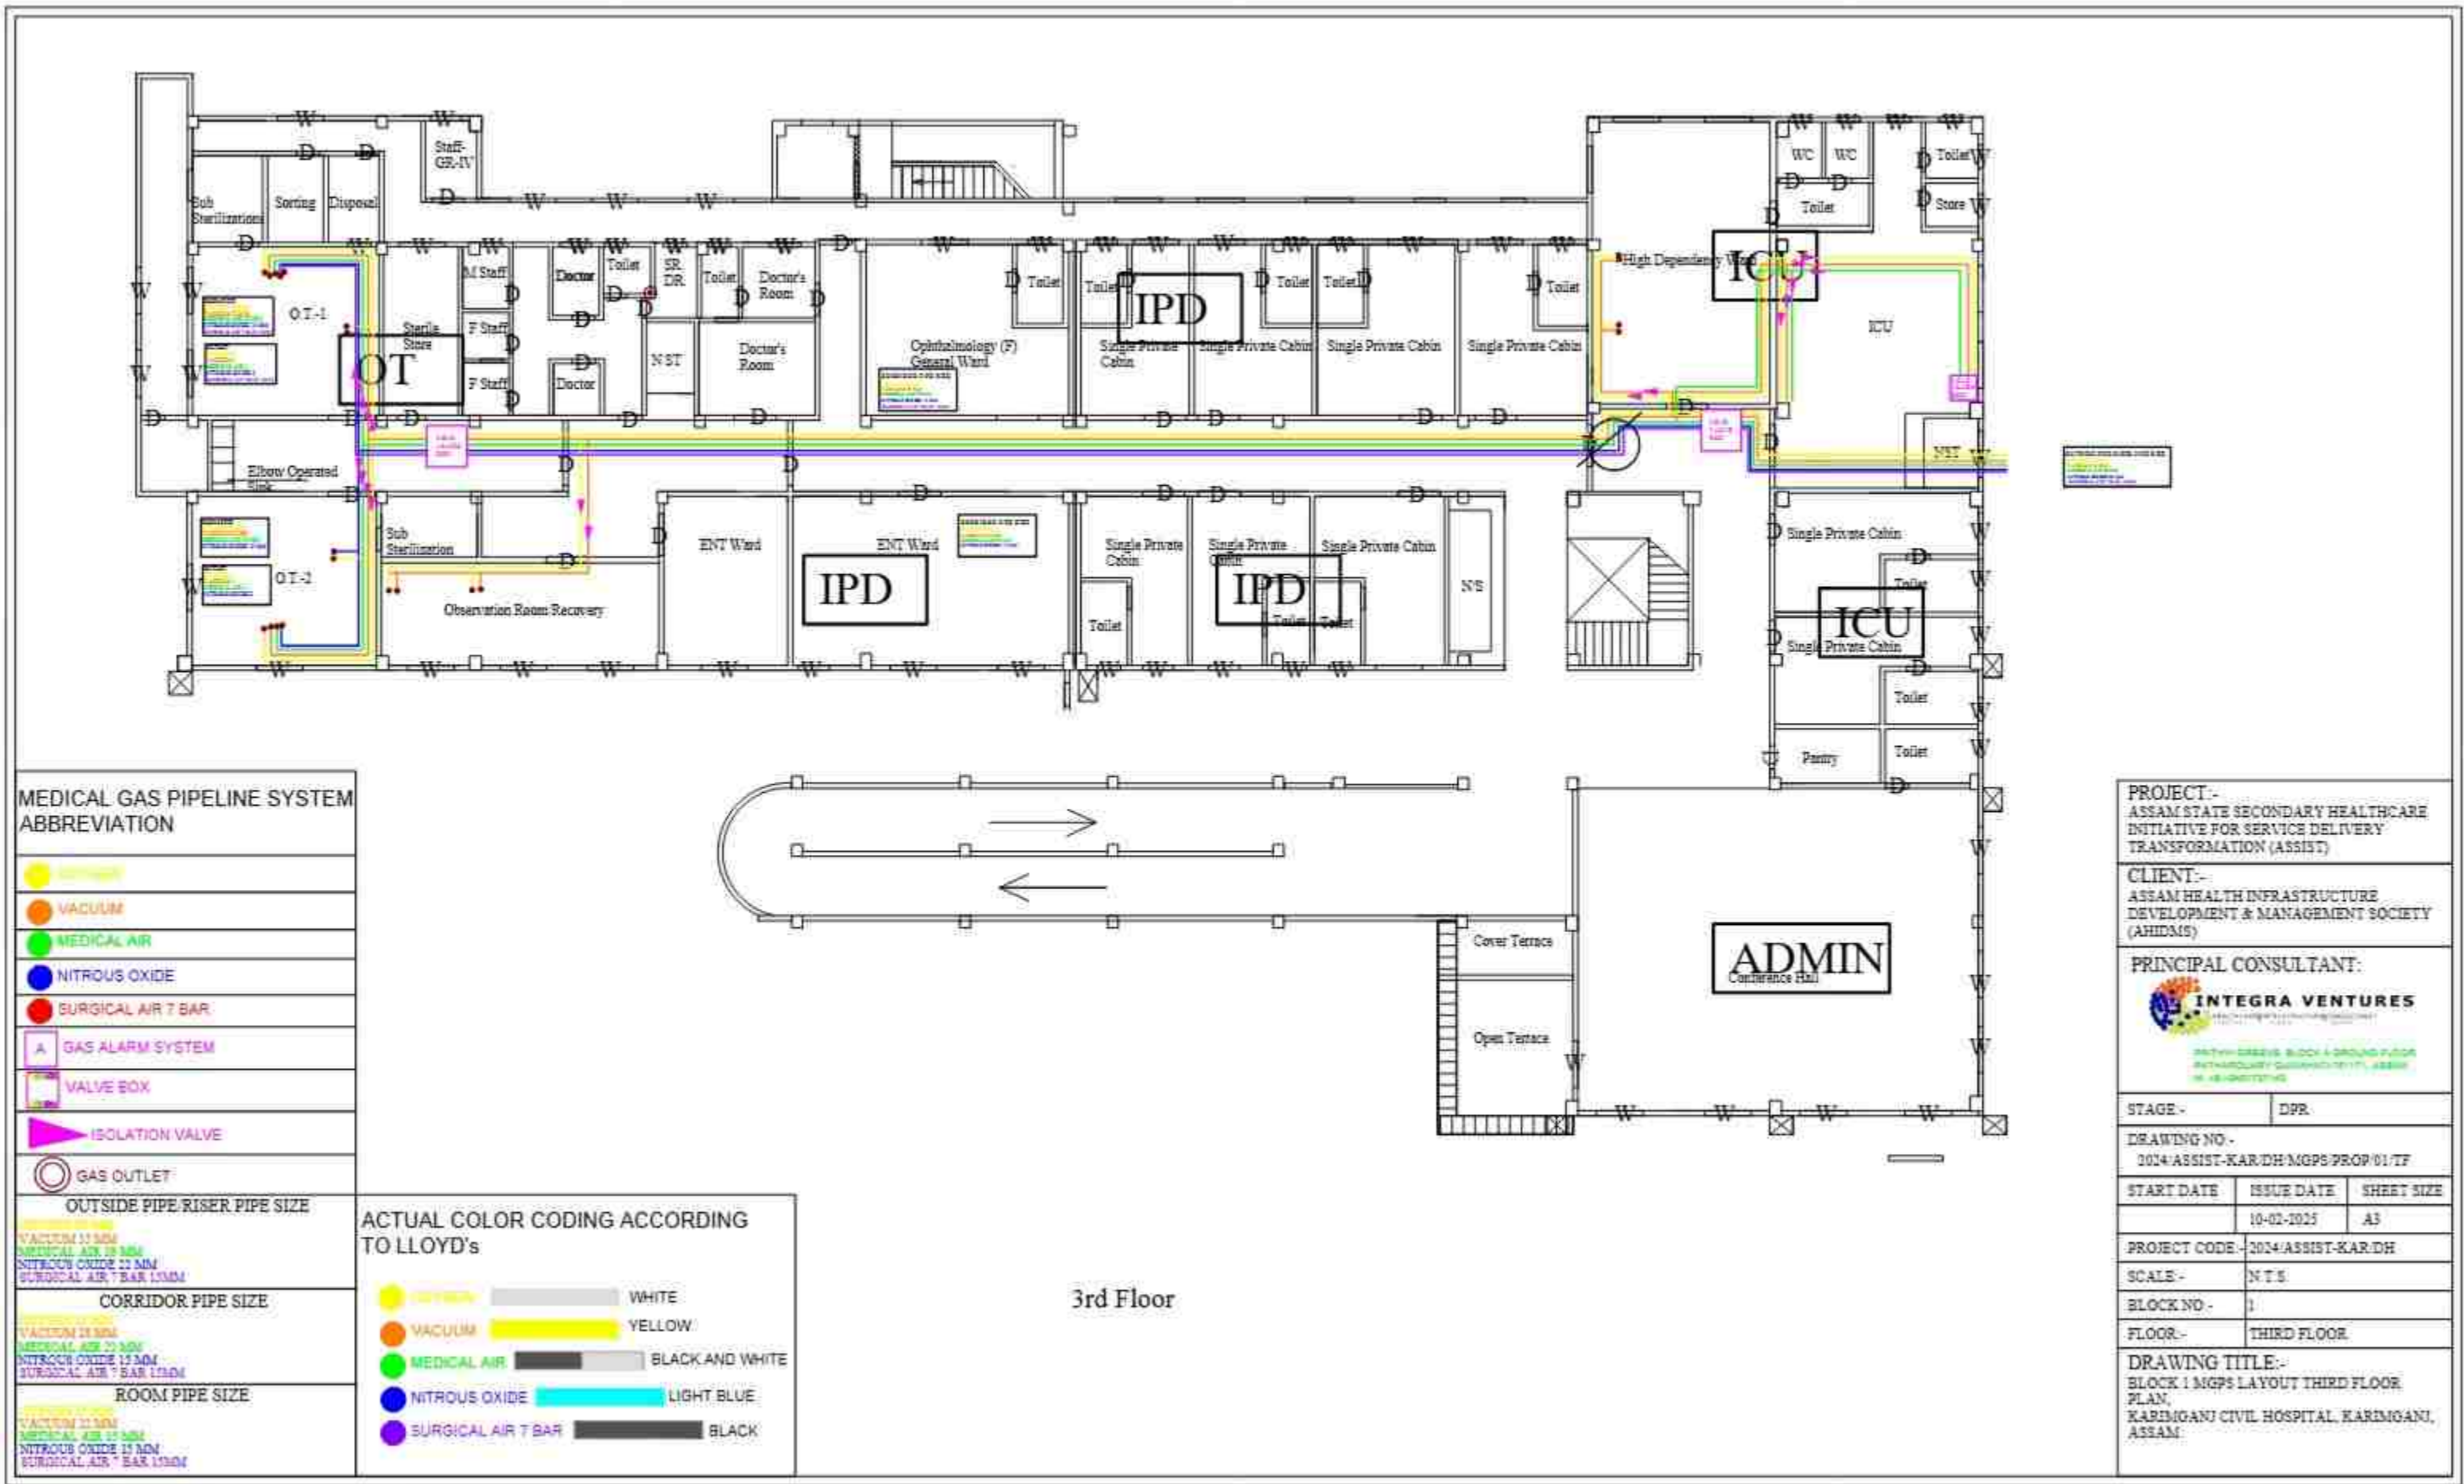



PROJECT:- ASSAM STATE SECONDARY HEALTHCARE INITIATIVE FOR SERVICE DELIVERY TRANSFORMATION (ASIST)		
CLIENT:- ASSAM HEALTH INFRASTRUCTURE DEVELOPMENT & MANAGEMENT SOCIETY (AHIDMS)		
PRINCIPAL CONSULTANT:  INTEGRA VENTURES Healthcare Block & Ground Floor Karmagani Civil Hospital, Karmagani, Assam IN-10-0000000000		
STAGE -	DPR	
DRAWING NO - 2024/ASSIST-KAR.DH.MOPS/PROP-01.FF		
START DATE	ISSUE DATE	SHEET SIZE
	10-01-2025	A3
PROJECT CODE:-	2024/ASSIST-KAR.DH	
SCALE -	N.T.S.	
BLOCK NO.-	2	
FLOOR.-	FIRST FLOOR	
DRAWING TITLE:- BLOCK 2 MOPS LAYOUT FIRST FLOOR PLAN, KARMAGANI CIVIL HOSPITAL, KARMAGANI, ASSAM		

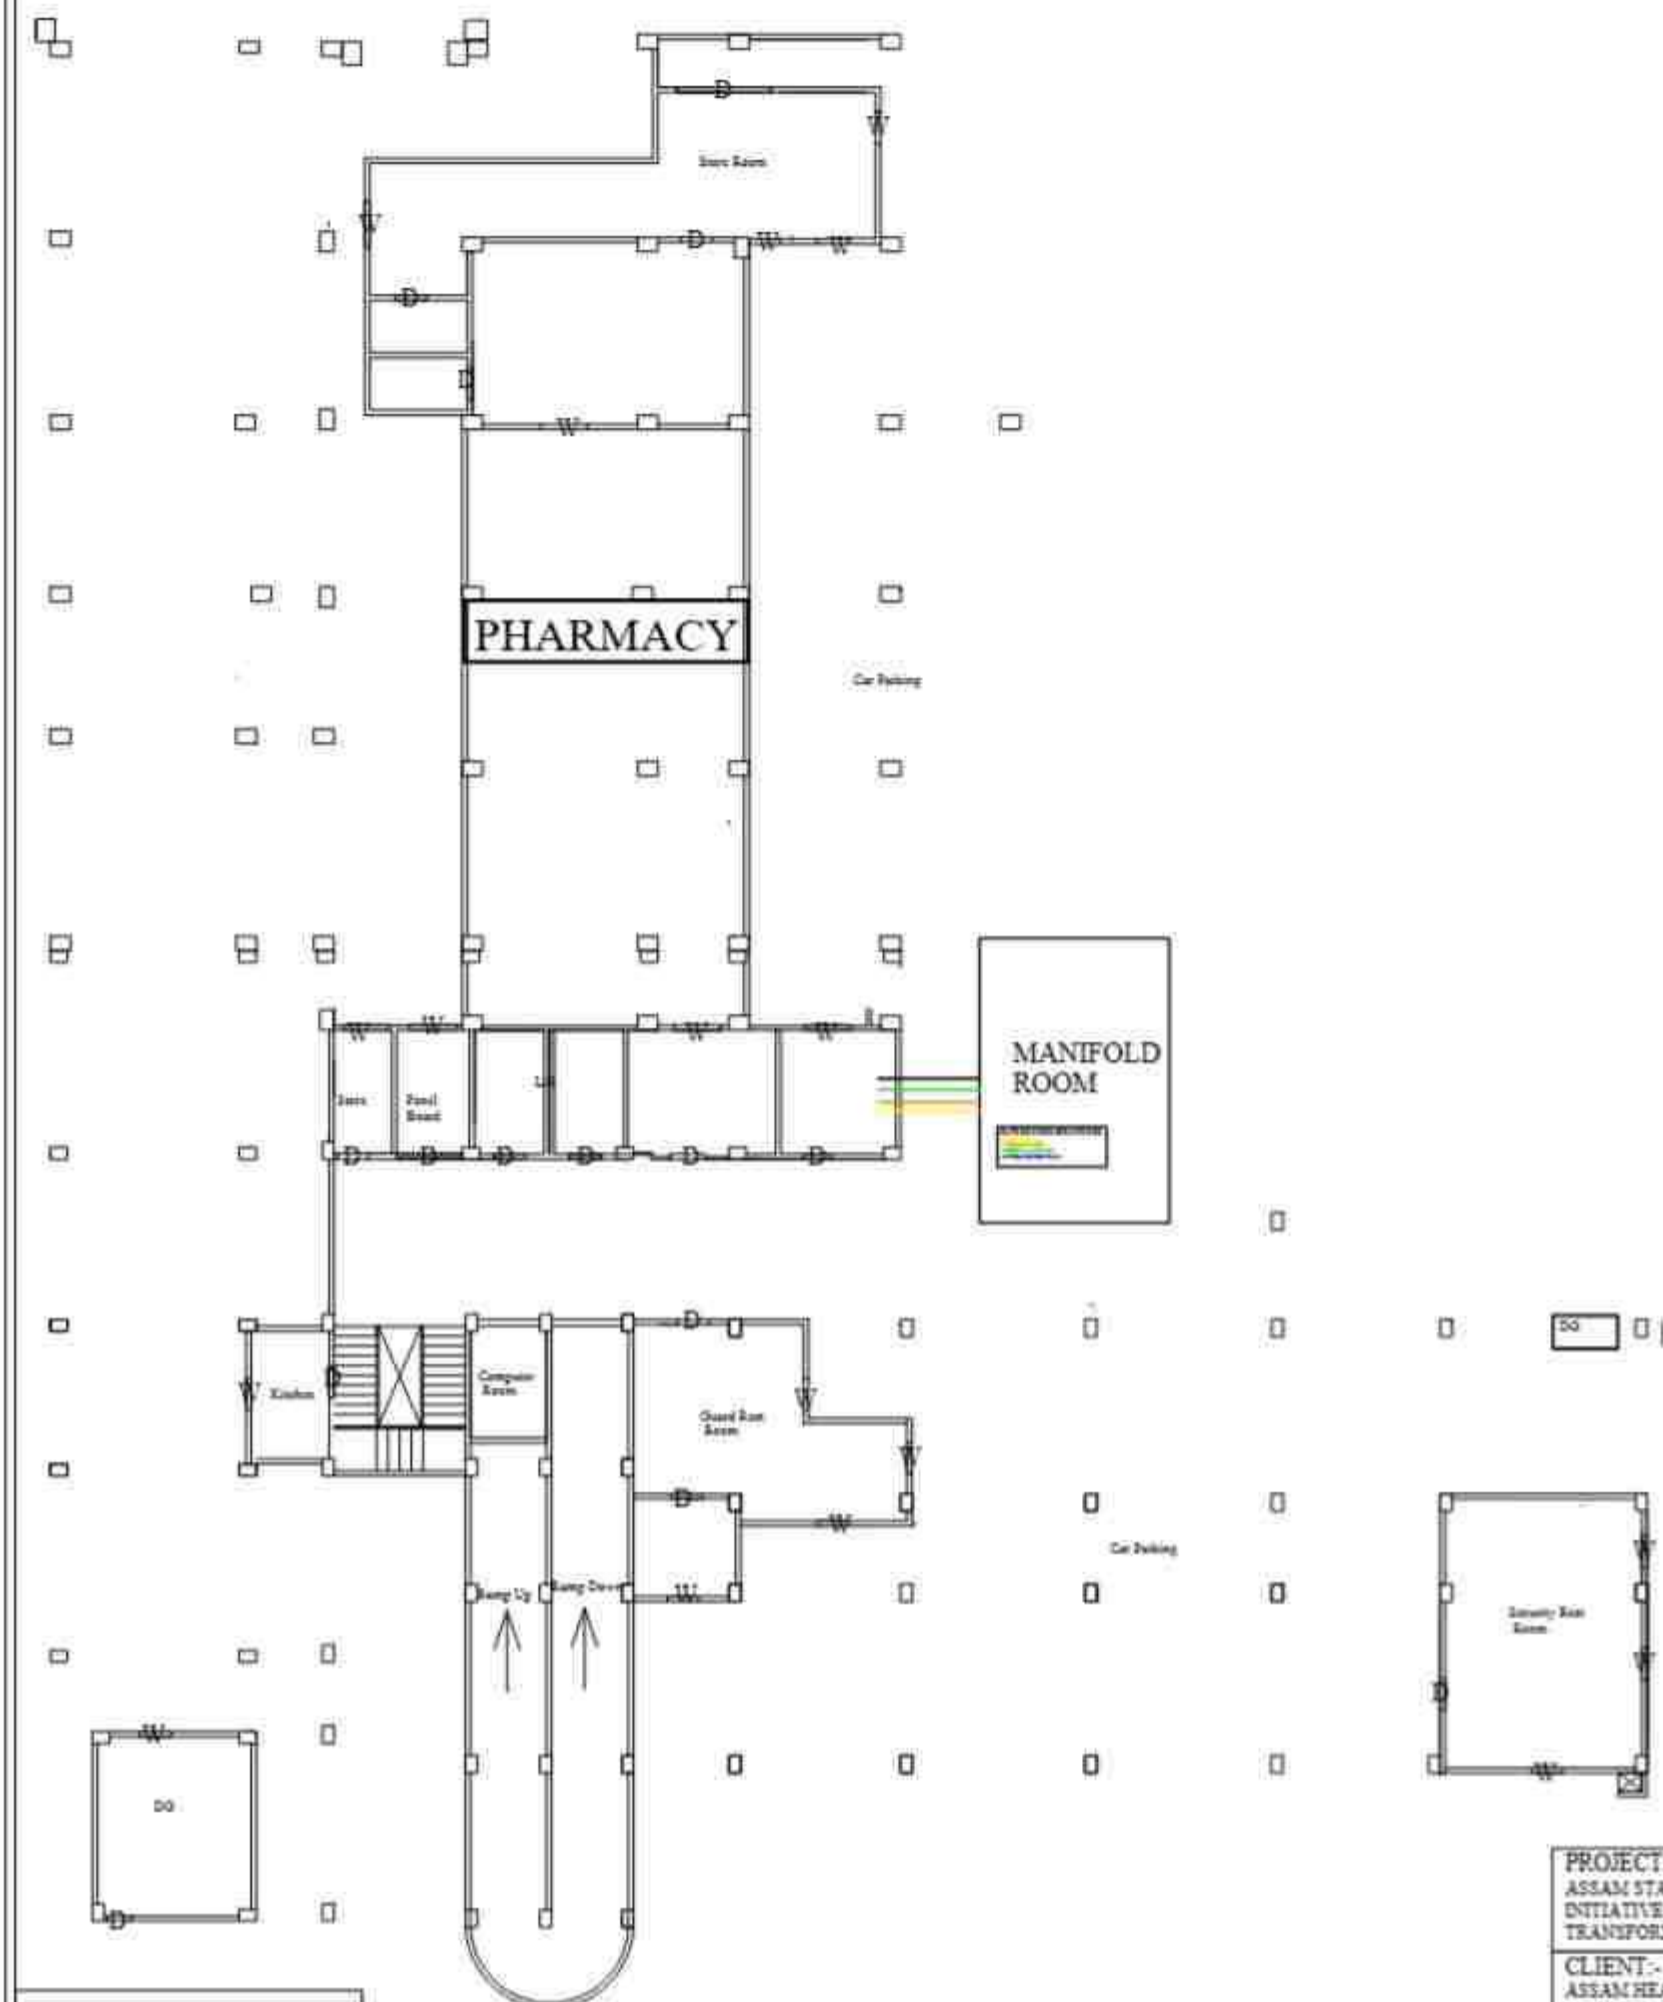


Ground Floor

MEDICAL GAS PIPELINE SYSTEM ABBREVIATION	
	VACUUM
	VACUUM
	MEDICAL AIR
	NITROUS OXIDE
	SURGICAL AIR 7 BAR
	GAS ALARM SYSTEM
	VALVE BOX
	ISOLATION VALVE
	GAS OUTLET
OUTSIDE PIPE RUNNER PIPE SIZE	
1" MEDICAL AIR	1" MEDICAL AIR
1" VACUUM	1" VACUUM
1" NITROUS OXIDE	1" NITROUS OXIDE
1" SURGICAL AIR 7 BAR	1" SURGICAL AIR 7 BAR
CORRIDOR PIPE SIZE	
1" MEDICAL AIR	1" MEDICAL AIR
1" VACUUM	1" VACUUM
1" NITROUS OXIDE	1" NITROUS OXIDE
1" SURGICAL AIR 7 BAR	1" SURGICAL AIR 7 BAR
ROOM PIPE SIZE	
1" MEDICAL AIR	1" MEDICAL AIR
1" VACUUM	1" VACUUM
1" NITROUS OXIDE	1" NITROUS OXIDE
1" SURGICAL AIR 7 BAR	1" SURGICAL AIR 7 BAR

ACTUAL COLOR CODING ACCORDING TO LLOYD'S	
	WHITE
	YELLOW
	BLACK AND WHITE
	LIGHT BLUE
	BLACK

PROJECT:- ASSAM STATE SECONDARY HEALTHCARE INITIATIVE FOR SERVICE DELIVERY TRANSFORMATION (ASSIST)		
CLIENT:- ASSAM HEALTH INFRASTRUCTURE DEVELOPMENT & MANAGEMENT SOCIETY (AHIDMS)		
PRINCIPAL CONSULTANT:  INTEGRA VENTURES PROFESSIONAL ENGINEERING CONSULTANTS 100/101/102/103/999/1000		
STAGE -		DPR
DRAWING NO.- 2024/ASSIST-KAR/DH/MGPS/PROP/02/GF		
START DATE	ISSUE DATE	SHEET SIZE
	10-02-2025	A3
PROJECT CODE- 2024/ASSIST-KAR/DH		
SCALE-	N.T.S.	
BLOCK NO.-	2	
FLOOR.-	GROUND FLOOR	
DRAWING TITLE:- BLOCK 2 MGPS LAYOUT GROUND FLOOR PLAN KARDIGANT CIVIL HOSPITAL, KARDIGANT, ASSAM		

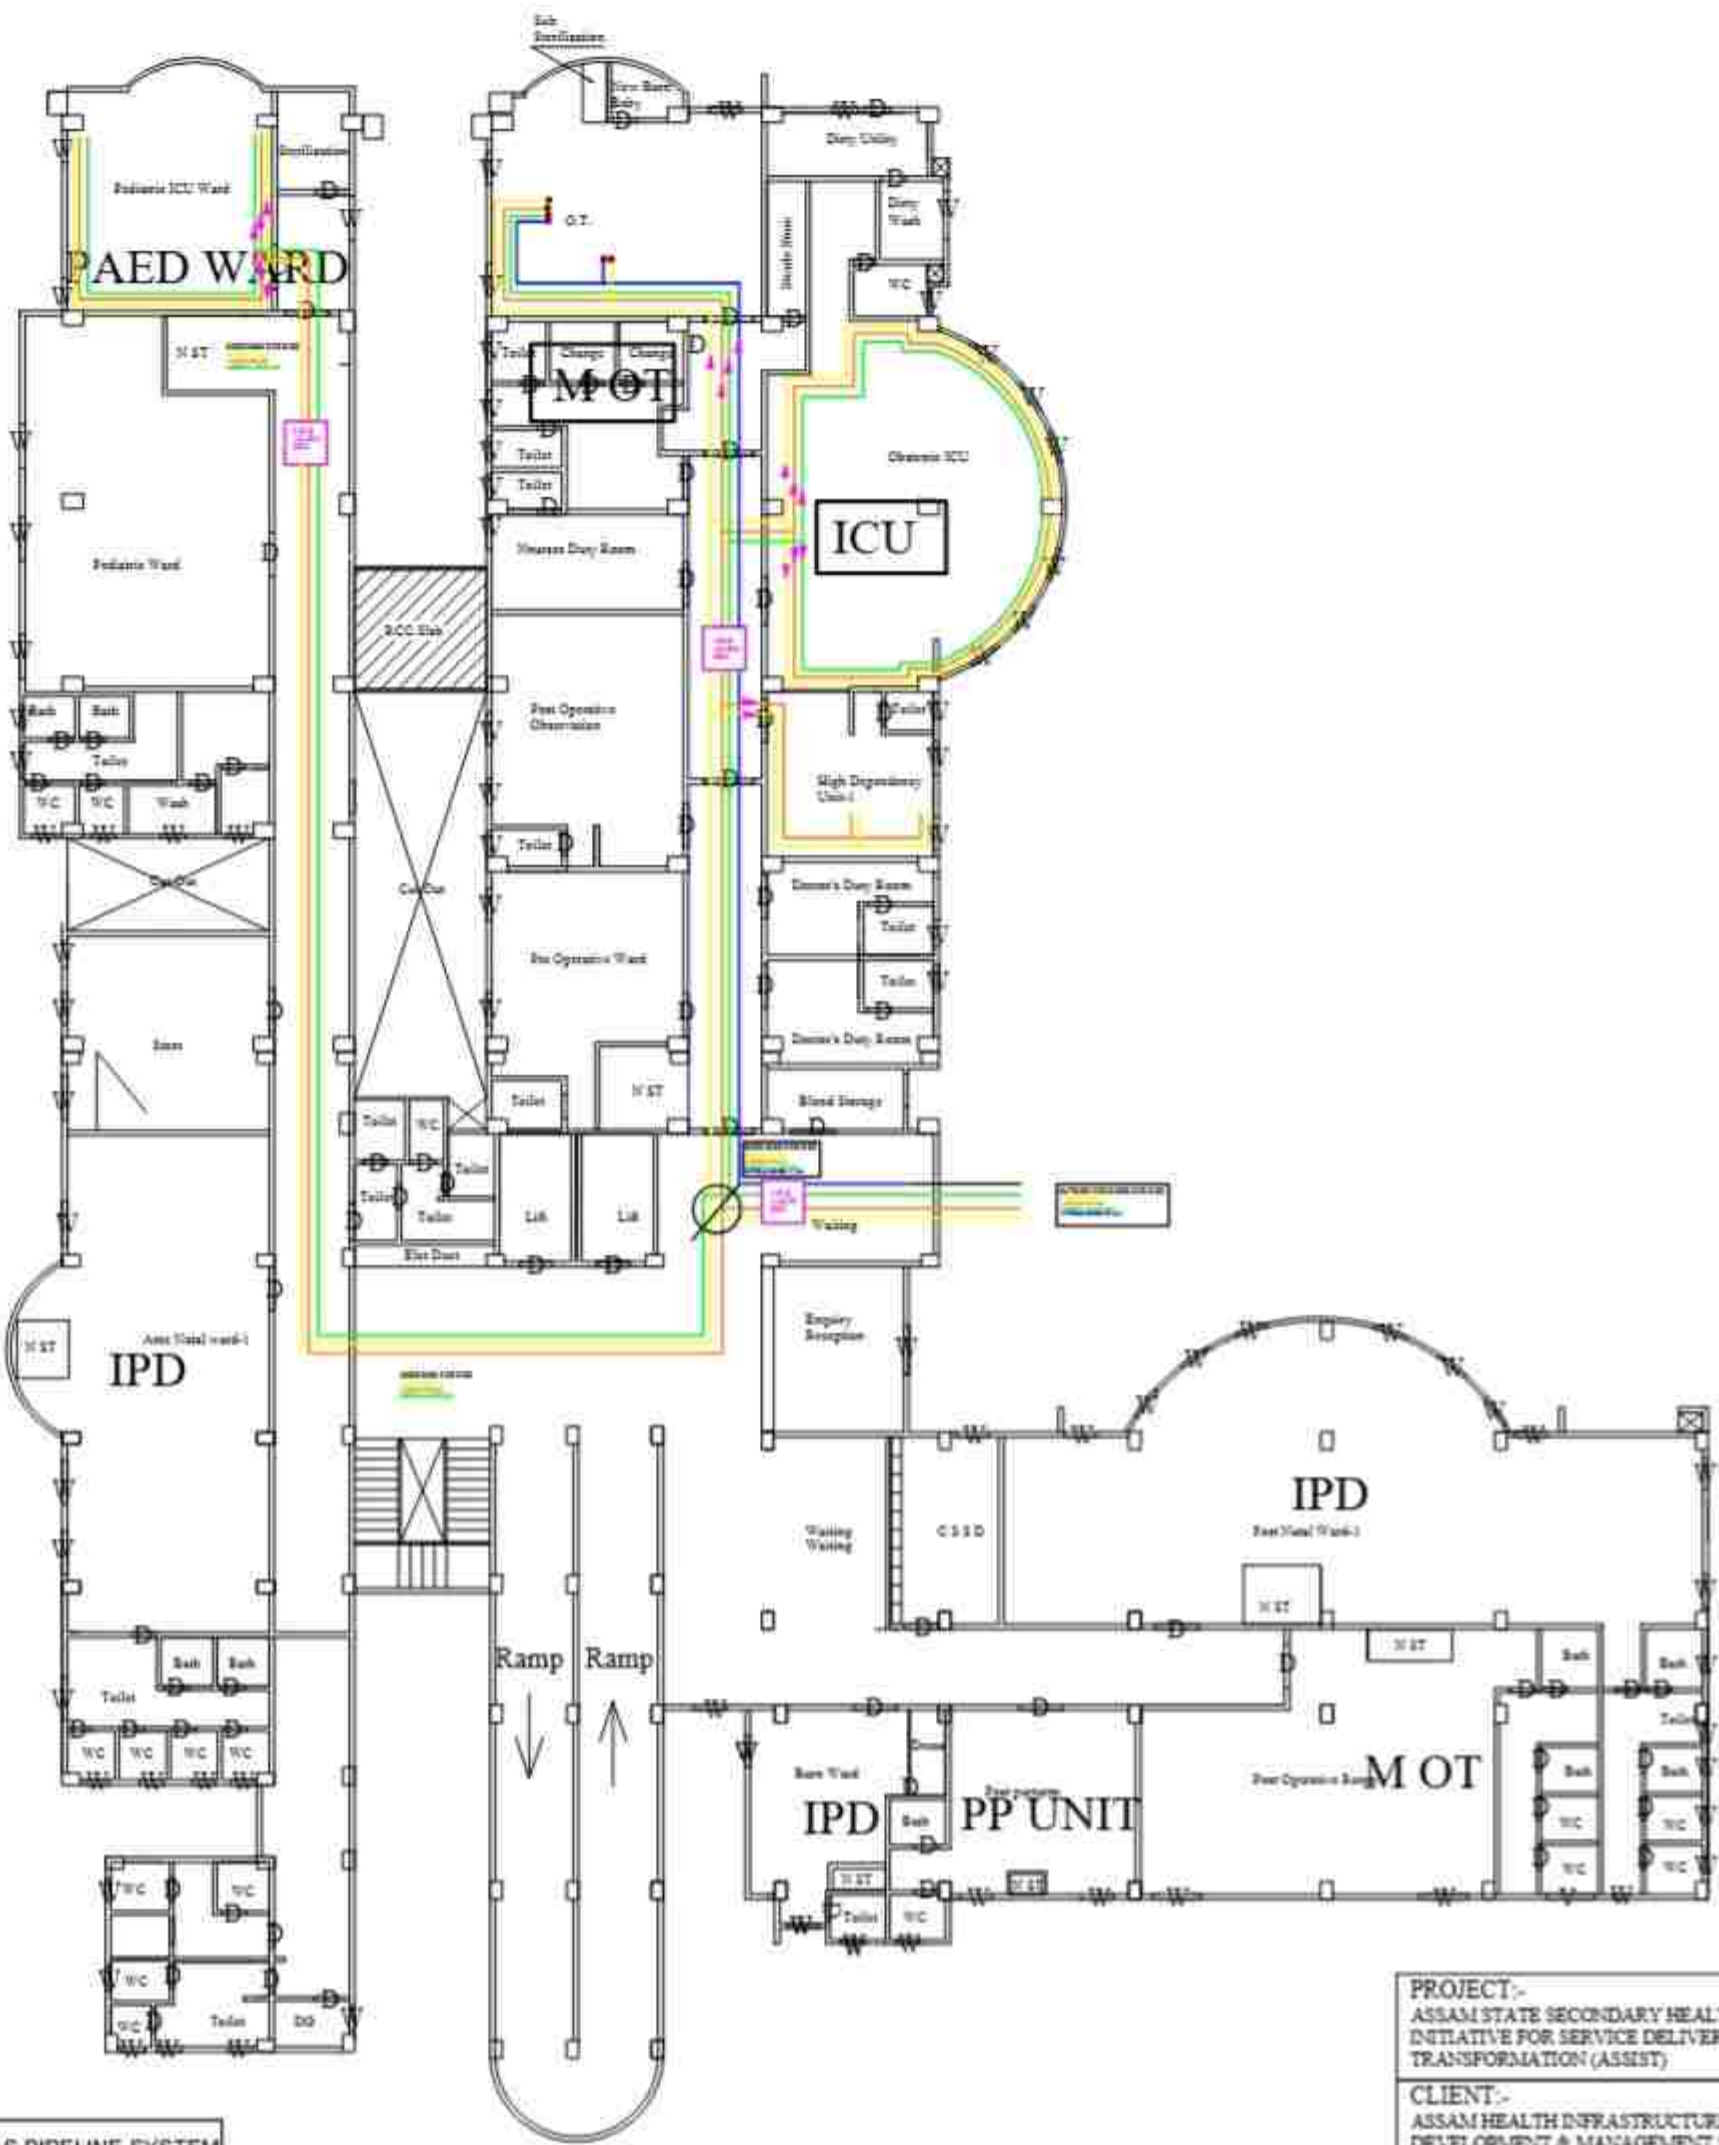

2nd Floor

MEDICAL GAS PIPELINE SYSTEM ABBREVIATION

●	OXYGEN
●	VACUUM
●	MEDICAL AIR
●	NITROUS OXIDE
●	SURGICAL AIR 7 BAR
●	SURGICAL AIR 1 BAR
A	GAS ALARM SYSTEM
V	VALVE BOX
I	ISOLATION VALVE
O	GAS OUTLET

OUTSIDE PIPE/RISER PIPE SIZE
1" O.D. x 1/2" I.D.
1" O.D. x 3/4" I.D.
1" O.D. x 1" I.D.
1" O.D. x 1 1/4" I.D.
1" O.D. x 1 1/2" I.D.
CORRIDOR PIPE SIZE
1" O.D. x 1/2" I.D.
1" O.D. x 3/4" I.D.
1" O.D. x 1" I.D.
1" O.D. x 1 1/4" I.D.
1" O.D. x 1 1/2" I.D.
ROOM PIPE SIZE
1" O.D. x 1/2" I.D.
1" O.D. x 3/4" I.D.
1" O.D. x 1" I.D.
1" O.D. x 1 1/4" I.D.
1" O.D. x 1 1/2" I.D.

ACTUAL COLOR CODING ACCORDING TO LLOYD'S

●	WHITE
●	YELLOW
●	BLACK AND WHITE
●	LIGHT BLUE
●	BLACK

PROJECT:-
ASSAM STATE SECONDARY HEALTHCARE
INITIATIVE FOR SERVICE DELIVERY
TRANSFORMATION (ASSIST)

CLIENT:-
ASSAM HEALTH INFRASTRUCTURE
DEVELOPMENT & MANAGEMENT SOCIETY
(AHIDMS)

PRINCIPAL CONSULTANT:-
INTEGRA VENTURES
PLOT NO. 10, SECTOR 10, KARDIGANJ, KARIMGANJ, ASSAM
PIN-781001
MOB: 98300 12345

STAGE->	DPR	
DRAWING NO->	2024/ASSIST-KAR/DH/MOPS/PROP/02/5F	
START DATE	ISSUE DATE	SHEET SIZE
	10-02-2025	A3
PROJECT CODE->	2024/ASSIST-KAR/DH	
SCALE->	N.T.S.	
BLOCK NO->	2	
FLOOR->	SECOND FLOOR	

DRAWING TITLE:-
BLOCK 2 MOPS LAYOUT SECOND FLOOR
PLAN,
KARIMGANJ CIVIL HOSPITAL, KARIMGANJ,
ASSAM



DOOR SCHEDULE:-

SNO	NAME	WIDTH	HEIGHT	REMARKS
1.	D1	0.75	2.00	SINGLE PANEL DOOR
2.	D2	0.90	2.00	SINGLE PANEL DOOR
3.	D3	1.05	2.00	SINGLE PANEL DOOR
4.	D4	1.20	2.00	SINGLE PANEL DOOR
4.	D4d	1.20	2.00	DOUBLE PANEL DOOR
5.	D5	1.60	2.00	DOUBLE PANEL DOOR
6.	D6	1.80	3.00	DOUBLE PANEL DOOR
7.	D7	2.00	2.00	DOUBLE PANEL DOOR

WINDOW SCHEDULE:-

SNO	NAME	BILL	WIDTH	HEIGHT	REMARKS
1.	W1	1.40	0.60	0.60	SINGLE PANEL WINDOW
2.	W2	0.70	0.90	1.30	SINGLE PANEL WINDOW
3.	W3	0.70	1.05	1.30	SINGLE PANEL WINDOW
4.	W4	0.70	1.20	1.30	DOUBLE PANEL WINDOW
5.	W5	0.70	1.30	1.30	DOUBLE PANEL WINDOW
6.	W6	0.70	1.80	1.30	DOUBLE PANEL WINDOW
7.	W7	0.70	2.00	1.30	DOUBLE PANEL WINDOW

LEGEND:

 	EXISTING
 	PROPOSED

PROJECT:-
ASSAM STATE SECONDARY HEALTHCARE
INITIATIVE FOR SERVICE DELIVERY
TRANSFORMATION (ASSIST)

CLIENT:-
ASSAM HEALTH INFRASTRUCTURE
DEVELOPMENT & MANAGEMENT SOCIETY
(AHIDMS)

PRINCIPAL CONSULTANT:-



INTEGRA VENTURES
PVT. LTD. 10/10, 10/11, 10/12, 10/99, 10/100

STAGE:- DPR

DRAWING NO:-
2024/ASSIST-KAR/DH/HVAC/PROP/01/FF

START DATE	ISSUE DATE	SHEET SIZE
	10-01-2025	A3


PROJECT CODE:- 2024/ASSIST-KAR/DH

SCALE:- N.T.S

BLOCK NO:- 1

FLOOR:- FIRST FLOOR

DRAWING TITLE:-
BLOCK 1 FIRST FLOOR PLAN HVAC
LAYOUT,
KARIMGANJ CIVIL HOSPITAL, KARIMGANJ,
ASSAM

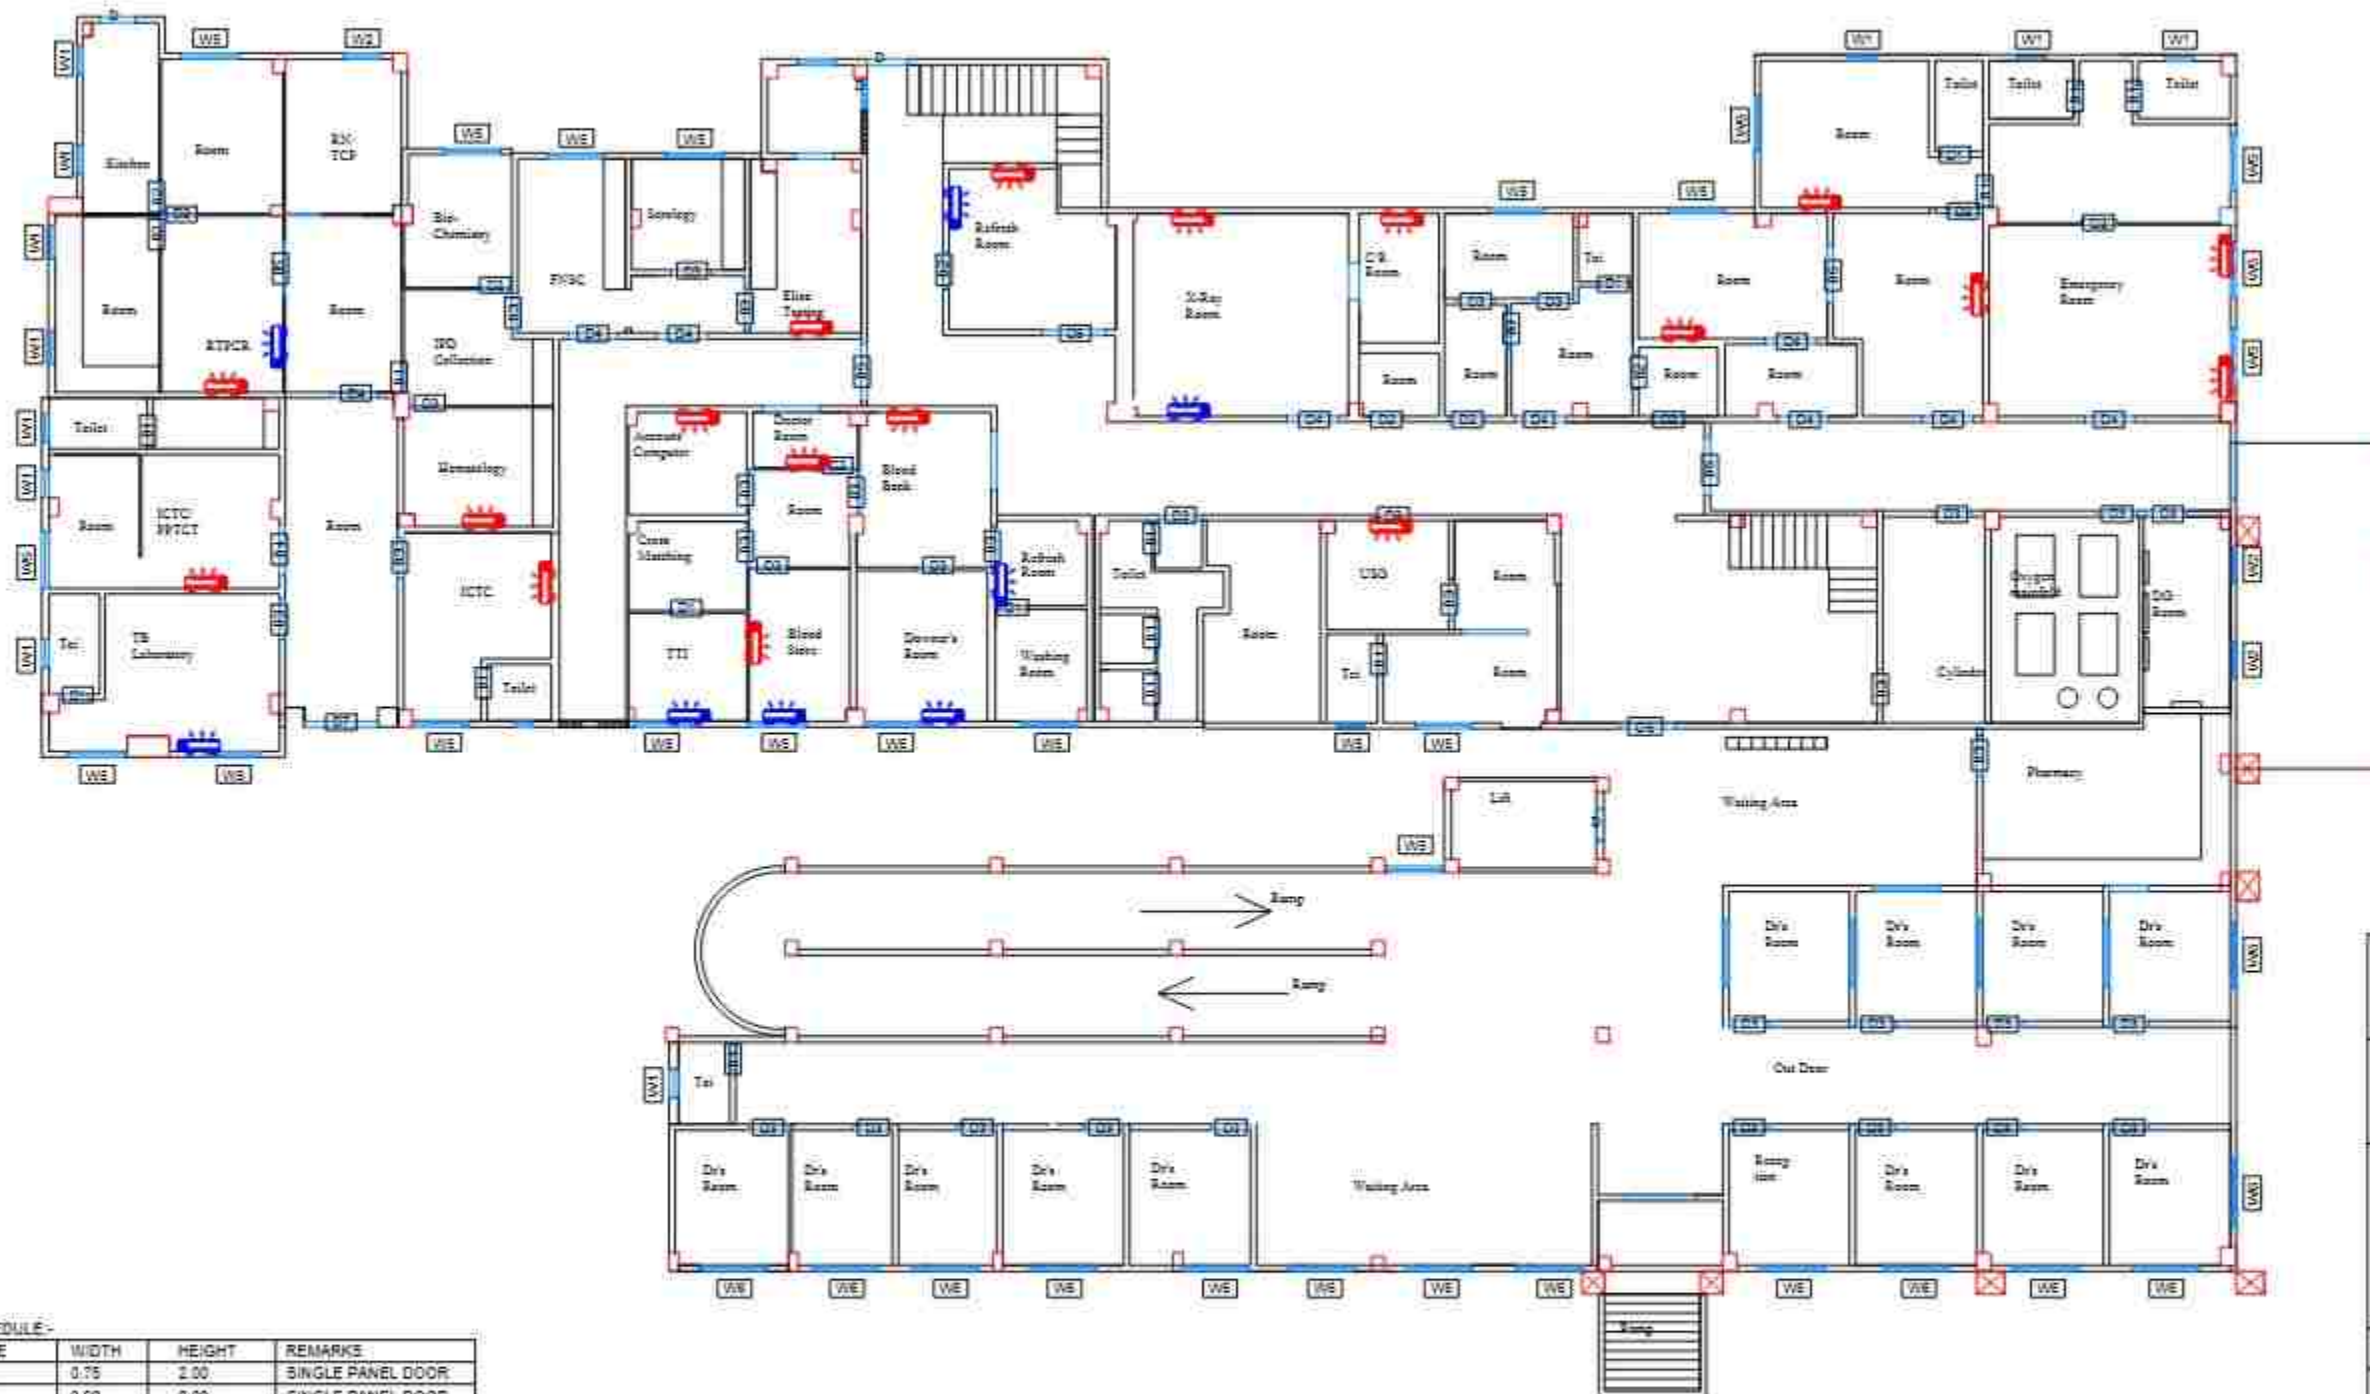

DOOR SCHEDULE -

SNO	NAME	WIDTH	HEIGHT	REMARKS
1.	D1	0.75	2.00	SINGLE PANEL DOOR
2.	D2	0.90	2.00	SINGLE PANEL DOOR
3.	D3	1.05	2.00	SINGLE PANEL DOOR
4.	D4	1.20	2.00	SINGLE PANEL DOOR
4	D4B	1.30	2.00	DOUBLE PANEL DOOR
5	D5	1.80	2.00	DOUBLE PANEL DOOR
6	D6	1.80	2.00	DOUBLE PANEL DOOR
7.	D7	2.00	2.00	DOUBLE PANEL DOOR

WINDOW SCHEDULE -

SNO	NAME	SILL	WIDTH	HEIGHT	REMARKS
1	W1	1.40	0.80	3.50	SINGLE PANEL WINDOW
2	W2	0.70	0.90	1.30	SINGLE PANEL WINDOW
3	W3	0.70	1.05	1.30	SINGLE PANEL WINDOW
4	W4	0.70	1.20	1.30	DOUBLE PANEL WINDOW
5	W5	0.70	1.50	1.30	DOUBLE PANEL WINDOW
6	W6	0.70	1.80	1.30	DOUBLE PANEL WINDOW
7.	W7	0.70	2.00	1.30	DOUBLE PANEL WINDOW

LEGEND:

 	EXISTING
 	PROPOSED

PROJECT:-
ASSAM STATE SECONDARY HEALTHCARE
INITIATIVE FOR SERVICE DELIVERY
TRANSFORMATION (ASSIST)

CLIENT:-
ASSAM HEALTH INFRASTRUCTURE
DEVELOPMENT & MANAGEMENT SOCIETY
(AHIMS)

PRINCIPAL CONSULTANT:-



ARCHITECT: SRIKANT BLOKAL GROUND FLOOR
HVAC PRELIMINARY DESIGN/PROPOSAL/ASSIST
TEL: 9874561234567

STAGE:- DPR

DRAWING NO.-
2024/ASSIST-KAR.DH.HVAC/PROP/01/GF

START DATE	ISSUE DATE	SHEET SIZE
	10-02-2025	A3

PROJECT CODE:- 2024/ASSIST-KAR.DH

SCALE:- N.T.S.

BLOCK NO:- 1

FLOOR:- GROUND FLOOR

DRAWING TITLE:-
BLOCK 1 GROUND FLOOR PLAN HVAC
LAYOUT,
KARIMGANJ CIVIL HOSPITAL, KARIMGANJ,
ASSAM



DOOR SCHEDULE -

SNO	NAME	WIDTH	HEIGHT	REMARKS
1.	D1	0.75	2.00	SINGLE PANEL DOOR
2.	D2	0.90	2.00	SINGLE PANEL DOOR
3.	D3	1.05	2.00	SINGLE PANEL DOOR
4.	D4	1.20	2.00	SINGLE PANEL DOOR
4.	D4a	1.20	2.00	DOUBLE PANEL DOOR
5.	D5	1.50	2.00	DOUBLE PANEL DOOR
6.	D6	1.80	2.00	DOUBLE PANEL DOOR
7.	D7	2.00	2.00	DOUBLE PANEL DOOR

WINDOW SCHEDULE -

SNO	NAME	SILL	WIDTH	HEIGHT	REMARKS
1.	W1	1.40	0.60	0.80	SINGLE PANEL WINDOW
2.	W2	0.70	0.90	1.30	SINGLE PANEL WINDOW
3.	W3	0.70	1.05	1.30	SINGLE PANEL WINDOW
4.	W4	0.70	1.20	1.30	DOUBLE PANEL WINDOW
5.	W5	0.70	1.50	1.30	DOUBLE PANEL WINDOW
6.	W6	0.75	1.80	1.30	DOUBLE PANEL WINDOW
7.	W7	0.70	2.00	1.30	DOUBLE PANEL WINDOW

LEGEND:

	EXISTING
	PROPOSED

PROJECT:-
ASSAM STATE SECONDARY HEALTHCARE
INITIATIVE FOR SERVICE DELIVERY
TRANSFORMATION (ASSIST)

CLIENT:-
ASSAM HEALTH INFRASTRUCTURE
DEVELOPMENT & MANAGEMENT SOCIETY
(AHIDMS)

PRINCIPAL CONSULTANT:



PROJECT ADDRESS: BLOCK 1 SECOND FLOOR
KARIMGANJ CIVIL HOSPITAL, KARIMGANJ, ASSAM
IN-144-0607701142

STAGE:- DPR

DRAWING NO:-
2024/ASSIST-KAR/DH/HVAC/PROP/01-SF

START DATE	ISSUE DATE	SHEET SIZE
	10-02-2025	A3


PROJECT CODE:- 2024/ASSIST-KAR/DH

SCALE:- N.T.S.

BLOCK NO:- 1

FLOOR:- SECOND FLOOR

DRAWING TITLE:-
BLOCK 1 SECOND FLOOR PLAN HVAC
LAYOUT,
KARIMGANJ CIVIL HOSPITAL, KARIMGANJ,
ASSAM

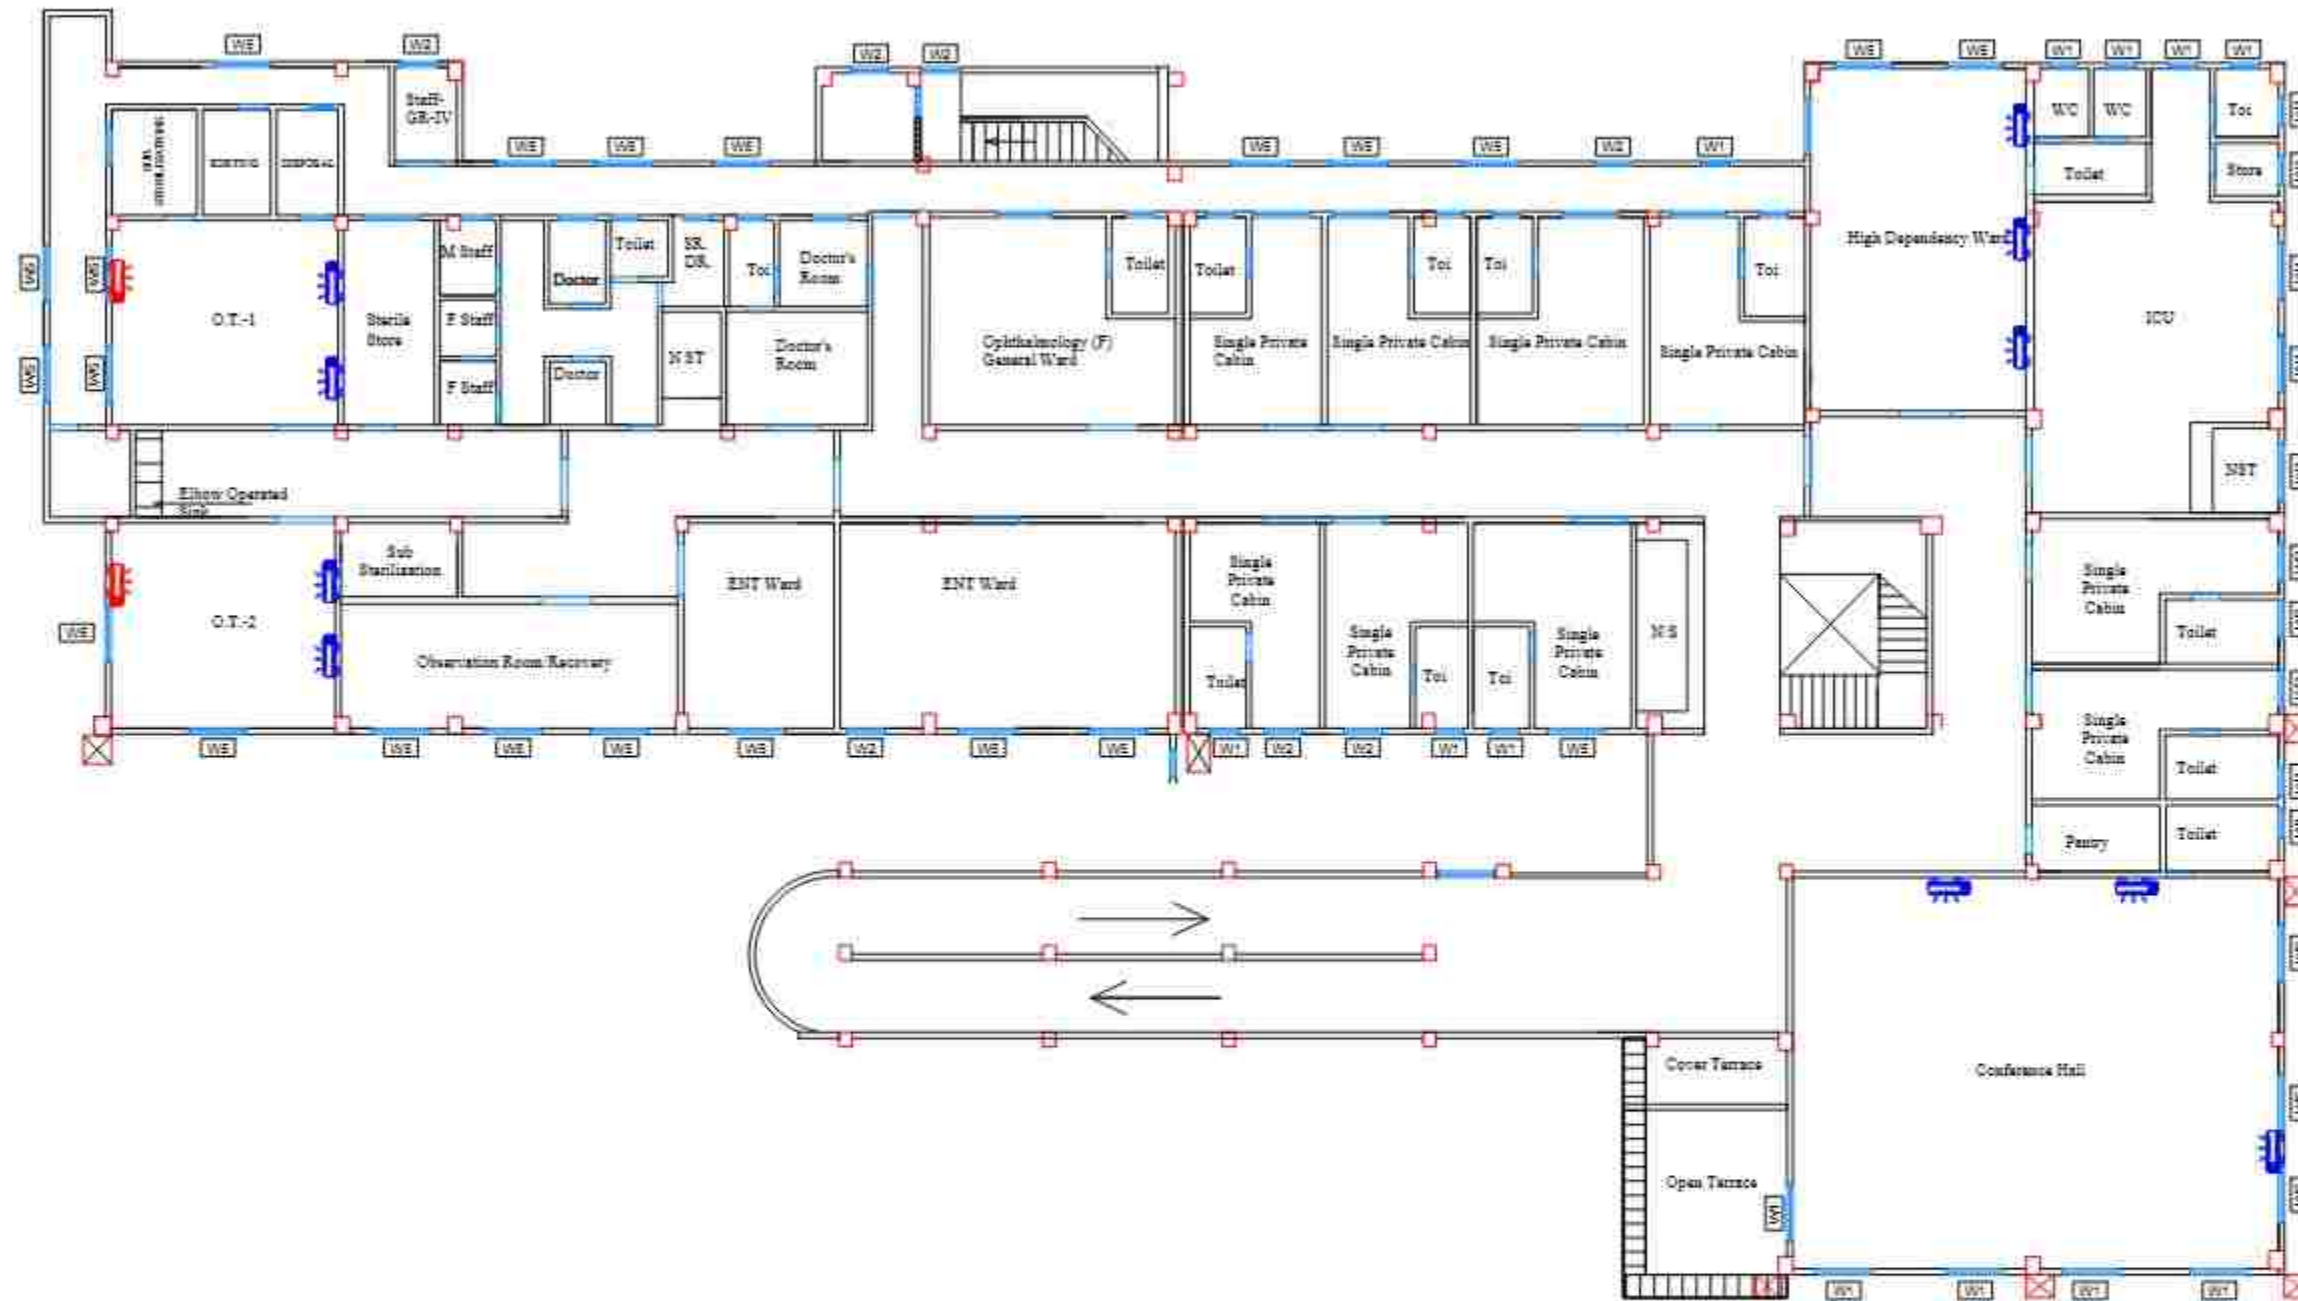

DOOR SCHEDULE-

SNO	NAME	WIDTH	HEIGHT	REMARKS
1.	D1	0.75	2.00	SINGLE PANEL DOOR
2.	D2	0.90	2.00	SINGLE PANEL DOOR
3.	D3	1.05	2.00	SINGLE PANEL DOOR
4.	D4	1.20	2.00	SINGLE PANEL DOOR
4.	D4a	1.20	2.00	DOUBLE PANEL DOOR
5.	D5	1.50	2.00	DOUBLE PANEL DOOR
6.	D6	1.80	2.00	DOUBLE PANEL DOOR
7.	D7	2.00	2.00	DOUBLE PANEL DOOR

WINDOW SCHEDULE-

SNO	NAME	SILL	WIDTH	HEIGHT	REMARKS
1.	W1	1.40	0.80	0.80	SINGLE PANEL WINDOW
2.	W2	0.70	0.90	1.50	SINGLE PANEL WINDOW
3.	W3	0.70	1.05	1.30	SINGLE PANEL WINDOW
4.	W4	0.70	1.20	1.30	DOUBLE PANEL WINDOW
5.	W5	0.70	1.50	1.30	DOUBLE PANEL WINDOW
6.	W6	0.70	1.80	1.30	DOUBLE PANEL WINDOW
7.	W7	0.70	2.00	1.30	DOUBLE PANEL WINDOW

LEGEND:

■	EXISTING
■	PROPOSED

PROJECT:-
ASSAM STATE SECONDARY HEALTHCARE
INITIATIVE FOR SERVICE DELIVERY
TRANSFORMATION (ASSIST)

CLIENT:-
ASSAM HEALTH INFRASTRUCTURE
DEVELOPMENT & MANAGEMENT SOCIETY
(AHIDMS)

PRINCIPAL CONSULTANT:-



STAGE:- DPR

DRAWING NO:-
2024/ASSIST-KAR/DH/HVAC/PROP/01/TF

START DATE 10-02-2025 **ISSUE DATE** **SHEET SIZE** A3


PROJECT CODE 2024/ASSIST-KAR/DH

SCALE:- N.T.S

BLOCK NO:- 1

FLOOR:- THIRD FLOOR

DRAWING TITLE:-
BLOCK 1 THIRD FLOOR PLAN HVAC
LAYOUT,
KARIMGANJ CIVIL HOSPITAL, KARIMGANJ,
ASSAM

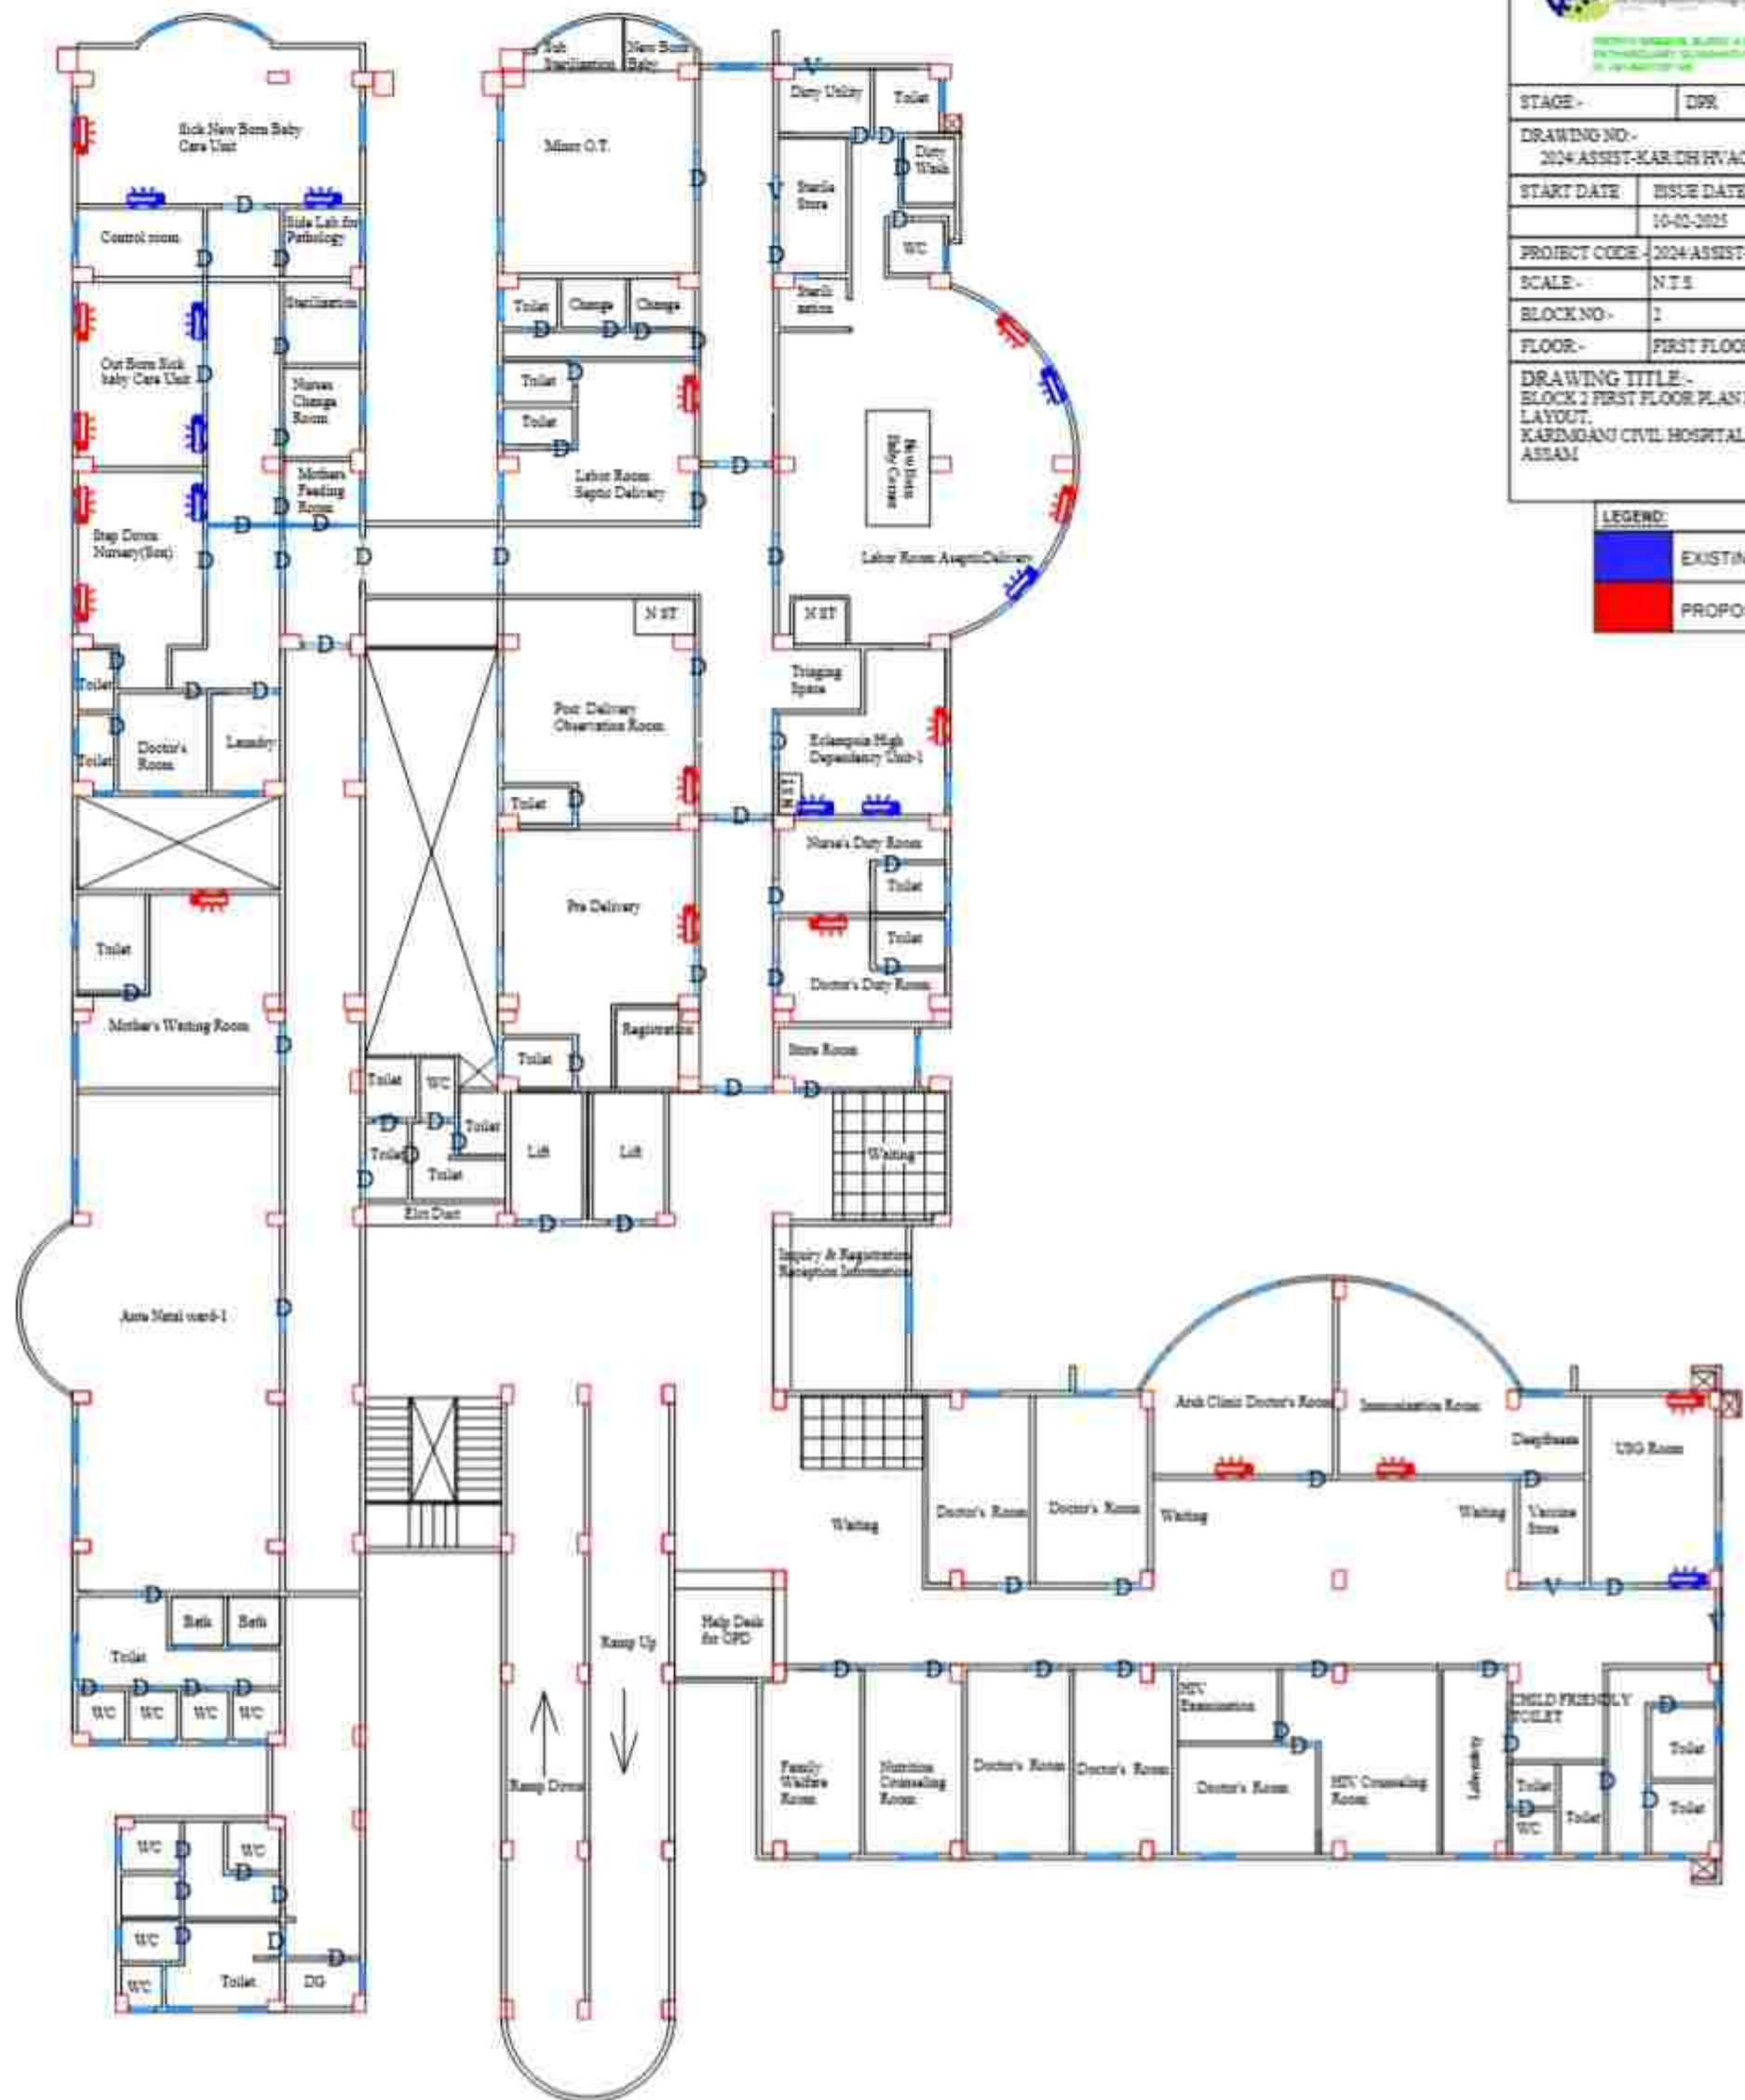

PROJECT:- ASSAM STATE SECONDARY HEALTHCARE INITIATIVE FOR SERVICE DELIVERY TRANSFORMATION (ASSIST)		
CLIENT:- ASSAM HEALTH INFRASTRUCTURE DEVELOPMENT & MANAGEMENT SOCIETY (AHIDS)		
PRINCIPAL CONSULTANT:  INTEGRA VENTURES PROJECTS CONSULTING DESIGN CONSTRUCTION OFFICE: KARIMGANJ, KARDIGANG & BARPOUR P.O. KARIMGANJ, GUWAHATI-781001, ASSAM E: info@integraventures.com		
STAGE -	DPR	
DRAWING NO.- 2024-ASSIST-KAR-DH-HVAC-PROP-02-FF		
START DATE	ISSUE DATE	SHEET SIZE
	10-02-2025	A3
PROJECT CODE -	2024-ASSIST-KAR-DH	
SCALE -	N.T.S	
BLOCK NO.-	1	
FLOOR.-	FIRST FLOOR	
DRAWING TITLE:- BLOCK 2 FIRST FLOOR PLAN HVAC LAYOUT, KARDIGANG CIVIL HOSPITAL, KARDIGANG, ASSAM		

LEGEND:	
	EXISTING
	PROPOSED

PROJECT:-
ASSAM STATE SECONDARY HEALTHCARE
INITIATIVE FOR SERVICE DELIVERY
TRANSFORMATION (ASSIST)

CLIENT:-
ASSAM HEALTH INFRASTRUCTURE
DEVELOPMENT & MANAGEMENT SOCIETY
(AHIDMS)

PRINCIPAL CONSULTANT:
 **INTEGRA VENTURES**
PVT. LTD.
100/101, 102, 103, 104, 999, 1000

STAGE - DPR

DRAWING NO -
2024/ASSIST-KAR DH HVAC PROP 01 OF

START DATE	ISSUE DATE	SHEET SIZE
	10-02-2025	A3

PROJECT CODE - 2024/ASSIST-KAR DH

SCALE - N.T.S.


BLOCK NO - 2

FLOOR - GROUND FLOOR

DRAWING TITLE:-
BLOCK 2 GROUND FLOOR PLAN HVAC
LAYOUT,
KARDIGANU CIVIL HOSPITAL, KARDIGANU,
ASSAM.

LEGEND:

	EXISTING
	PROPOSED

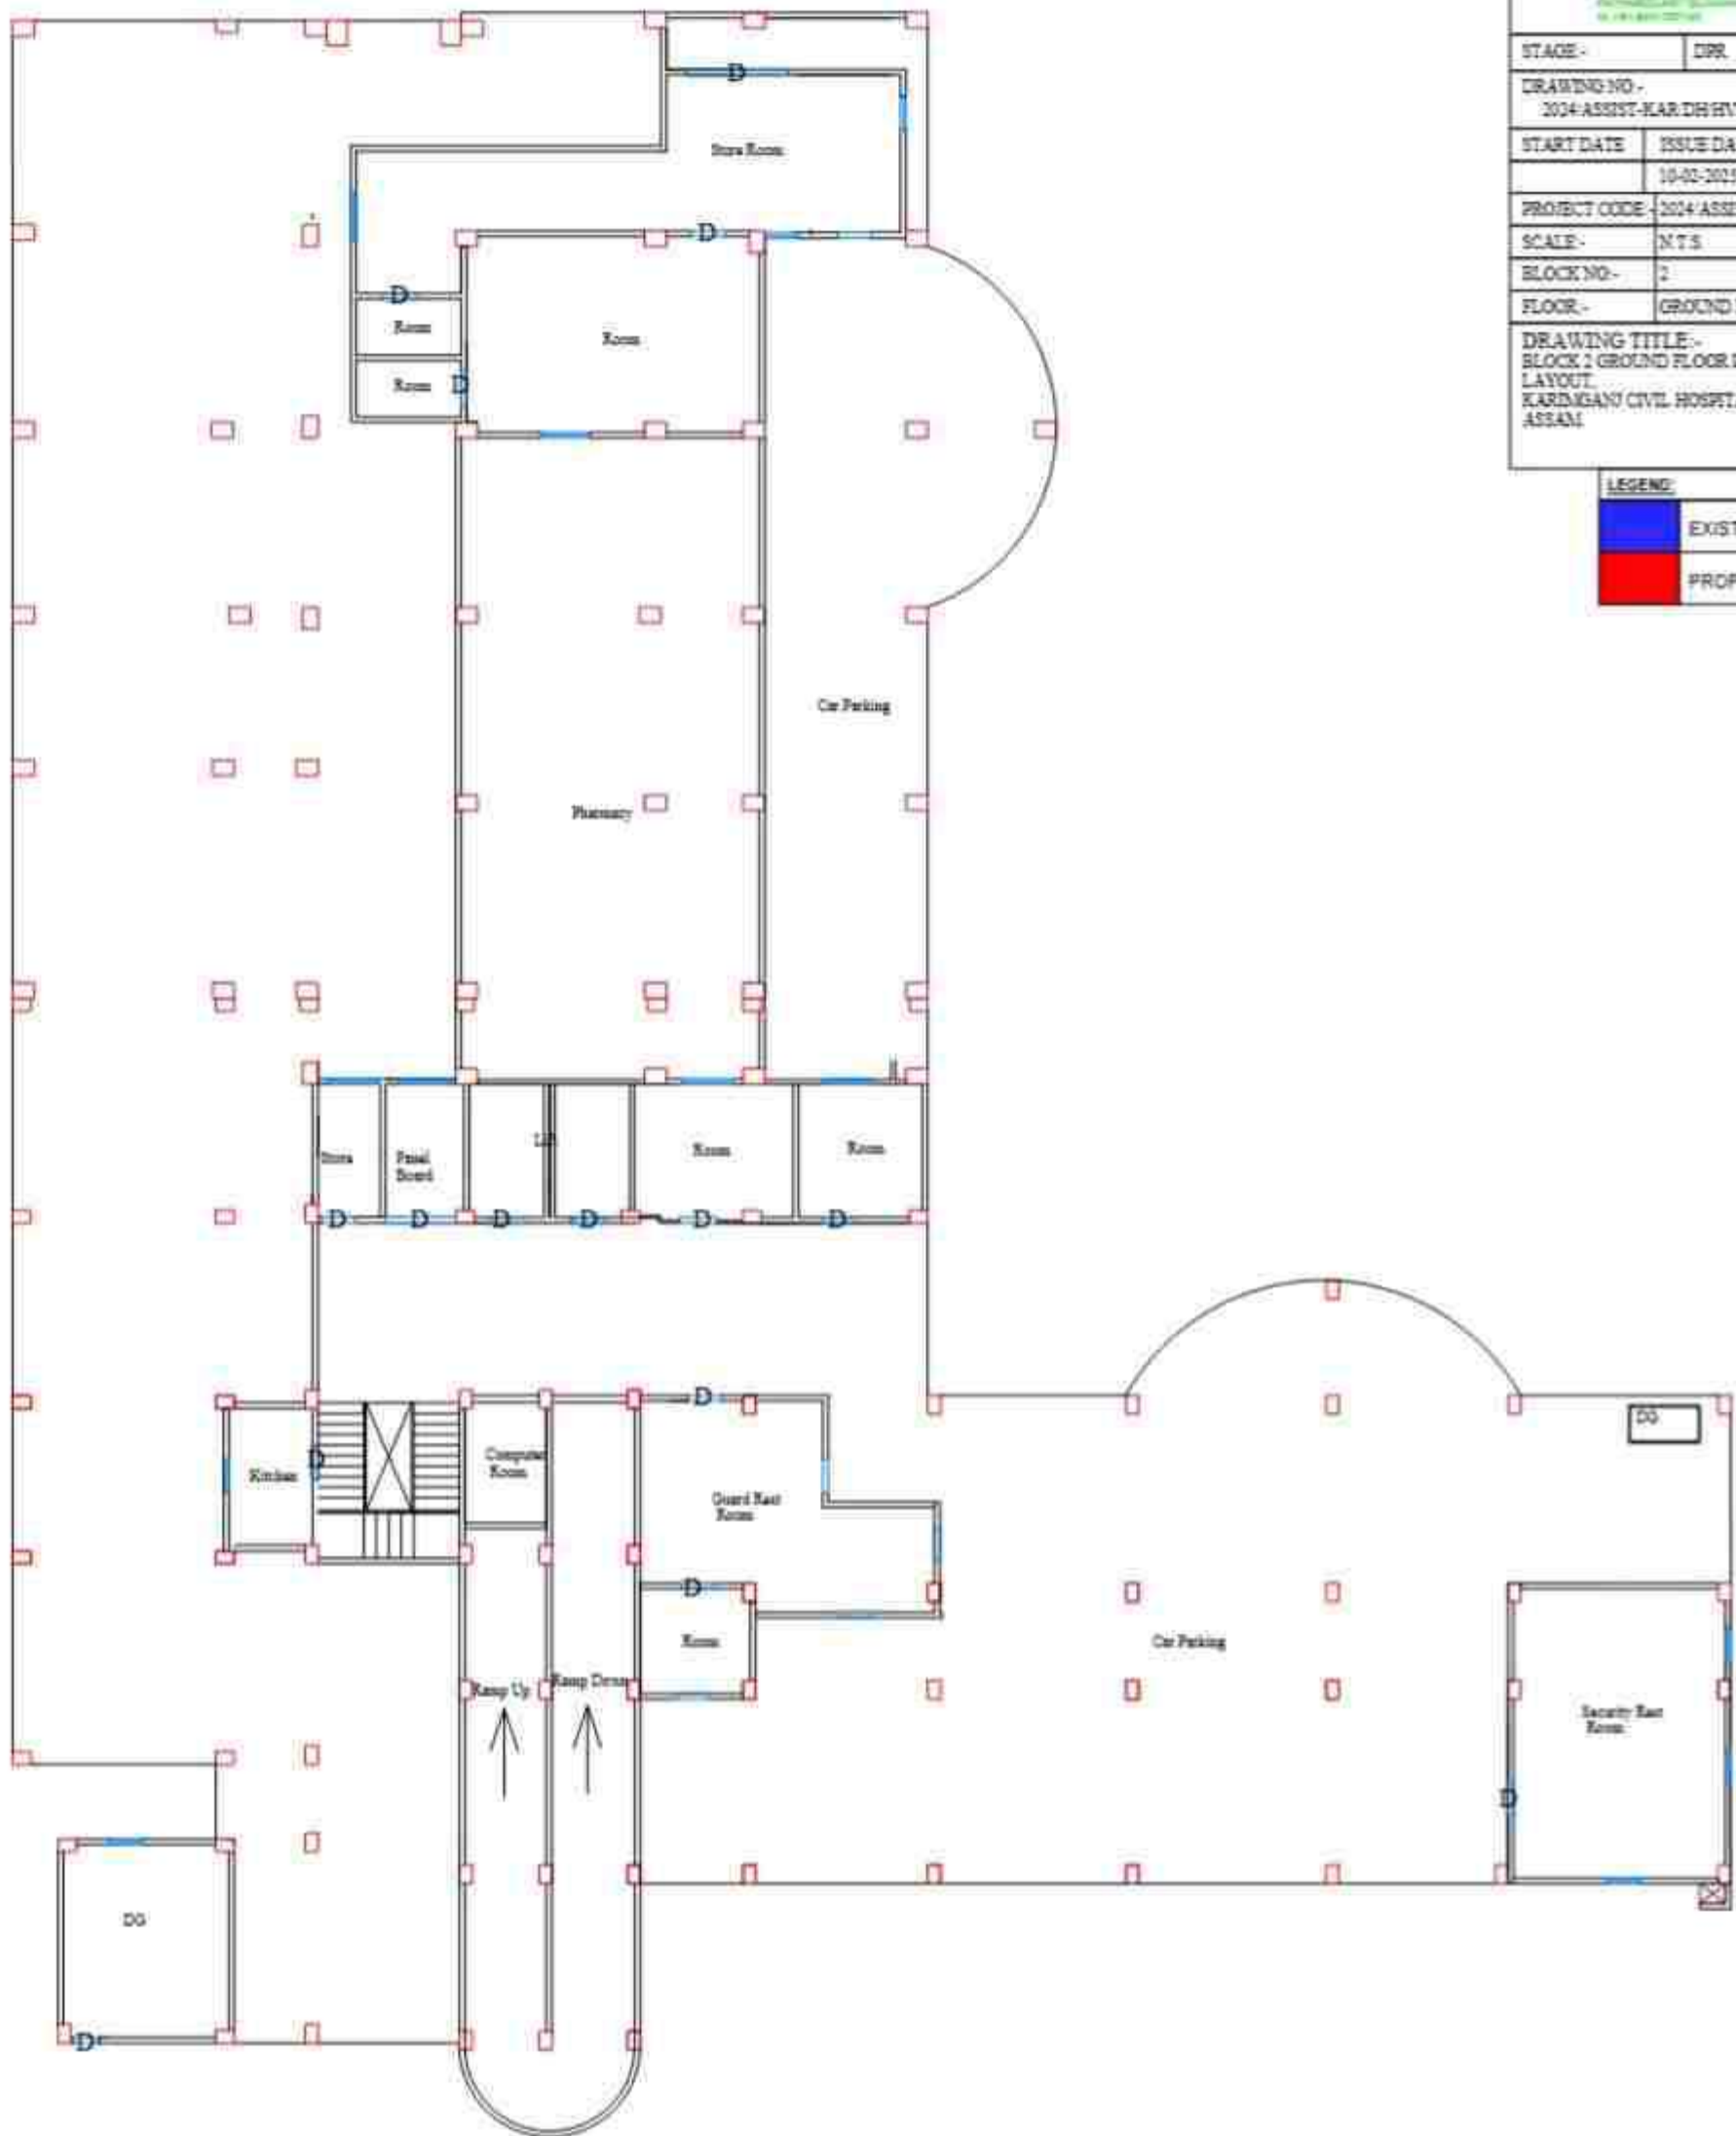

PROJECT:-
ASSAM STATE SECONDARY HEALTHCARE
INITIATIVE FOR SERVICE DELIVERY
TRANSFORMATION (ASSIST)

CLIENT:-
ASSAM HEALTH INFRASTRUCTURE
DEVELOPMENT & MANAGEMENT SOCIETY
(AHIMS)

PRINCIPAL CONSULTANT:



ADDRESS: KARDIANGI, NAGALAND
KARDIANGI, NAGALAND
IN: 781 122-122-122

STAGE:- DPR

DRAWING NO:-
2024/ASSIST-KARDIANGI/HVAC/PROP-02-SF

START DATE: 10-01-2025
ISSUE DATE: A3
SHEET SIZE:

PROJECT CODE: 2024/ASSIST-KARDIANGI

SCALE:- N.T.S.


BLOCK NO:- 2


FLOOR:- SECOND FLOOR

DRAWING TITLE:-
BLOCK 2 SECOND FLOOR PLAN HVAC
LAYOUT,
KARDIANGI CIVIL HOSPITAL, KARDIANGI,
ASSAM

LEGEND:

EXISTING
PROPOSED

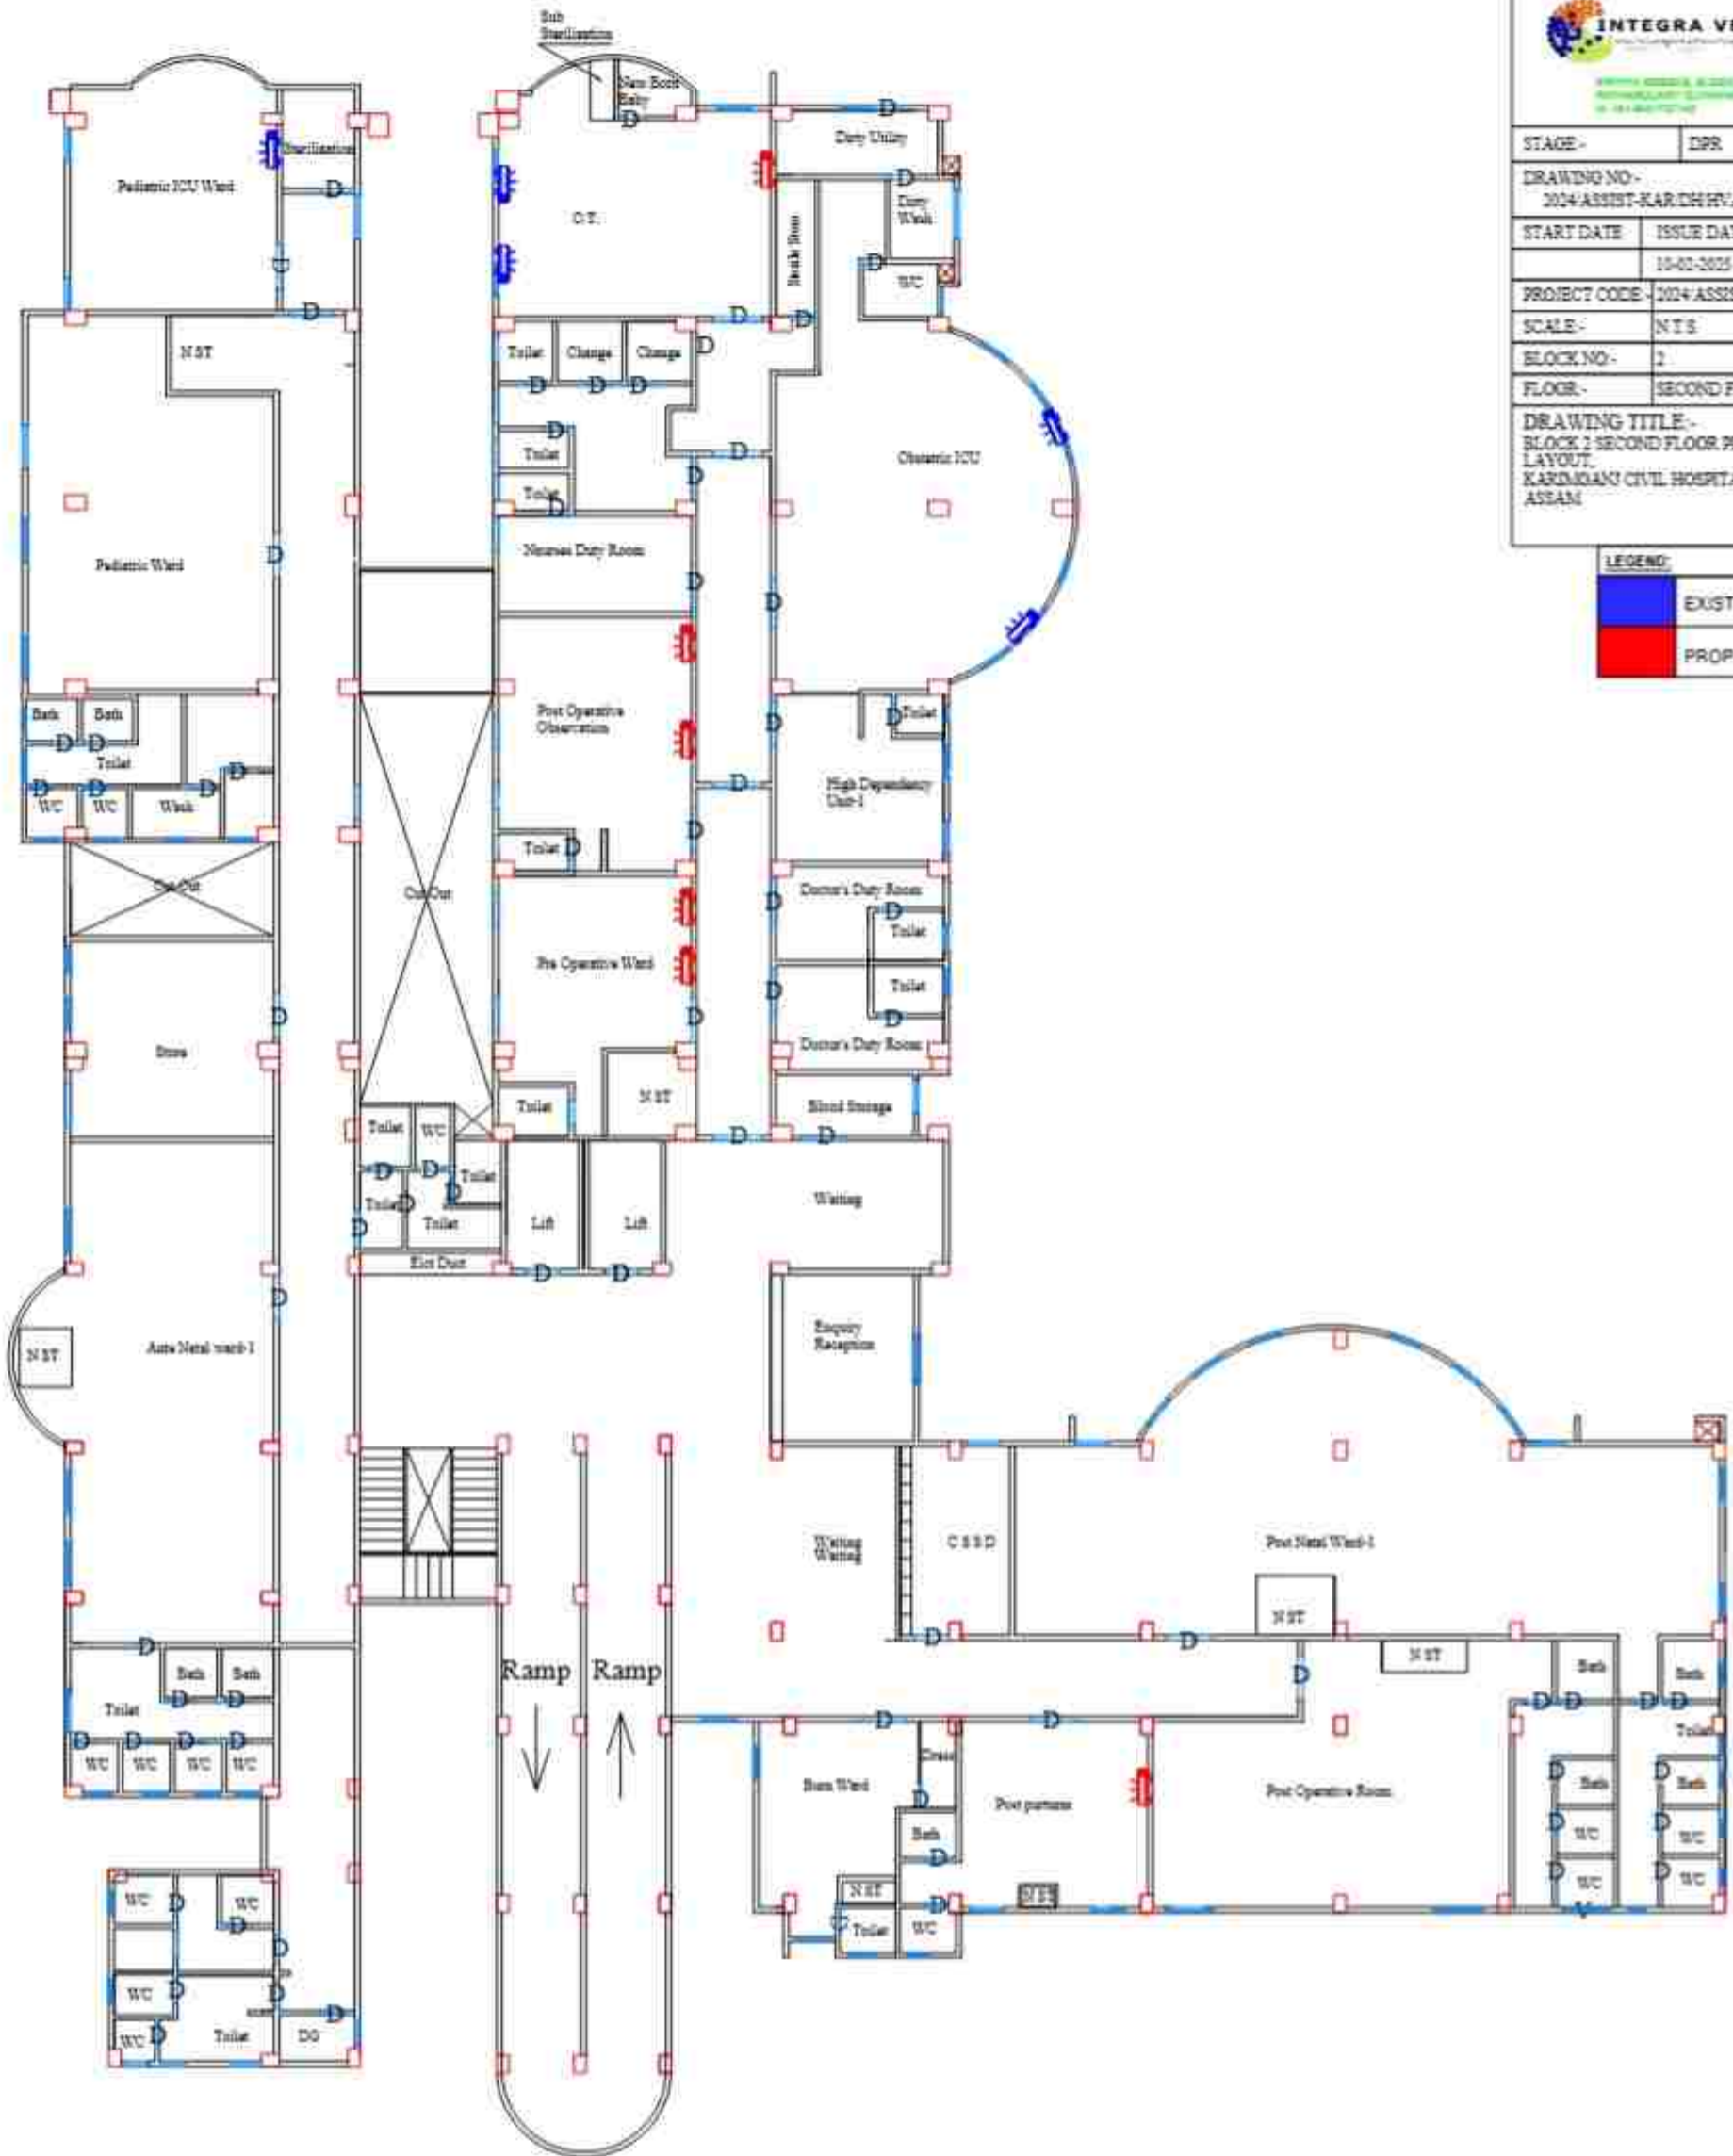

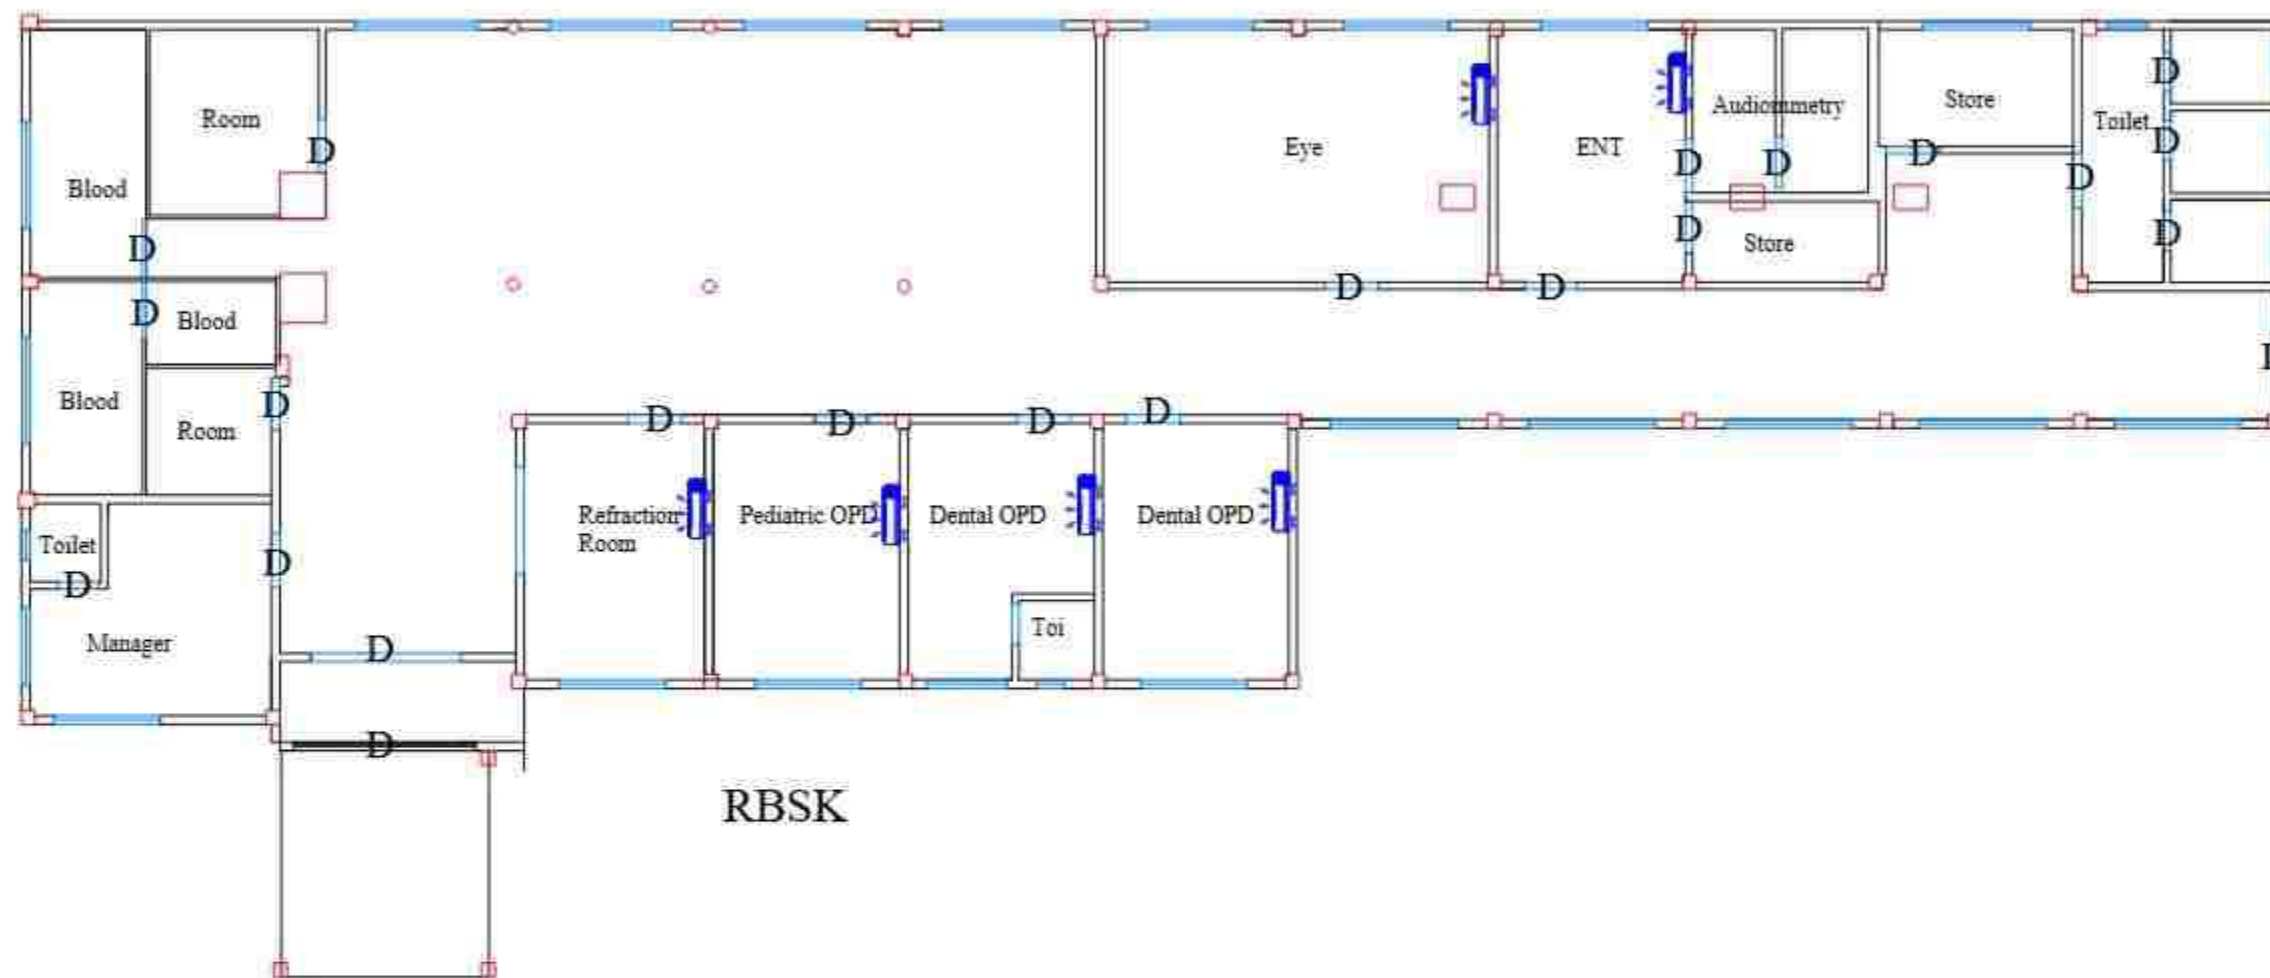

RBSK

PROJECT:- ASSAM STATE SECONDARY HEALTHCARE INITIATIVE FOR SERVICE DELIVERY TRANSFORMATION (ASSIST)		
CLIENT:- ASSAM HEALTH INFRASTRUCTURE DEVELOPMENT & MANAGEMENT SOCIETY (AHIMS)		
PRINCIPAL CONSULTANT:- INTEGRA VENTURES www.integraventures.com 91 9862011111 WEALTH CREATOR, BLOCK & GROUND FLOOR, ANANDAPUR, GUWAHATI-781005, ASSAM 91 9862011111		
STAGE -	DPR	
DRAWING NO:- 2024/ASSIST-KAR/DH/HVAC/PROP/03		
START DATE	ISSUE DATE	SHEET SIZE
	10-02-2025	A1
PROJECT CODE:-	2024/ASSIST-KAR/DH	
SCALE:-	N.T.S	
BLOCK NO:-	3	
FLOOR:-	GROUND FLOOR	
DRAWING TITLE:- BLOCK 3 GROUND FLOOR PLAN HVAC LAYOUT, KARIMGANJ CIVIL HOSPITAL, KARIMGANJ, ASSAM		

LEGEND:

	EXISTING
	PROPOSED